



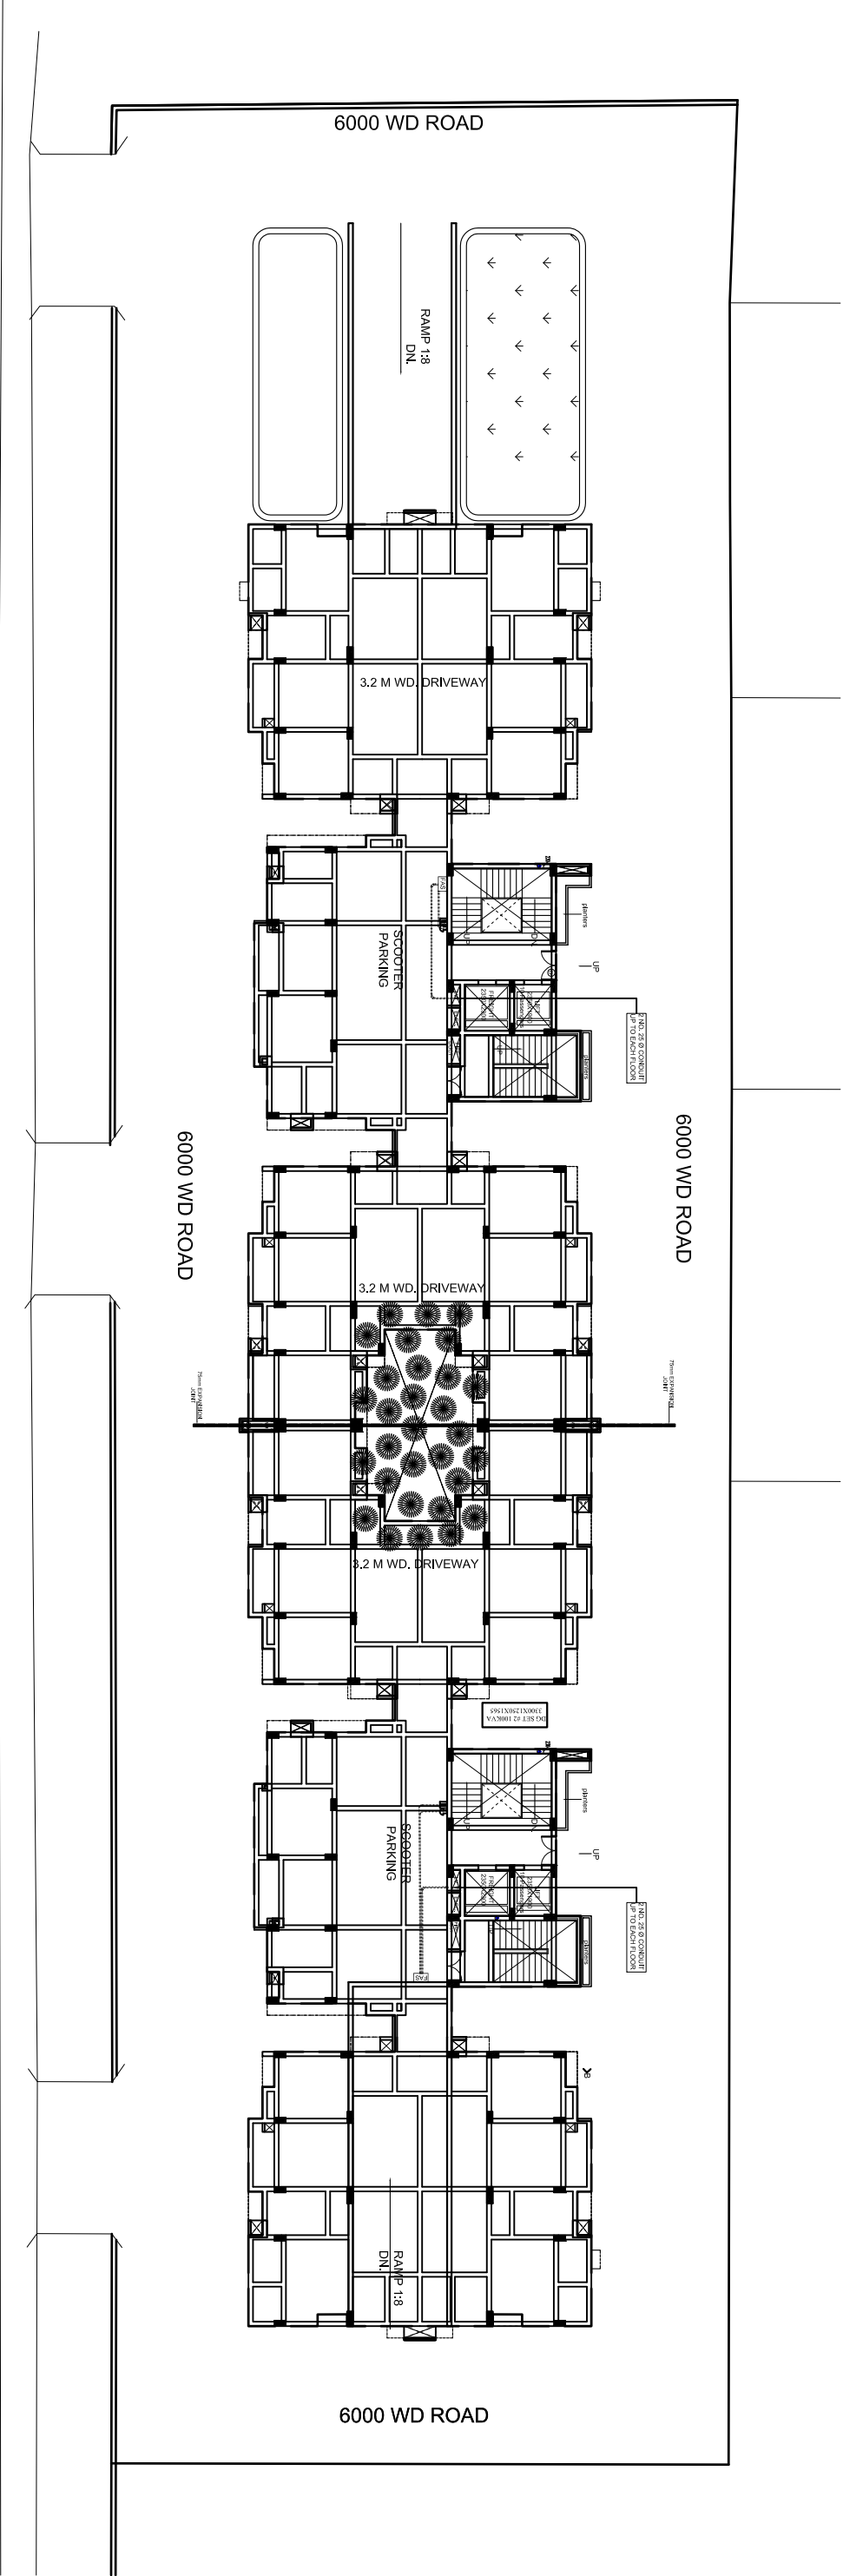

STILT FIRE ALARM LAYOUT PLAN

GENERAL NOTES:-

1. FIRE ALARM CONTROL CABLE SHALL BE 2CX1.5 SQ.MM UNARMORED FRLS OUTER SHEATHED, PVC INSULATED COPPER CONDUCTOR CABLE LAID IN CONCEALED MEDIUM CLASS PVC CONDUIT.
2. PUBLIC ADDRESS CONTROL CABLE SHALL BE 2CX1.0 SQ.MM UNARMORED FRLS OUTER SHEATHED, PVC INSULATED COPPER CONDUCTOR CABLE LAID IN CONCEALED MEDIUM CLASS PVC CONDUIT.
3. 20MM Ø MEDIUM CLASS PVC CONDUIT SHALL BE CONCEALED IN SLAB/WALL, FOR FIRE ALARM & PA CABLING IN CONCEALED CONDUIT TYPE. PVC CONDUIT SHALL BE USED WHERE IN FIRE SHAFT VERTICAL RISER AND EXPOSED BELOW CEILING.
4. THE FIRE ALARM SYSTEM DESIGNED AS PER IS: 2189-1999.

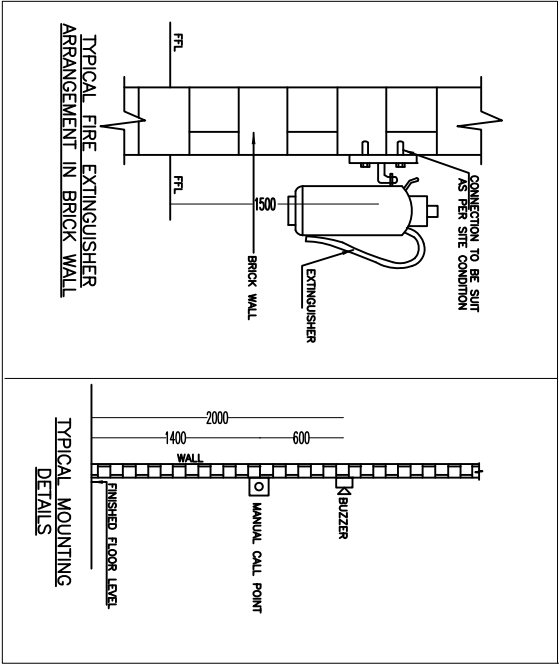

<u>ELECTRICAL LEGEND :-</u>		
S.NO.	SYMBOL	<u>DESCRIPTION</u>
1		FIRE ALARM SYSTEM
2		BUZZER
3		MANUAL CALL POINT

PROPOSED GROUP HOUSING AT PLOT NO. C3,SECTOR O, MANSAROVAR YOJNA, KANPUR ROAD ,LDA, LUCKNOW

BUILDING MEP CONSULTANT
TRIVENT CONSULTING ENGINEERS
FLAT NO.-D, GF, AVON RESIDENCY
A1/8, SEC-H,ALIGANJ, LUCKNOW
EMAIL:triventconsultants_lko@gmail.com
Ph:5224108651, 09794991199

OWNER

ARCHITECT

ORIENTATION

m

u

r

a

l

a

g

e

ira-sunil namit architects , interior decorators & muralists
B-1/29 , sector - a , aliganj lucknow
no. : 2321590. 2321590.

Sheet No - 1
Ref No - L-80(AF-979)
Date - November'16
Drawn By-MOHIT JAISWAL

FIRE DRAWING
STILT FLOOR FIRE ALARM LAYOUT
SCALE - 1:200