


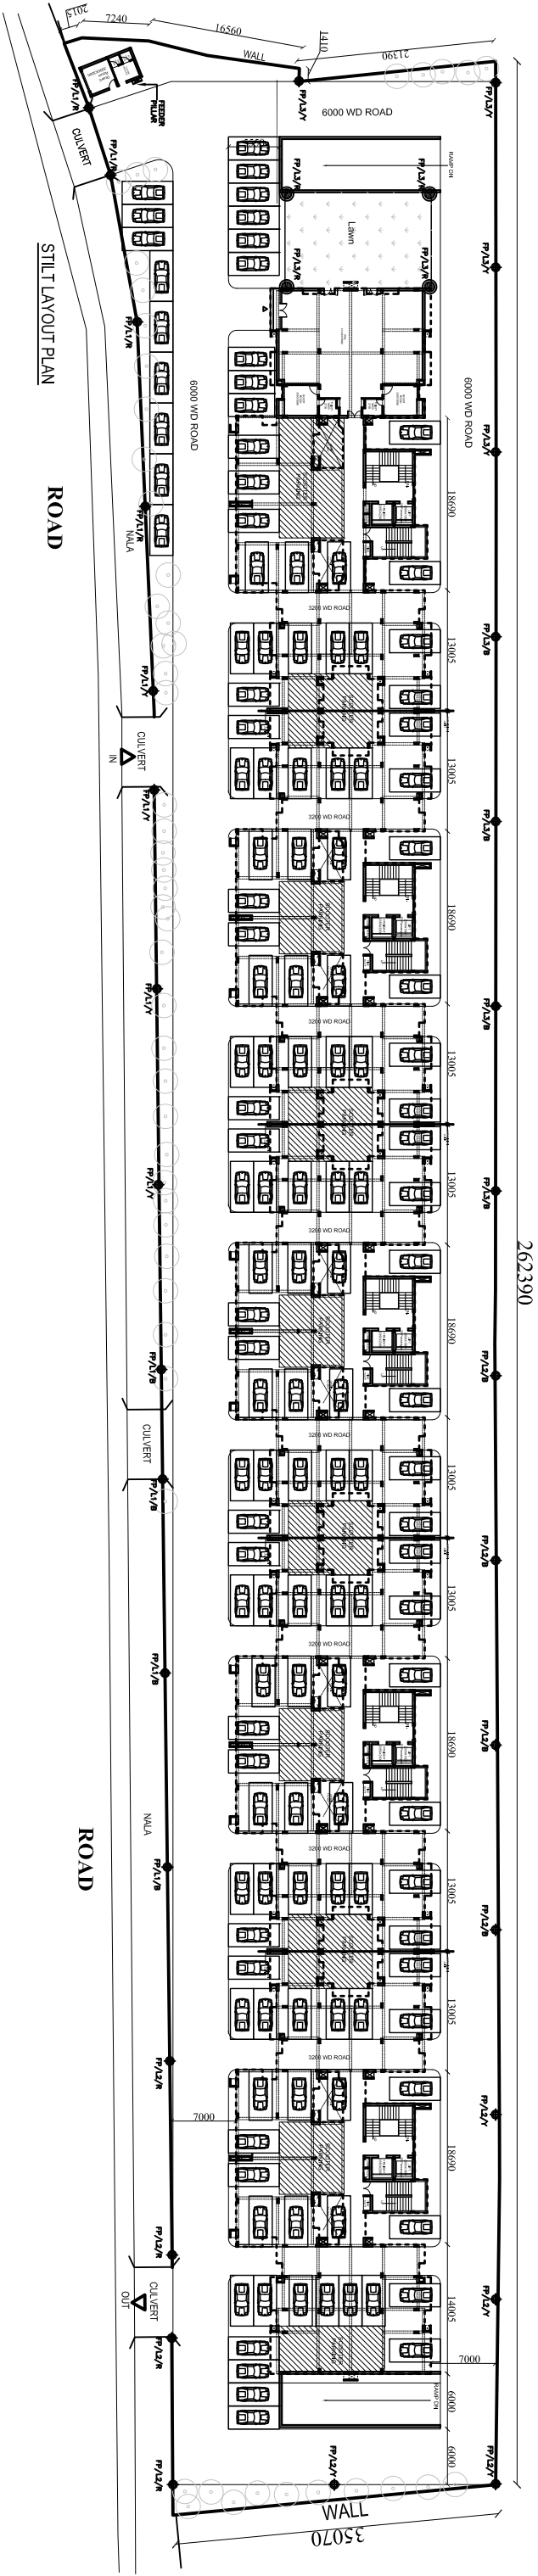

ELECTRICAL LEGEND :-

S.NO.	SYMBOL	DESCRIPTION
1		7M SINGLE ARM POLE
2		FEEDER PILLAR
3		3M POST TOP LANTERN
4		100MM DIA ROAD CROSSING

PROPOSED GROUP HOUSING - ASLESA APARTMENTS AT PLOT NO. C4, SECTOR -O, MANSAROVAR YOJNA, KANPUR ROAD ,LDA, LUCKNOW		BUILDING MAP CONSULTANT TRIVENI CONSULTING ENGINEERS FLAT-D, AVON RESIDENCY, A1/8, SECTOR-H, ALIGANJ, LUCKNOW. EMAIL:triveniconsultants.lko@gmail.com Mb:09794991199		OWNER		ARCHITECT				architects m u r a l i a g e architects , interior decorators & muralists A-3/269 , vibhav khand , gomti nagar , lucknow phone no. : 2980139, 2320715		sayi/a-rohit ira-sumit namit Sheet No 17		SERVICES DRAWING EXTERNAL ELECTRICAL SCALE - 1:400	
--	--	---	--	--------------	--	------------------	--	--	--	--	--	--	--	---	--