



SIXTH FLOOR FIRE ALARM LAYOUT

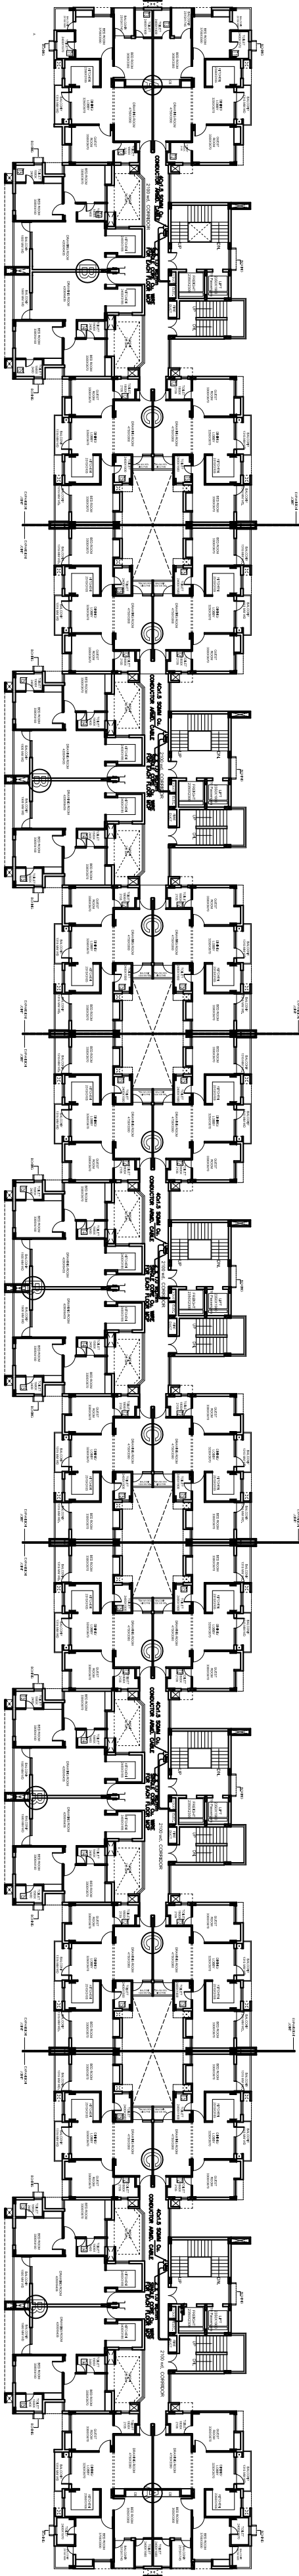

TYPICAL FLOOR FIRE ALARM LAYOUT (1ST TO 5TH FLOOR)

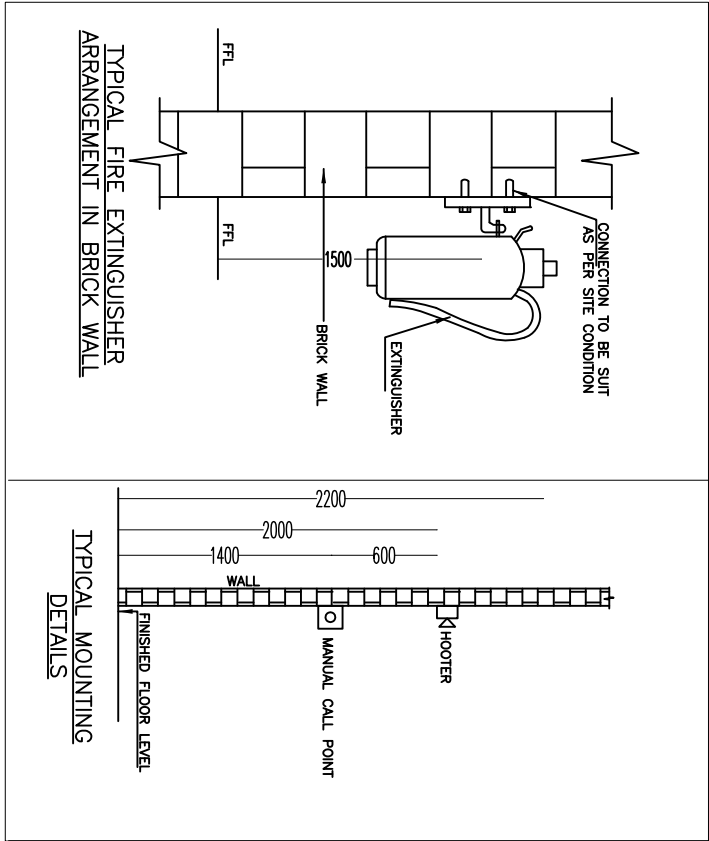

- GENERAL NOTES:-
1. FIRE ALARM CONTROL CABLE SHALL BE 2CX1.5 SQ.MM UNARMORED FRLS OUTER SHEATHED, PVC INSULATED COPPER CONDUCTOR CABLE LAID IN CONCEALED MEDIUM CLASS PVC CONDUIT.
 2. PUBLIC ADDRESS CONTROL CABLE SHALL BE 2CX1.0 SQ.MM UNARMORED FRLS OUTER SHEATHED, PVC INSULATED COPPER CONDUCTOR CABLE LAID IN CONCEALED MEDIUM CLASS PVC CONDUIT.
 3. 20MM Ø MEDIUM CLASS PVC CONDUIT SHALL BE CONCEALED IN SLAB/WALL, FOR FIRE ALARM & PA CABLING IN CONCEALED CONDUIT TYPE. PVC CONDUIT SHALL BE USED WHERE IN FIRE SHAFT VERTICAL RISER AND EXPOSED BELOW CEILING.
 4. THE FIRE ALARM SYSTEM DESIGNED AS PER IS: 2189 – 1999.

PLOT NO -C4

PROPOSED GROUP HOUSING AT PLOT NO. C4, SECTOR -O,
MANSAROVAR YOJNA, KANPUR ROAD ,LDA, LUCKNOW

BUILDING MFP CONSULTANT TRIVENT CONSULTING ENGINEERS FLAT NO.-D, GF, AYON, RESIDENCY A1/8, SEC-H, ALIGANJ, LUCKNOW EMAIL:triventconsultants_lko@gmail.com PH:3224105631, 09794931193		ARCHITECT		ORIENTATION		architects m u r a l a g e architects , interior decorators & muralists B-1/29 , sector - a , alliganj lucknow phone no. : 2321590, 2320715		sayita-rohit ira-sunil namit		Sheet No 15 Ref No - L-81 AF-979(3) Date - November'16		SERVICES DRAWING TYPICAL FLOOR & SIXTH FLOOR FIRE ALARM LAYOUT SCALE - 1:300	
---	--	------------------	--	--------------------	--	---	--	---	--	---	--	---	--