


LEGEND:- WATER SUPPLY

SYMBOL	DESCRIPTION
	110 HDPE WATER SUPPLY PIPE
	160 HDPE WATER SUPPLY PIPE
	200 DI. K9 RISING MAIN

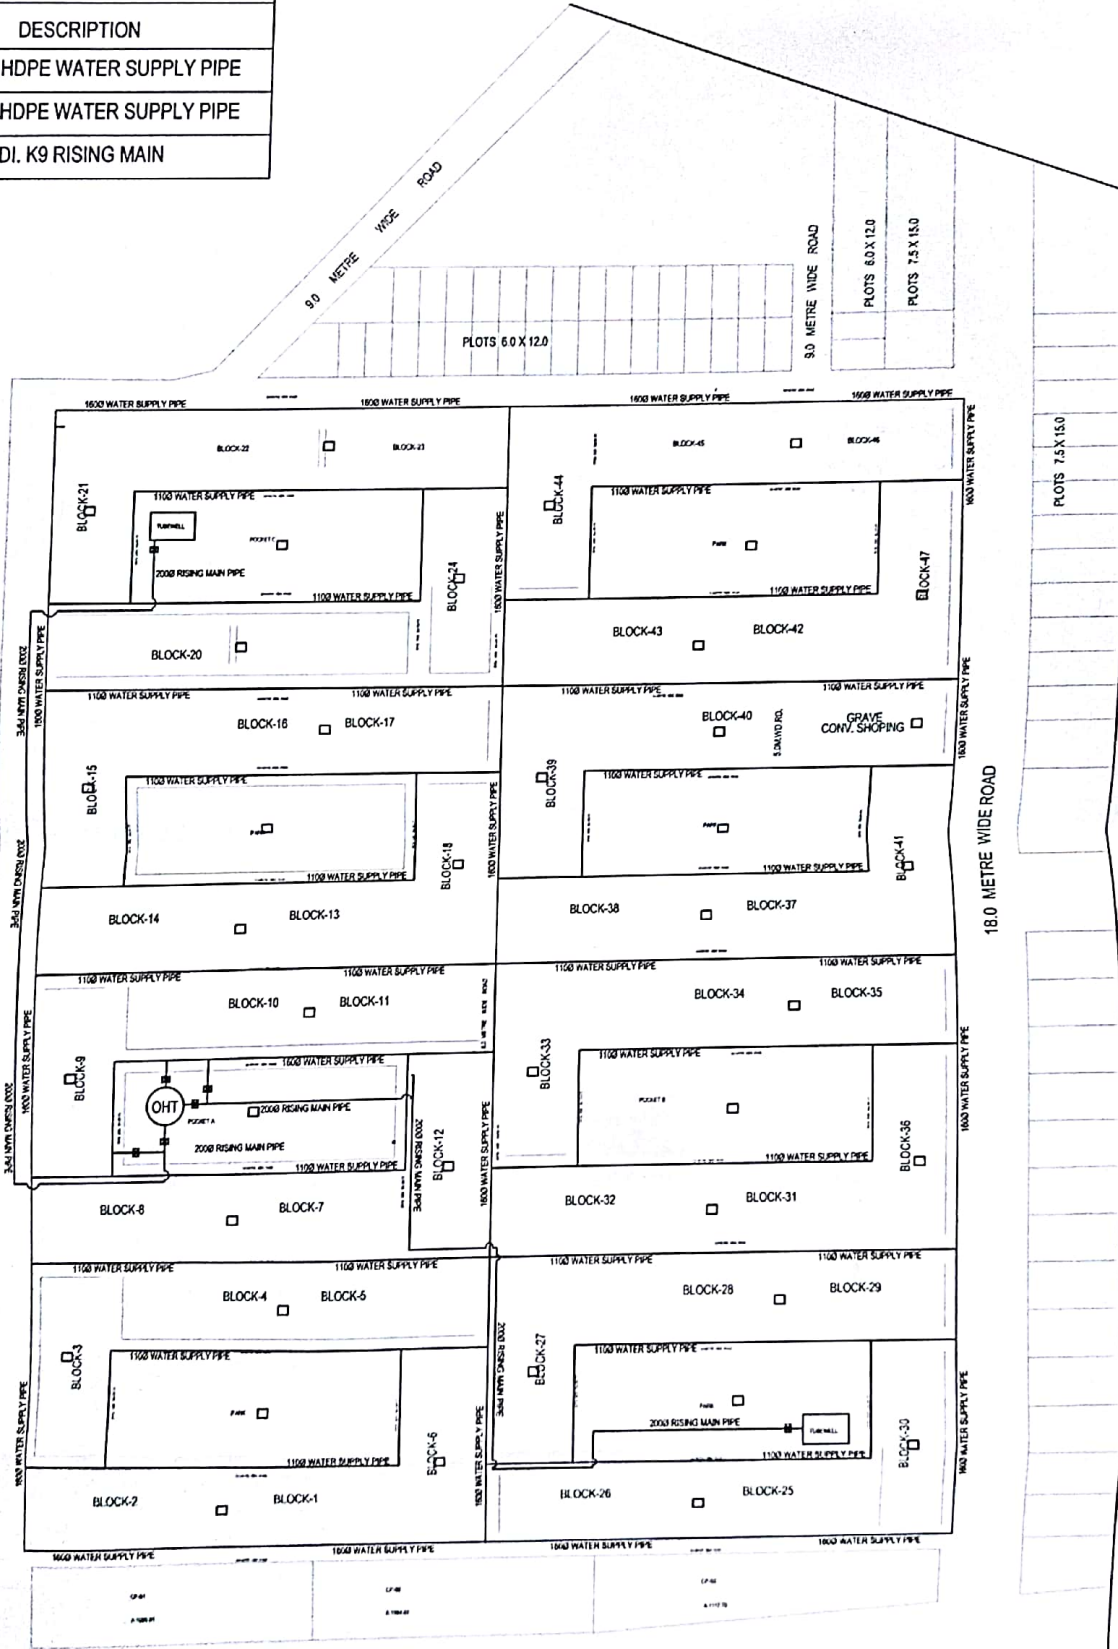

(विशेष कृपायां वाच्य) अखिल कदीर (कुल निवासी)
अपर अभियन्ता
(विशेष निर) सहायक अभियन्ता

PROJECT:-	DRAWING TITLE:-	Drg. No.	Scale	Drawn by	Services Consultant:	ARCHITECTURAL CONSULTANTS -
PRADHANMANTRI-AWAS-BASANTKUNJ	SITE PLAN WATER SUPPLY LAYOUT	PL-03	A2-150	AMIT	SHAH PANT	ARCH DOT CREATION
			Date	Checked By		
			SEP/2019	M. PANT		

ARCHITECTURAL CONSULTANTS -
ARCH DOT CREATION
BLOCK/NO OFFICE:
719, 7TH Floor, Cyber Heights, Vasant Vihar, New Delhi, India
Ph: 011-2725621, 9411021936
e-mail: arch.dot.creation@gmail.com
PRADMANTRI OFFICE:
2160-2161 Karama Marg, Mansarovar, Jaipur, India
Ph: 09471594638
e-mail: arch.dot.creation@gmail.com