


SITE PLAN

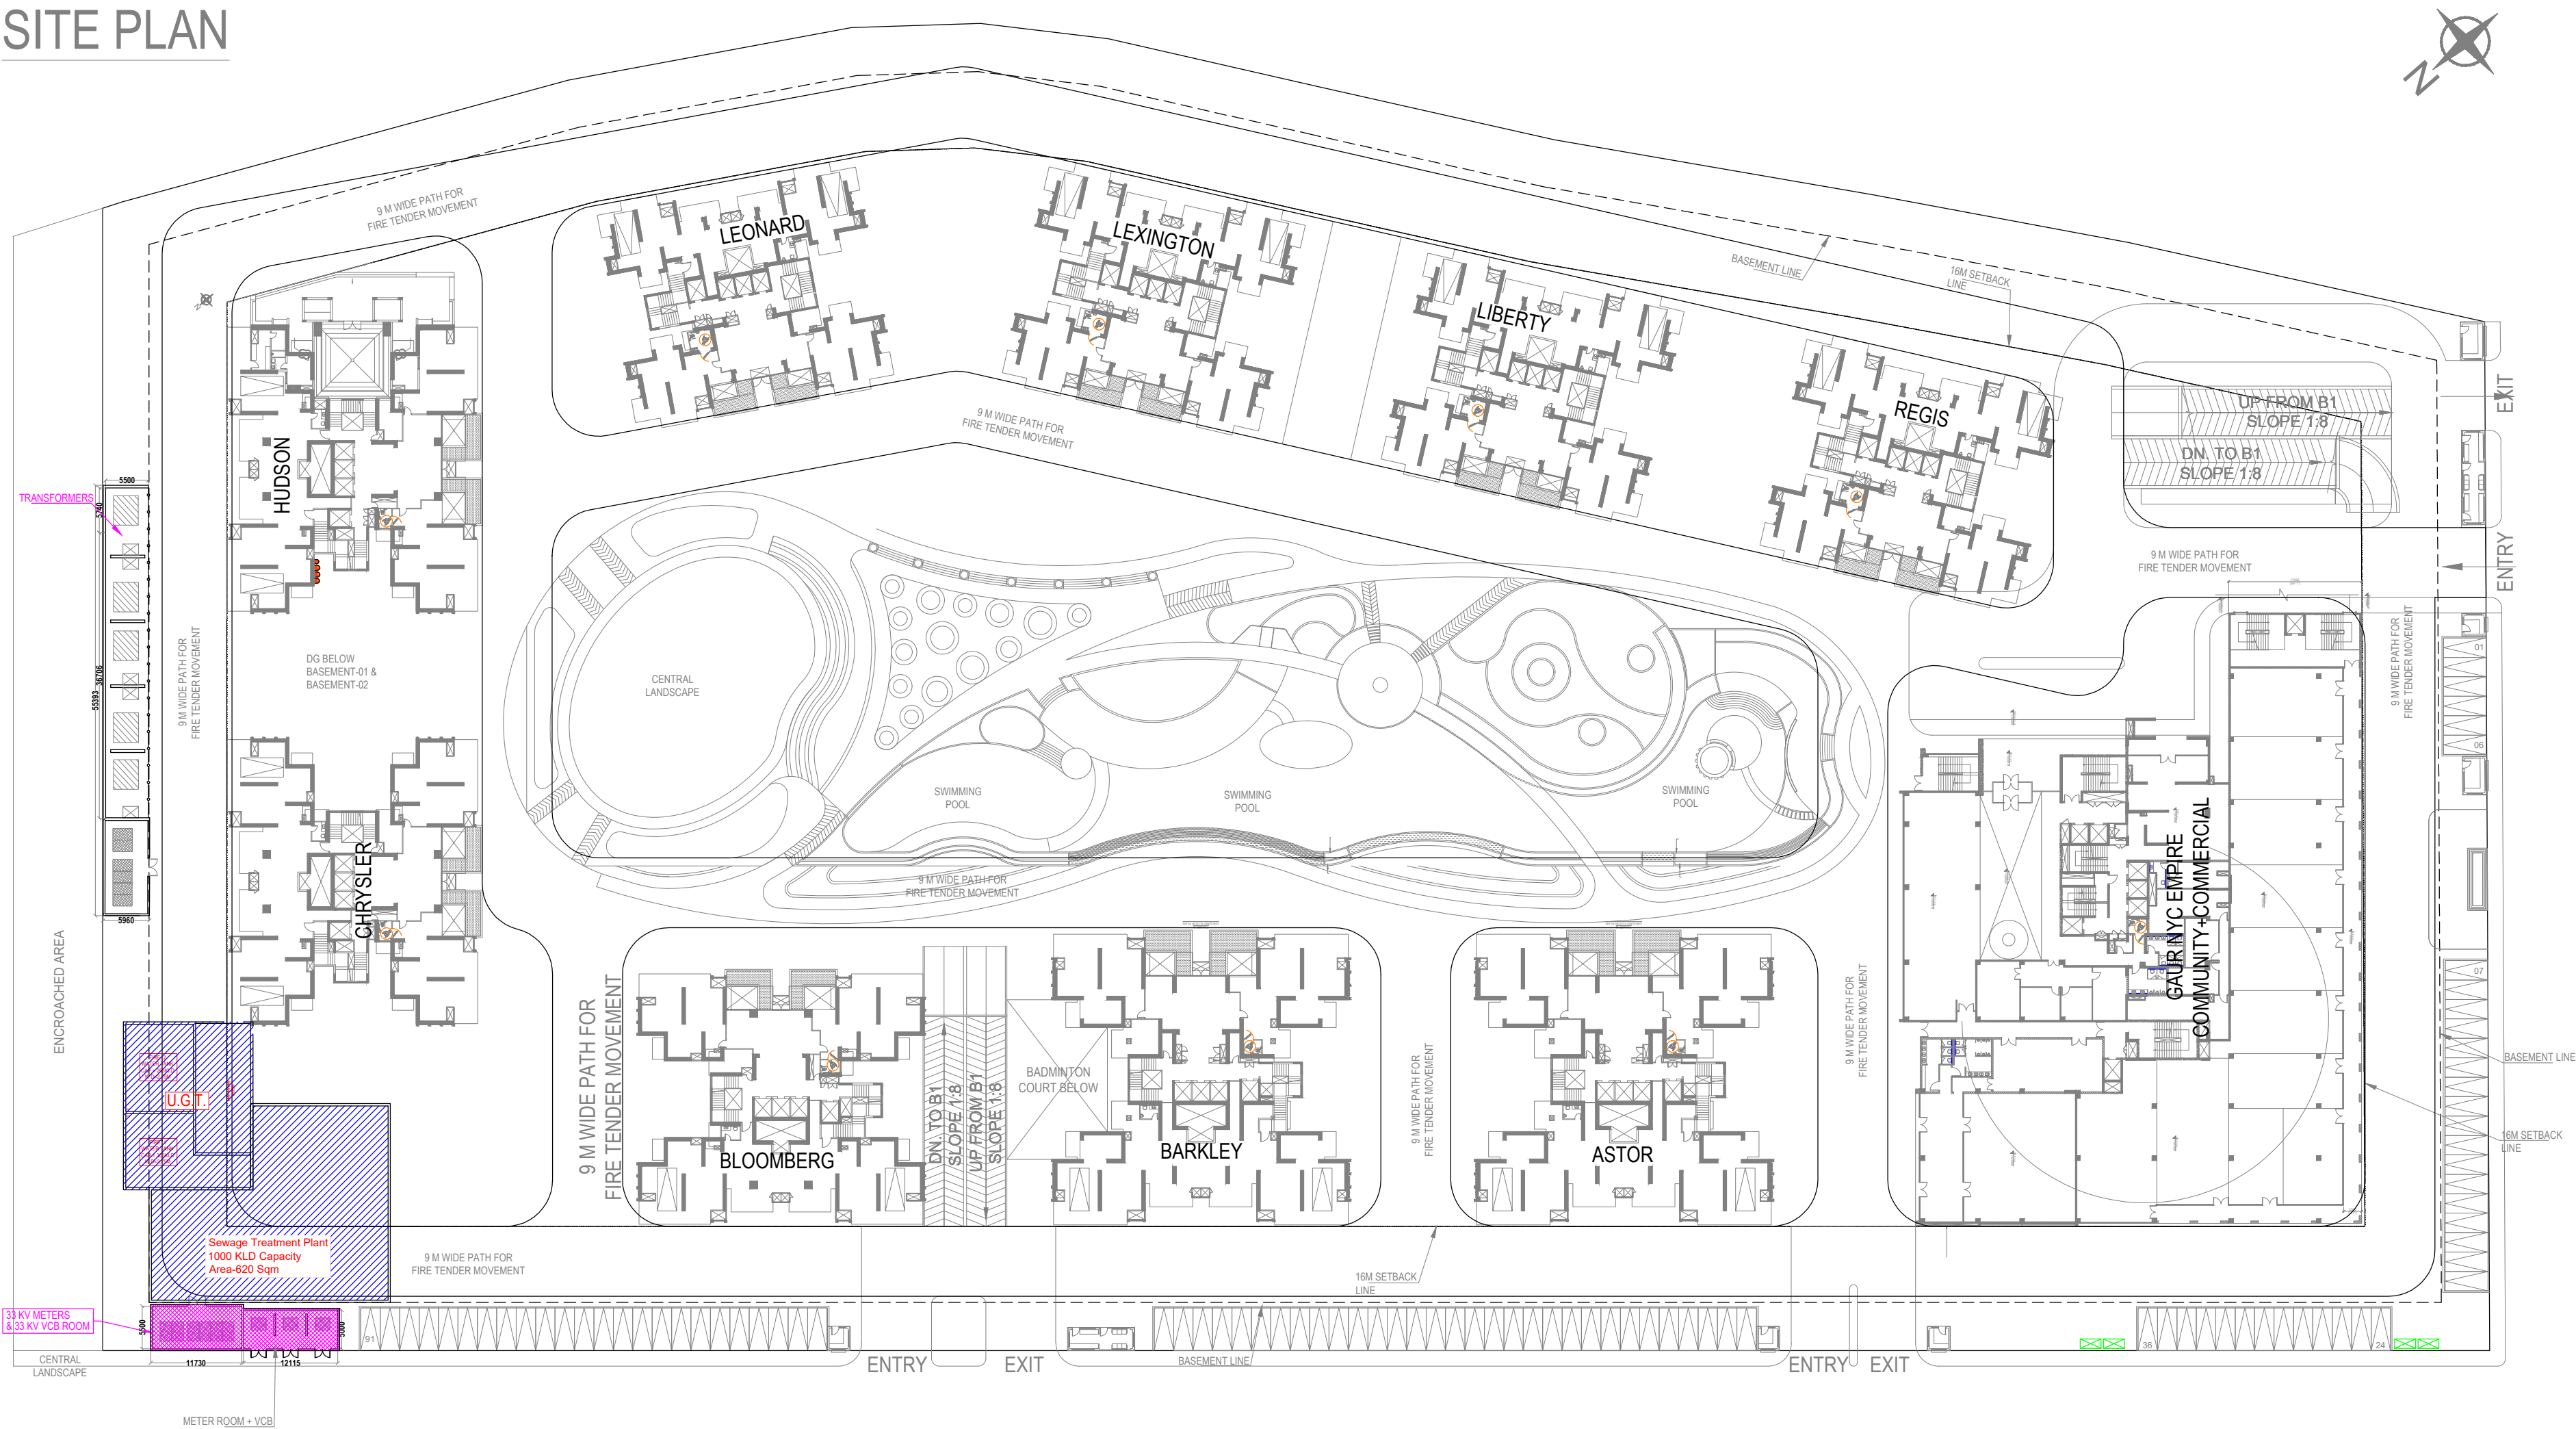

PROJECT - Gaur NYC Residences at Ghaziabad.								
SUMMARY LOAD SHEET								
Sl.no	Substation with Block	Nos Of Tower	Number of Units each Tower	Total Number of Units	Load in KW	Diversity	Demand Load in KW	Load in KVA
1	TOWER GAUR NYC EMPIRE (2B+S+31)	1	48	48	485	50%	242	269
2	TOWER ASTO & BARKLEY (2B+S+33)	2	128	256	2153	50%	1077	1196
3	TOWER BLOOMBERG, CHRYSLER & HUDSON (2B+S+33)	3	128	384	2707	50%	1354	1504
4	TOWER LEONARD, LEXINGTON,LIBERTY & REGIS (2B+S+34)	4	132	528	2830	50%	1415	1572
5	Commercial				179	75%	134	149
6	Common Services				1574	80%	1259	1399
Total				1216			5481	6090
Recommended Transformers = 4 no. 2000 KVA								

project **PROPOSED GAUR NYC RESIDENCES.**
AT PLOT NO 6, GROUP HOUSING AT SEC 3, NH-24,
WAVE CITY, GHAZIABAD (U.P.)

title **SITE PLAN**

subtitle **EXTERNAL ELECTRICAL LAYOUT**

drawing released for
☐ APPROVAL ☒ SUBMISSION
☐ ADVANCE COPY ☐ CONSTRUCTION

drg. no. CES / SP / EL-01 drawn by Surjeet

scale 1:500@ A1 designed by Attequr rehman

date 15.06.2024 checked by Anand Havelia

architects
Confluence
NEW DELHI , INDIA
B-421,NFC Ph-91-11-26925684 ccs@inconfluence.com Members of IBC
N.D-65,INDIA Ph-91-11-40564768 www.inconfluence.com ISO-9001:2000
architecture urban design hospitality interiors

services consultant
Consummate Engineering Services (P) Ltd.
Noida Office : B - 67, Sector - 67, Noida - 201 301
Tel : (0120) 2303500 (30 Lines)
Lko. Office : R 006, Rohtas Plumeria, Gomti Nagar, Lucknow
e mail : mail@cespln, website : www.cespln