

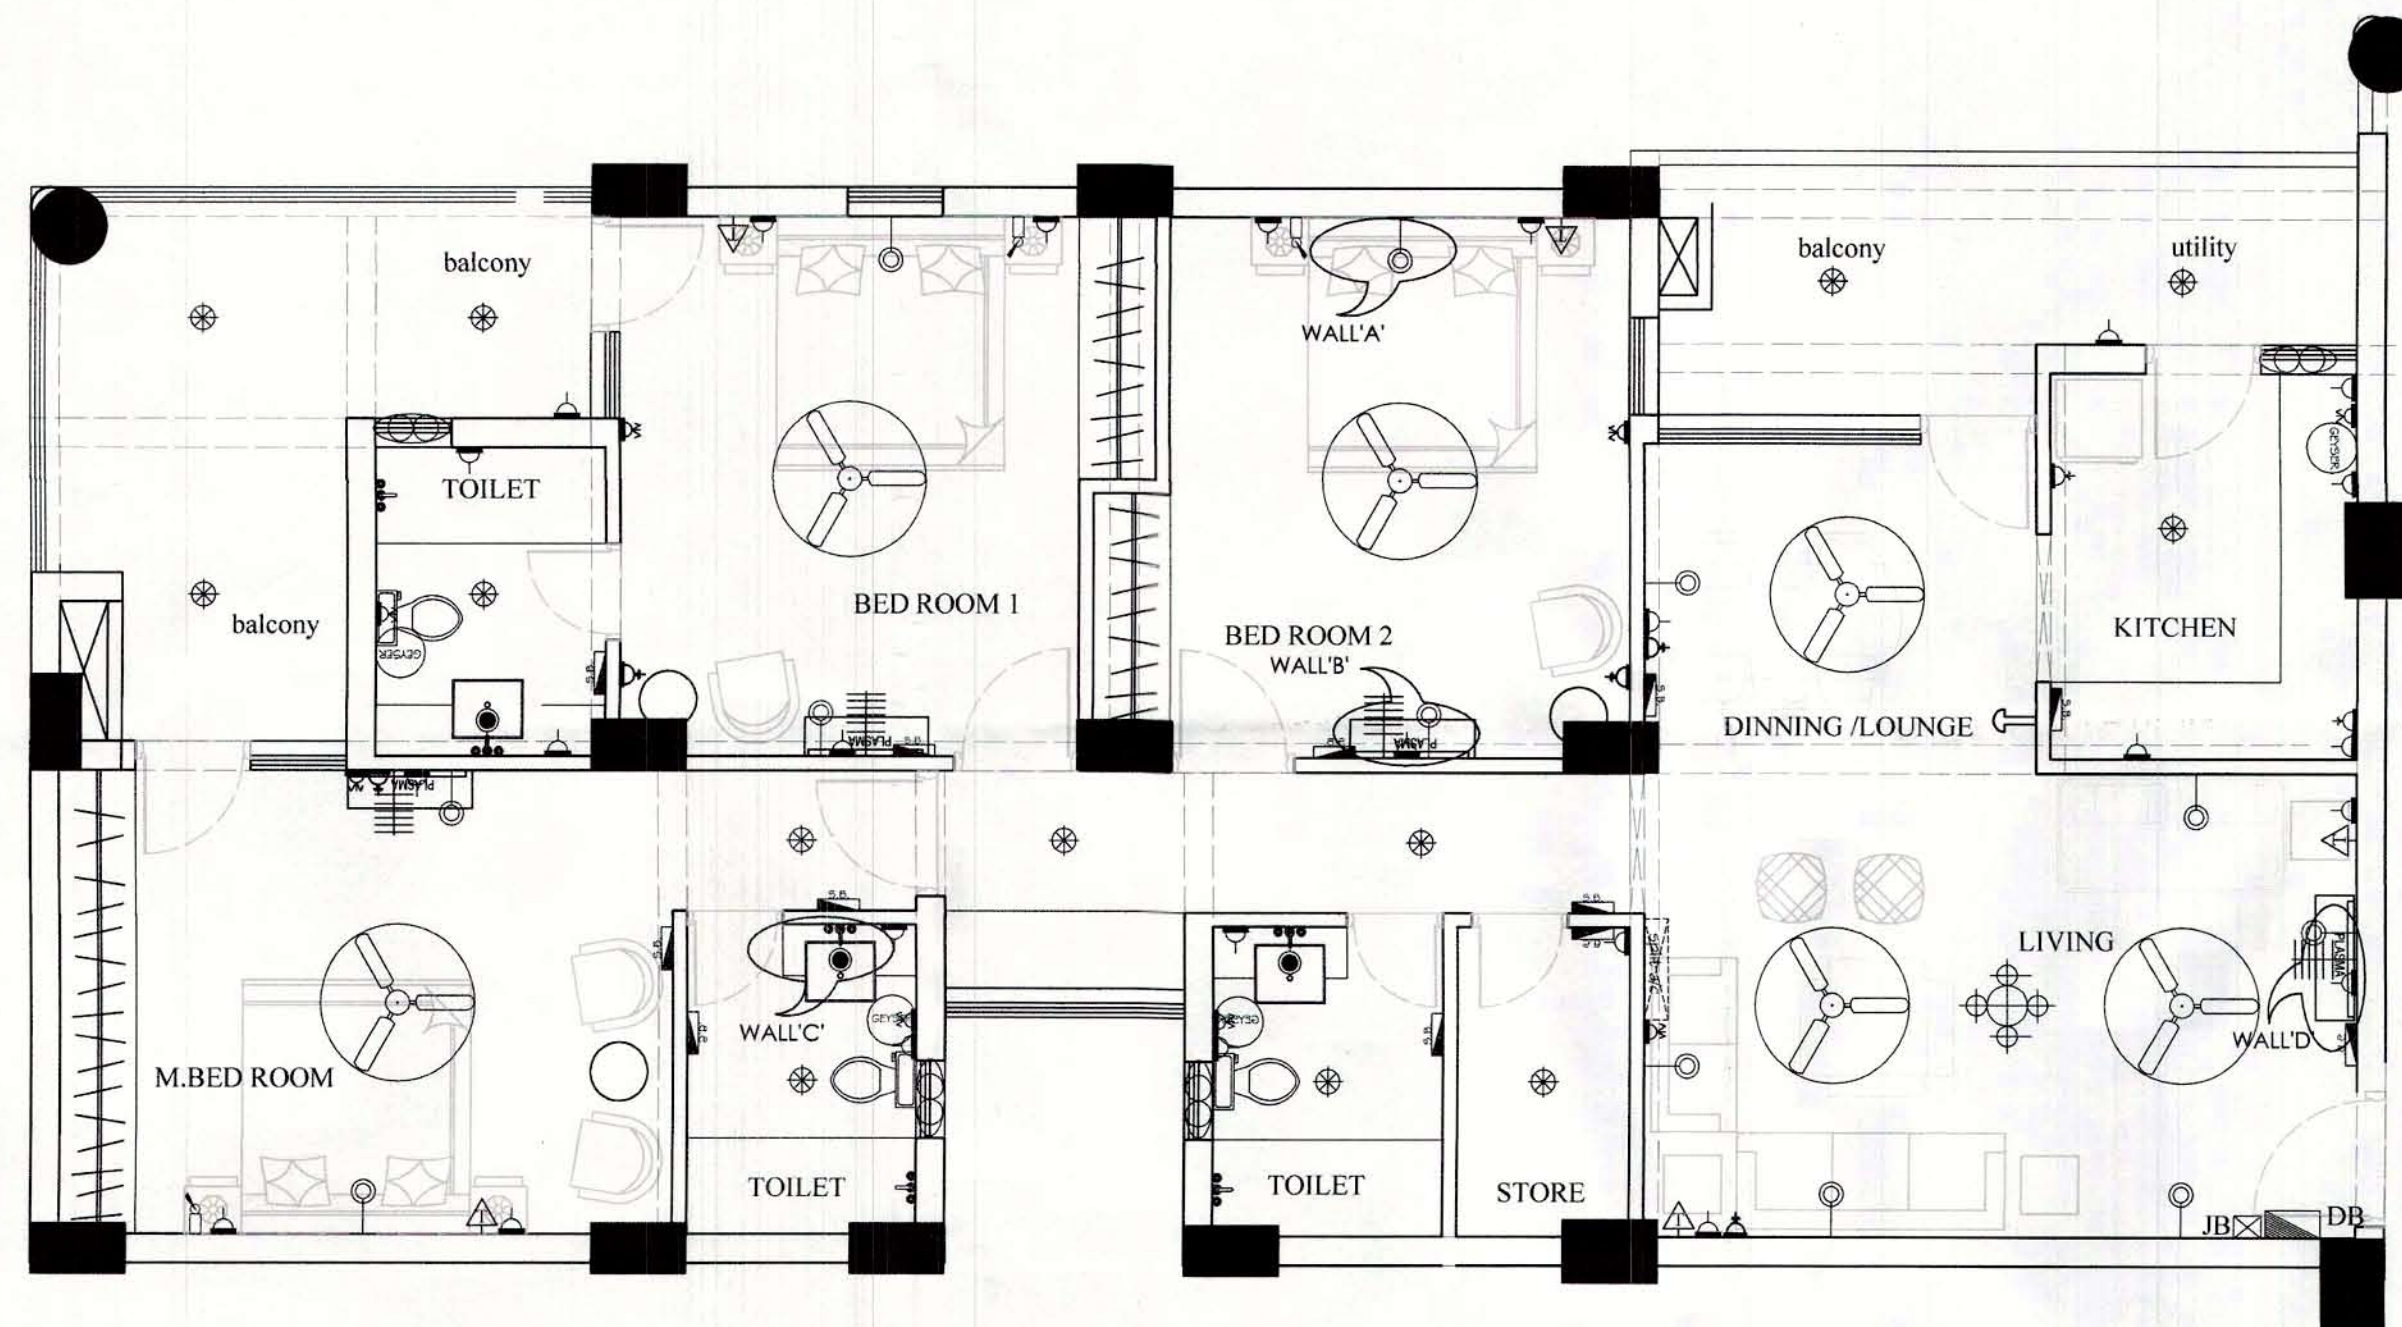
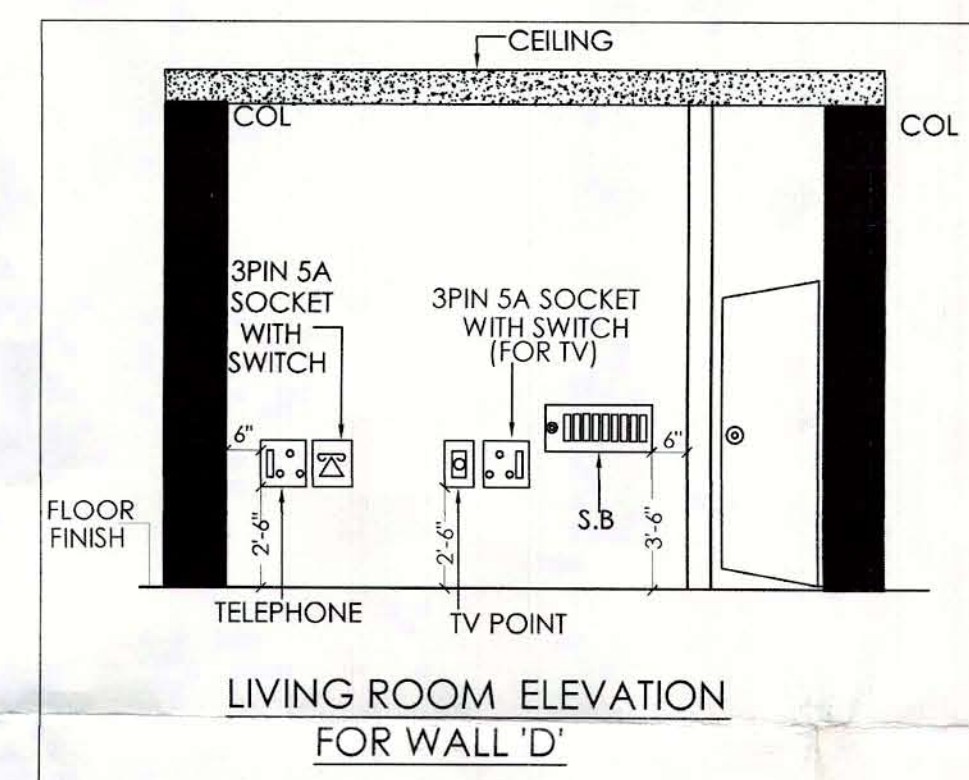
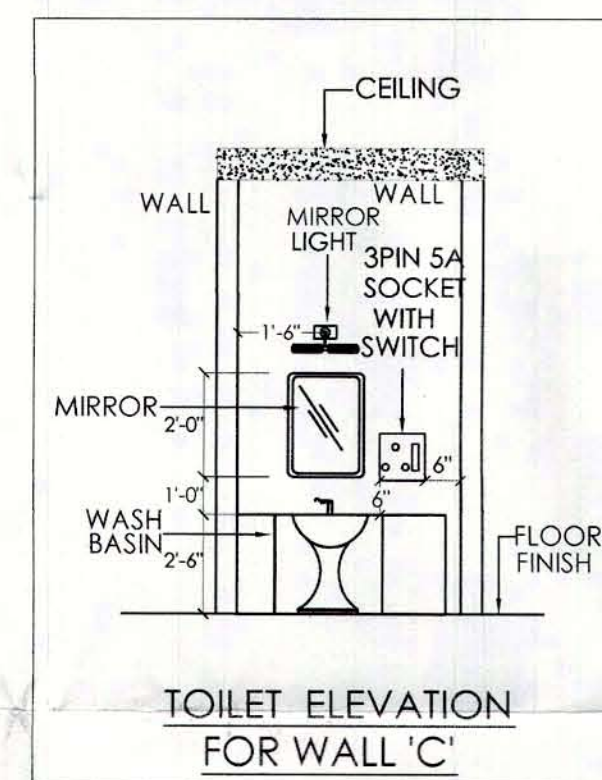


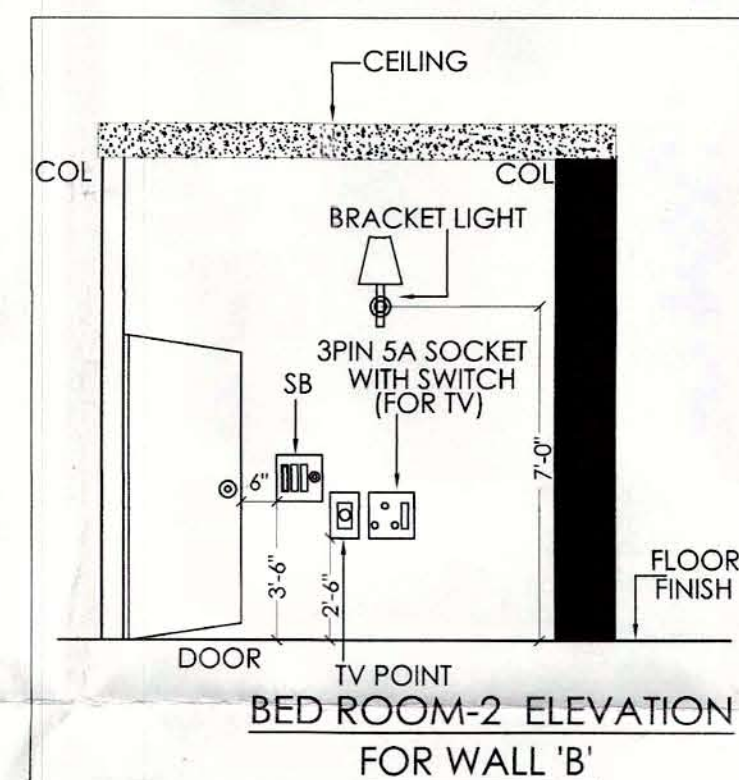

TYPE-II

ELEVATION FOR BEDROOM, TOILET & LIVING ROOM

SYMBOL	LEGEND FOR ELECTRICAL FIXTURES	HEIGHT
	SWITCH BOARD	3'-6"
	15 AMP 3 PIN SOCKET WITH SWITCH	2'-6"
	5 AMP 3 PIN SOCKET WITH SWITCH	2'-6"
	BRACKET LIGHT	7'-0"
	TELEPHONE OUTLET	2'-6"
	CEILING FAN	—
	T.V. POINT	2'-6"
	CEILING LIGHT	—
	EXHAUST FAN	—
	DISTRIBUTION BOARD	5'-0"
	JUNCTION BOX	7'-0"
	SOCKET SWITCH (GEYSER)	6'-0"
	BELL PUSH	3'-6"
	BUZZER	7'-0"
	A.C. SWITCH SOCKET	6'-0"
	CHANDELIER	—
	MIRROR BRACKET LIGHT	6'-0"
	2 WAY SWITCH	3'-6"

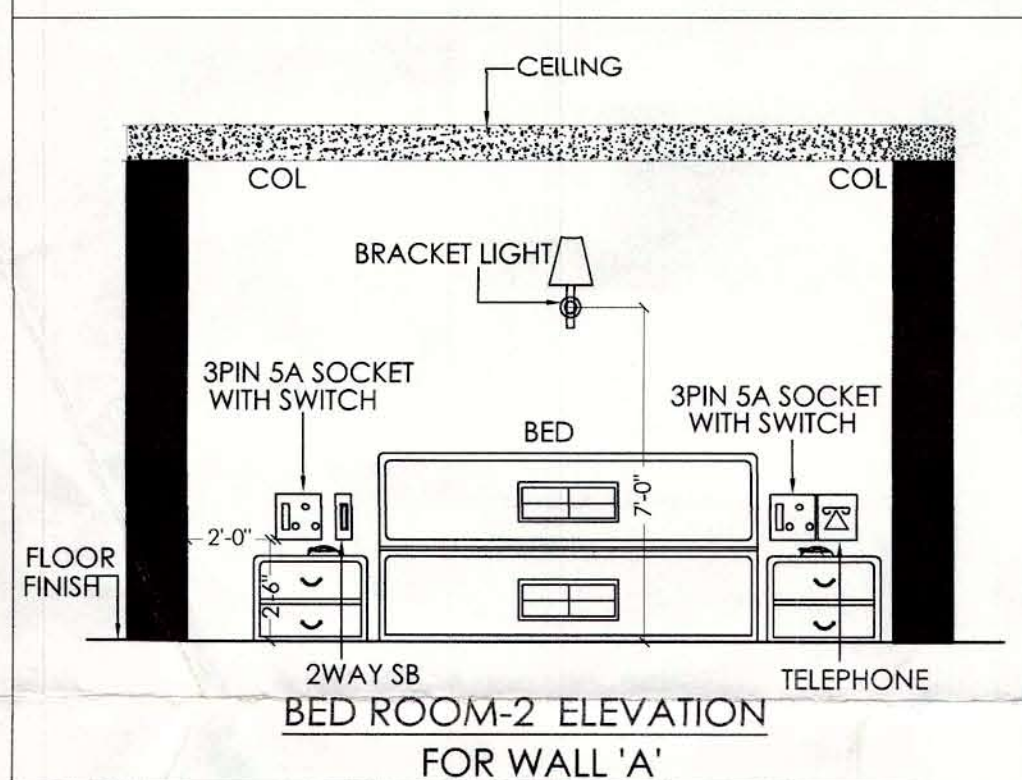

ACAD:

PROJECT:

PROPOSED SITE LAYOUT PLAN FOR
MANGLAM SHILA FOR PRERNA CONSTRUCTION
AT DAYAL BAGH, AGRA.

BLOCK NAME:

BLOCK "F"


SHEET TITLE:
ELEVATIONS
ELECTRICAL LAYOUT

SCALE:
N.T.S.

DEALT BY: CHKD BY:
SUMAN A.SINGH

allied
ARCHITECTS (P) LTD.

ARCHITECTS, ENGINEERS, INTERIOR DESIGNERS, VALUERS, PLANNERS
80/57 MALVIYA NAGAR, NEW DELHI-110 017
PH-668 0229, 668 9674 . FAX-668 7536

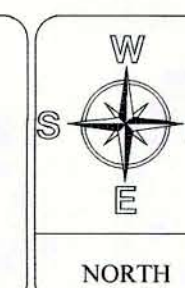

REV.-00
DATE:
25-06-14
DRG. NO:
EL/03(A)

CONSULTANT:



GIAN CONSULTANCY SERVICES
ELECTRICAL ENGG. & CONSULTANT

1352-1, STREET-13, GOVINDPURI
KALKAJI, N.D-19
PH: 011-26470050

E-mail: gianconsultancy@yahoo.com
gcs@gianconsultancy.com