



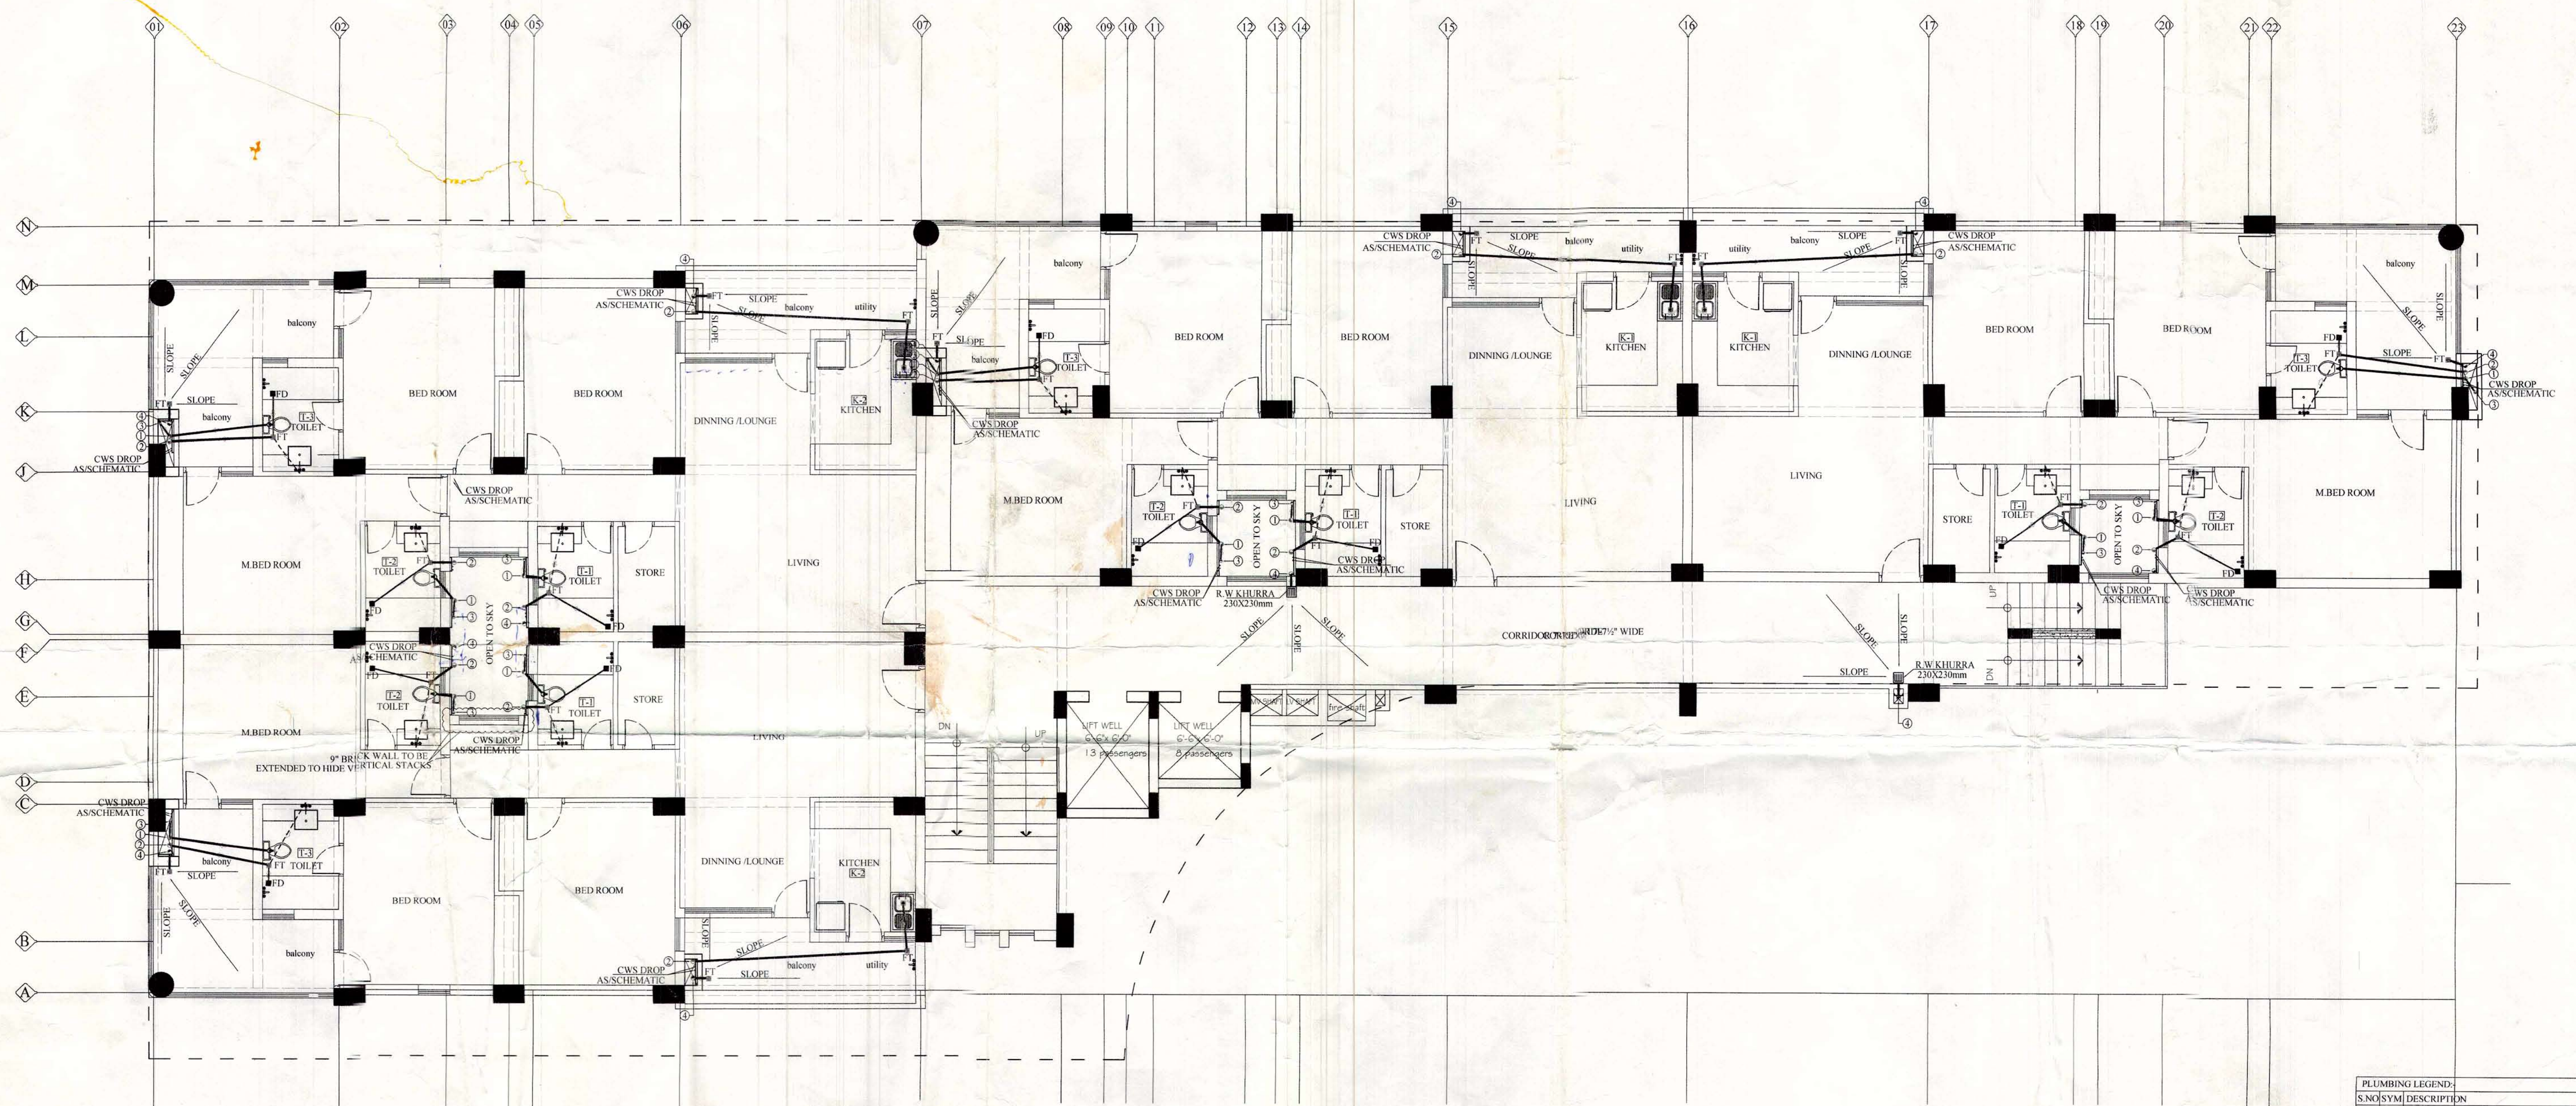

PLUMBING LEGEND:	
S.NO	SYMBOL DESCRIPTION
1.	4" SOIL PIPE STACK
1A.	6" SOIL PIPE DROP
2.	4" WASTE PIPE STACK
3.	3" A.S.P. VENT PIPE
4.	4" RAIN WATER PIPE STACK
5.	6" RAIN WATER PIPE STACK
6.	CWS DROP ASSCHEMATIC
7.	DOMESTIC WATER SUPPLY RISER
8.	FLOOR TRAP
9.	FLOOR DRAIN
10.	URINAL TRAP
11.	CLEAN OUT PLUG (COP)
12.	1" WASTE PIPE (W.B TO F.T)
13.	2" WASTE PIPE (F.D TO F.T)
14.	3" WASTE PIPE (HORIZONTAL)
15.	4" SOIL PIPE (HORIZONTAL)
16.	4" RAIN WATER PIPE (HORIZONTAL)
17.	4" STONE WARE PIPE (G.T TO M.H)
18.	0-9" X 0-9" R.W. KHURRA
19.	MANHOLE 3-0" X 2-8"
20.	CATCH BASIN 1-8" X 1-6"
21.	GULLY TRAP 1-0" X 1-0"

PROJECT :-

PROPOSED SHOPPING/ HELTH CLUB COMPLEX
AT (MANGLAM SHILA) FOR PRERNA CONSTRUCTION
AT DAYAL BAGH, AGRA.

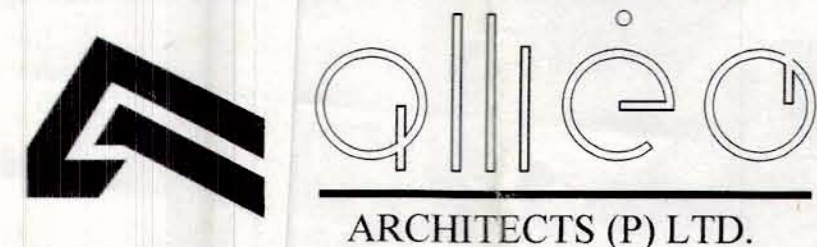

ARCHITECTS,ENGINEERS,INTERIOR DESIGNERS,VALUERS,PLANNERS
80/57 MALVIYA NAGAR, NEW DELHI-110 017
PH-668 0229, 668 9674 . FAX-668 7536

Services consultant
SANITARY CONSULTING SERVICES
SARVAPRIYA VIHAR
NEW DELHI - 110016
PHONE:011-26563670
EMAIL:vinod20th@rediffmail.com

SHEET TITLE:
TYPICAL FLOOR PLAN
PLUMBING LAYOUT

BLOCK NAME:

BLOCK-F

DRAWN BY :-

ASHISH

CHECKED BY :

V.K SHARMA

DATE:-

21-06-2014

SCALE:-

1:75@A2

DRG. NO.

PL-04

DEALT BY :

Ar. V.K. TIWARI

