


45 M WIDE ROAD

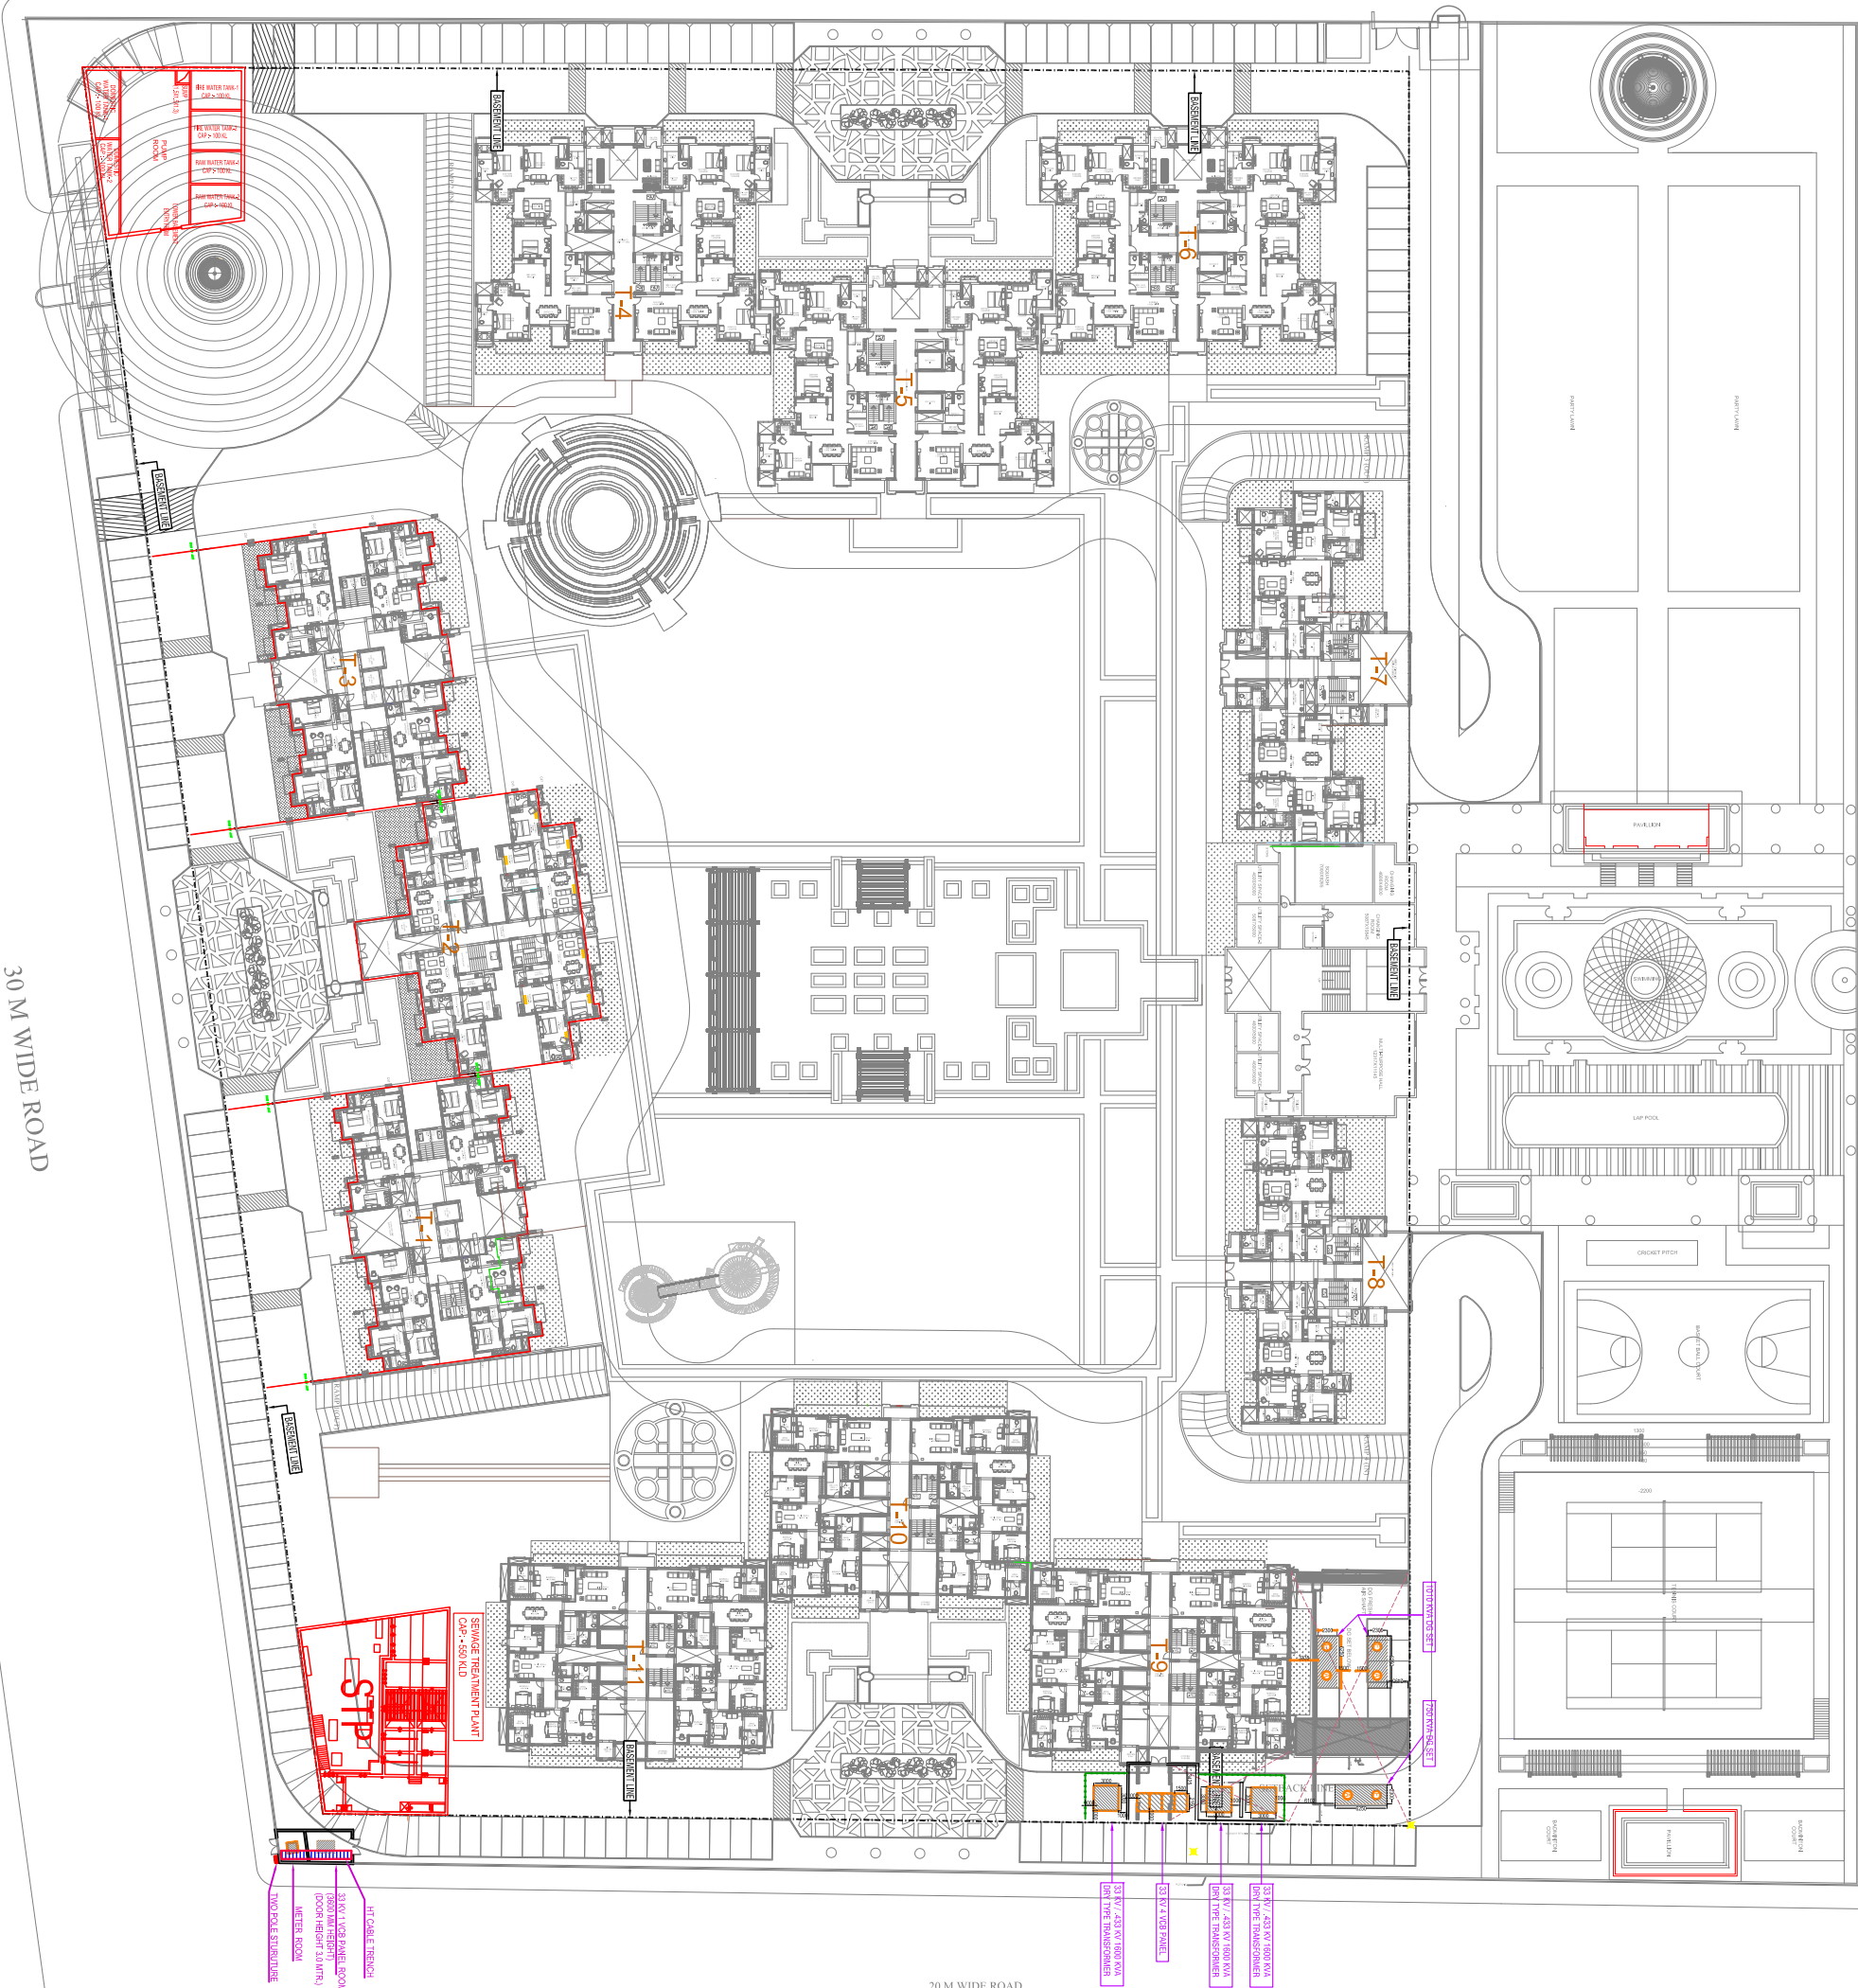

30 M WIDE ROAD

20 M WIDE ROAD

Rev. no.	Date	Revision
..
..
..
..

Project
ACE PARKWAY
SECTOR 150, NODA

Title
SITE PLAN

Subtitle
EXTERNAL ELECTRICAL LAYOUT

Drawing released for
☐ APPROVAL
☐ ADVANCE COPY

Drawn by
Savarn Sharma
Designed by
M. Manjunath
Checked by
Anand Haveli

Architects
Raj Kumar

Services Consultant
Consummate Engineering Services (P) Ltd.
Head Office : 8 - 47, Sector - 47, Noida - 201 301
Tel : 01200945200 (23 Lines)
Lko. Office : 1106, Kirti Park, Gurgaon - 122 002
e mail : mail@cespln, website : www.cespln