


LEGEND: -

SYMBOL	TYPE
	COMPACT SUB STATION
	EXTERNAL FEEDER PILLAR
	HT SUPPLY IN UNDER GROUND

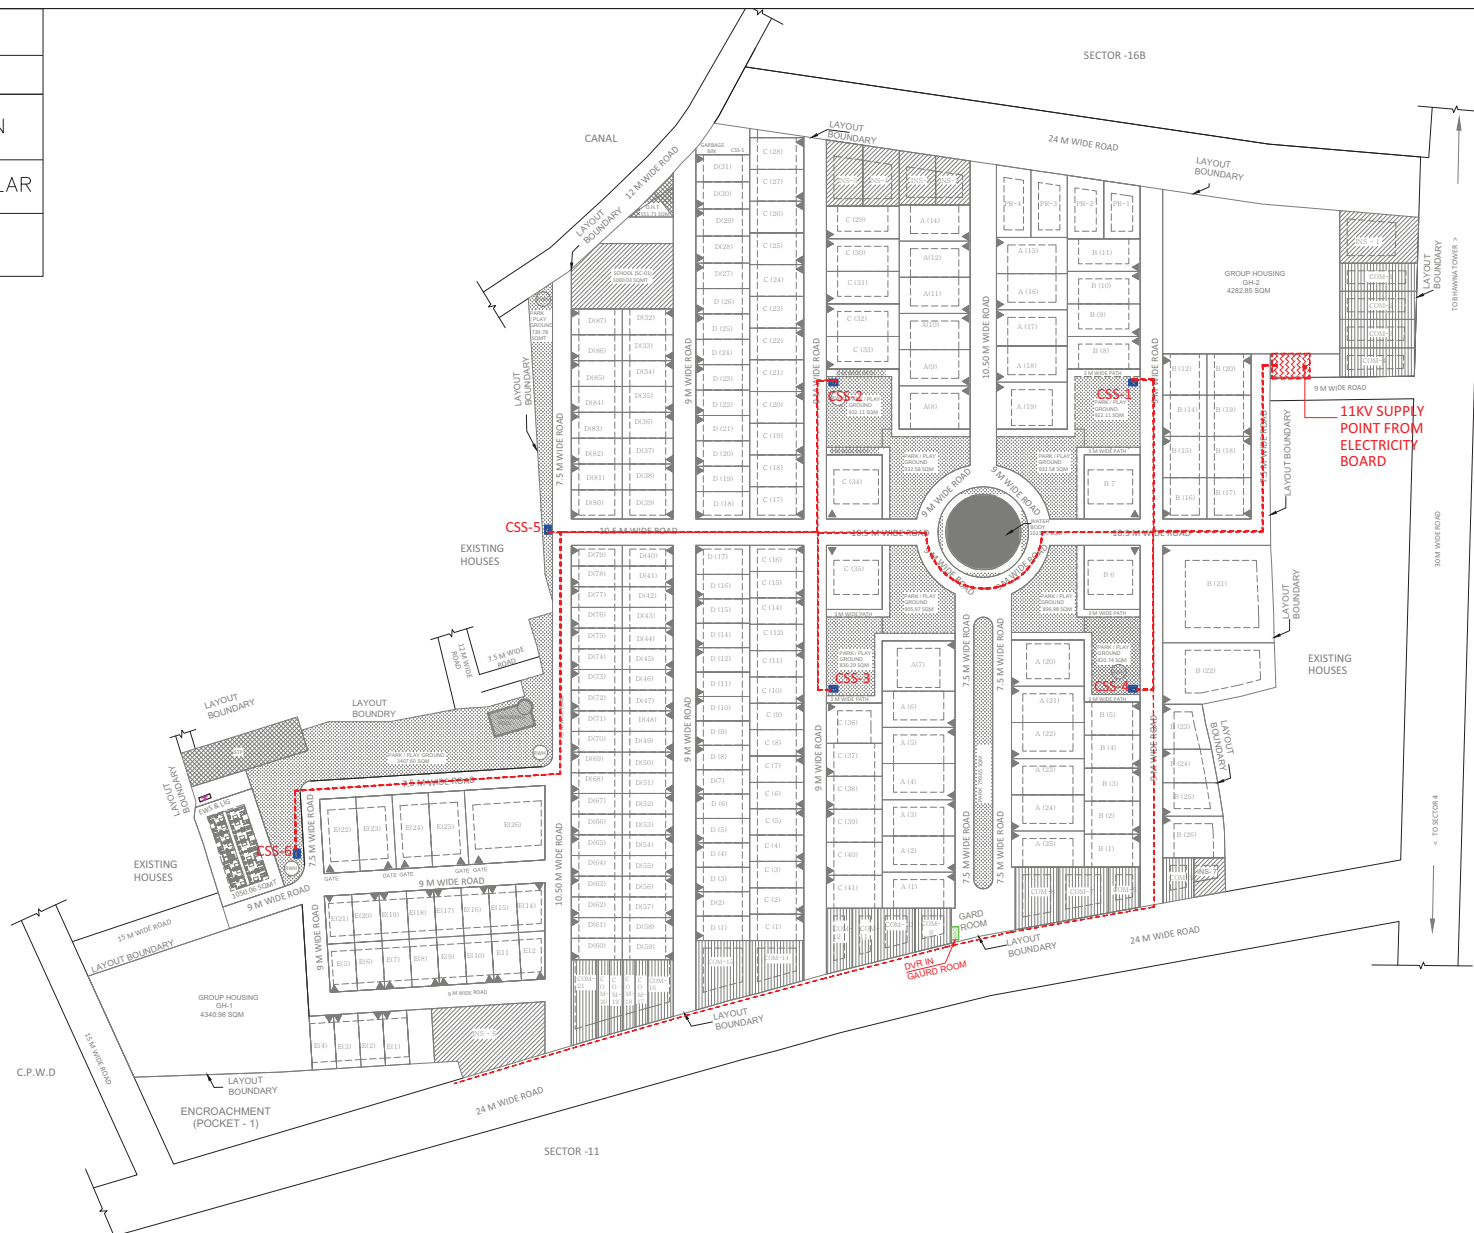

MEP CONSULTANT :-



**SK.INNOVATION
ENGINEERING PVT.LTD.**
Address:-C-15 Ground Floor, Jaipuria
Apartment, Seemant Vihar,
Kaushambi(Ghaziabad)
MOB.NO:-9718536912,9650901083,9650030116.
email:- info@skiepl.com
web:-www.skiepl.com

ARCHITECTS :-

Nexusplus consultant
B-116, Second Floor,
Sector-50, Noida.

CLIENT :
BHARAT NAGAR HOUSING
SHOBHIK GOYAL

PROJECT :-
ANTHEM, SEC-15 POCKET -A,
SIKANDRA YOJNA , AGRA

COMPANY :
BHARAT NAGAR HOUSING

DRAWING TITLE :-
HT PSS & HT CABLE ROUTE
DRAWING SITE PLAN

DRAWN BY
R.K.

ENGINEER
S.S.

CHECKED BY
R.R.

DRAWING NO.

SK/BNH/SP/EL-03

DATE:-

20-04-2017

SCALE:-

A1 , 1 : 1000

FOR REFERENCE

☐ FOR APPROVAL

☐ FOR ESTIMATION

☐ FOR TENDER

☒ FOR CONSTRUCTION

☐ AS-BUILT