


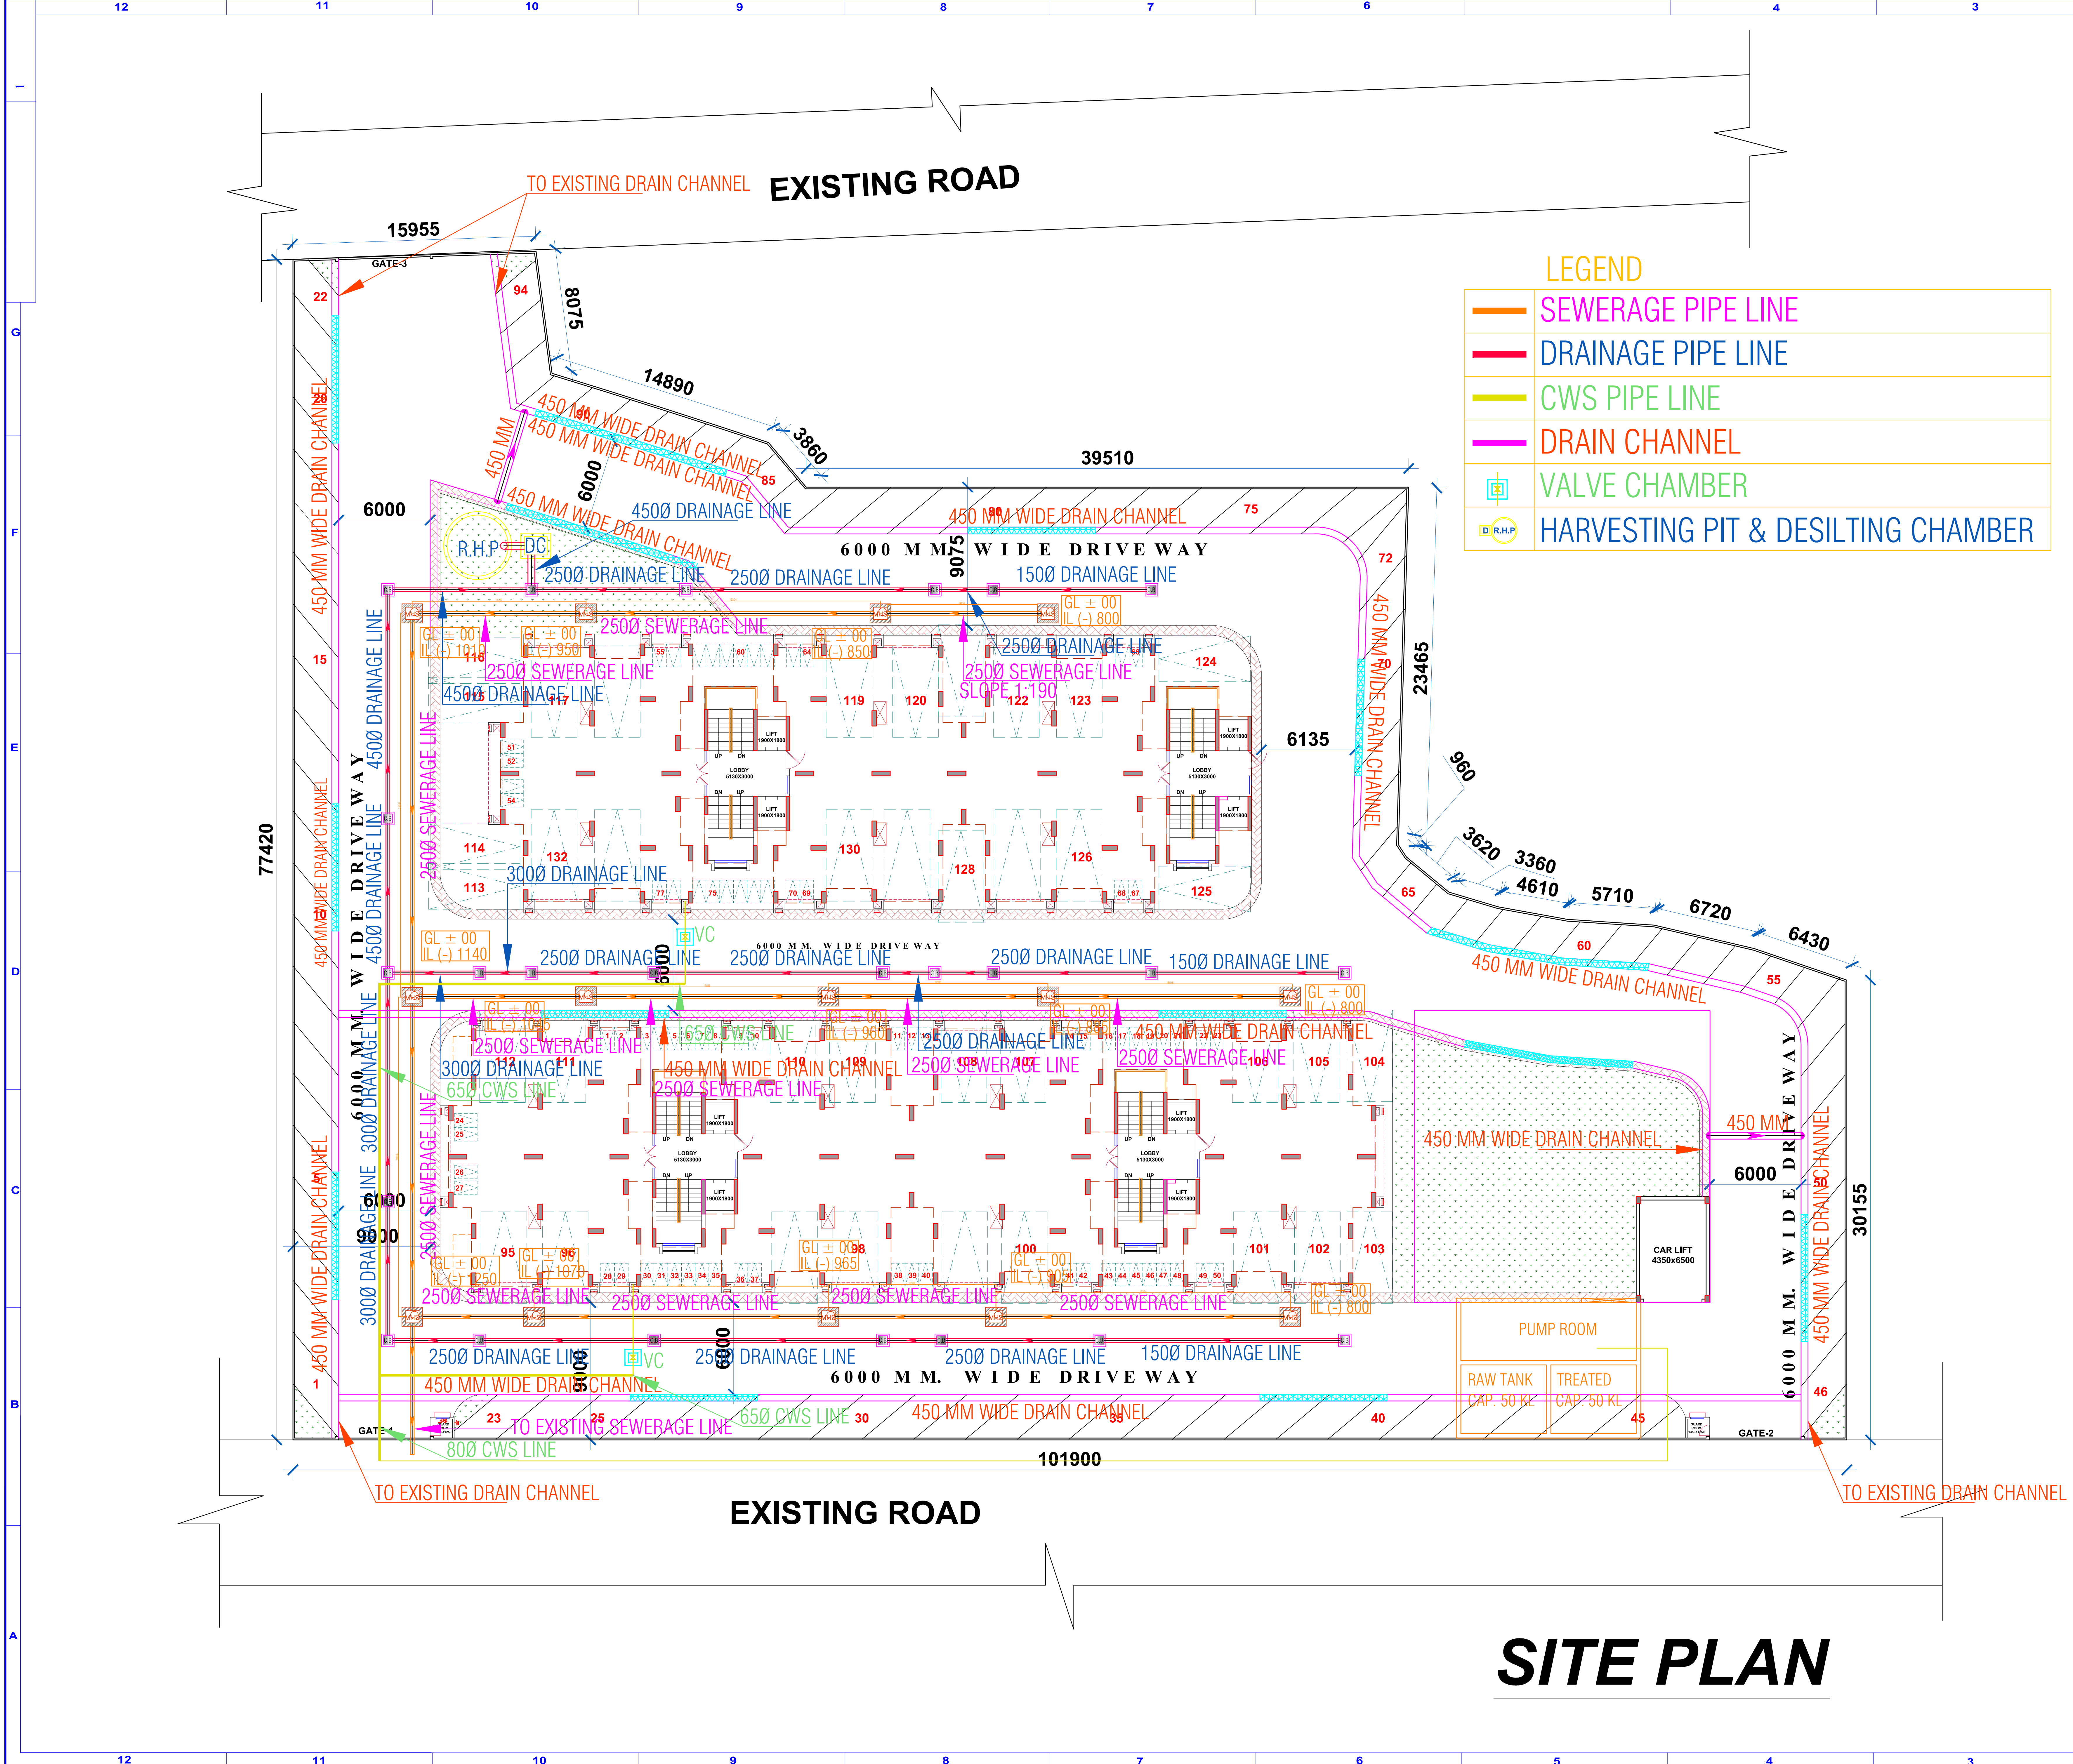

SITE PLAN


WORKING DRAWING

NOTES -
THIS DRAWING IS CONFIDENTIAL AND SHOULD NOT BE DISCLOSED, COPIED OR LENT TO A THIRD PARTY WITHOUT WRITTEN CONSENT OF SKYLINE ARCHITECTURAL CONSULTANTS PVT LTD. EXCEPT THE SYSTEM FOR WHICH THE DRAWING IS MEANT.

DO NOT SCALE DRAWING ONLY WRITTEN DIMENSIONS ARE TO BE FOLLOWED

Plumbing and Fire Protection Consulting Services
SYSTEM CONSULTANCY SERVICES
F - 1/240, 1St Floor Sector 16, Rohini
Email: writetoscs@gmail.com

NORTH

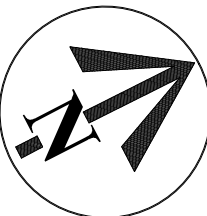

REVISIONS

SL. NO.	DESCRIPTION	BY	DATE
R0			

CLIENT

PROJECT

KANPUR ROAD YOJNA ,
GROUP HOUSING SCHEME,
LUCKNOW

ARCHITECT

SKYLINE
architectural consultants pvt ltd.
architects, engineers & interior designers
office
patrakar puram crossing gomti nagar Bho U.P. INDIA
dial
0522-2394123, 2393123, 4044123 fax 0522-2393126
email
skyline@skysc.com, architectskyline315@gmail.com
website www.skylinearchitect.com
also off: 48107 MIDC WASH TECH DRIVE GUNTE-5 WILSON MCHRON
MICHIGAN, USA - 48393 TEL : (248)675-1200 FAX (248)675-1201
architect : sanjay & vijay sinha
AN ISO 9001:2008 CERTIFIED

TITLE		SCALE	DATE
SITE PLAN PLUMBING LAYOUT			
DRAWING NO.	LDA /LKO /500AI/-01		REV.
SHEET NO.	A1		0