



PLOT NO : - GH-3B

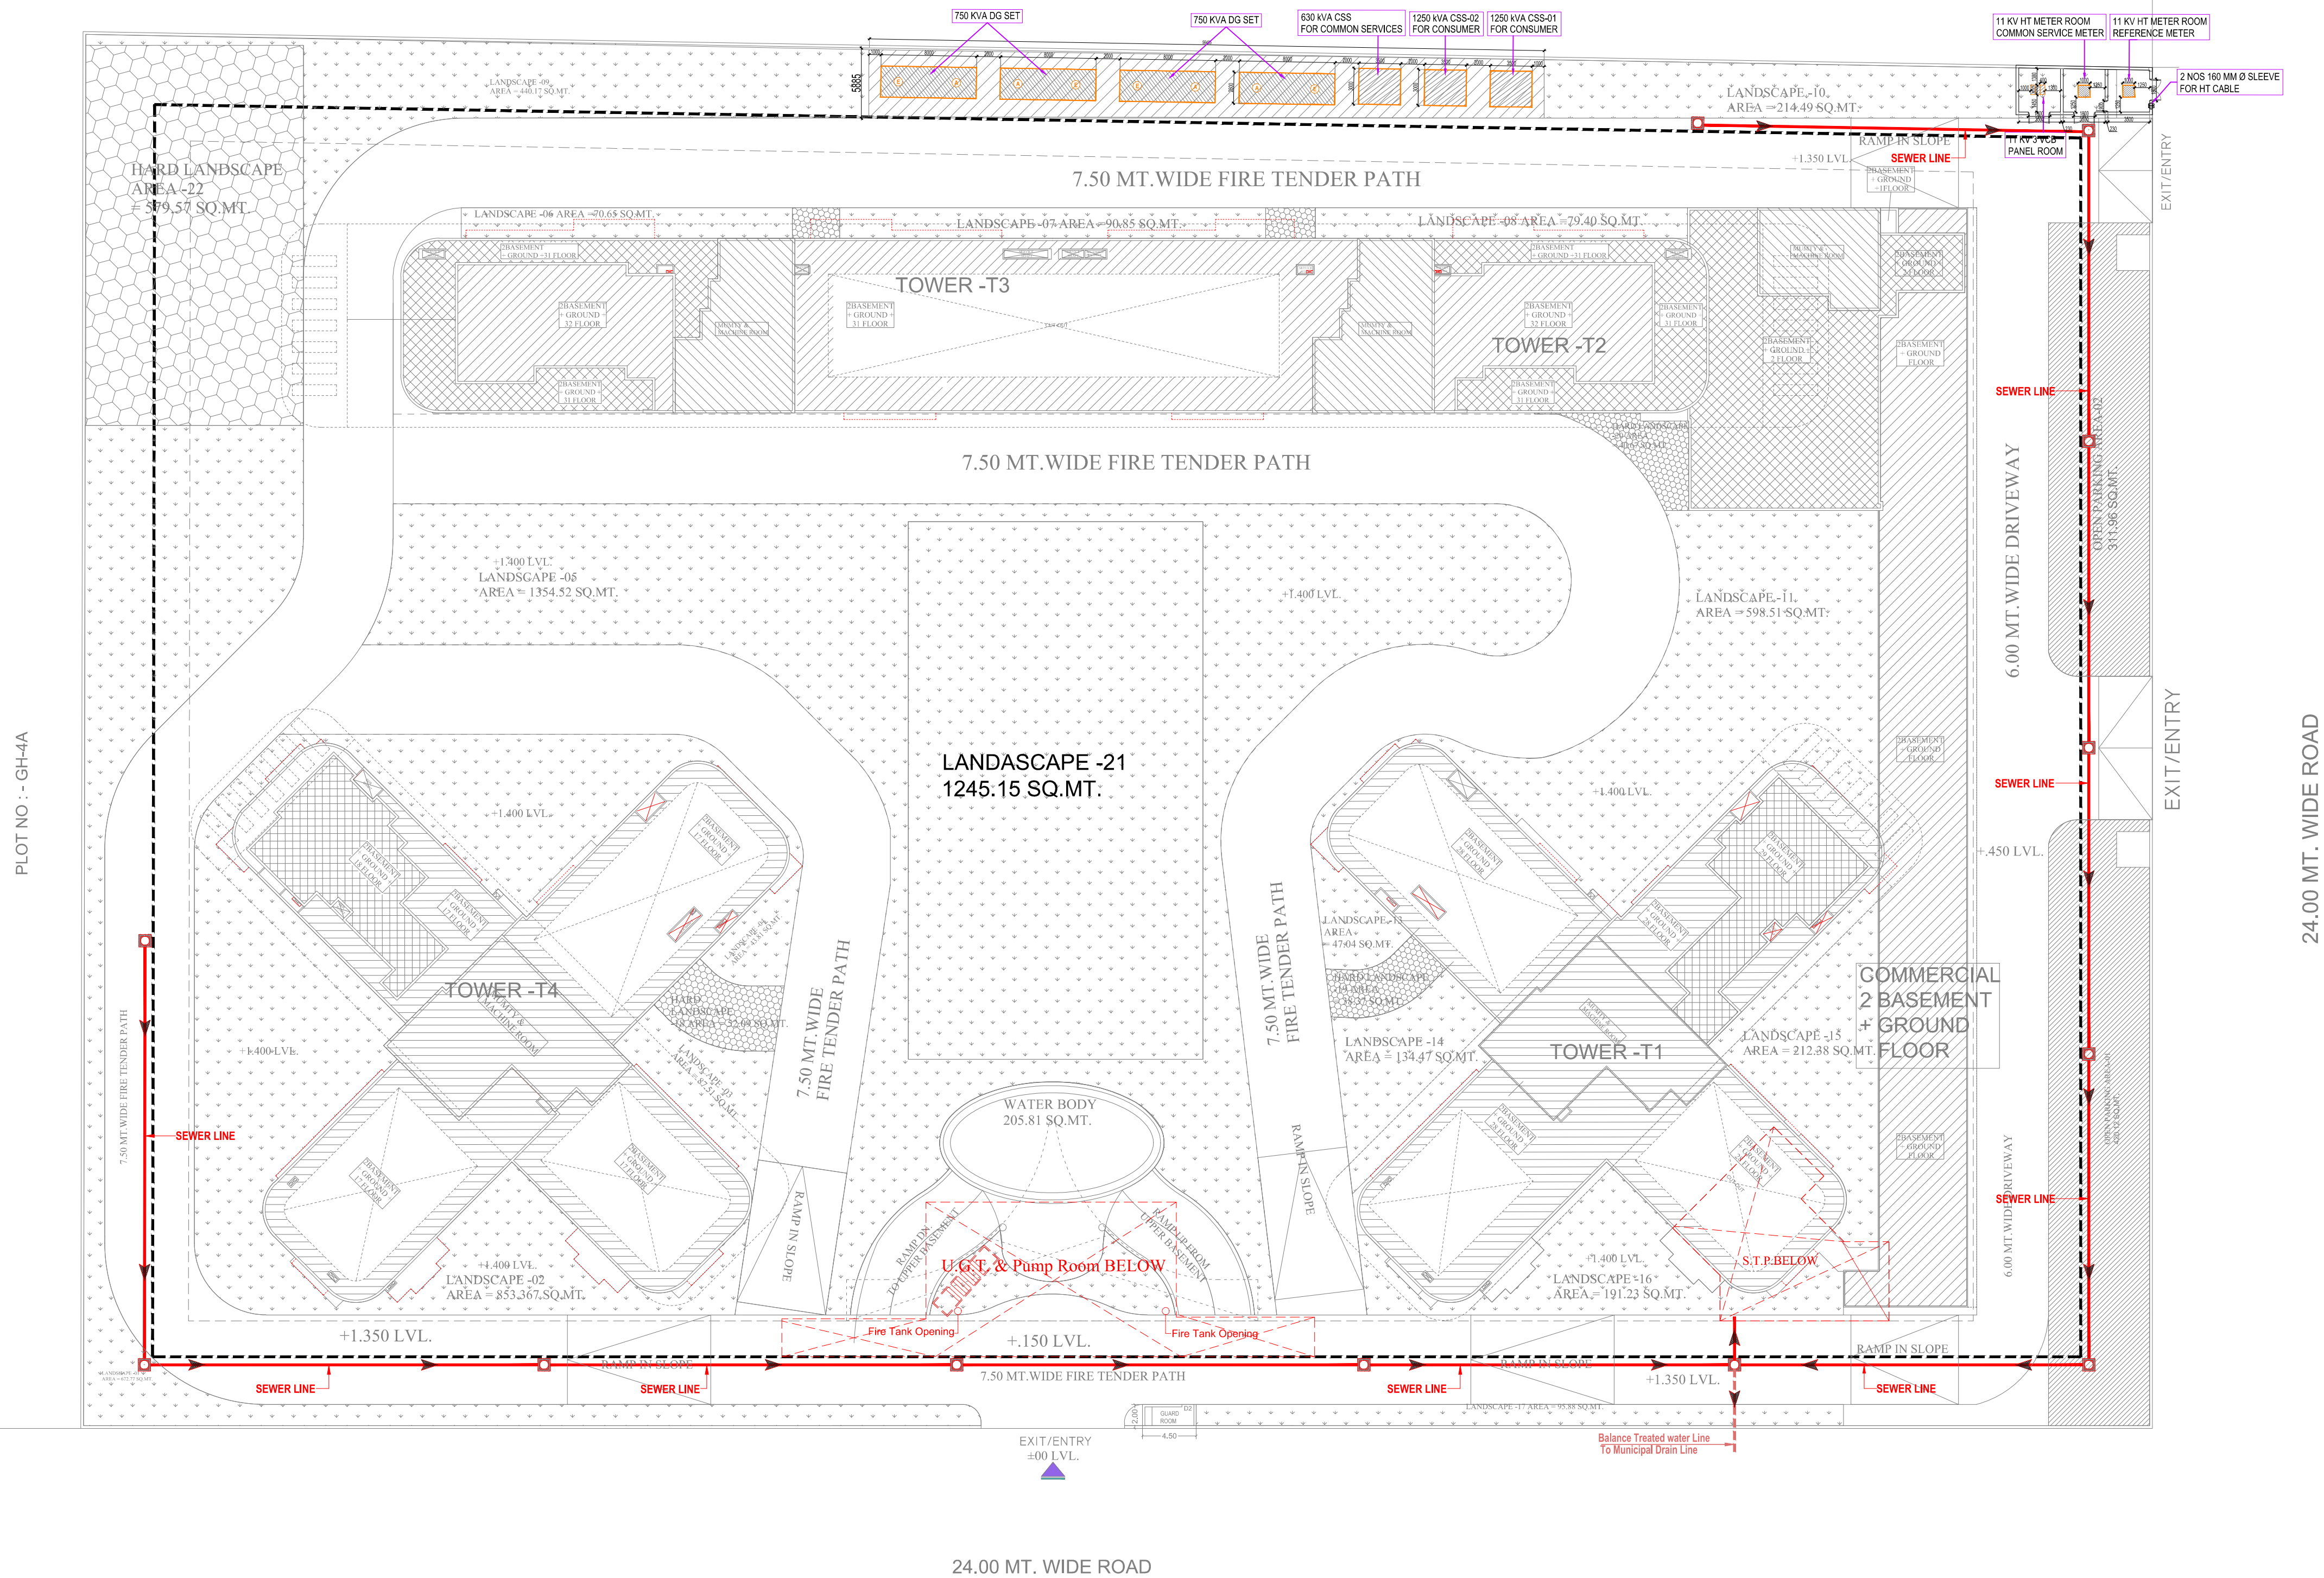

LEGEND :		
S. No.	SYMBOL	DESCRIPTION
1.	M.H. □	MANHOLE
2.	—■—	SEWER LINE
3.	- - -■ - - -	BYPASS SEWER LINE
4.	- - - - -	BASEMENT LINE

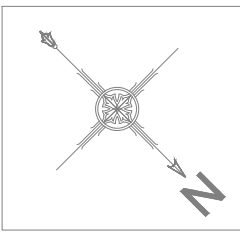

Rev. no.	Date	Revision
..	..	..

Project
PROPOSED GROUP HOUSING
AT PLOT No. GH-03A, SECTOR-12,
GREATER NOIDA

Title
SITE PLAN.

Subtitle
EXTERNAL SEWERAGE SERVICES

Drawing released for
☐ APPROVAL ☒ SUBMISSION
☐ ADVANCE COPY ☐ CONSTRUCTION

Drg. no. VVIP WHITE / EX / S-01 Drawn by Kulwant

Scale 1 : 350 Designed by R.K.

Date May 2024 Checked by Anand Havella

Architects
ARCHITECTS:
Space Designers International
B - 34, SECTOR-67, NOIDA
PIN: 201304 (INDIA) TEL: 91-11-63271118
E-MAIL: info@spacedi.com, www.spacedi.com

Services Consultant
cespl Consultants Pvt. Ltd.
B - 67, Sector - 67, Noida - 201 301
Tel : (0120) 3225400 / 3225401
e mail : mail@cespl.in, website : www.cespl.in