


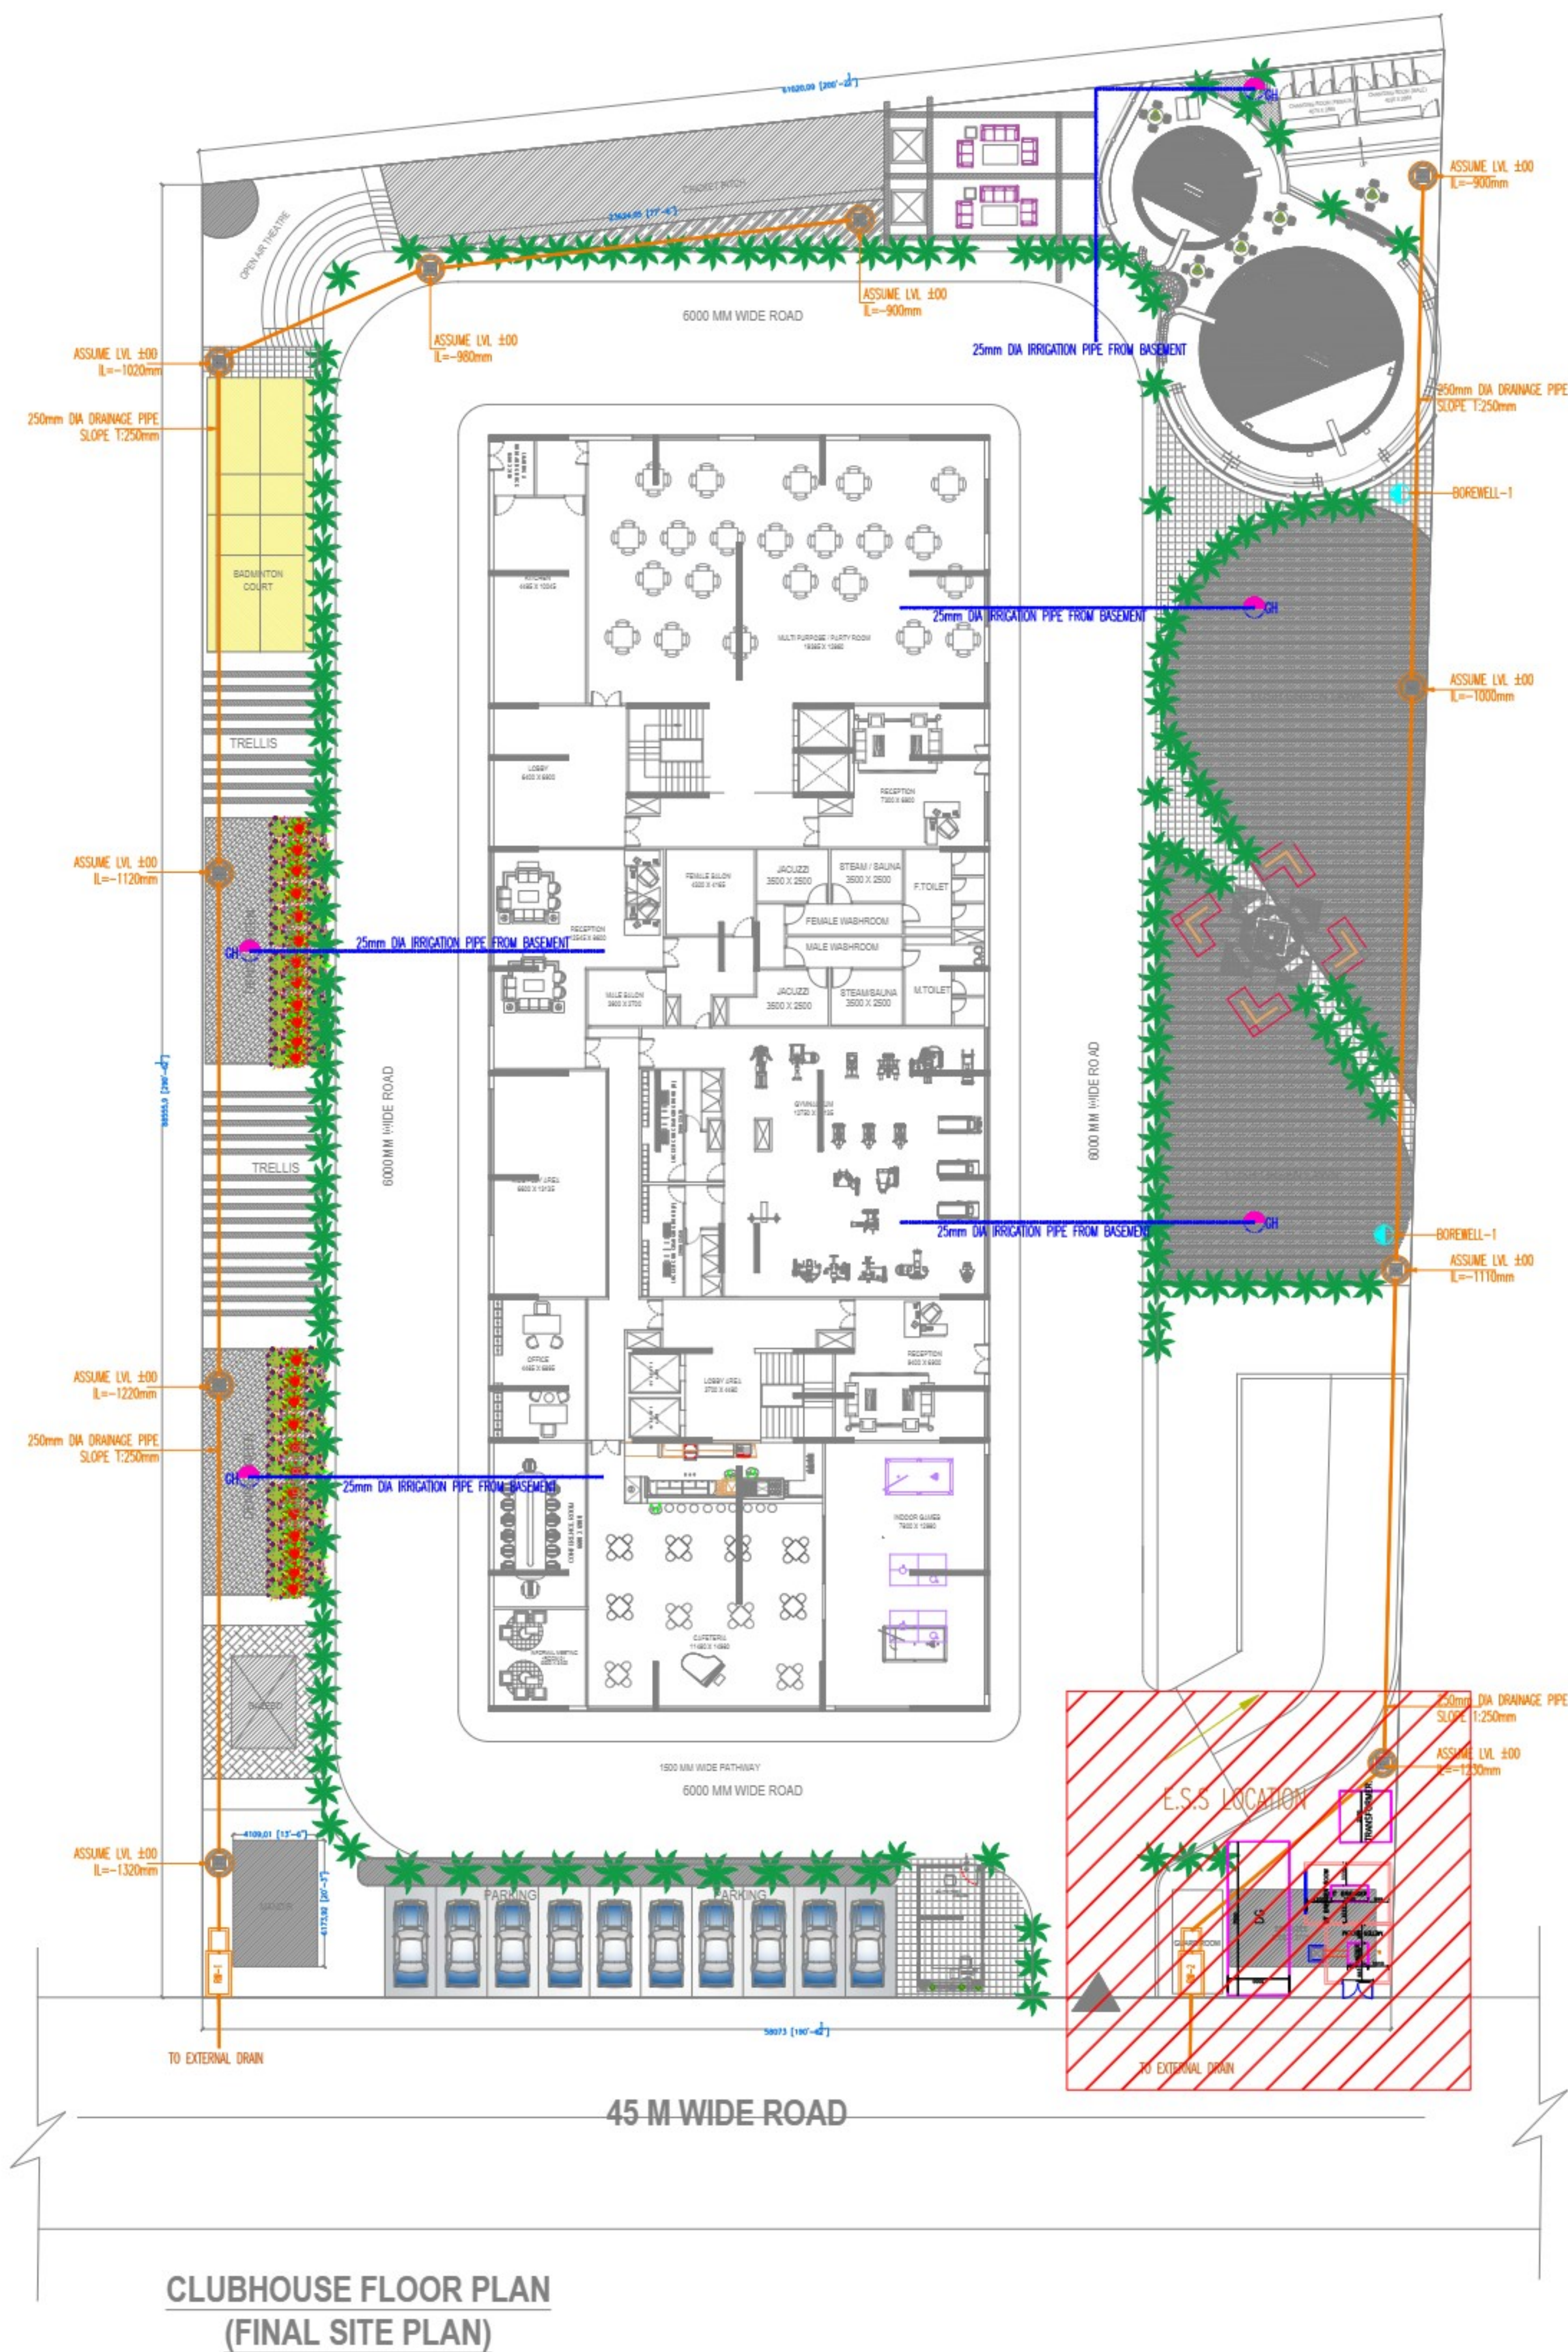


LEGENDS FOR SEWERAGE:-	
STP	SEWERAGE TREATMENT PLANT
→	SEWERAGE LINE

LEGENDS FOR DRAINAGE:-	
☐	RAIN WATER HARVESTING PIT
CB	MANHOLE FOR DRAINAGE
DMH	MANHOLE FOR DRAINAGE
→	DRAINAGE LINE

LEGENDS FOR WATER SUPPLY:-	
→	DOMESTIC WATER SUPPLY PIPE
→	FLUSHING WATER SUPPLY PIPE
GH	GARDEN HYDRANT

LEGENDS FOR ELECTRICAL:-	
HT BREAKER	HT BREAKER
DG	DIESEL GENERATOR
TRANSFORMER	TRANSFORMER

Rev. no.	Date
Project BABA HOUSHING	
Title	
Subtitle EXTERNAL SERVICES LAYOUT	
drawing released for ☐ APPROVAL ☒ SUBMISSION ☐ ADVANCE COPY ☐ CONSTRUCTION	
drg. no. PL. - 01	drawn by: KK
scale NTS	designed by: KK
date 14.01.2025	checked by: DK
Architects SINGLA ARCHITECTS & ASSOCIATES EROS MARKET PLACE, PLOT NO- 02, SHOP - 87 1ST. FLOOR SHAKTI KHAND - 2, INDIRAPURAM, GHAZIABAD (U.P.) Mob: 9971998445 e-mail : gsingla32@gmail.com,	
MEP Consultant:  WeDESIGN Associates "Engineered to perfection" Email - wedesignconsultancy@gmail.com Mob: - 9999288416, 9999288407, 9882244495	

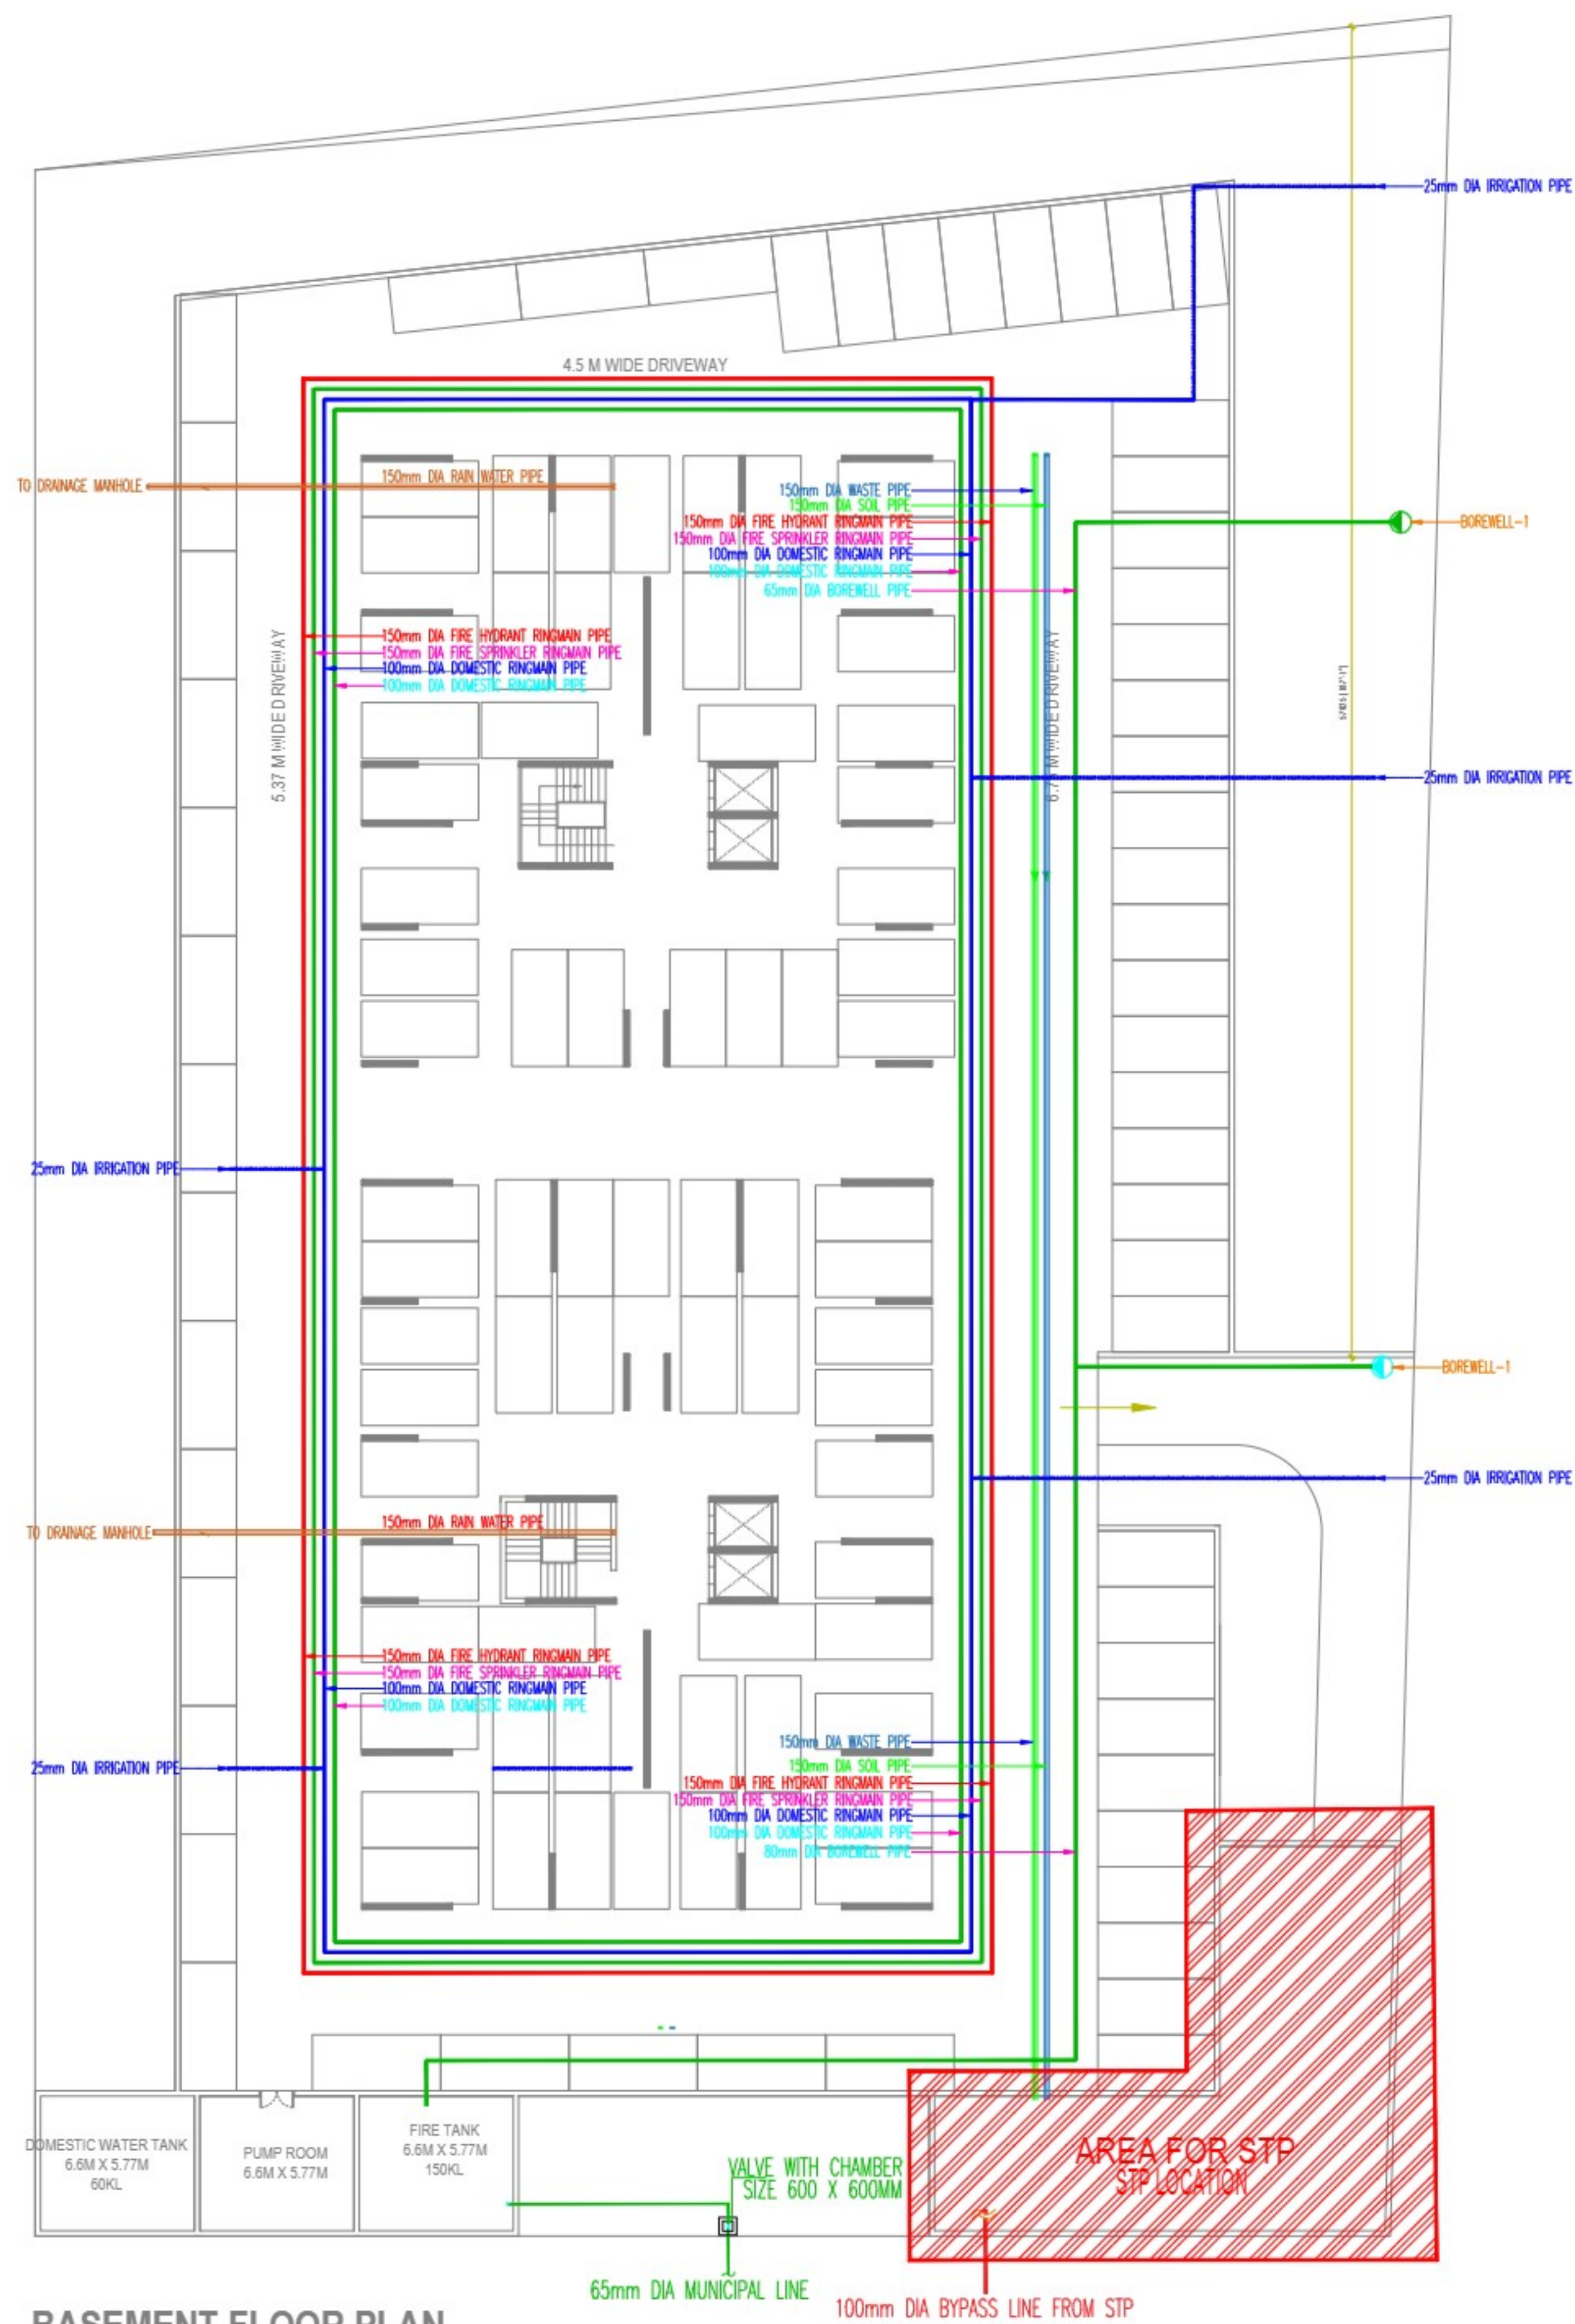

BASEMENT FLOOR PLAN

Rev. no.	Date
Project	
BABA HOUSHING	
Title	
Subtitle	
BASEMENT SERVICES LAYOUT	
drawing released for	
☐ APPROVAL	☒ SUBMISSION
☐ ADVANCE COPY	☐ CONSTRUCTION
drg. no.	PL. - 02
scale	NTS
date	14.01.2025
Architects	
SINGLA ARCHITECTS & ASSOCIATES	
EROS MARKET PLACE, PLOT NO- 02, SHOP - 87 1ST. FLOOR	
SHAKTI KHAND - 2, INDIRAPURAM, GHAZIABAD (U.P.)	
Mob: 9971998445	
e-mail : gsingla32@gmail.com,	
MEP Consultant:	
WeDESIGN Associates	
Engineered to perfection	
Email - weDesignconsultancy@gmail.com	
Mob. - 9999288416, 9999288407, 9882244495	