
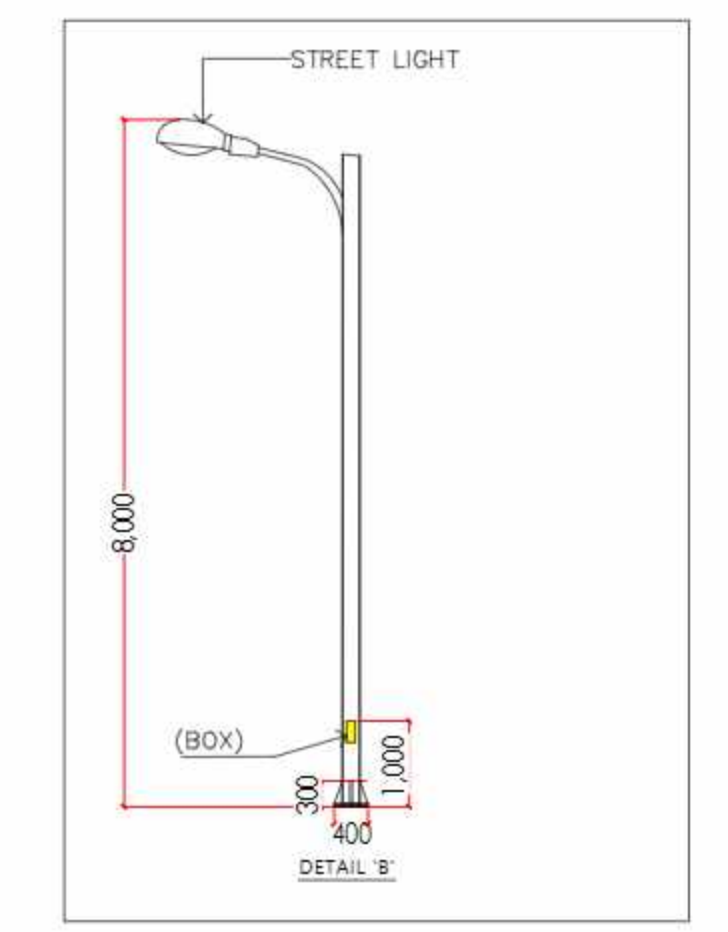
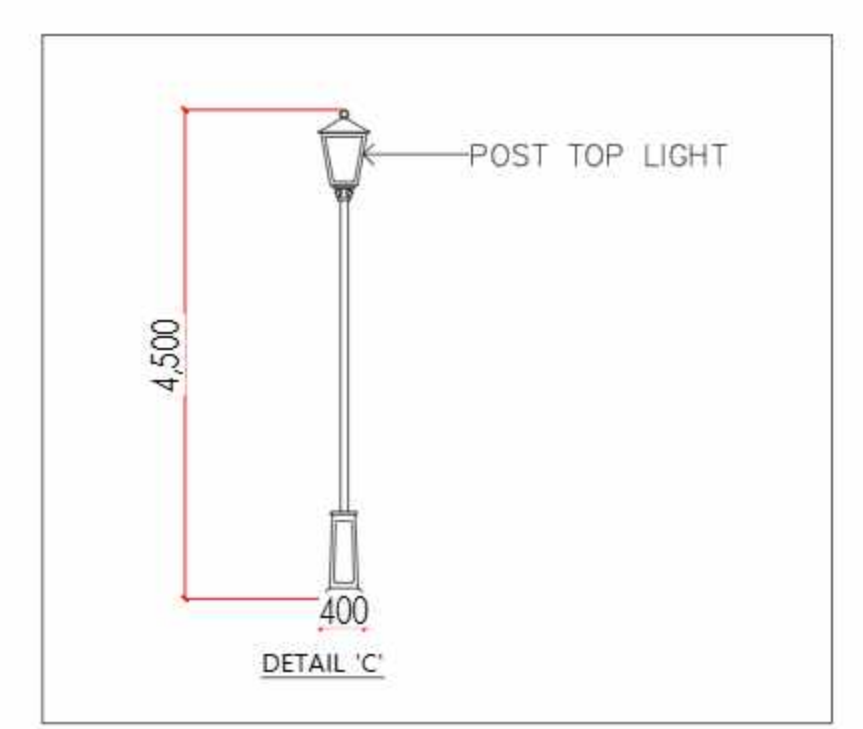


INTERNAL ROADS LIGHTING LEGEND :-

SR.NO.	SYMBOL	NAME
1.		STREET LIGHT (8M HIGH)
2.		POST TOP LIGHT (4.5 M HIGH)
3.		BOLLARD LIGHT (1M HIGH)
4.		FEEDER PILLAR

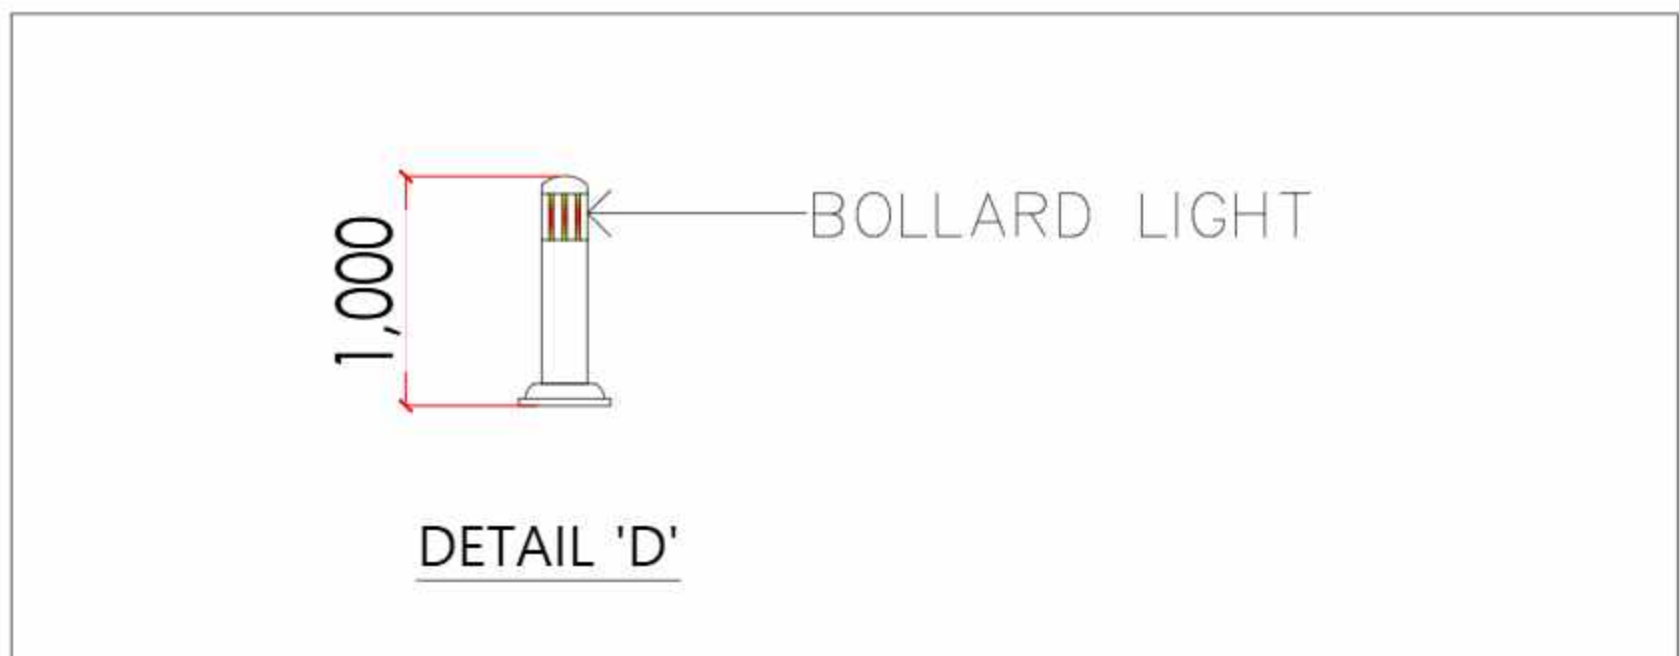

PROJECT TITLE  
**PROPOSED GROUP HOUSING :  
 THE ROYAL RETREAT**  
 AT : GH-07, Situated at Integrated Township -  
 Shalimar One World,Village Baghamau,Lucknow

KEYPLAN:

KHASRA NO:-  
 (PART OF KHASRA NO.)  
 309P,361,368P,370P,371P,653P,647P & 632P

**SUBMISSION DRAWING**

DRAWING TITLE  
**SITE PLAN  
 EXTERNAL LIGHTING LAYOUT  
 ELECTRICAL LAYOUT**

SCALE 1:200@ 1200x600 DATE 28-07-2025

DRAWN SANDHEP CHECKED SUBRATA

PAPER ISSUED

CLIENT & DEVELOPER  
 M/S. Z.M. ENTERPRISES Pvt. Ltd.  
 3rd Floor, 38/ 22, Payagpur Towers, Mira Bai Marg  
 Hazratganj, Lucknow - 226001 (u.p.)

DESIGN ARCHITECT:  
  
**SIKKA ASSOCIATES ARCHITECTS**

PLUMBING & FIRE:  
  
**SIKKA ASSOCIATES ARCHITECTS**

OWNER SIGNATURE ARCHITECT SIGNATURE

D.NO. KSMB/EL/SUB-01 S NO. 01