
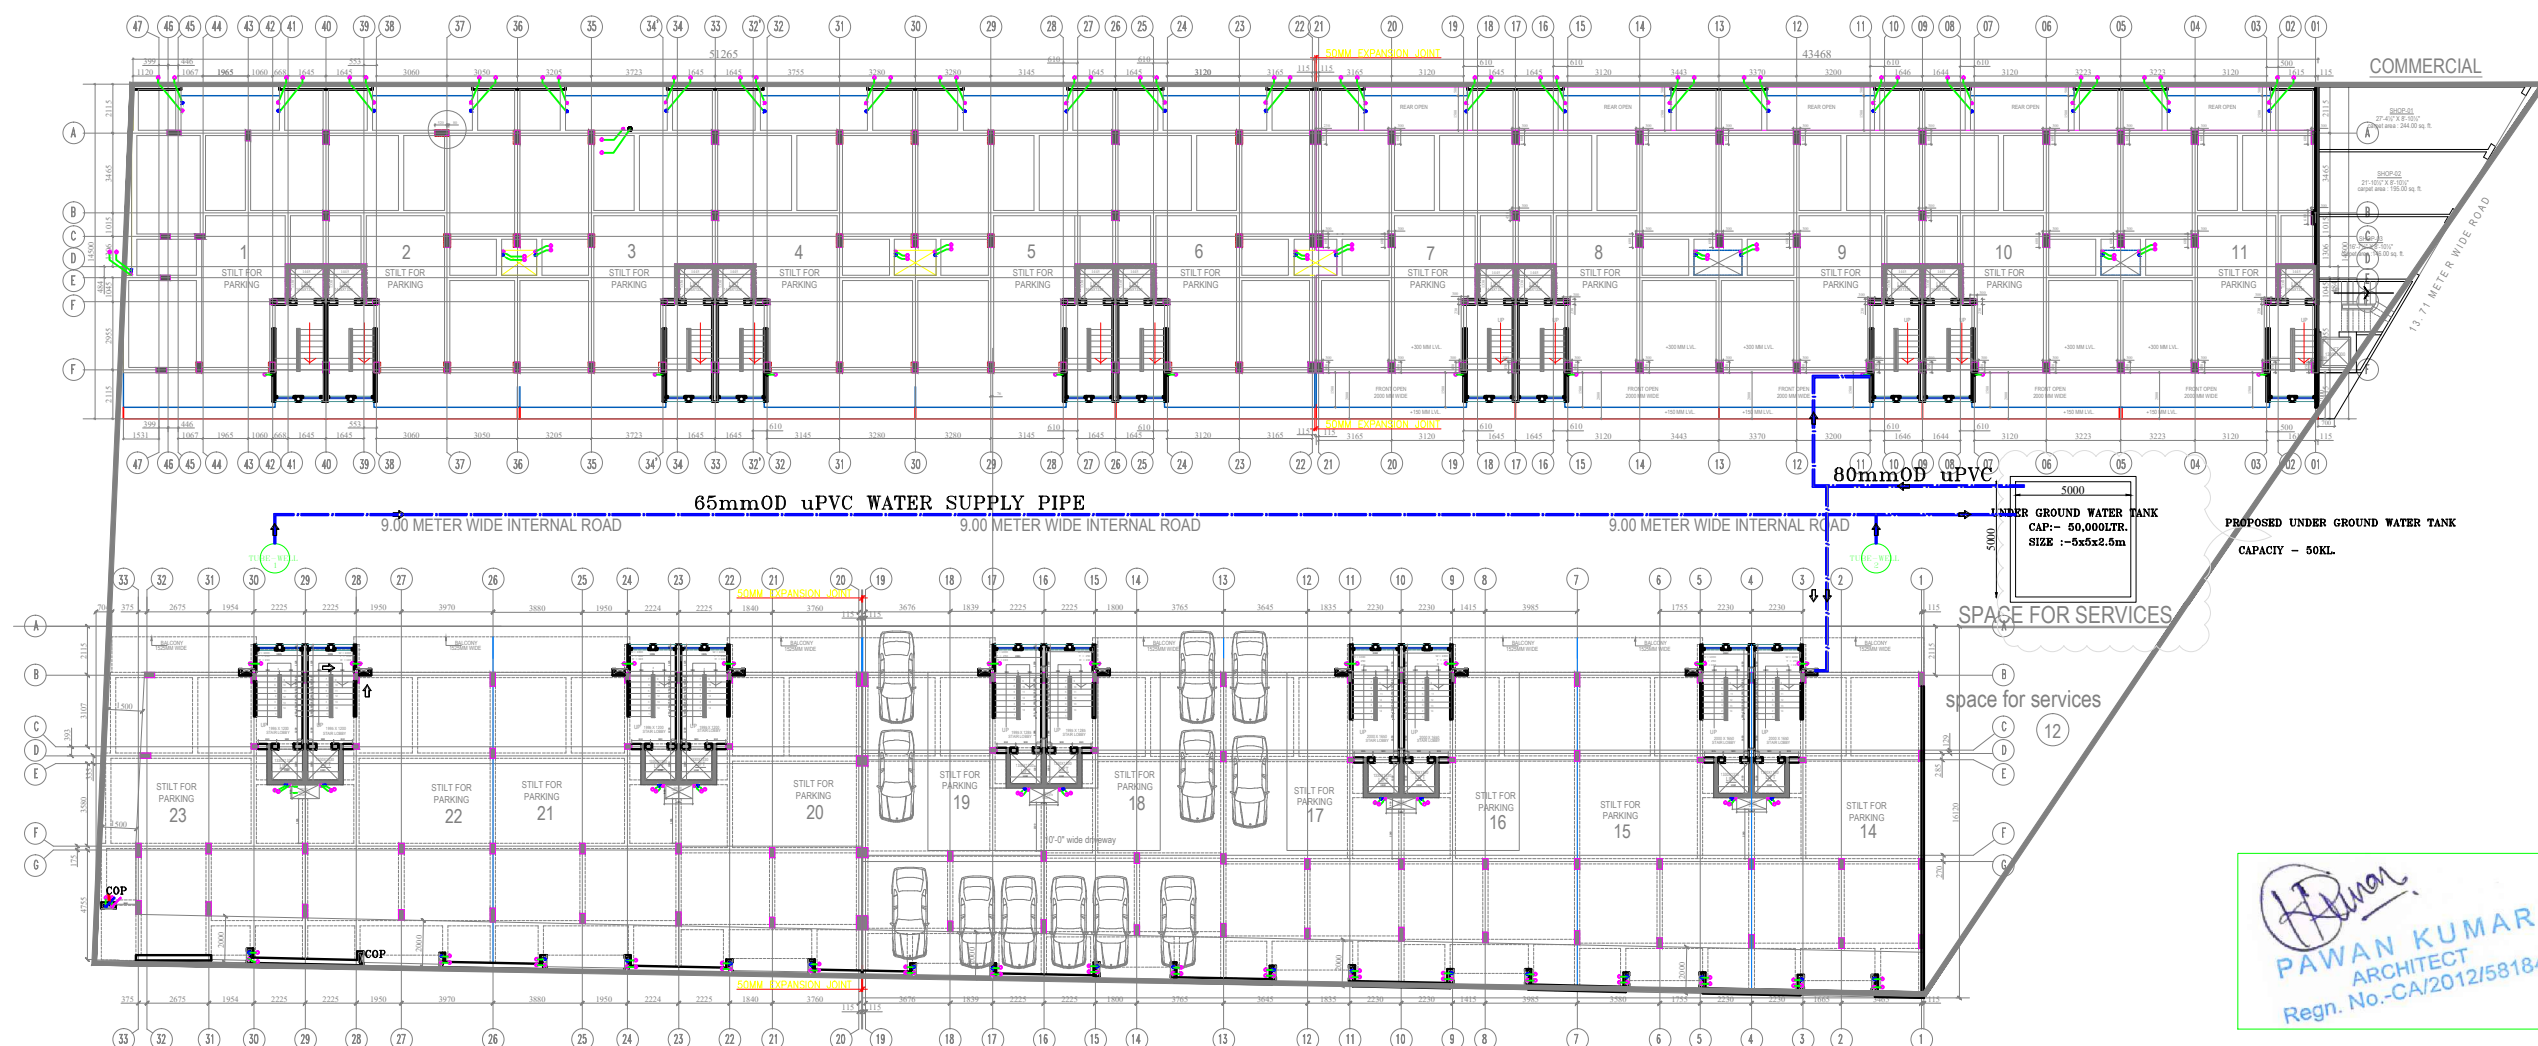


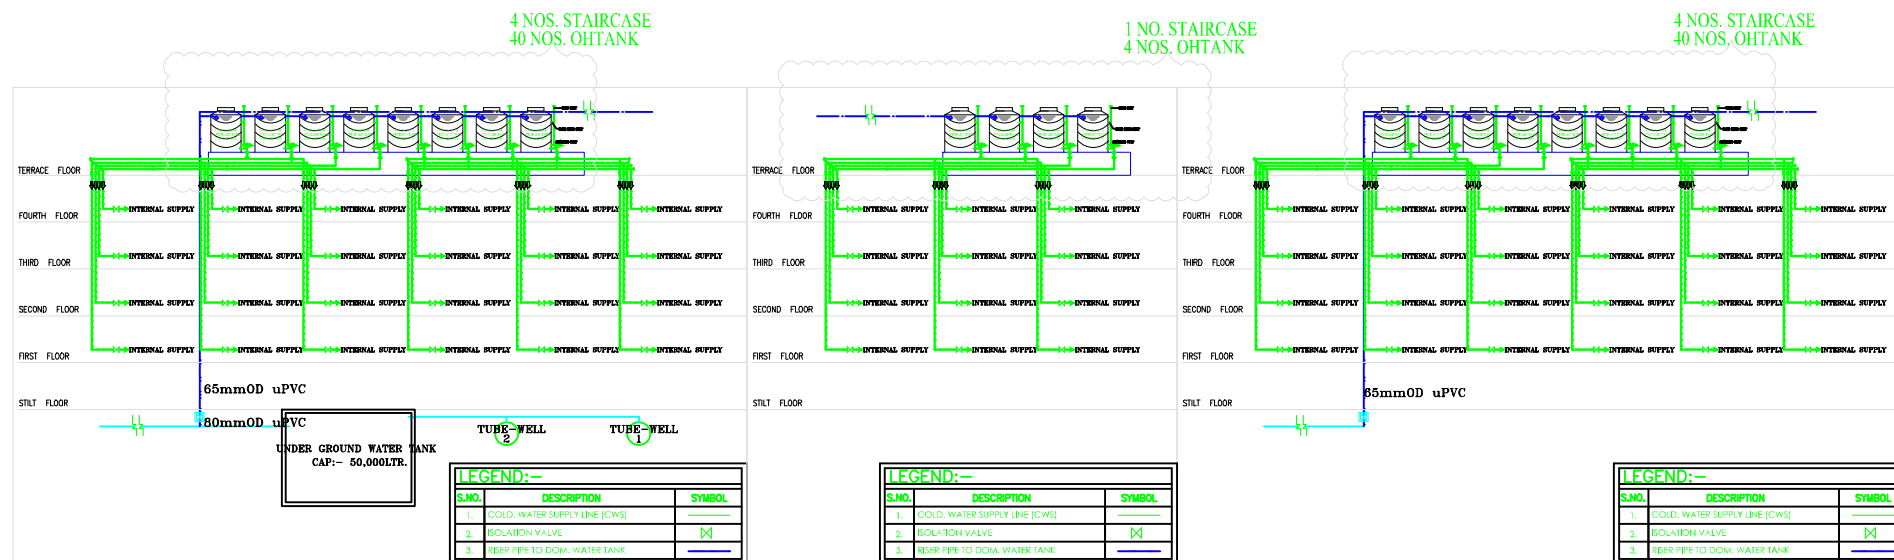

*Pawan Kumar*  
PAWAN KUMAR  
ARCHITECT  
Regn. No.-CA/2012/58184

STILT FLOOR PLAN

| Rev. No. | Date | Revision |
|----------|------|----------|
| ..       | ..   | ..       |

Project :  
PROPOSED ROW HOUSING AT  
"ROYCE VAISHALI"  
PLOT NO.18B,SECTOR-3,  
VAISHALI, GHAZIABAD

Title :  
WORKING DRG. WATER SUPPLY

Subtitle :  
WORKING DRG.  
STILT FLOOR PLAN

Drawing Released For :  
☒ APPROVAL ☐ SUBMISSION  
☐ ADVANCE COPY ☐ CONSTRUCTION

Drg. No :  
WD. S.P. -01

Scale :

Date : 24th Apr. 2019

Ckd By :

Drawn By : Deepak

Design By : Dushyant Kumar

Pawan Kumar

Architects :  
D+P ASSOCIATES  
DESIGNERS & PLANNERS  
architects,engineers,interior designers,landscape & vastu consult.  
L-11, HIMALAYA LEGAND, F.F., NYAY KHAND-1,  
INDIRAPURAM, GHAZIABAD Mobile: 98 10888916 , 9873326241  
Email Id: dpassociates2015@gmail.com, dparchitects2015@gmail.com

