

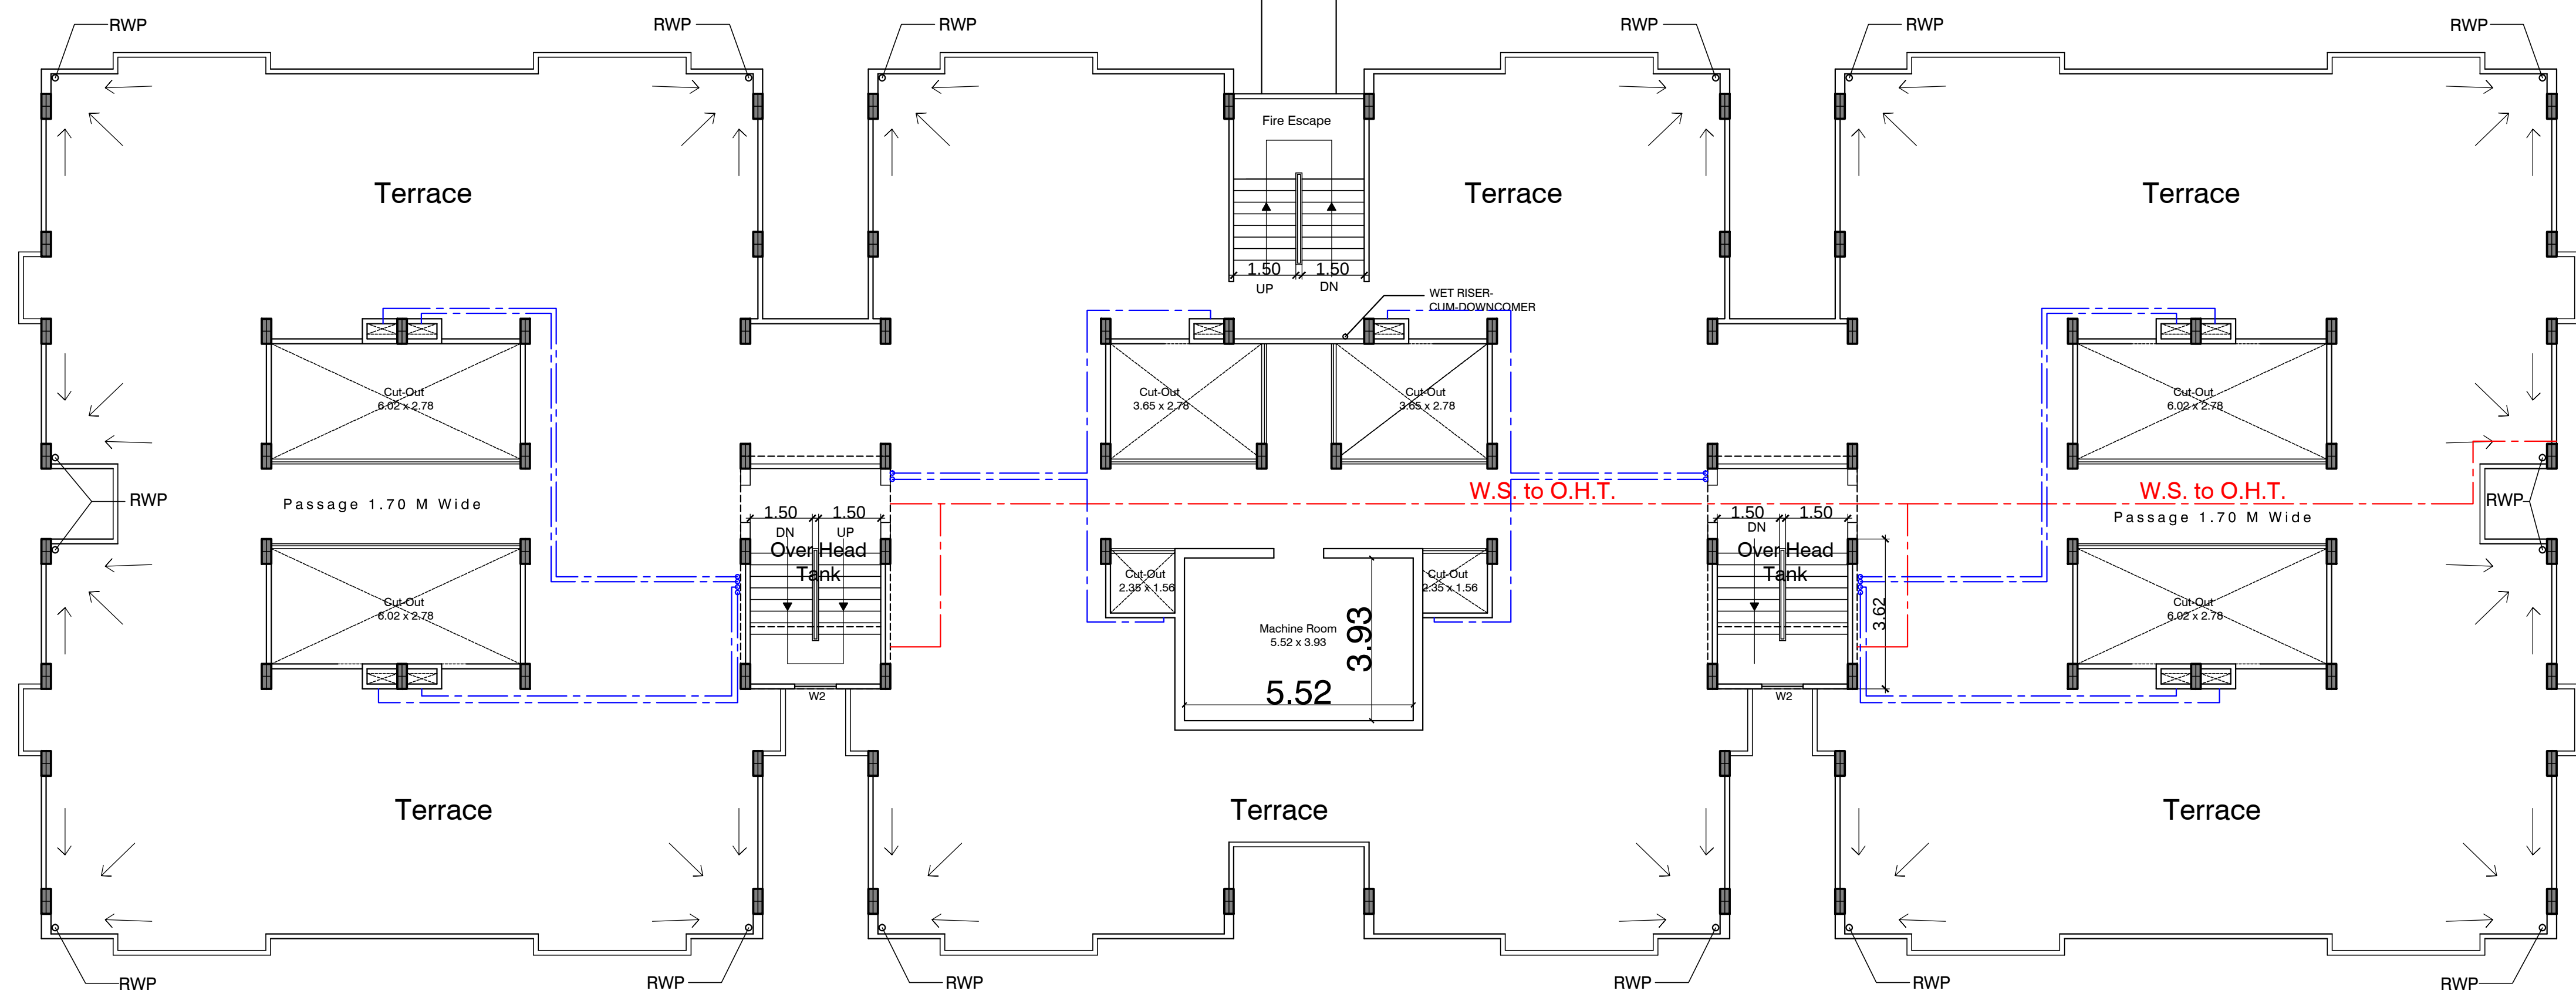


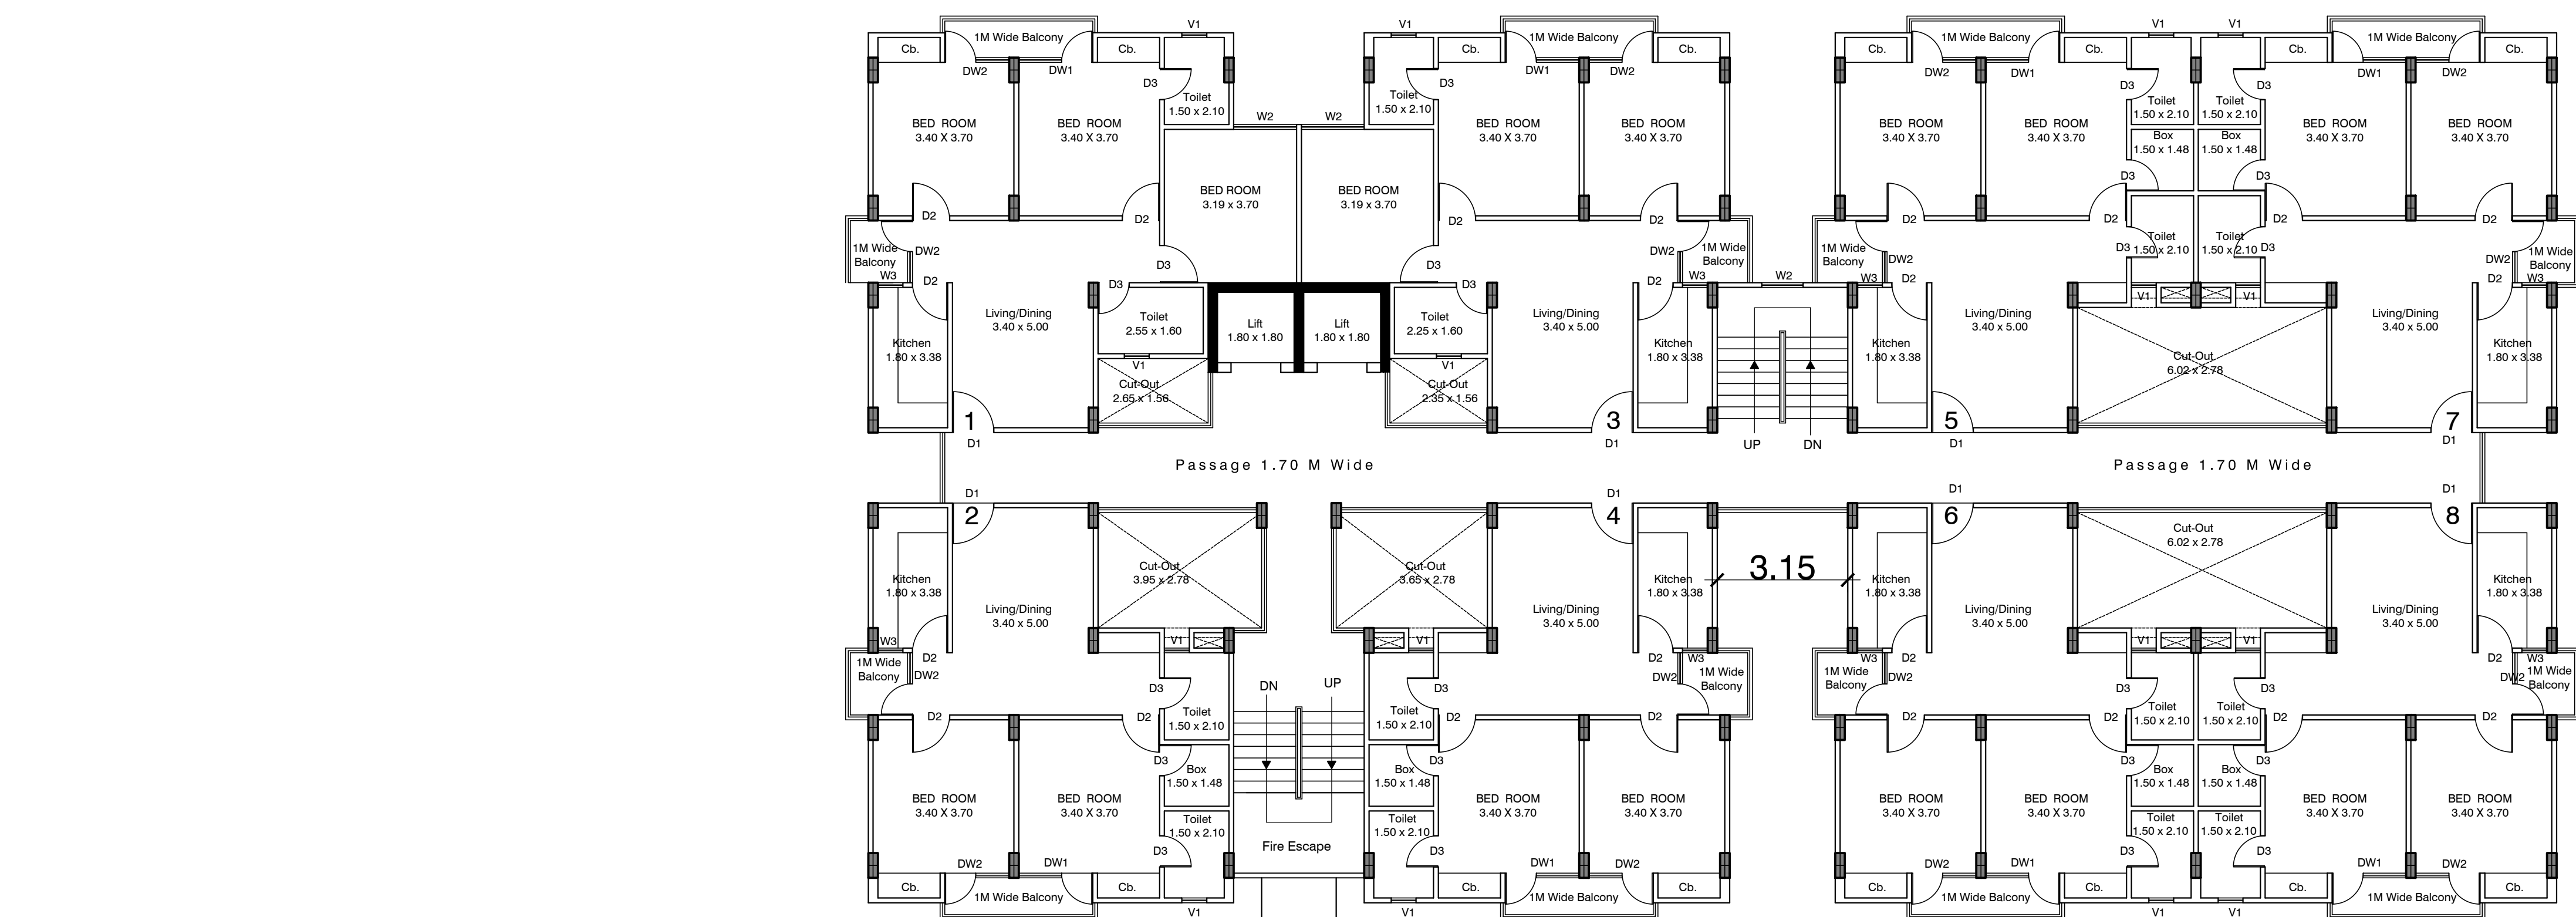


9th. FLOOR

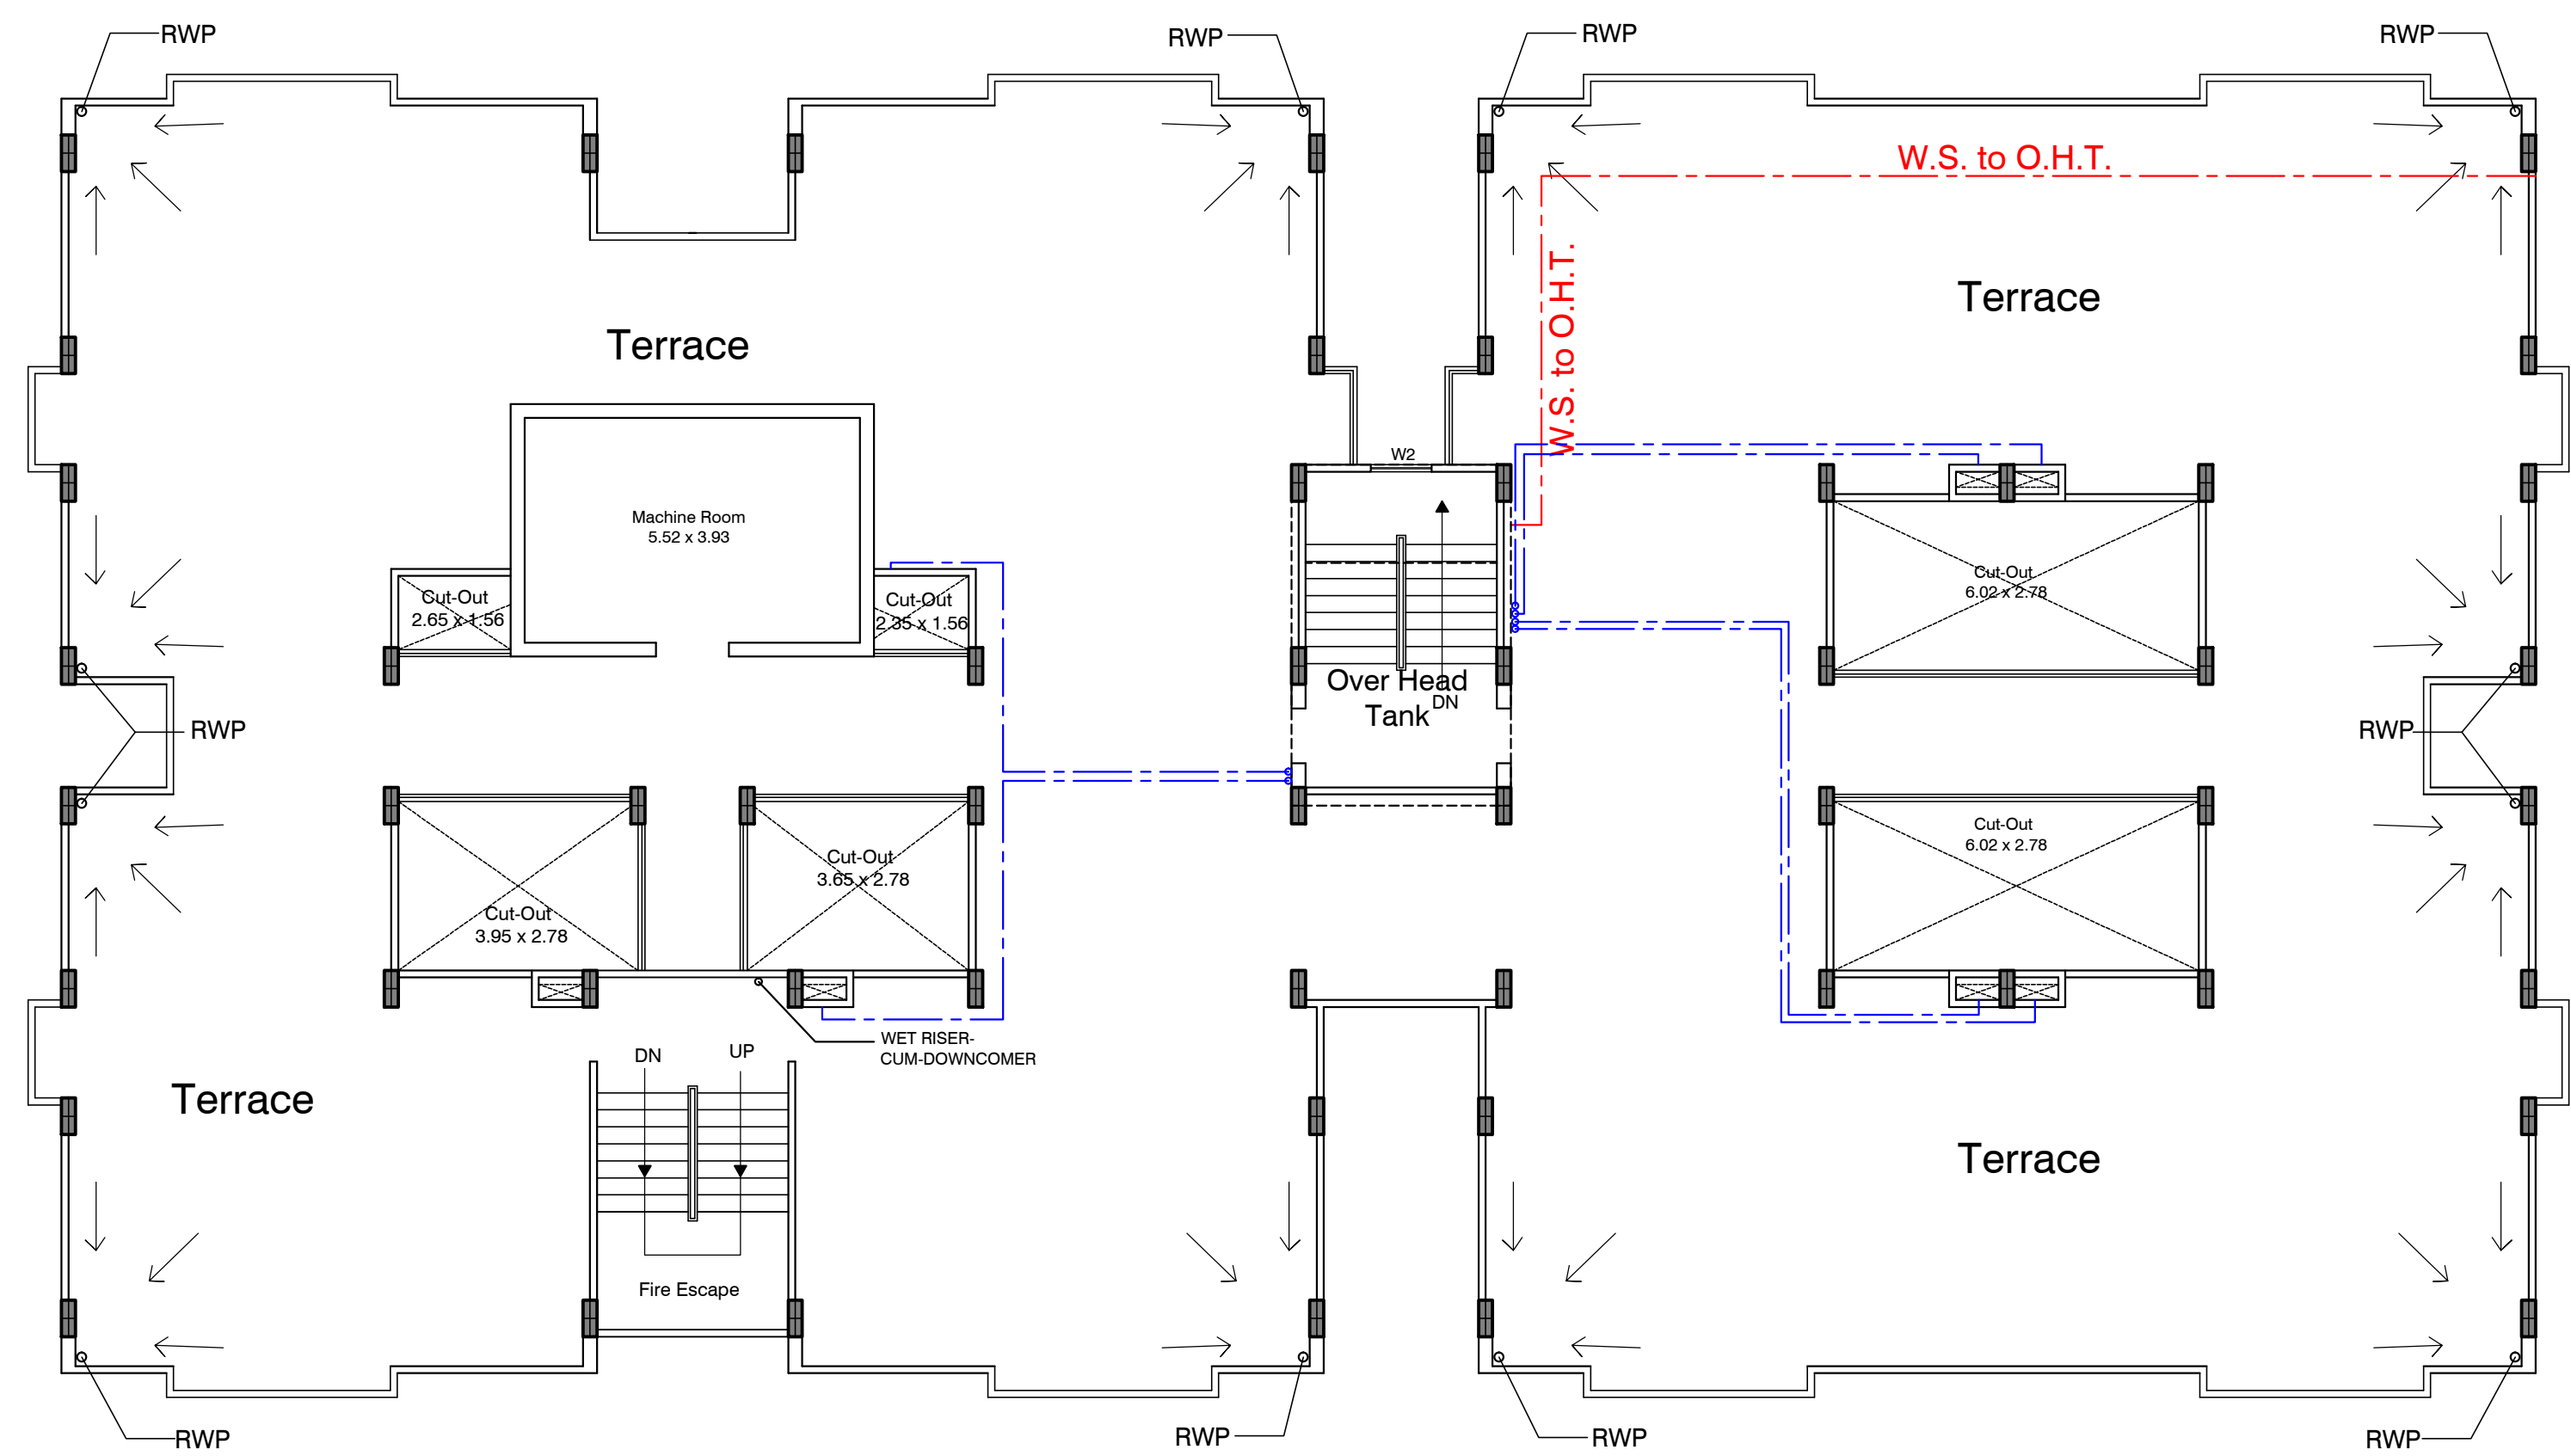

TERRACE FLOOR

Note - All Rain Water Pipe (RWP) Should be Given For Under Ground Rain Water Harvesting

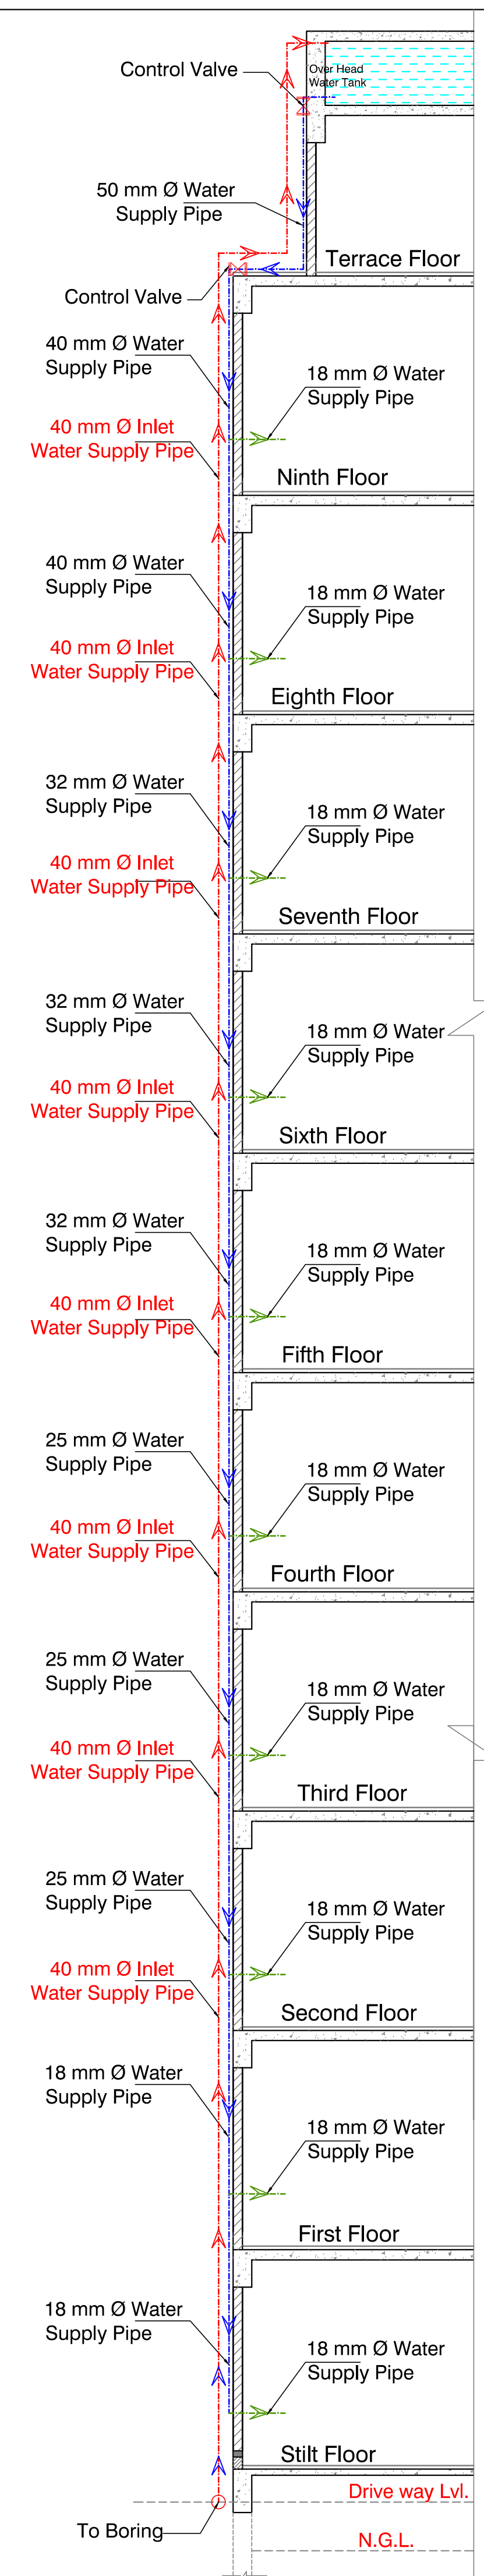

Typical Section

PROPOSED RESIDENTIAL APARTMENT
BUILDING PLAN ON PLOT NO. 381,382
VILLAGE-TATIYA JHANAKU
DIST. - KANPUR NAGAR (UP)

OWNED BY :
Shri Kamal Nath Mehrotra S/O
Late Amarnath Mehrotra Through
Attorney Shri Shyam Nath
Mehrotra
R/C 1/1 (2) Krishna Nagar,
Dist. - Kanpur Nagar (UP)


OWNER'S SIGN :

ENGINEER'S SIGN/ ARCHITECT'S SIGN

PAVAN & ASSOCIATE
HIG 21, Mukharji Vihar Indra Nagar Kanpur 208024
Phone No. 08090823823

Scale - 1:100

DRW. No. - 2/2

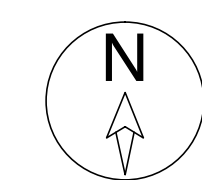

North

Drawing Title - Plumbing Plan