


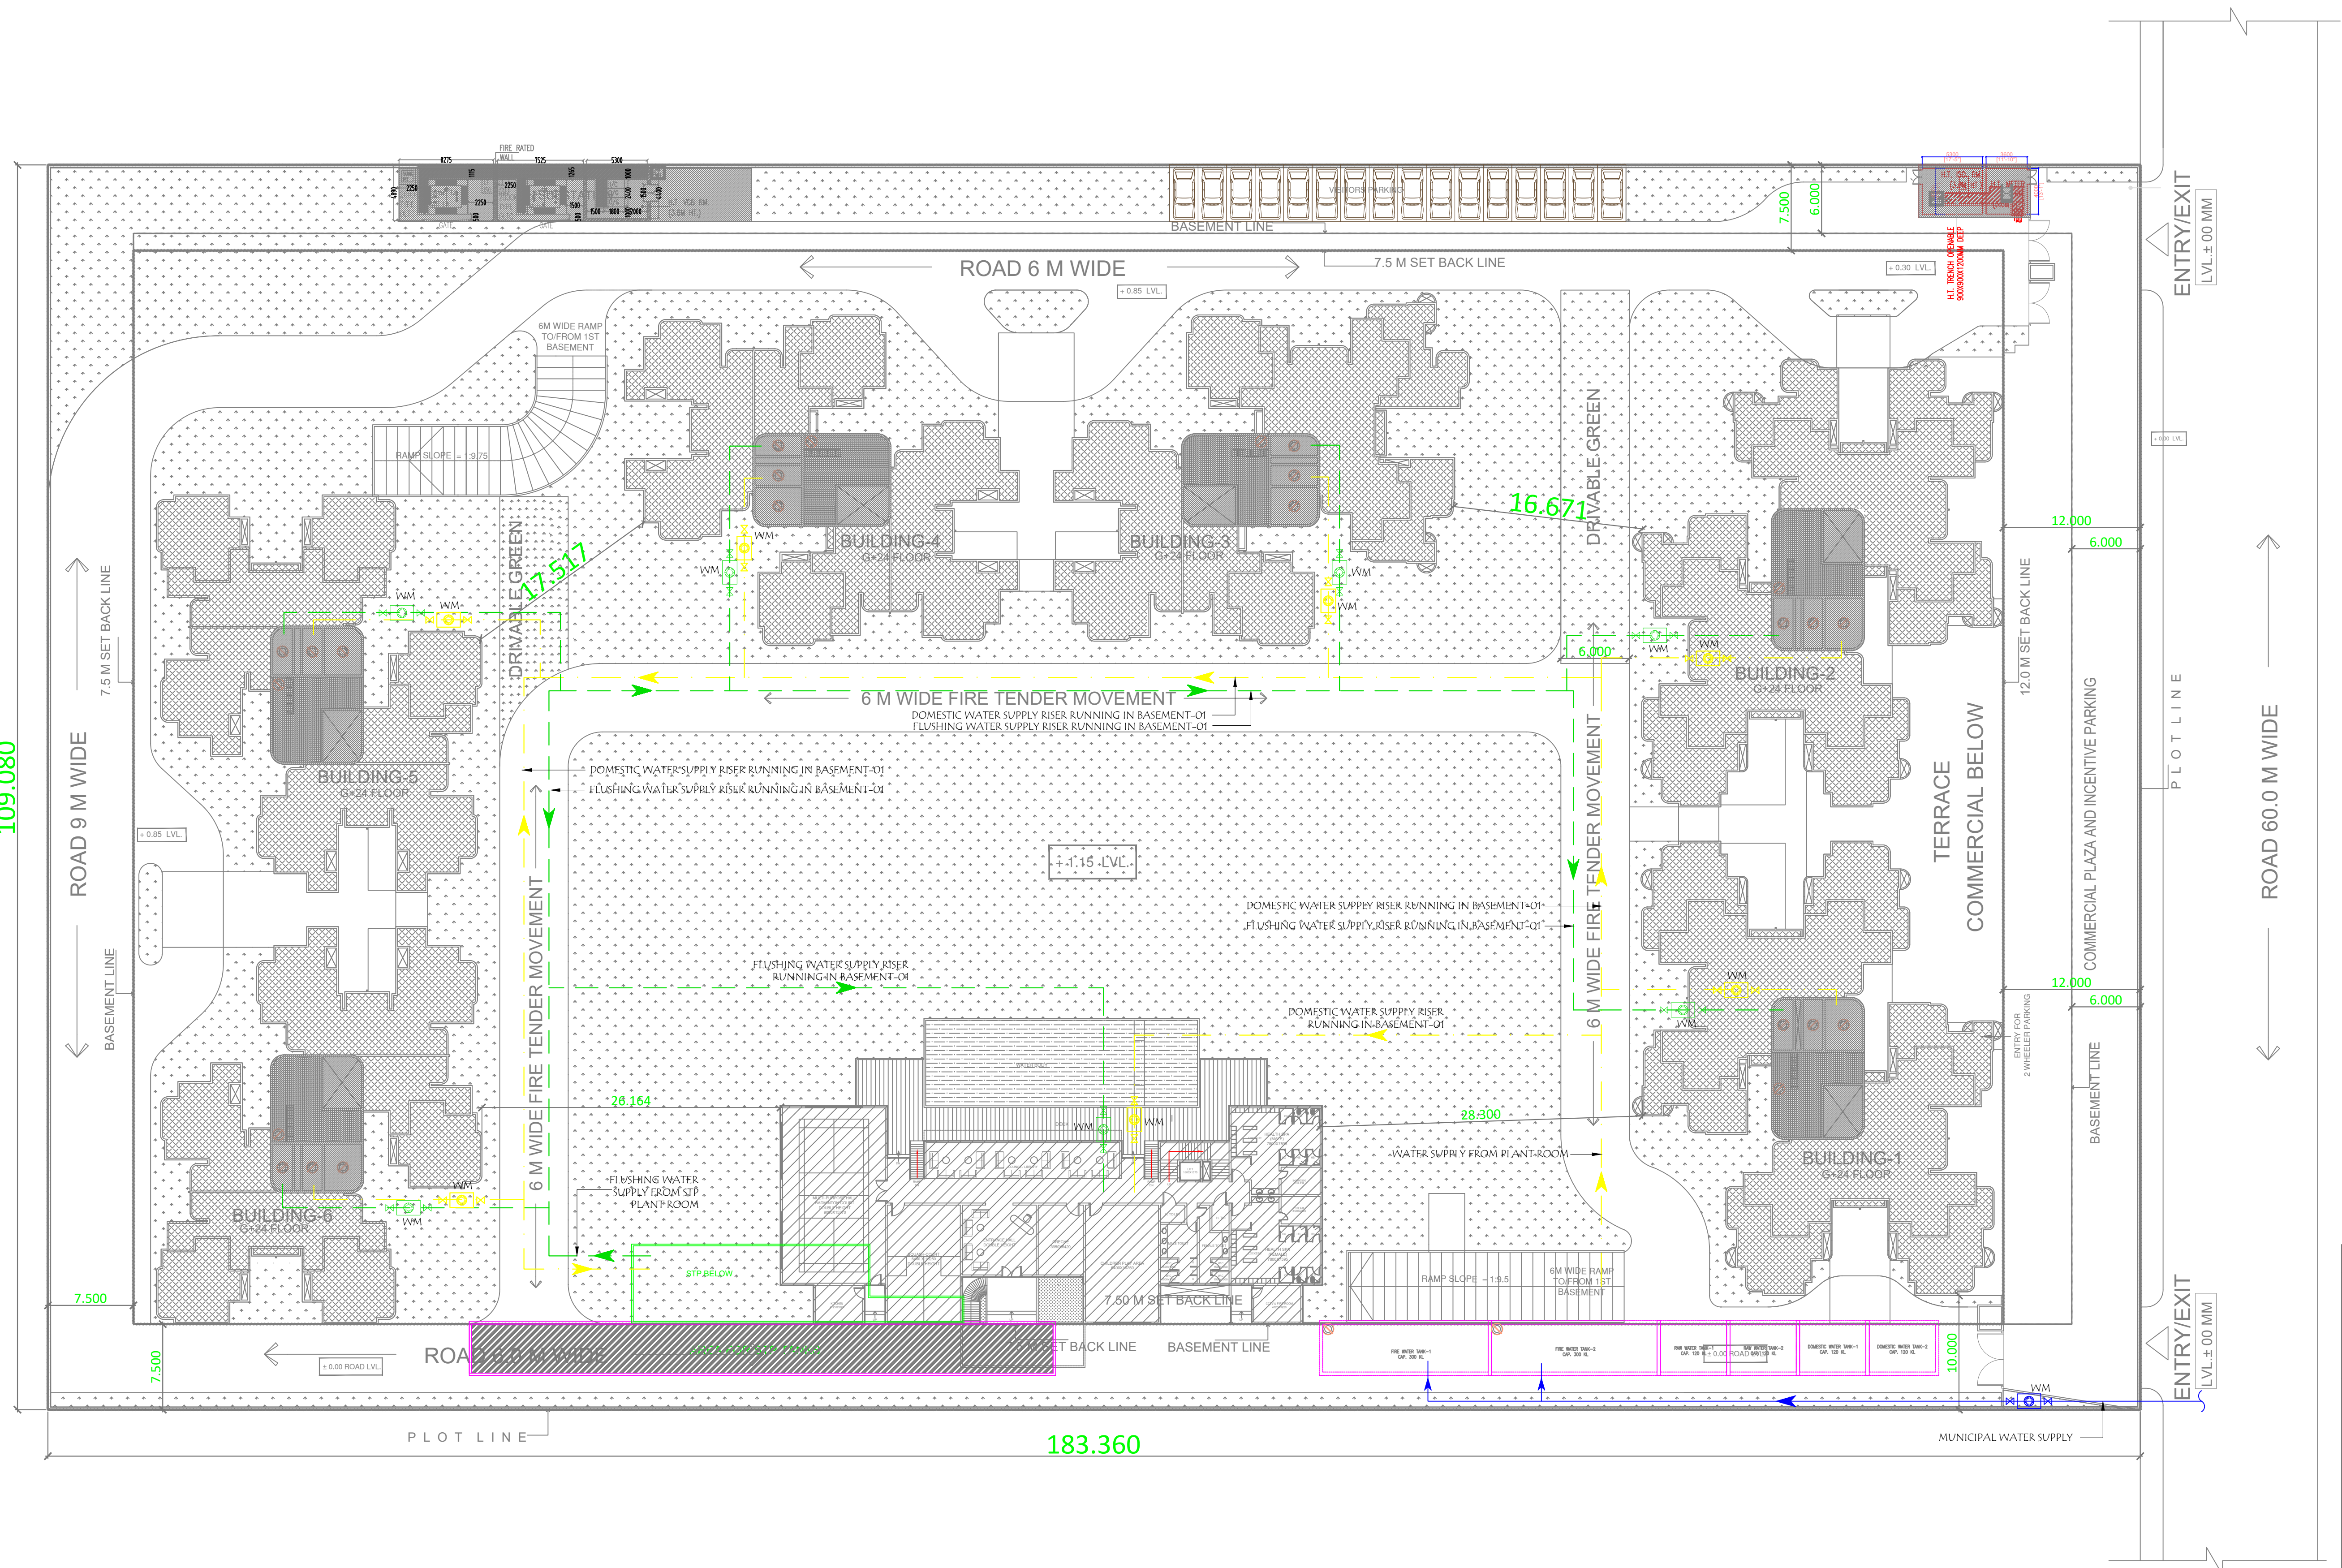

DESCRIPTION	SYMBOL
MUNICIPAL WATER SUPPLY PIPE	
DOMESTIC WATER SUPPLY PIPE	
FLUSHING WATER SUPPLY PIPE	
WATER METER	W.M.

SUBMISSION DRAWING	
PROJECT : PROPOSED GROUP HOUSING AT PLOT NO GH 11A , SECTOR 1 , GREATER NOIDA	
CLIENT : ENTICEMENT INFRASTRUCTURE PVT.LTD.	
SHEET TITLE : SITE PLAN WATER SUPPLY LAYOUT	
DATE : 04.01.2018	DRG.NO : PL-WS-01
SCALE : 1:300	NORTH : 
OWNER'S SIGN	ARCHITECT'S SIGN
ARCHITECTS: SPACE DESIGN GROUP W-139, GREATER KAILASH-I, NEW DELHI -48 PH: +91 - 11-29240732 , +91-11- 41631265 EMAIL : spacedesigngroup@rediffmail.com	