

P/O OTHER'S

PLUMBING NOTES:-

1. WASH BASIN TO MULTI TRAP (MT) 40 00 uPVC
2. MULTI FLOOR TRAP (MT) TO FLOOR TRAP (FT) 50 00 uPVC WASTE PIPE.
3. FLOOR TRAP (FT) TO VERTICAL PIPE 110 00 uPVC
4. 110 00 uPVC PIPE USED FOR SOIL & WASTE.
5. 110 00 uPVC PIPE USED FOR TERRACE RAIN WATER

SYMBOLS OF PIPES


SYMBOL	DESCRIPTION
①	110 00 uPVC SOIL PIPE
②	110 00 uPVC WASTE PIPE
③	110 00 uPVC RAIN WATER PIPE FOR TERRACE
④	DOMESTIC WATER SUPPLY D/N TAKE PIPE FOR BELOW FLOORS *
⑤	DOMESTIC WATER SUPPLY D/N TAKE PIPE FOR TOP THREE FLOOR
⑥	DOMESTIC WATER SUPPLY RISER PIPE *
⑦	90 00 uPVC RAIN WATER PIPE FOR BALCONY
⑧	75# ANTISIPHONAGE PIPE (VENT PIPE FOR WC)

MANHOLE & CATCH BASIN SCHEDULE

SYMBOL	DESCRIPTION
MB	RAIN WATER CATCH BASIN (1'-0"X1'-0") UP TO 2'-0" DEPTH
MB	RAIN WATER CATCH BASIN (2'-0"X2'-0") UP TO 2'-0" DEPTH
MB	SEWER CHAMBER (2'-0"X2'-0")
MB	DULLY TRAP (1'-0"X1'-0")

LEGEND

- EXTERNAL STORM WATER LINE
- EXTERNAL SEWER LINE
- WATER SUPPLY RISER PIPE
- MUNICIPAL WATER SUPPLY CONNECTION

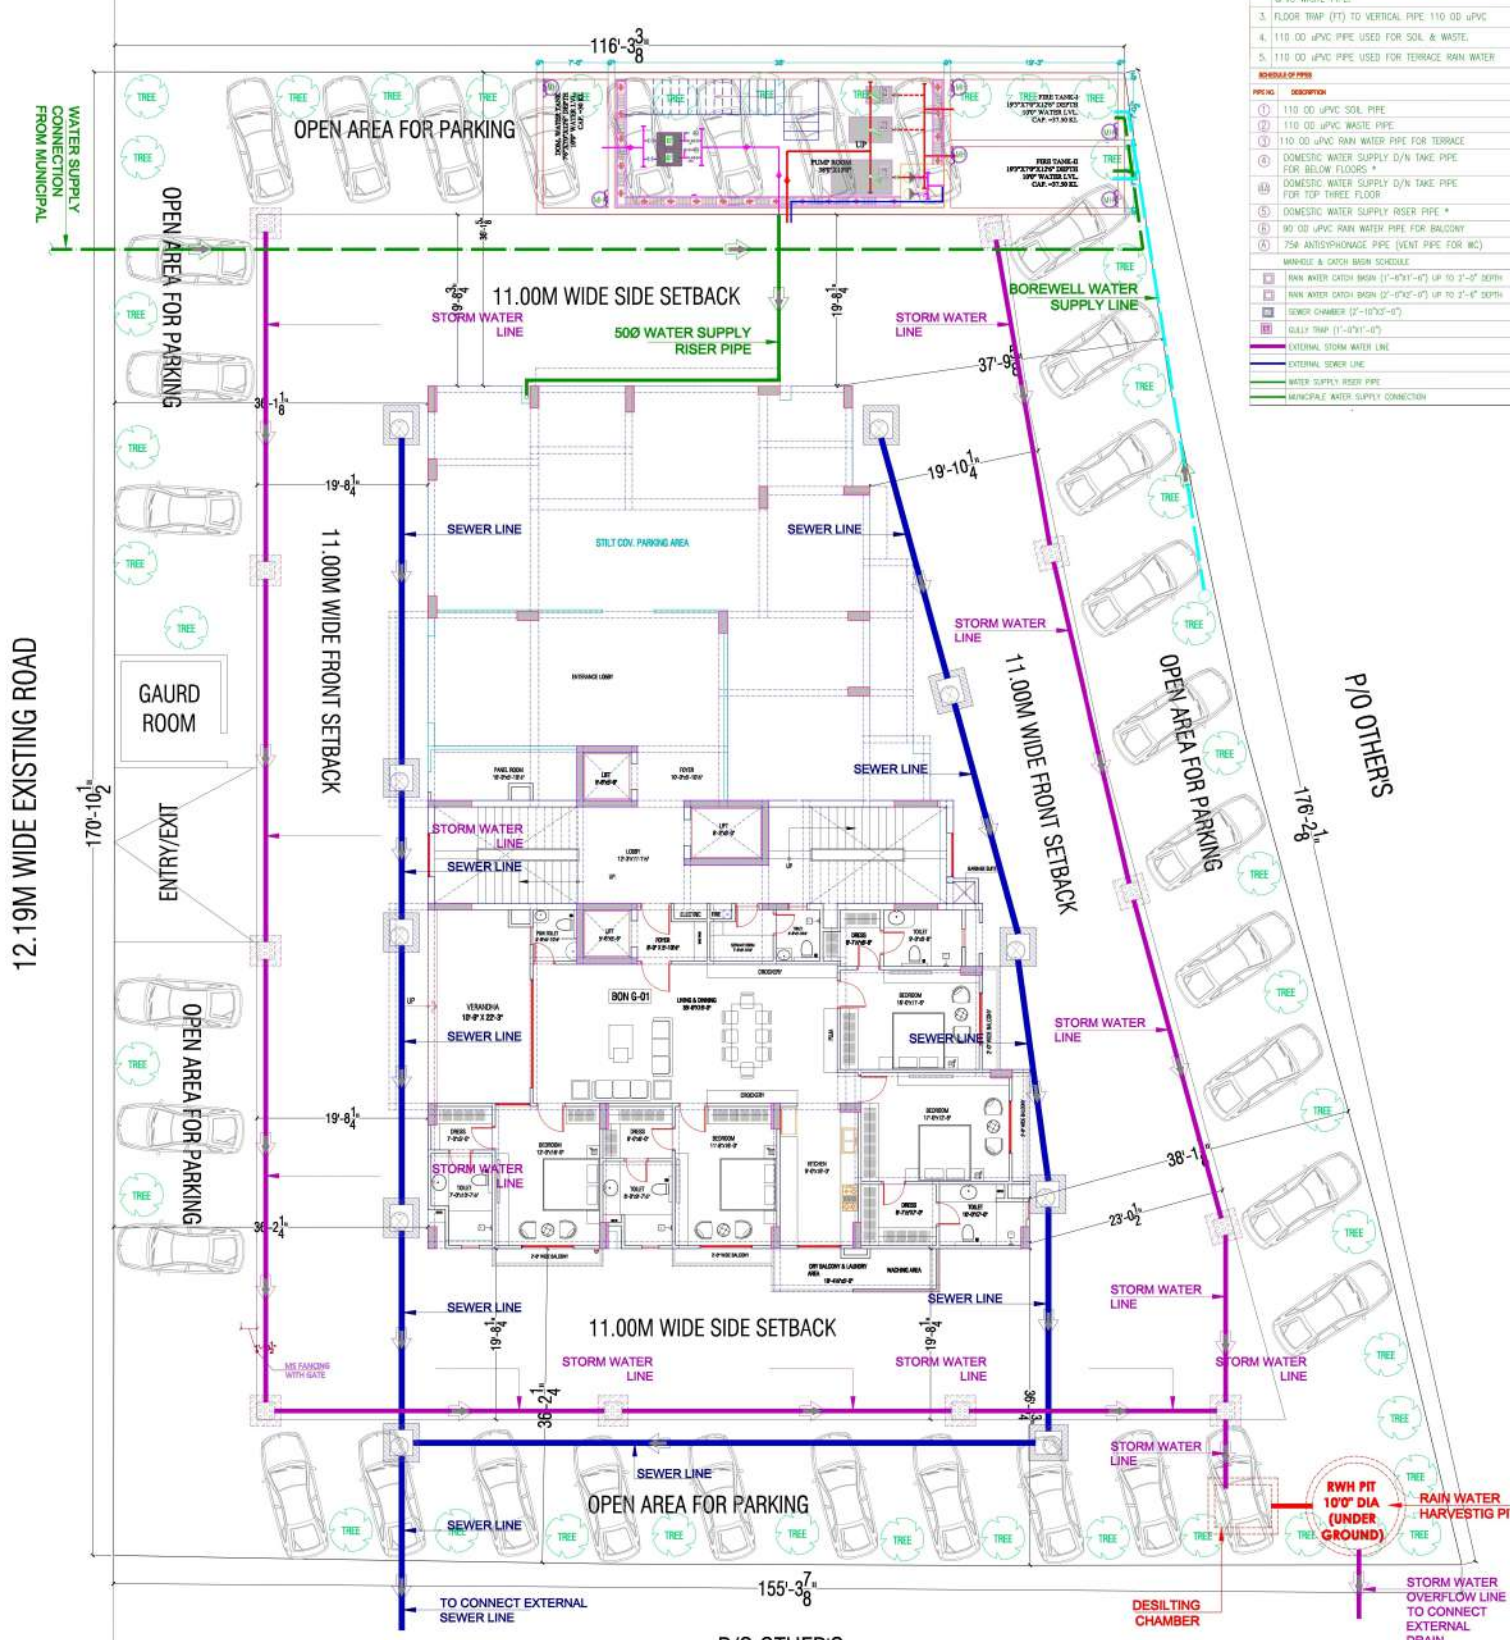

GROUND FLOOR PLAN

P/O OTHER'S
SITE PLAN

GENERAL NOTES :-

1. All dimensions are in feet and inches.
2. Do not scale this drawing below written dimensions only.
3. This drawing shall be read in conjunction with other architectural, structural and services drawings.
4. Any discrepancy in the drawing should be immediately brought to the notice of architect prior to construction.

5. Architectural Drawings should be followed for the Location of structural and masonry members however size & reinforcement shall be followed as structural or other relevant drawings.

6. Coordination with other services drawings such as electrical, hvac, plumbing etc. is the sole responsibility of the contractor.

7. For details follow large scale detailed drawings.

8. All drawings/measurements must be checked & verified by the contractor at site.

9. Architect's responsibility is limited to the soundness of its design only.

10. Bad workmanship will be sole responsibility of client & contractor.

WARNING :-

1. This drawing is the sole copyright of Architects Mishra Garg & Associates and should be used for the purpose expressly issued.

DRAWING TITLE
EXTERNAL PLUMBING SITE PLAN "PARCHID BOUNTY" AT FIROZABAD

PROJECT TITLE
RESIDENTIAL APARTMENT "PARCHID BOUNTY" AT FIROZABAD

ARCHITECTS :
MISHRA GARG & ASSOCIATES
ARCHITECTS, ENGINEERS & INTERIORS DESIGNERS
G-2, LAXMI NAGAR, SOHNA, GURGAON
TEL: 91-9910202014
EMAIL: info@mgad.com

DESIGN BY / CHECKED BY	PROJECT ARCHITECT	DATE	NORTH
SCALE	JOB NO.	DWG. NO.	PL-01
1:1.5			