

General Notes

1. THIS DRAWING IS ONLY FOR PRESENTATION PURPOSE.
2. THIS DRAWING AND DESIGN IS CREATED BY AVIGHNA STUDIO. NO PORTION MAY BE USED OR REPRODUCED WITHOUT THEIR WRITTEN PERMISSION.
3. ARCHITECT MUST BE INFORMED OF ANY ADDITIONAL INFORMATION REQUIRED OR IN CASE OF ANY DISCREPANCY.
4. THIS DRAWING IS TO BE READ IN CONJUNCTION WITH THE DESIGNERS SPECIFICATIONS AND CONDITIONS OF CONTRACT.
5. ALL DIMENSIONS ARE IN MM U.N.O.
6. ALL DIMENSIONS ARE TO BE READ NOT SCALED.

SYMBOL	DESCRIPTION
	DISTRIBUTION BOX
	SWITCH BOARD (54 SOCKET & SWITCHES)
	15A SOCKET WITH SWITCH
	5A POWER SOCKET WITH SWITCH
	BELL PUSH ONCE/VAIR
	CEILING EXHAUST FAN
	SPLIT AC
	TOILET MIRROR LIGHT 1x12w
	KEY TAG 4x7"
	TELEPHONE AS PER FURNITURE LAYOUT
	CEILING LIGHT
	POLE LIGHT
	WALL BRACKET LED LIGHT 4x7"
	1x14 W MIRROR LIGHT 7x7"
	1A 5S WALL LIGHT SWITCH USE CHARGING TYPE C CHARGING SWITCHES FOR CEILING LIGHT @HT. 2.0
	1A 5S WALL LIGHT SWITCH SWITCHES FOR CEILING LIGHTS, TELEPHONE, 25A AC SWITCH, SKIRTING LIGHT @HT. 2.0
	5A 2NOS SOCKET -1 NOS (5A SWITCH, TV COAXIAL SOCKET, LAN @HT 4.0)
	SIDE WALL SPRINKLER HEAD
	PENDENT SPRINKLER HEAD
	SMOKE DETECTOR
	SKIRTING LIGHT 4x7"
	2NOS 15A SWITCH SOCKET -1 NOS (5A SWITCH FOR LIGHT @HT 3.0)
	SPIKE LIGHT
	3x1.5 SQMM LIGHT CONTROL CU WIRE
	3x1.5 SQMM 2 WAY LIGHT CONTROL WIRE
	3x2.5 SQMM CU WIRE FOR AC (DU)
	3x4.0 SQMM CU WIRE FOR POWER CIRCUIT
	3x2.5 SQMM CU WIRE FOR LIGHT CIRCUIT
	CAT6 LAN WIRE RJ45 JACK TO LAN SWITCH
	2 PAIR TELEPHONE WIRE RJ-11 JACK TO TTE
	RHS TV CABLE SETUP BOX TO TV SPLITTER
	CAT6 CCTV CABLE CCTV CAMERA TO NVR

PROJECT-
PROPOSED STUDIO APARTMENT

CLIENT-
CORAL GROUP

DESIGN TITLE-
ELECTRICAL LAYOUT - STILT FLOOR

DRAWING NO: _____ SCALE: **N.T.S.**

DEALT BY: **VISHNU KUMAWAT** CHECKED BY: _____


DATE: **13-09-2025** NORTH:

MEP-

A-8, PATH NO. 4, JAMUNA NAGAR,
SODALA, JAIPUR-302008,
MAIL: - cubemep@gmail.com,
Ph. No. 0141 2221089
Mob. No. +91 9214308430


ARCHITECT-

avighna associates
-- ARCHITECTS, INTERIOR DESIGNERS & PLANNERS --
Studio: 2nd floor block 2 office no 203, Vidyapeeth, Malviya, Jaipur
+91 9214308430
Phone: 9443332295
Email: cubemep@avignastudio.com

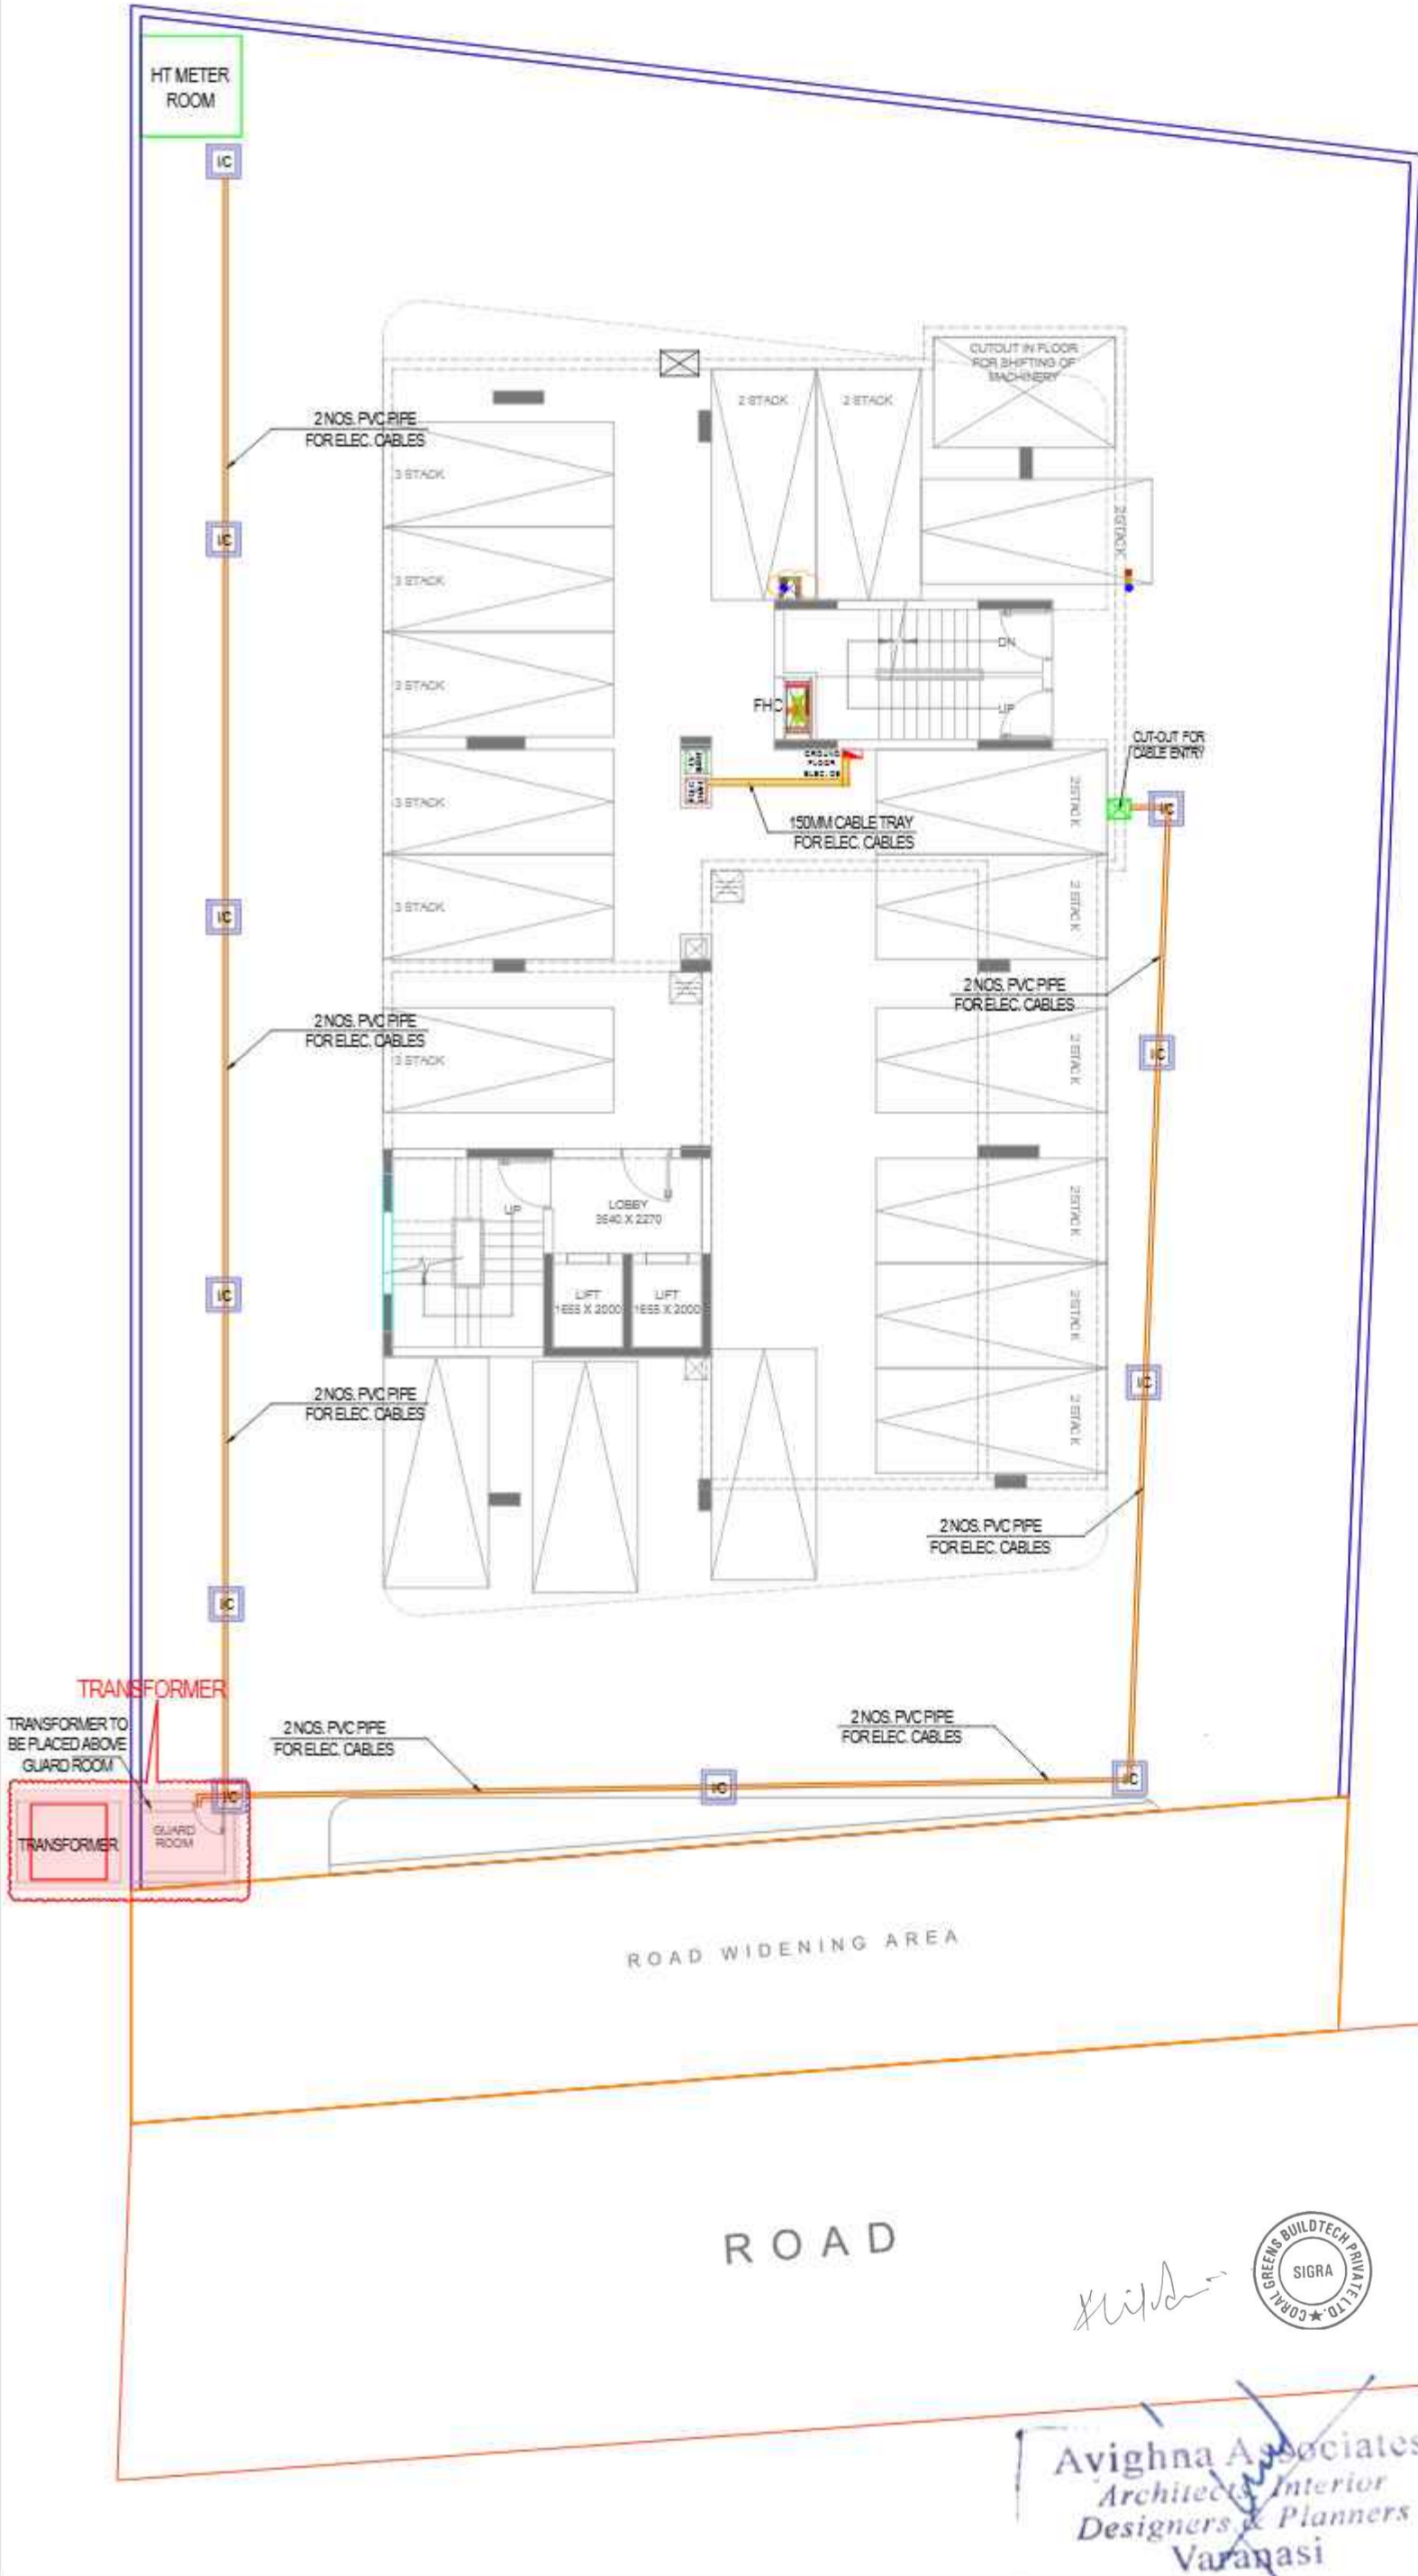

Handwritten signature
Avighna Associates
Architects Interior
Designers & Planners
Varanasi



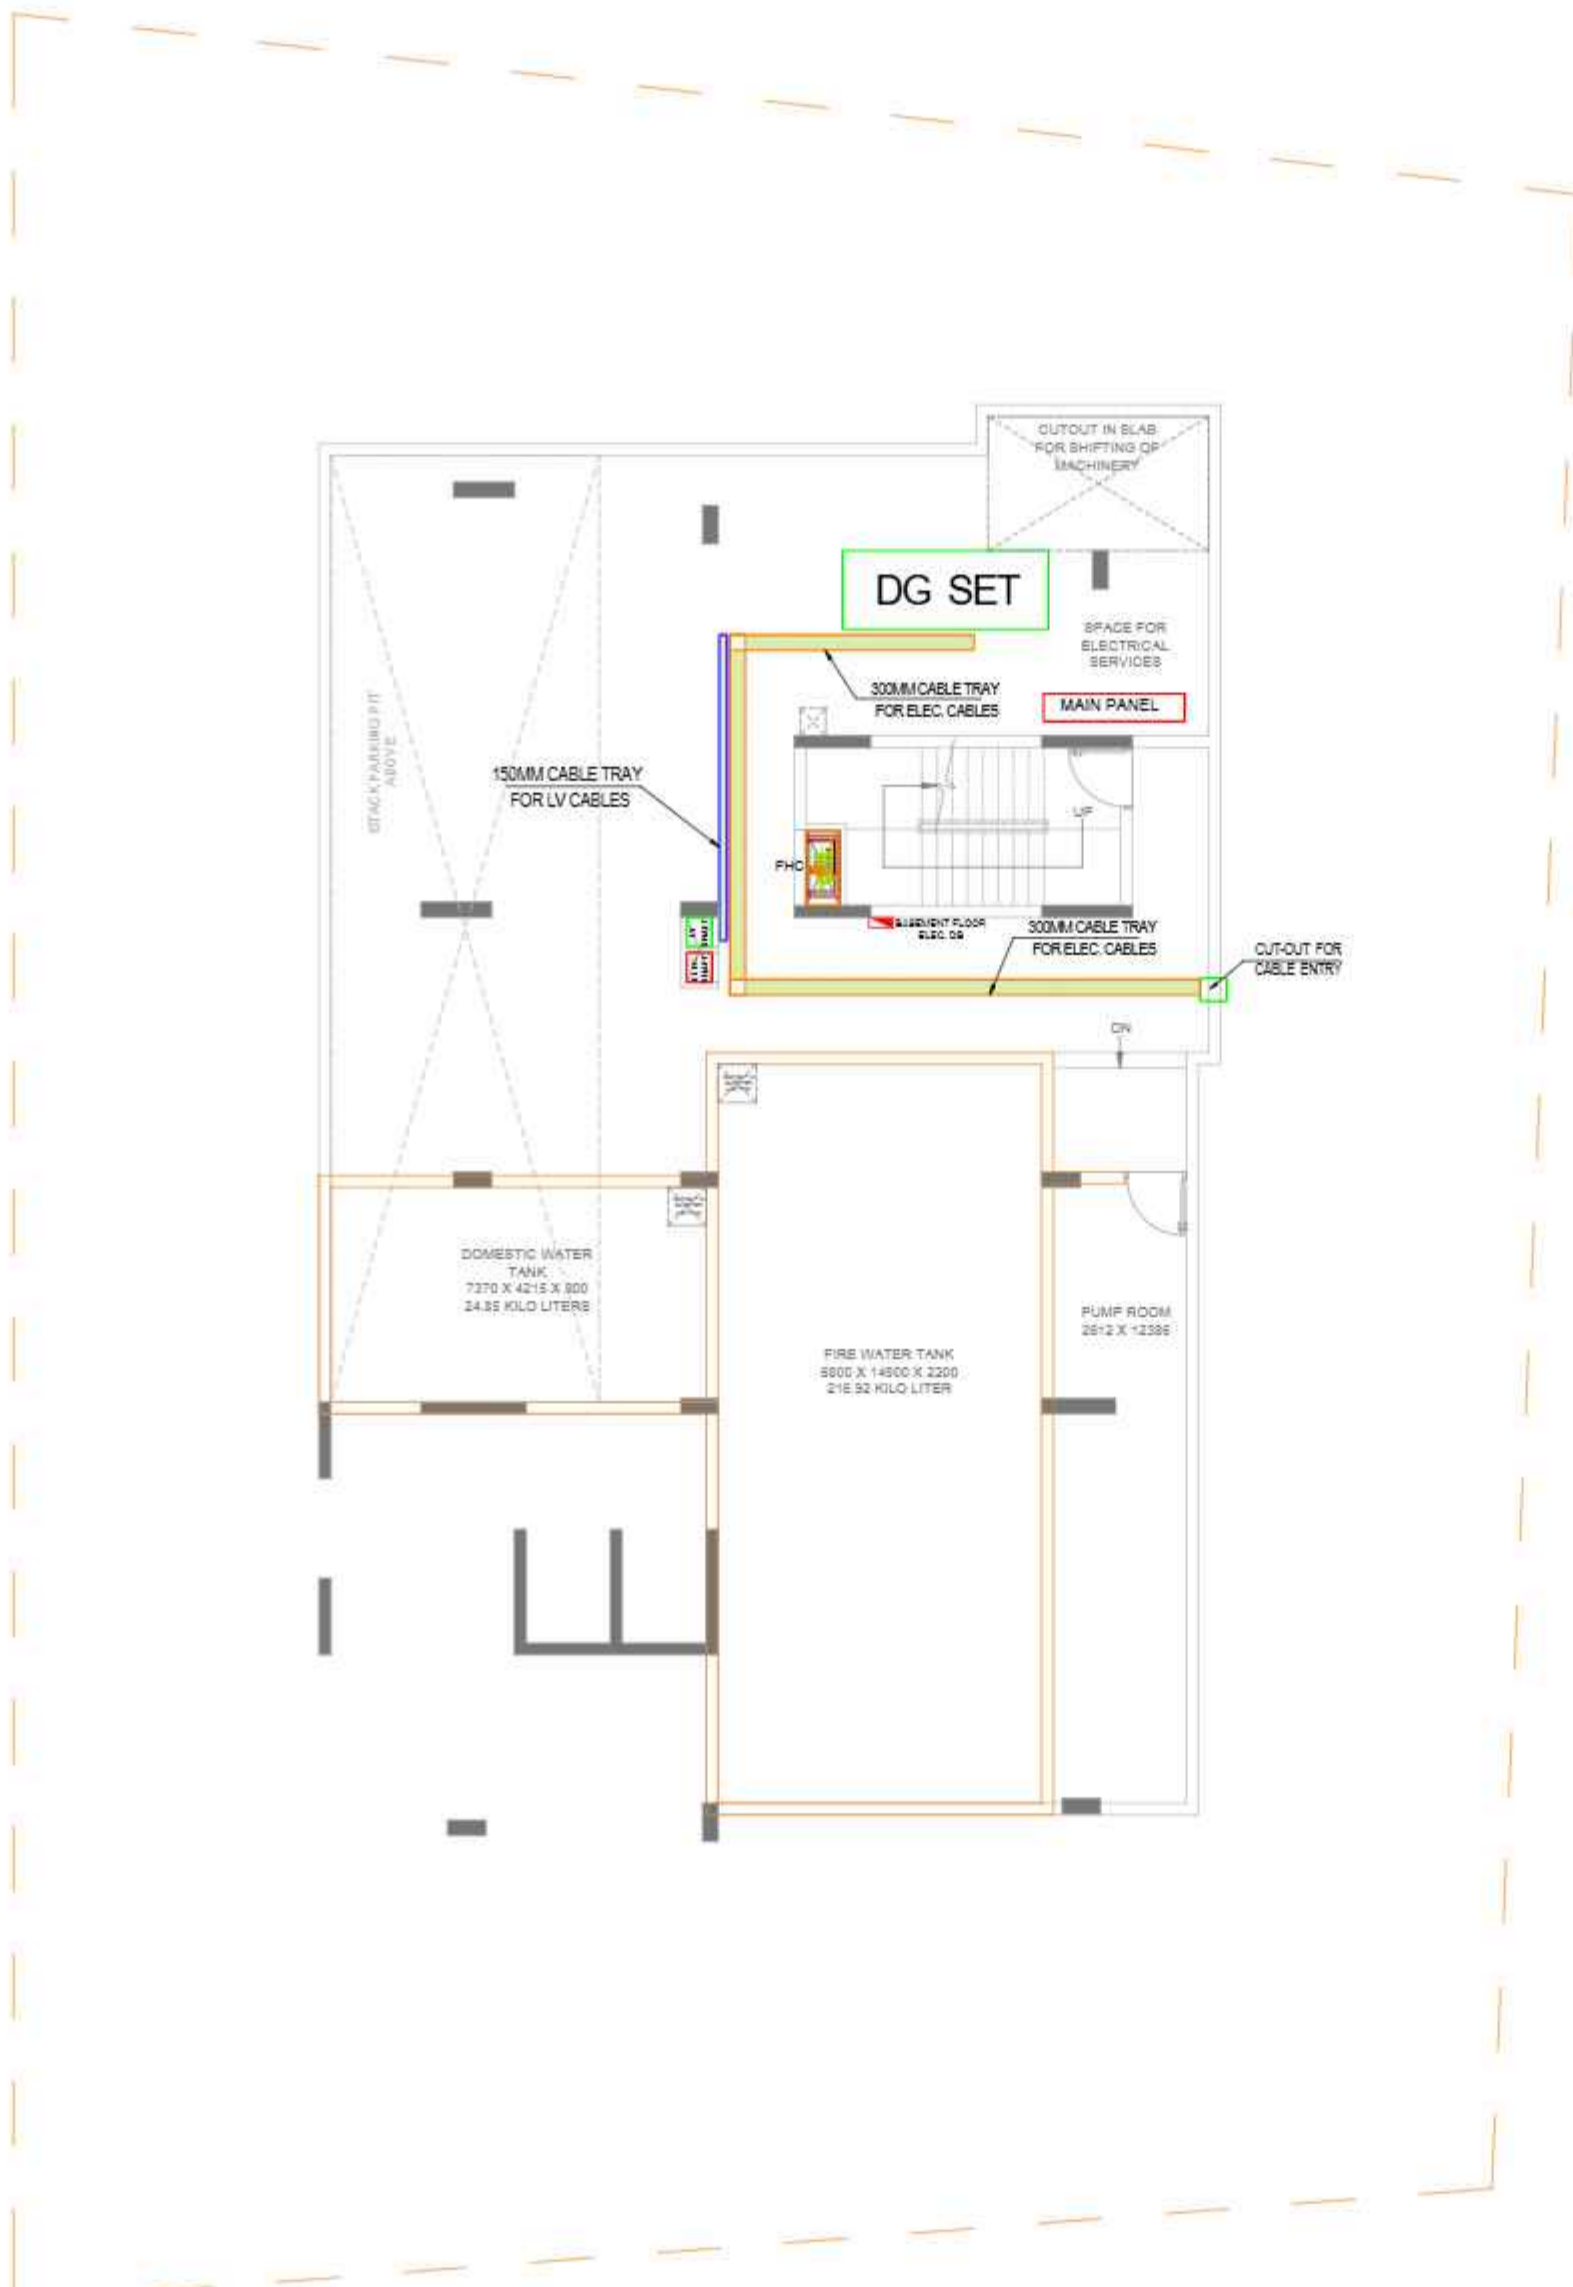

General Notes

1. THIS DRAWING IS ONLY FOR PRESENTATION PURPOSE.
2. THIS DRAWING AND DESIGN IS CREATED BY AVIGHNA STUDIO. NO PORTION MAY BE USED OR REPRODUCED WITHOUT THEIR WRITTEN PERMISSION.
3. ARCHITECT MUST BE INFORMED OF ANY ADDITIONAL INFORMATION REQUIRED OR IN CASE OF ANY DISCREPANCY.
4. THIS DRAWING IS TO BE READ IN CONJUNCTION WITH THE DESIGNERS SPECIFICATIONS AND CONDITIONS OF CONTRACT.
5. ALL DIMENSIONS ARE IN MM U.N.O.
6. ALL DIMENSIONS ARE TO BE READ NOT SCALED.

SYMBOL	DESCRIPTION
	DISTRIBUTION BOX
	SWITCH BOARD (24 SOCKET & SWITCHES)
	15 A SOCKET WITH SWITCH
	24 POWER SOCKET WITH SWITCH
	BELL PUSH ON/OFF
	CEILING EXHAUST FAN
	SPLIT AC
	TOILET MIRROR LIGHT 1x12w
	KEY TAG 4x4"
	TELEPHONE AS PER FURNITURE LAYOUT
	CEILING LIGHT
	POLE LIGHT
	WALL BRACKET LED LIGHT 4x4"
	1 x 14 W MIRROR LIGHT 7x7"
	24 SS WALL LIGHT SWITCH USE CHARGING TYPE C CHARGING SWITCHES FOR CEILING LIGHT @HT. 2'0"
	24 SS WALL LIGHT SWITCH SWITCHES FOR CEILING LIGHTS, TELEPHONE, 24 AC SWITCH, SKIRTING LIGHT @HT. 2'0"
	24 NO. 15A SOCKET + 1 NO. 15A SWITCH, TV COAXIAL SOCKET, LAN @HT 4'0"
	SIDE WALL SPRINKLER HEAD
	PENDENT SPRINKLER HEAD
	SMOKE DETECTOR
	SKIRTING LIGHT 4x4"
	2 NOS 15A SWITCH SOCKET + 1 NOS 24 SWITCH FOR LIGHT @HT 3'6"
	SPIKE LIGHT
	3 x 1.5 SQMM LIGHT CONTROL CU WIRE
	3 x 1.5 SQMM 2 WAY LIGHT CONTROL WIRE
	3 x 2.5 SQMM CU WIRE FOR AC (DU)
	3 x 4.0 SQMM CU WIRE FOR POWER CIRCUIT
	3 x 2.5 SQMM CU WIRE FOR LIGHT CIRCUIT
	CAT6 LAN WIRE RJ45 JACK TO LAN SWITCH
	2 PAIR TELEPHONE WIRE RJ11 JACK TO TTE
	RGN TV CABLE SETUP BOX TO TV SPLITTER
	CAT6 CCTV CABLE CCTV CAMERA TO NVR

PROJECT-
PROPOSED STUDIO APARTMENT

CLIENT-
CORAL GROUP

DESIGN TITLE-
ELECTRICAL LAYOUT - BASEMENT FLOOR

DRAWING NO.:	SCALE: N.T.S.
DEALT BY - VISHNU KUMAWAT	CHECKED BY -
DATE: 13-09-2025	NORTH:


MEP-

 A-8, PATH NO. 4, JAMUNA NAGAR,
 SODALA, JAIPUR-302008,
 MAIL: - cubemep@gmail.com,
 Ph. No. 0141 2221089
 Mob. No. +91 9214308430

ARCHITECT-

avighna associates
 ARCHITECTS, INTERIOR DESIGNERS & PLANNERS -
 studio: 2nd floor block 2 office no 203, vishal plaza, rajdhani, Varanasi
 +91 912 212 019, U.P.
 phone: 9443332295
 email: avighna@avighnaassociates.com

Avighna Associates
 Architects, Interior
 Designers & Planners
 Varanasi

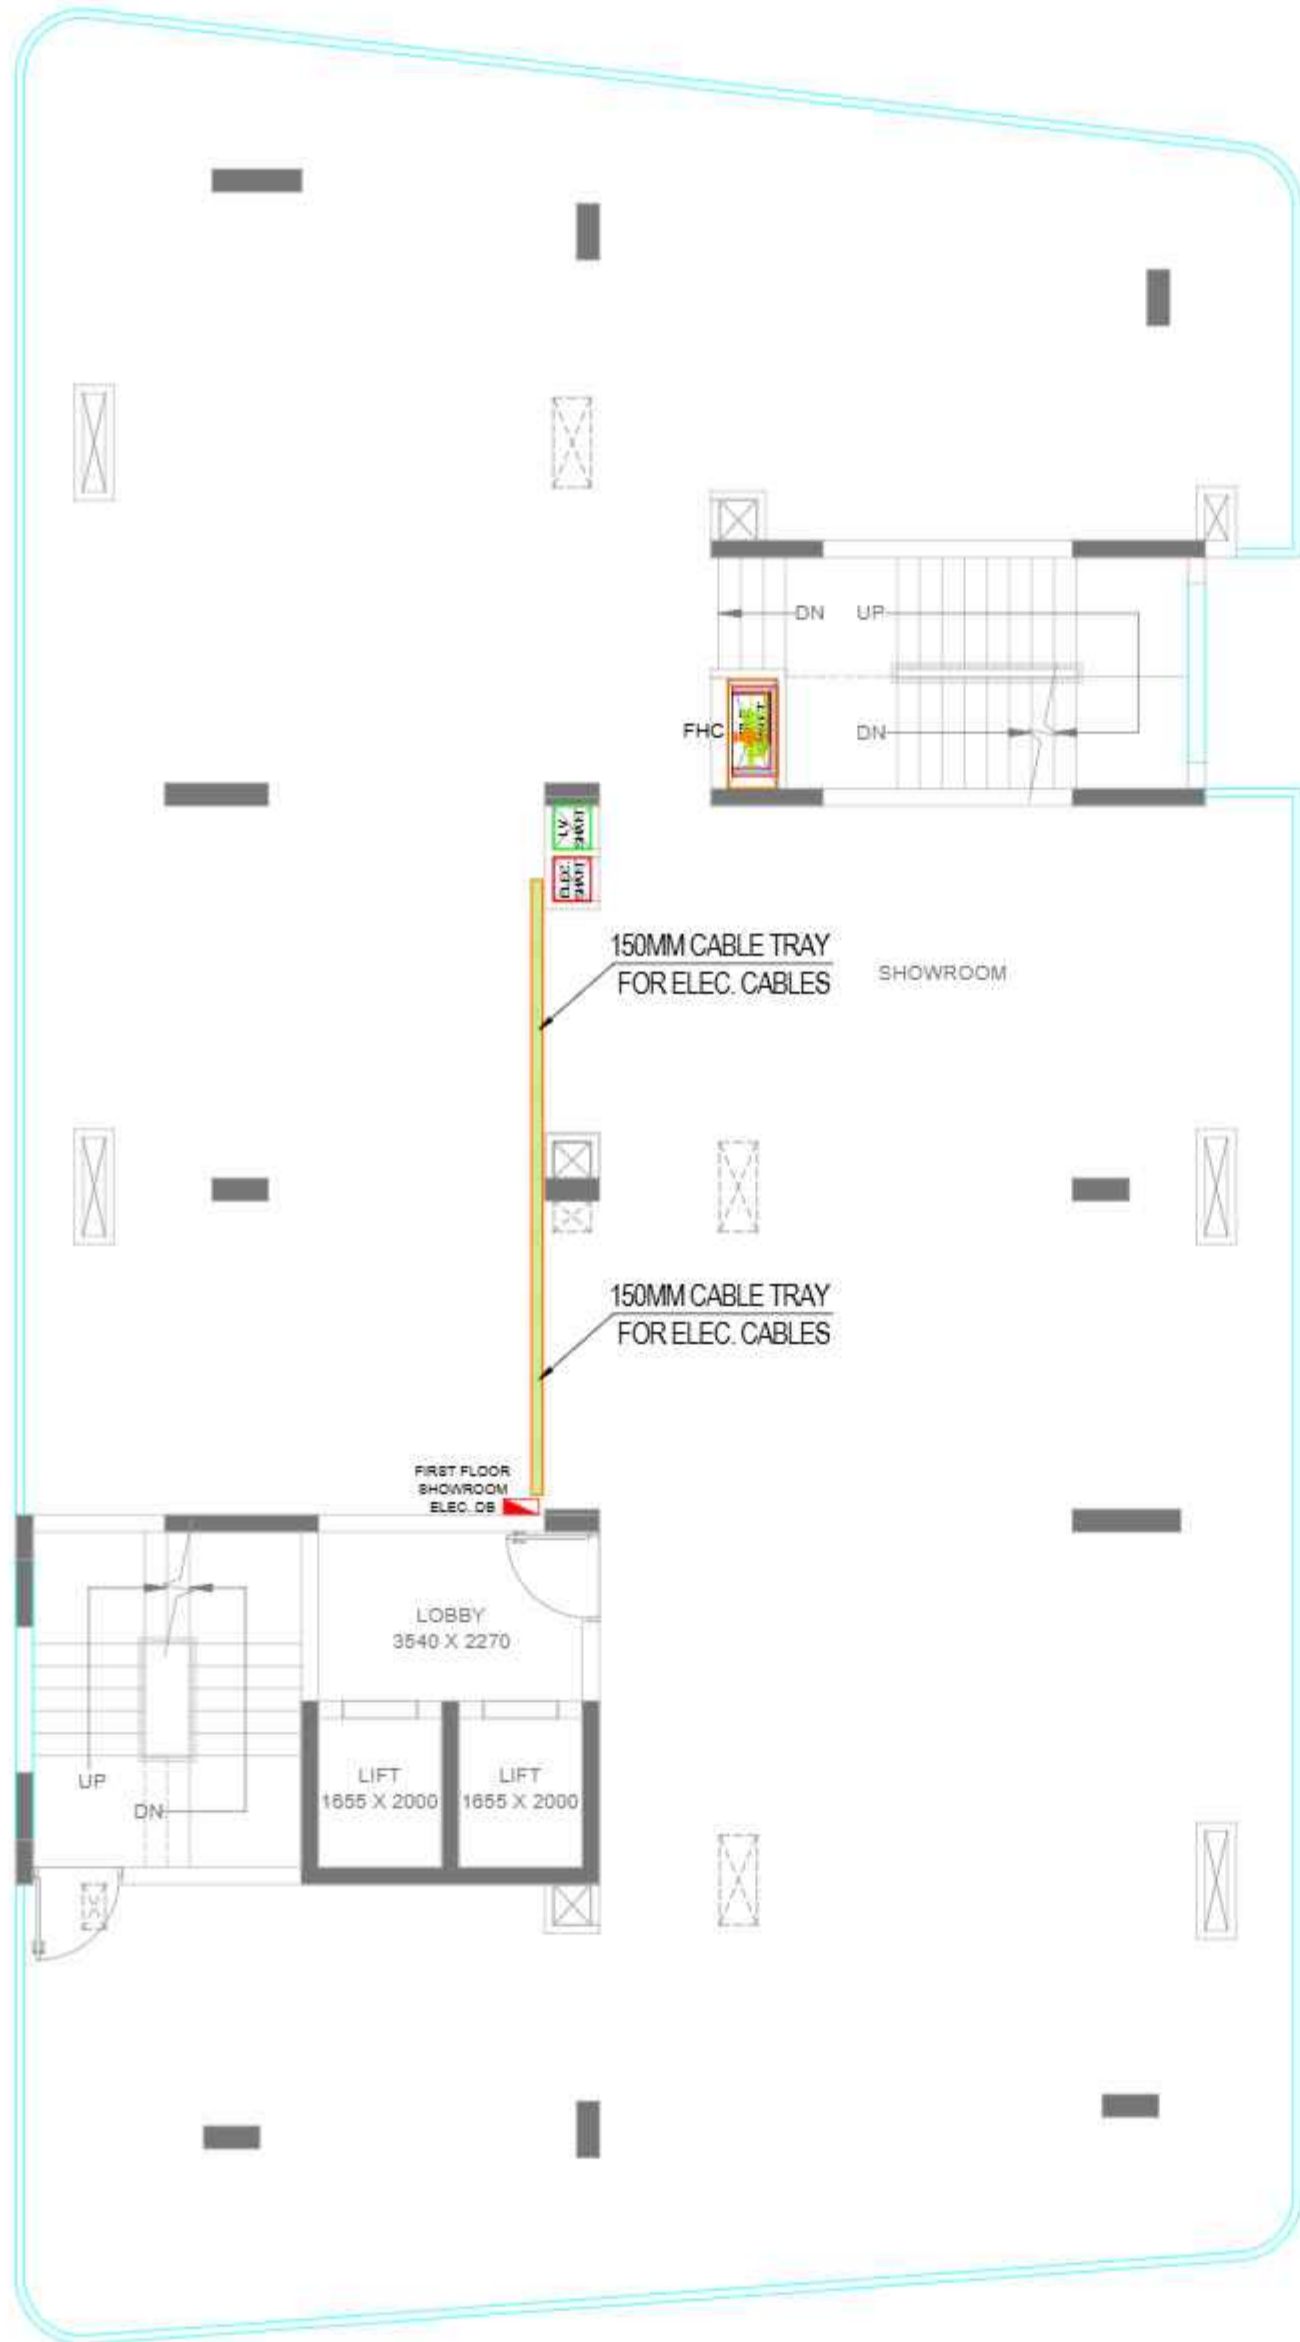

General Notes

1. THIS DRAWING IS ONLY FOR PRESENTATION PURPOSE.
2. THIS DRAWING AND DESIGN IS CREATED BY AVIGHNA STUDIO. NO PORTION MAY BE USED OR REPRODUCED WITHOUT THEIR WRITTEN PERMISSION.
3. ARCHITECT MUST BE INFORMED OF ANY ADDITIONAL INFORMATION REQUIRED OR IN CASE OF ANY DISCREPANCY.
4. THIS DRAWING IS TO BE READ IN CONJUNCTION WITH THE DESIGNERS SPECIFICATIONS AND CONDITIONS OF CONTRACT.
5. ALL DIMENSIONS ARE IN MM U.N.O.
6. ALL DIMENSIONS ARE TO BE READ NOT SCALED.

SYMBOL	DESCRIPTION
	DISTRIBUTION BOX
	SWITCH BOARD (24 SOCKET & SWITCHES)
	15 A SOCKET WITH SWITCH
	24 POWER SOCKET WITH SWITCH
	BELL PUSH ON/OFF
	CEILING EXHAUST FAN
	SPLIT AC
	TOILET MIRROR LIGHT 1x12w
	KEY TAG 4x4"
	TELEPHONE AS PER FURNITURE LAYOUT
	CEILING LIGHT
	POLE LIGHT
	WALL BRACKET LED LIGHT 4x4"
	1 x 14 W MIRROR LIGHT 7x7"
	24 SS WALL LIGHT SWITCH USE CHARGING TYPE C CHARGING SWITCHES FOR CEILING LIGHT @ HT. 2.0
	24 SS WALL LIGHT SWITCH SWITCHES FOR CEILING LIGHTS, TELEPHONE, 23A AC SWITCH, SKIRTING LIGHT @ HT. 2.0
	24 NOS SOCKET - 1 NOS 15A SWITCH, TV COAXIAL SOCKET, LAN @ HT 4"
	SIDE WALL SPRINKLER HEAD
	PENDENT SPRINKLER HEAD
	SMOKE DETECTOR
	SKIRTING LIGHT 4x4"
	2 NOS 15A SWITCH SOCKET - 1 NOS 24 SWITCH FOR LIGHT @ HT 2.0
	SPIKE LIGHT
	3 x 1.5 SQMM LIGHT CONTROL CU WIRE
	3 x 1.5 SQMM 2 WAY LIGHT CONTROL WIRE
	3 x 2.5 SQMM CU WIRE FOR AC (DU)
	3 x 4.0 SQMM CU WIRE FOR POWER CIRCUIT
	3 x 2.5 SQMM CU WIRE FOR LIGHT CIRCUIT
	CAT6 LAN WIRE RJ45 JACK TO LAN SWITCH
	2 PAIR TELEPHONE WIRE RJ11 JACK TO TTE
	RGN TV CABLE SETUP BOX TO TV SPLITTER
	CAT6 CCTV CABLE CCTV CAMERA TO NVR

PROJECT-
PROPOSED STUDIO APARTMENT

CLIENT-
CORAL GROUP

DESIGN TITLE-
ELECTRICAL LAYOUT - 1ST FLOOR

DRAWING NO:	SCALE: N.T.S.
DEALT BY - VISHNU KUMAWAT	CHECKED BY -
DATE: 13-09-2025	NORTH:

MEP-


 A-8, PATH NO. 4, JAMUNA NAGAR,
 SODALA, JAIPUR-302008,
 MAIL: - cubemep@gmail.com,
 Ph. No. 0141 2221089
 Mob. No. +91 9214308430

ARCHITECT-

avighna associates
 ARCHITECTS, INTERIOR DESIGNERS & PLANNERS -
 studio: 2nd floor block 0 office no 205, vishal plaza, rajdhani, Varanasi
 +22192, U.P.
 phone: 9443332295
 email: avighna@avighnaassociates.com

Handwritten signature

Avighna Associates
 Architects, Interior
 Designers & Planners
 Varanasi

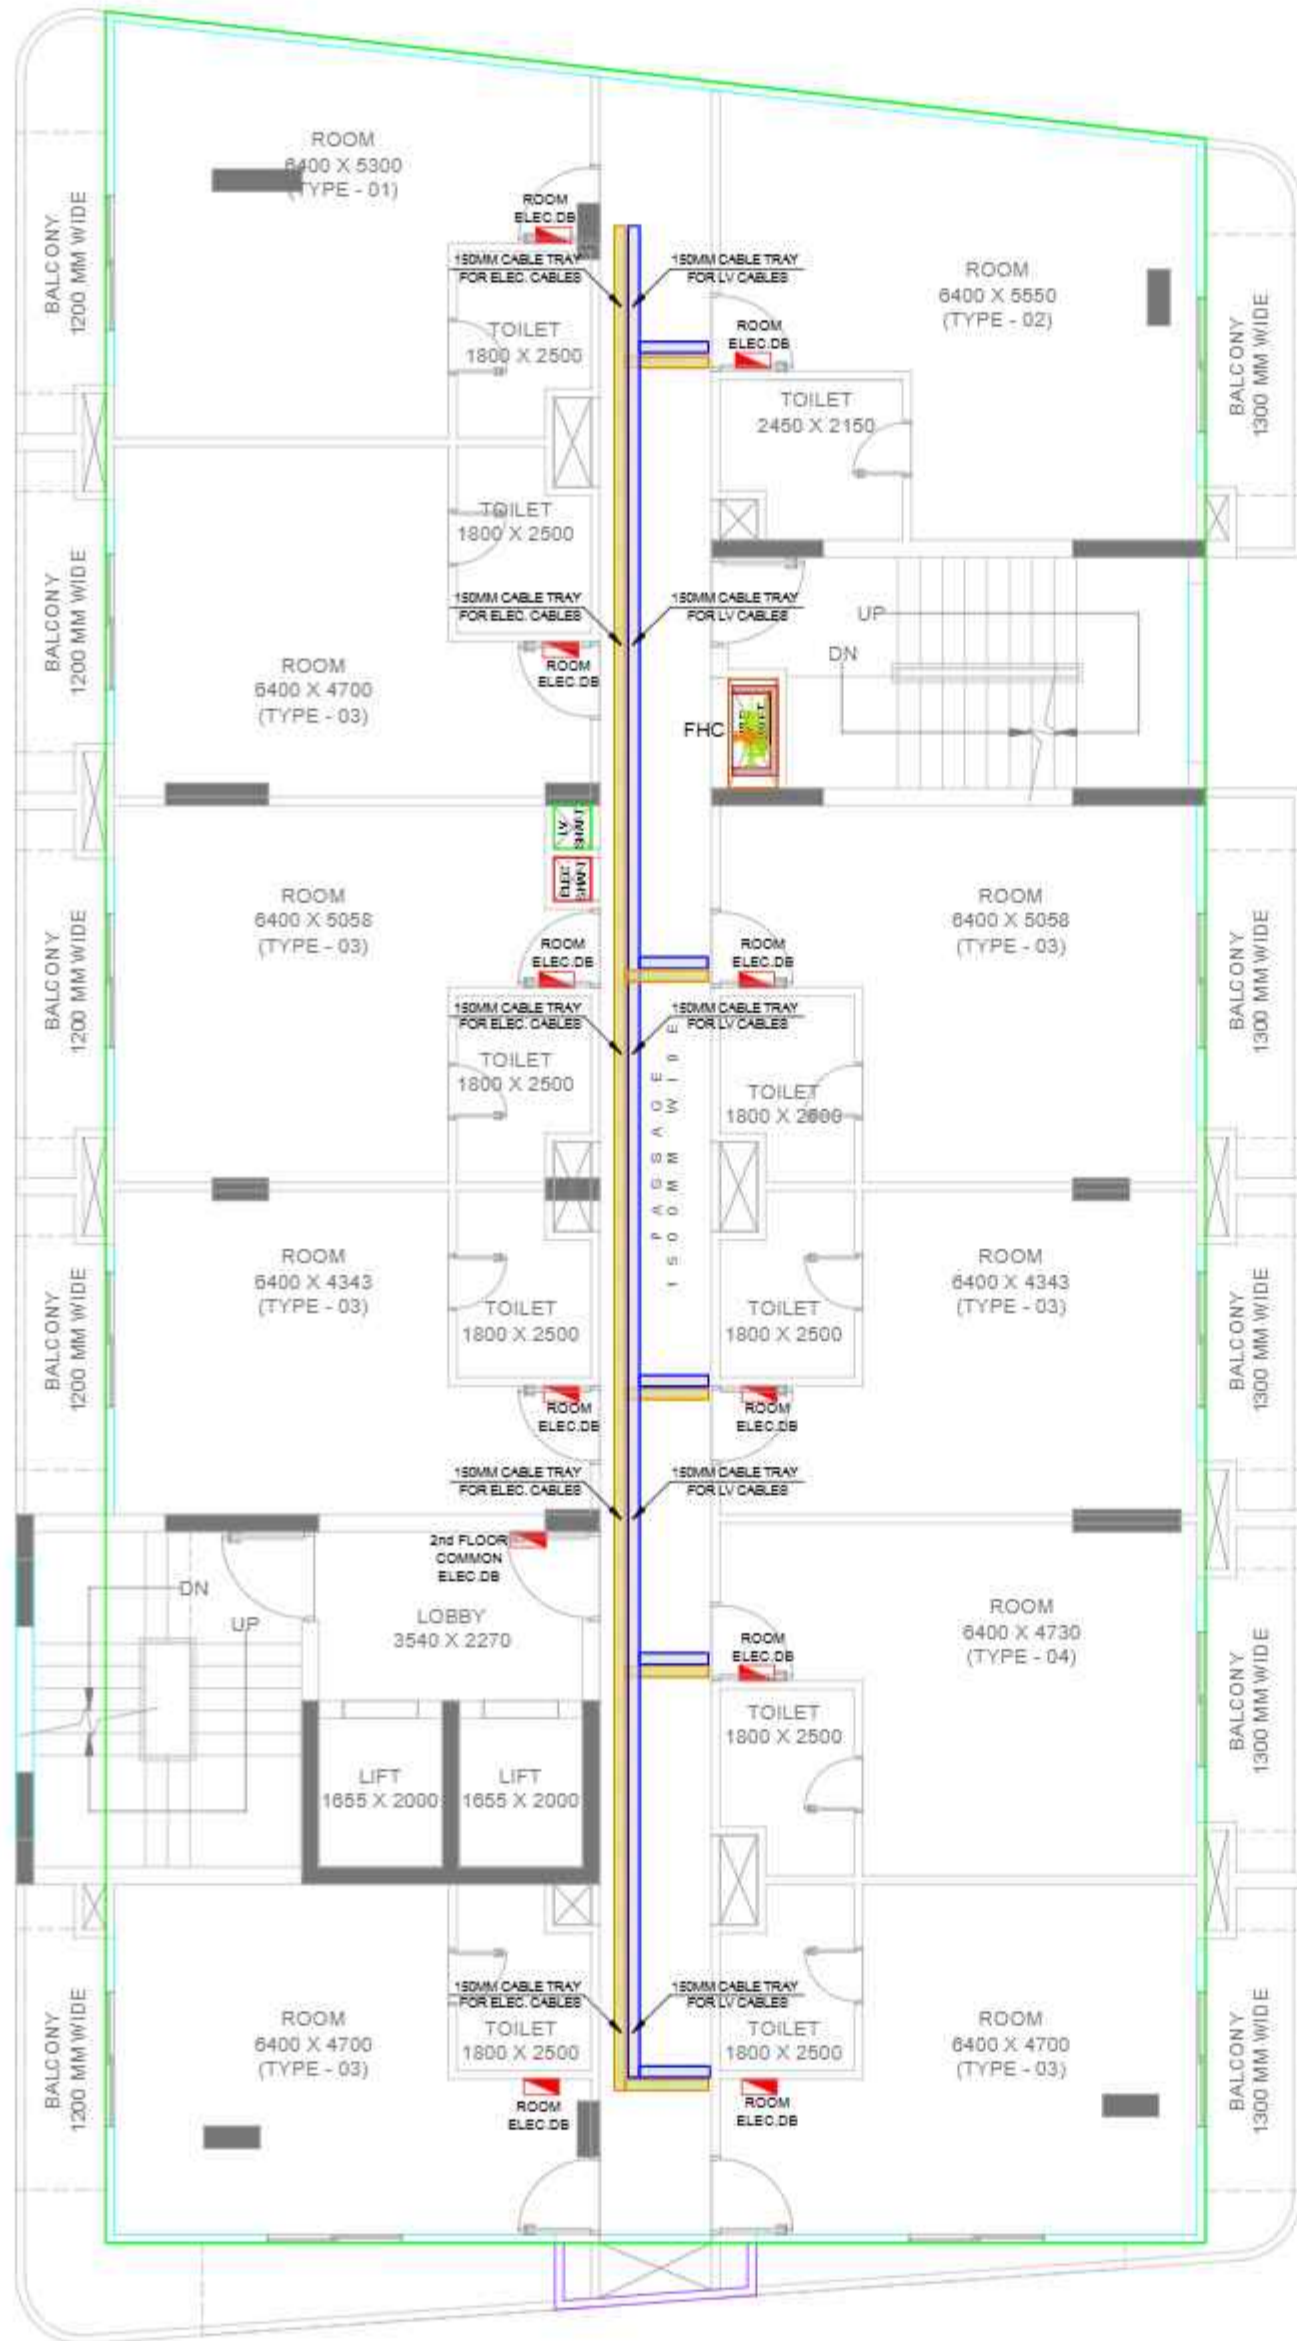

General Notes

1. THIS DRAWING IS ONLY FOR PRESENTATION PURPOSE.
2. THIS DRAWING AND DESIGN IS CREATED BY AVIGHNA STUDIO. NO PORTION MAY BE USED OR REPRODUCED WITHOUT THEIR WRITTEN PERMISSION.
3. ARCHITECT MUST BE INFORMED OF ANY ADDITIONAL INFORMATION REQUIRED OR IN CASE OF ANY DISCREPANCY.
4. THIS DRAWING IS TO BE READ IN CONJUNCTION WITH THE DESIGNERS SPECIFICATIONS AND CONDITIONS OF CONTRACT.
5. ALL DIMENSIONS ARE IN MM U.N.O.
6. ALL DIMENSIONS ARE TO BE READ NOT SCALED.

SYMBOL	DESCRIPTION
	DISTRIBUTION BOX
	SWITCH BOARD (54 SOCKET & SWITCHES)
	15A SOCKET WITH SWITCH
	24 POWER SOCKET WITH SWITCH
	BELL PUSH ON/OFF
	CEILING EXHAUST FAN
	8PLT AC
	TOILET MIRROR LIGHT 1x12w
	KEY TAG 4x4"
	TELEPHONE AS PER FURNITURE LAYOUT
	CEILING LIGHT
	POLE LIGHT
	WALL BRACKET LED LIGHT 4x4"
	1 x 14 W MIRROR LIGHT 7x7"
	24 SS WALL LIGHT SWITCH USE CHARGING TYPE C CHARGING SWITCHES FOR CEILING LIGHT @T. 20
	24 SS WALL LIGHT SWITCH SWITCHES FOR CEILING LIGHTS, TELEPHONE, 24 AC SWITCH, SKIRTING LIGHT @T. 20
	24 NOB SOCKET - 1 NOB (24 SWITCH, TV COAXIAL SOCKET, LAN @T. 40"
	SIDE WALL SPRINKLER HEAD
	PENDENT SPRINKLER HEAD
	SMOKE DETECTOR
	SKIRTING LIGHT 4x4"
	2 NOB 15A SWITCH SOCKET - 1 NOB (24 SWITCH FOR LIGHT @T. 20)
	SPIKE LIGHT
	3 x 1.5 SQMM LIGHT CONTROL CU WIRE
	3 x 1.5 SQMM 2 WAY LIGHT CONTROL WIRE
	3 x 2.5 SQMM CU WIRE FOR AC (DU)
	3 x 4.0 SQMM CU WIRE FOR POWER CIRCUIT
	3 x 2.5 SQMM CU WIRE FOR LIGHT CIRCUIT
	CAT6 LAN WIRE RJ45 JACK TO LAN SWITCH
	2 PAIR TELEPHONE WIRE RJ11 JACK TO TTE
	RDS TV CABLE SETUP BOX TO TV SPLITTER
	CAT6 CCTV CABLE CCTV CAMERA TO NVR

PROJECT-
PROPOSED STUDIO APARTMENT

CLIENT-
CORAL GROUP

DESIGN TITLE-
ELECTRICAL LAYOUT - 2ND FLOOR

DRAWING NO.: _____ **SCALE:**
N.T.S.

DEALT BY - VISHNU KUMAWAT **CHECKED BY -** _____

DATE: 13-09-2025 **NORTH:**

MEP-


A-8, PATH NO. 4, JAMUNA NAGAR,
SODALA, JAIPUR-302008,
MAIL: - cubemep@gmail.com,
Ph. No. 0141 2221089
Mob. No. +91 9214308430

ARCHITECT-

avighna associates
- ARCHITECTS, INTERIOR DESIGNERS & PLANNERS -
Studio: 2nd floor block office no 203, Vidyapeeth, Mohanpur, Varanasi
+91 9214308430
Phone: 9443332295
Email: avighna@avighnaassociates.com

Avighna Associates
Architects, Interior
Designers & Planners
Varanasi

- General Notes**
1. THIS DRAWING IS ONLY FOR PRESENTATION PURPOSE.
 2. THIS DRAWING AND DESIGN IS CREATED BY AVIGHNA STUDIO. NO PORTION MAY BE USED OR REPRODUCED WITHOUT THEIR WRITTEN PERMISSION.
 3. ARCHITECT MUST BE INFORMED OF ANY ADDITIONAL INFORMATION REQUIRED OR IN CASE OF ANY DISCREPANCY.
 4. THIS DRAWING IS TO BE READ IN CONJUNCTION WITH THE DESIGNERS SPECIFICATIONS AND CONDITIONS OF CONTRACT.
 5. ALL DIMENSIONS ARE IN MM U.N.O.
 6. ALL DIMENSIONS ARE TO BE READ NOT SCALED.

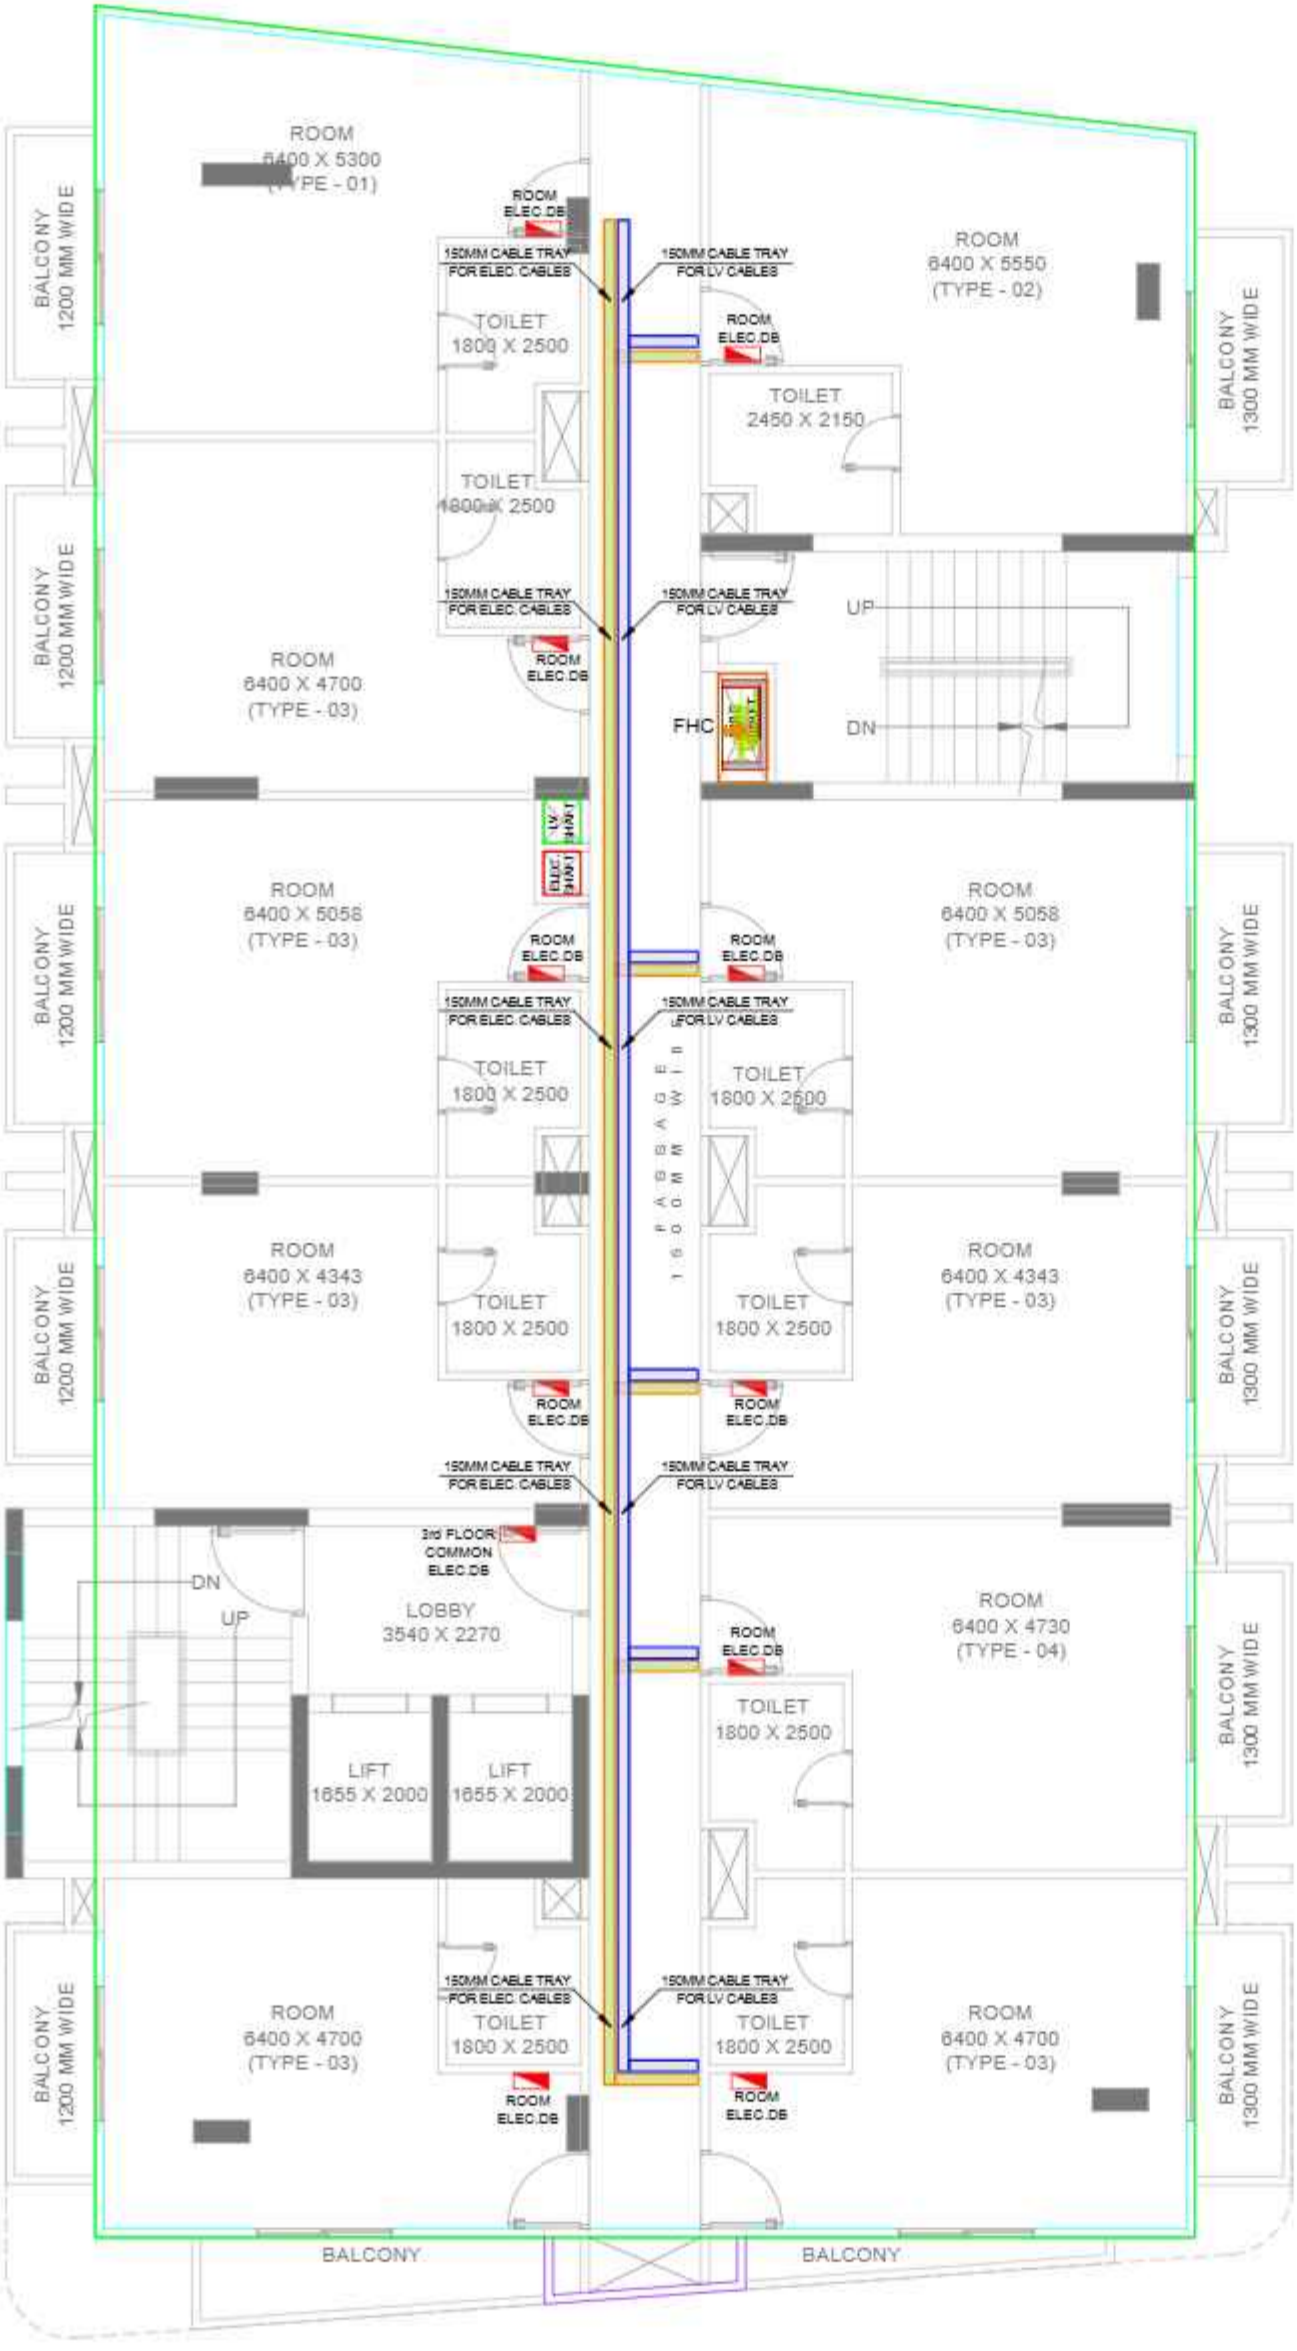

SYMBOL	DESCRIPTION
[Symbol]	DISTRIBUTION BOX
[Symbol]	SWITCH BOARD (5A SOCKET & SWITCHES)
[Symbol]	15A SOCKET WITH SWITCH
[Symbol]	5A POWER SOCKET WITH SWITCH
[Symbol]	BELL PUSH ON/OFF
[Symbol]	CEILING EXHAUST FAN
[Symbol]	5P/1T AC
[Symbol]	TOILET MIRROR LIGHT 1x18w
[Symbol]	KEY TAG 4x0"
[Symbol]	TELEPHONE AS PER FURNITURE LAYOUT
[Symbol]	CEILING LIGHT
[Symbol]	POLE LIGHT
[Symbol]	WALL BRACKET LED LIGHT 4x0"
[Symbol]	1 x 14 W MIRROR LIGHT 7x0"
[Symbol]	5A SS/WALL LIGHT SWITCH USE CHARGING TYPE C CHARGING SWITCHES FOR CEILING LIGHT @T. 20
[Symbol]	5A SS/WALL LIGHT SWITCH SWITCHES FOR CEILING LIGHTS, TELEPHONE, 5A AC SWITCH, SKIRTING LIGHT @T. 20
[Symbol]	5A/10A SOCKET 4 NOS (5A SWITCH, TV COAXIAL SOCKET, LAN @T. 40"
[Symbol]	SIDE WALL SPRINKLER HEAD
[Symbol]	PENDENT SPRINKLER HEAD
[Symbol]	SMOKE DETECTOR
[Symbol]	SKIRTING LIGHT 4x0"
[Symbol]	2 NOS 15A SWITCH SOCKET 4 NOS 5A SWITCH FOR LIGHT @T. 30"
[Symbol]	SPIKE LIGHT
[Symbol]	3 x 1.5 SQMM LIGHT CONTROL CU WIRE
[Symbol]	3 x 1.5 SQMM 2 WAY LIGHT CONTROL WIRE
[Symbol]	3 x 2.5 SQMM CU WIRE FOR AC (DU)
[Symbol]	3 x 4.0 SQMM CU WIRE FOR POWER CIRCUIT
[Symbol]	3 x 2.5 SQMM CU WIRE FOR LIGHT CIRCUIT
[Symbol]	CAT5 LAN WIRE RJ45 JACK TO LAN SWITCH
[Symbol]	2 PAIR TELEPHONE WIRE RJ11 JACK TO TTE
[Symbol]	RGN TV CABLE SETUP BOX TO TV SPLITTER
[Symbol]	CAT5 CCTV CABLE CCTV CAMERA TO NVR

PROJECT-
PROPOSED STUDIO APARTMENT

CLIENT-
CORAL GROUP

DESIGN TITLE-
ELECTRICAL LAYOUT - 3RD FLOOR

DRAWING NO.: _____ **SCALE:**
N.T.S.

DEALT BY - VISHNU KUMAWAT **CHECKED BY -** _____

DATE: 13-09-2025 **NORTH:**

MEP-

cube consultant
A-8, PATH NO. 4, JAMUNA NAGAR,
SODALA, JAIPUR-302008,
MAIL: - cubemep@gmail.com,
Ph. No. 0141 2221089
Mob. No. +91 9214308430


ARCHITECT-

avighna associates
-- ARCHITECTS, INTERIOR DESIGNERS & PLANNERS --
Studio: 2nd floor block 0 office no 205, Vardaan Plaza, Mahanagar, Varanasi
221012, U.P.
Phone: 9453332295
Email: avighna@avighnaassociates.com

Handwritten signature

SIGRA
COAL GREENS BUILDTECH PRIVATE LTD.

Avighna Associates
Architects, Interior Designers & Planners
Varanasi

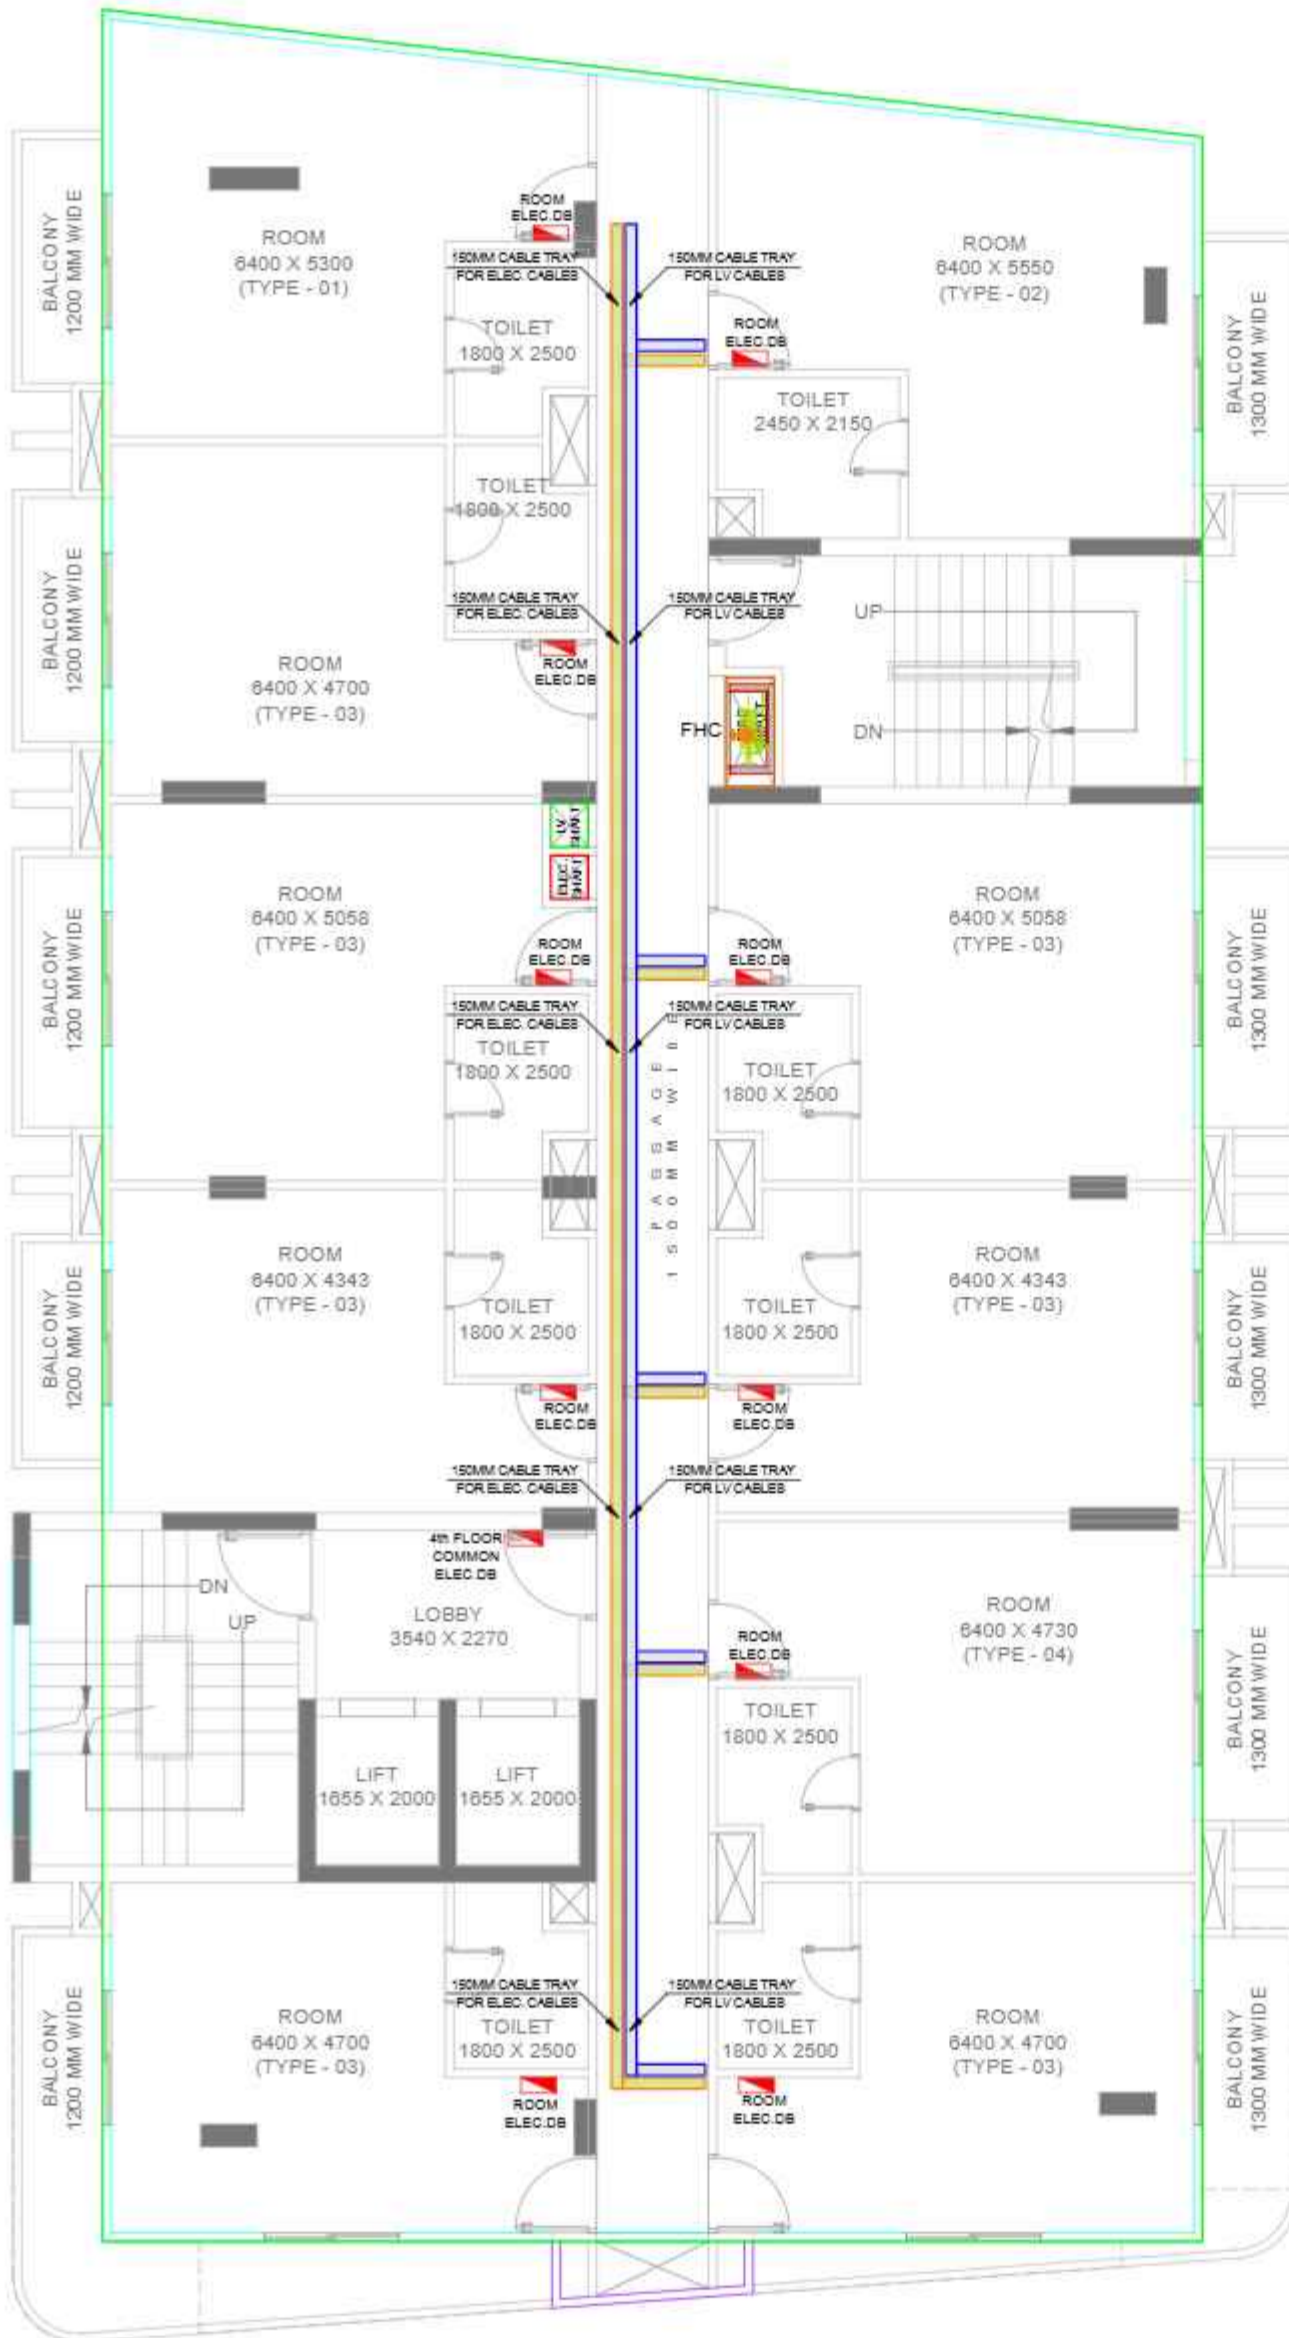

General Notes

1. THIS DRAWING IS ONLY FOR PRESENTATION PURPOSE.
2. THIS DRAWING AND DESIGN IS CREATED BY AVIGHNA STUDIO. NO PORTION MAY BE USED OR REPRODUCED WITHOUT THEIR WRITTEN PERMISSION.
3. ARCHITECT MUST BE INFORMED OF ANY ADDITIONAL INFORMATION REQUIRED OR IN CASE OF ANY DISCREPANCY.
4. THIS DRAWING IS TO BE READ IN CONJUNCTION WITH THE DESIGNERS SPECIFICATIONS AND CONDITIONS OF CONTRACT.
5. ALL DIMENSIONS ARE IN MM U.N.O.
6. ALL DIMENSIONS ARE TO BE READ NOT SCALED.

SYMBOL	DESCRIPTION
	DISTRIBUTION BOX
	SWITCH BOARD (24 SOCKET & SWITCHES)
	15A SOCKET WITH SWITCH
	24 POWER SOCKET WITH SWITCH
	BELL PUSH ON/OFF
	CEILING EXHAUST FAN
	SPILT AC
	TOILET MIRROR LIGHT 1x18w
	KEY TAG 4x7"
	TELEPHONE AS PER FURNITURE LAYOUT
	CEILING LIGHT
	POLE LIGHT
	WALL BRACKET LED LIGHT 4x7"
	1 x 14 W MIRROR LIGHT 7x7"
	24 SS WALL LIGHT SWITCH USE CHARGING TYPE C CHARGING SWITCH FOR CEILING LIGHT @ HT. 2.0
	24 SS WALL LIGHT SWITCH SWITCHES FOR CEILING LIGHTS, TELEPHONE, 24 AC SWITCH, SKIRTING LIGHT @ HT. 2.0
	24 NOS SOCKET - 1 NOS (24 SWITCH, TV COAXIAL SOCKET, LAN @ HT 4")
	SIDE WALL SPRINKLER HEAD
	PENDENT SPRINKLER HEAD
	SMOKE DETECTOR
	SKIRTING LIGHT 4x7"
	2 NOS 15A SWITCH SOCKET - 1 NOS (24 SWITCH FOR LIGHT @ HT. 2.0)
	SPIKE LIGHT
	3 x 1.5 SQMM LIGHT CONTROL CU WIRE
	3 x 1.5 SQMM 2 WAY LIGHT CONTROL WIRE
	3 x 2.5 SQMM CU WIRE FOR AC (DU)
	3 x 4.0 SQMM CU WIRE FOR POWER CIRCUIT
	3 x 2.5 SQMM CU WIRE FOR LIGHT CIRCUIT
	CAT5 LAN WIRE RJ45 JACK TO LAN SWITCH
	2 PAIR TELEPHONE WIRE RJ11 JACK TO TTE
	RDS TV CABLE SETUP BOX TO TV SPLITTER
	CAT5 COAXIAL CABLE COAXIAL CAMERA TO NVR

PROJECT-
PROPOSED STUDIO APARTMENT

CLIENT-
CORAL GROUP

DESIGN TITLE-
ELECTRICAL LAYOUT - 4TH FLOOR

DRAWING NO.: _____ **SCALE:**
N.T.S.

DEALT BY - VISHNU KUMAWAT **CHECKED BY -** _____

DATE: 13-09-2025 **NORTH:**

MEP-


A-8, PATH NO. 4, JAMUNA NAGAR,
SODALA, JAIPUR-302008,
MAIL: - cubemep@gmail.com,
Ph. No. 0141 2221089
Mob. No. +91 9214308430

ARCHITECT-

avighna associates
- ARCHITECTS, INTERIOR DESIGNERS & PLANNERS -
Studio: 2nd floor block 2 office no 203, Vidyapeeth, Indira Nagar,
221012, U.P.
Phone: 9443332295
Email: avighna@avighnaassociates.com



Avighna Associates
Architects, Interior
Designers & Planners
Varanasi

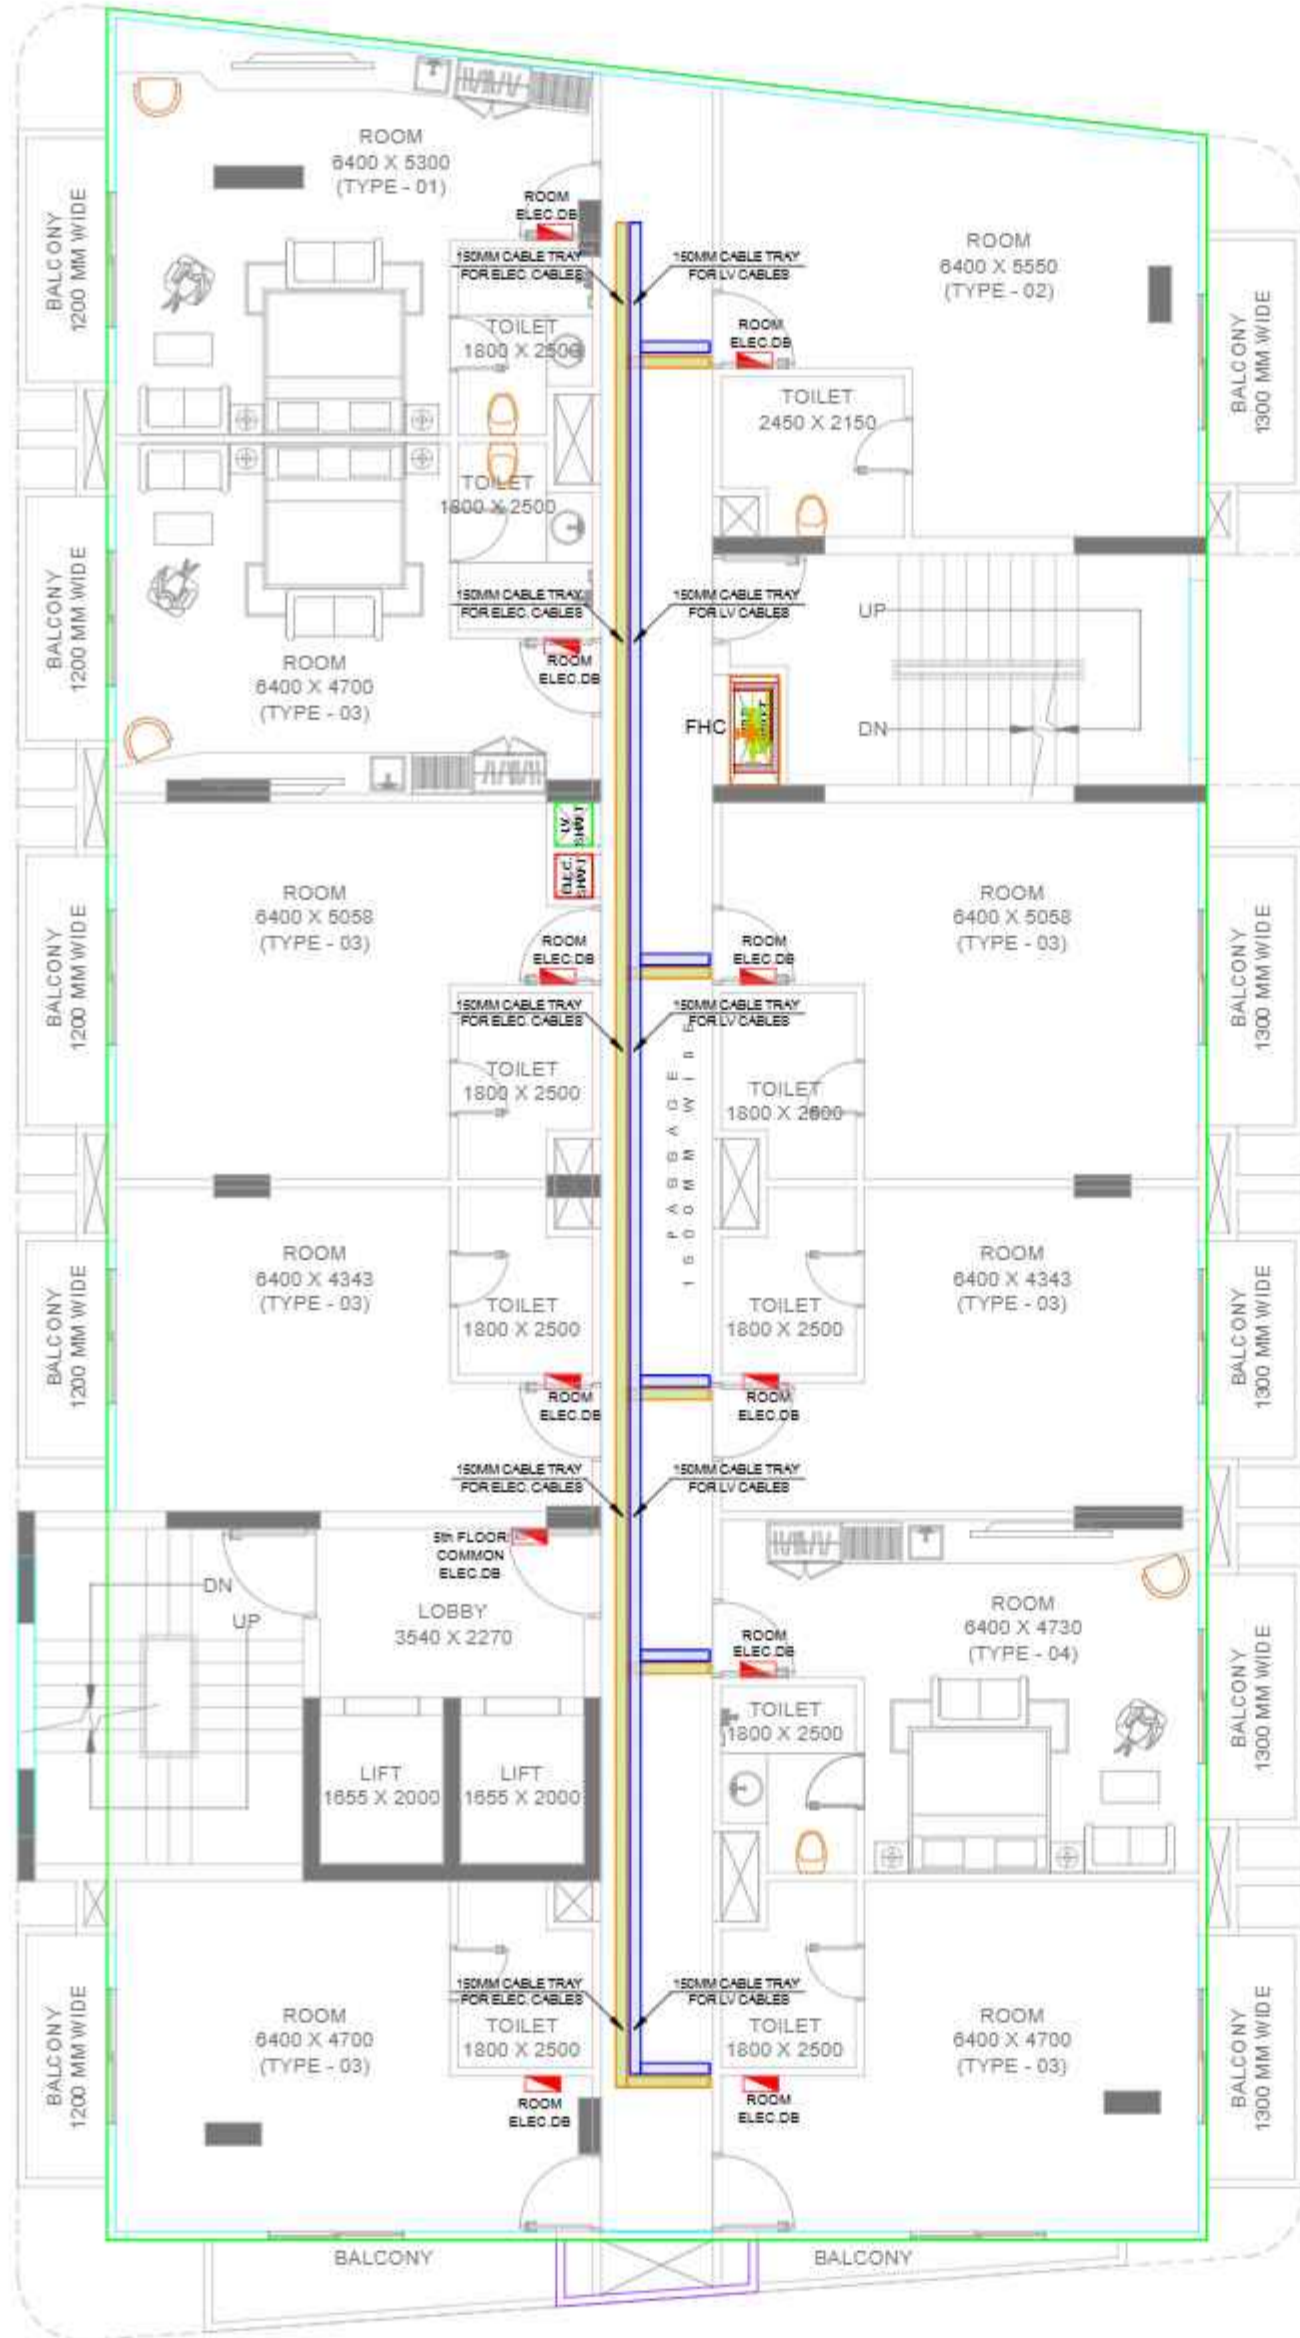

General Notes

1. THIS DRAWING IS ONLY FOR PRESENTATION PURPOSE.
2. THIS DRAWING AND DESIGN IS CREATED BY AVIGHNA STUDIO. NO PORTION MAY BE USED OR REPRODUCED WITHOUT THEIR WRITTEN PERMISSION.
3. ARCHITECT MUST BE INFORMED OF ANY ADDITIONAL INFORMATION REQUIRED OR IN CASE OF ANY DISCREPANCY.
4. THIS DRAWING IS TO BE READ IN CONJUNCTION WITH THE DESIGNERS SPECIFICATIONS AND CONDITIONS OF CONTRACT.
5. ALL DIMENSIONS ARE IN MM U.N.O.
6. ALL DIMENSIONS ARE TO BE READ NOT SCALED.

SYMBOL	DESCRIPTION
[Symbol]	DISTRIBUTION BOX
[Symbol]	SWITCH BOARD (5A SOCKET & SWITCHES)
[Symbol]	15A SOCKET WITH SWITCH
[Symbol]	5A POWER SOCKET WITH SWITCH
[Symbol]	BELL PUSH ON/OFF
[Symbol]	CEILING EXHAUST FAN
[Symbol]	5P/1T AC
[Symbol]	TOILET MIRROR LIGHT 1x15w
[Symbol]	KEY TAG 4x7"
[Symbol]	TELEPHONE AS PER FURNITURE LAYOUT
[Symbol]	CEILING LIGHT
[Symbol]	POLE LIGHT
[Symbol]	WALL BRACKET LED LIGHT 4x7"
[Symbol]	1x14 W MIRROR LIGHT 7x7"
[Symbol]	5A 5S/WALL LIGHT SWITCH USE CHARGING TYPE C CHARGING SWITCH FOR CEILING LIGHT @T. 20
[Symbol]	5A 5S/WALL LIGHT SWITCH SWITCHES FOR CEILING LIGHTS, TELEPHONE, 5A AC SWITCH, SKIRTING LIGHT @T. 20
[Symbol]	5A 2NBS SOCKET 4-NBS (5A SWITCH, TV COAXIAL SOCKET, LAN @T. 40"
[Symbol]	SIDE WALL SPRINKLER HEAD
[Symbol]	PENDENT SPRINKLER HEAD
[Symbol]	SMOKE DETECTOR
[Symbol]	SKIRTING LIGHT 4x7"
[Symbol]	2NBS 15A SWITCH SOCKET 4-NBS 5A SWITCH FOR LIGHT @T. 30"
[Symbol]	SPIKE LIGHT
[Symbol]	3x1.5 SQMM LIGHT CONTROL CU WIRE
[Symbol]	3x1.5 SQMM 2 WAY LIGHT CONTROL WIRE
[Symbol]	3x2.5 SQMM CU WIRE FOR AC (DU)
[Symbol]	3x4.0 SQMM CU WIRE FOR POWER CIRCUIT
[Symbol]	3x2.5 SQMM CU WIRE FOR LIGHT CIRCUIT
[Symbol]	CAT5 LAN WIRE RJ45 JACK TO LAN SWITCH
[Symbol]	2 PAIR TELEPHONE WIRE RJ11 JACK TO TTE
[Symbol]	RGN TV CABLE SETUP BOX TO TV SPLITTER
[Symbol]	CAT5 COAXIAL CABLE COAXIAL CAMERA TO NVR

**PROJECT-
PROPOSED STUDIO APARTMENT**

**CLIENT-
CORAL GROUP**

**DESIGN TITLE-
ELECTRICAL LAYOUT - 5TH FLOOR**

DRAWING NO: _____ SCALE: **N.T.S.**

DEALT BY: **VISHNU KUMAWAT** CHECKED BY: _____

DATE: **13-09-2025** NORTH:

MEP-

 A-8, PATH NO. 4, JAMUNA NAGAR, SODALA, JAIPUR-302008,
 MAIL: - cubemep@gmail.com,
 Ph. No. 0141 2221089
 Mob. No. +91 9214308430

ARCHITECT-

avighna associates
 ARCHITECTS, INTERIOR DESIGNERS & PLANNERS
 Studio: 2nd floor block 2 office no 203, Vidyapeeth, Indira Nagar,
 221012, U.P.
 Phone: 9443332295
 Email: avighna@avighnaassociates.com

Handwritten signature

Avighna Associates
 Architects, Interior Designers & Planners
 Varanasi

General Notes

1. THIS DRAWING IS ONLY FOR PRESENTATION PURPOSE.
2. THIS DRAWING AND DESIGN IS CREATED BY AVIGHNA STUDIO. NO PORTION MAY BE USED OR REPRODUCED WITHOUT THEIR WRITTEN PERMISSION.
3. ARCHITECT MUST BE INFORMED OF ANY ADDITIONAL INFORMATION REQUIRED OR IN CASE OF ANY DISCREPANCY.
4. THIS DRAWING IS TO BE READ IN CONJUNCTION WITH THE DESIGNERS SPECIFICATIONS AND CONDITIONS OF CONTRACT.
5. ALL DIMENSIONS ARE IN MM U.N.O.
6. ALL DIMENSIONS ARE TO BE READ NOT SCALED.

SYMBOL	DESCRIPTION
	DISTRIBUTION BOX
	SWITCH BOARD (54 SOCKET & SWITCHES)
	15A SOCKET WITH SWITCH
	24 POWER SOCKET WITH SWITCH
	BELL PUSH ON (MIR)
	CEILING EXHAUST FAN
	SPLIT AC
	TOILET MIRROR LIGHT 1x18w
	KEY TAG 4x4"
	TELEPHONE AS PER FURNITURE LAYOUT
	CEILING LIGHT
	POLE LIGHT
	WALL BRACKET LED LIGHT 4x4"
	1x14 W MIRROR LIGHT 7x7"
	24 SS WALL LIGHT SWITCH USE CHARGING TYPE C CHARGING SWITCH FOR CEILING LIGHT @T. 20
	24 SS WALL LIGHT SWITCH SWITCHES FOR CEILING LIGHTS, TELEPHONE, 23A AC SWITCH, SKIRTING LIGHT @T. 20
	24 NOE SOCKET 4-NOE (24 SWITCH, TV COAXIAL SOCKET, LAN @T. 40"
	SIDE WALL SPRINKLER HEAD
	PENDENT SPRINKLER HEAD
	SMOKE DETECTOR
	SKIRTING LIGHT 4x4"
	2 NOE 15A SWITCH SOCKET 4-NOE (24 SWITCH FOR LIGHT @T. 30"
	SPIKE LIGHT
	3x1.5 SQMM LIGHT CONTROL CU WIRE
	3x1.5 SQMM 2 WAY LIGHT CONTROL WIRE
	3x2.5 SQMM CU WIRE FOR AC (DU)
	3x4.0 SQMM CU WIRE FOR POWER CIRCUIT
	3x2.5 SQMM CU WIRE FOR LIGHT CIRCUIT
	CAT5 LAN WIRE RJ45 JACK TO LAN SWITCH
	2 PAIR TELEPHONE WIRE RJ11 JACK TO TTE
	RIS TV CABLE SETUP BOX TO TV SPLITTER
	CAT5 CCTV CABLE CCTV CAMERA TO NVR

PROJECT-
PROPOSED STUDIO APARTMENT

CLIENT-
CORAL GROUP

DESIGN TITLE-
ELECTRICAL LAYOUT - 6TH FLOOR

DRAWING NO.: _____ **SCALE:**
N.T.S.

DEALT BY - VISHNU KUMAWAT **CHECKED BY -** _____


DATE: 13-09-2025 **NORTH:**

MEP-

A-8, PATH NO. 4, JAMUNA NAGAR,
SODALA, JAIPUR-302008,
MAIL: - cubemep@gmail.com,
Ph. No. 0141 2221089
Mob. No. +91 9214308430


ARCHITECT-

avighna associates
ARCHITECTS, INTERIOR DESIGNERS & PLANNERS
Studio: 2nd floor block 2 office no 203, Vidyapeeth, Indira Nagar,
221012, U.P.
Phone: 9443332295
Email: avighna@avighnaassociates.com

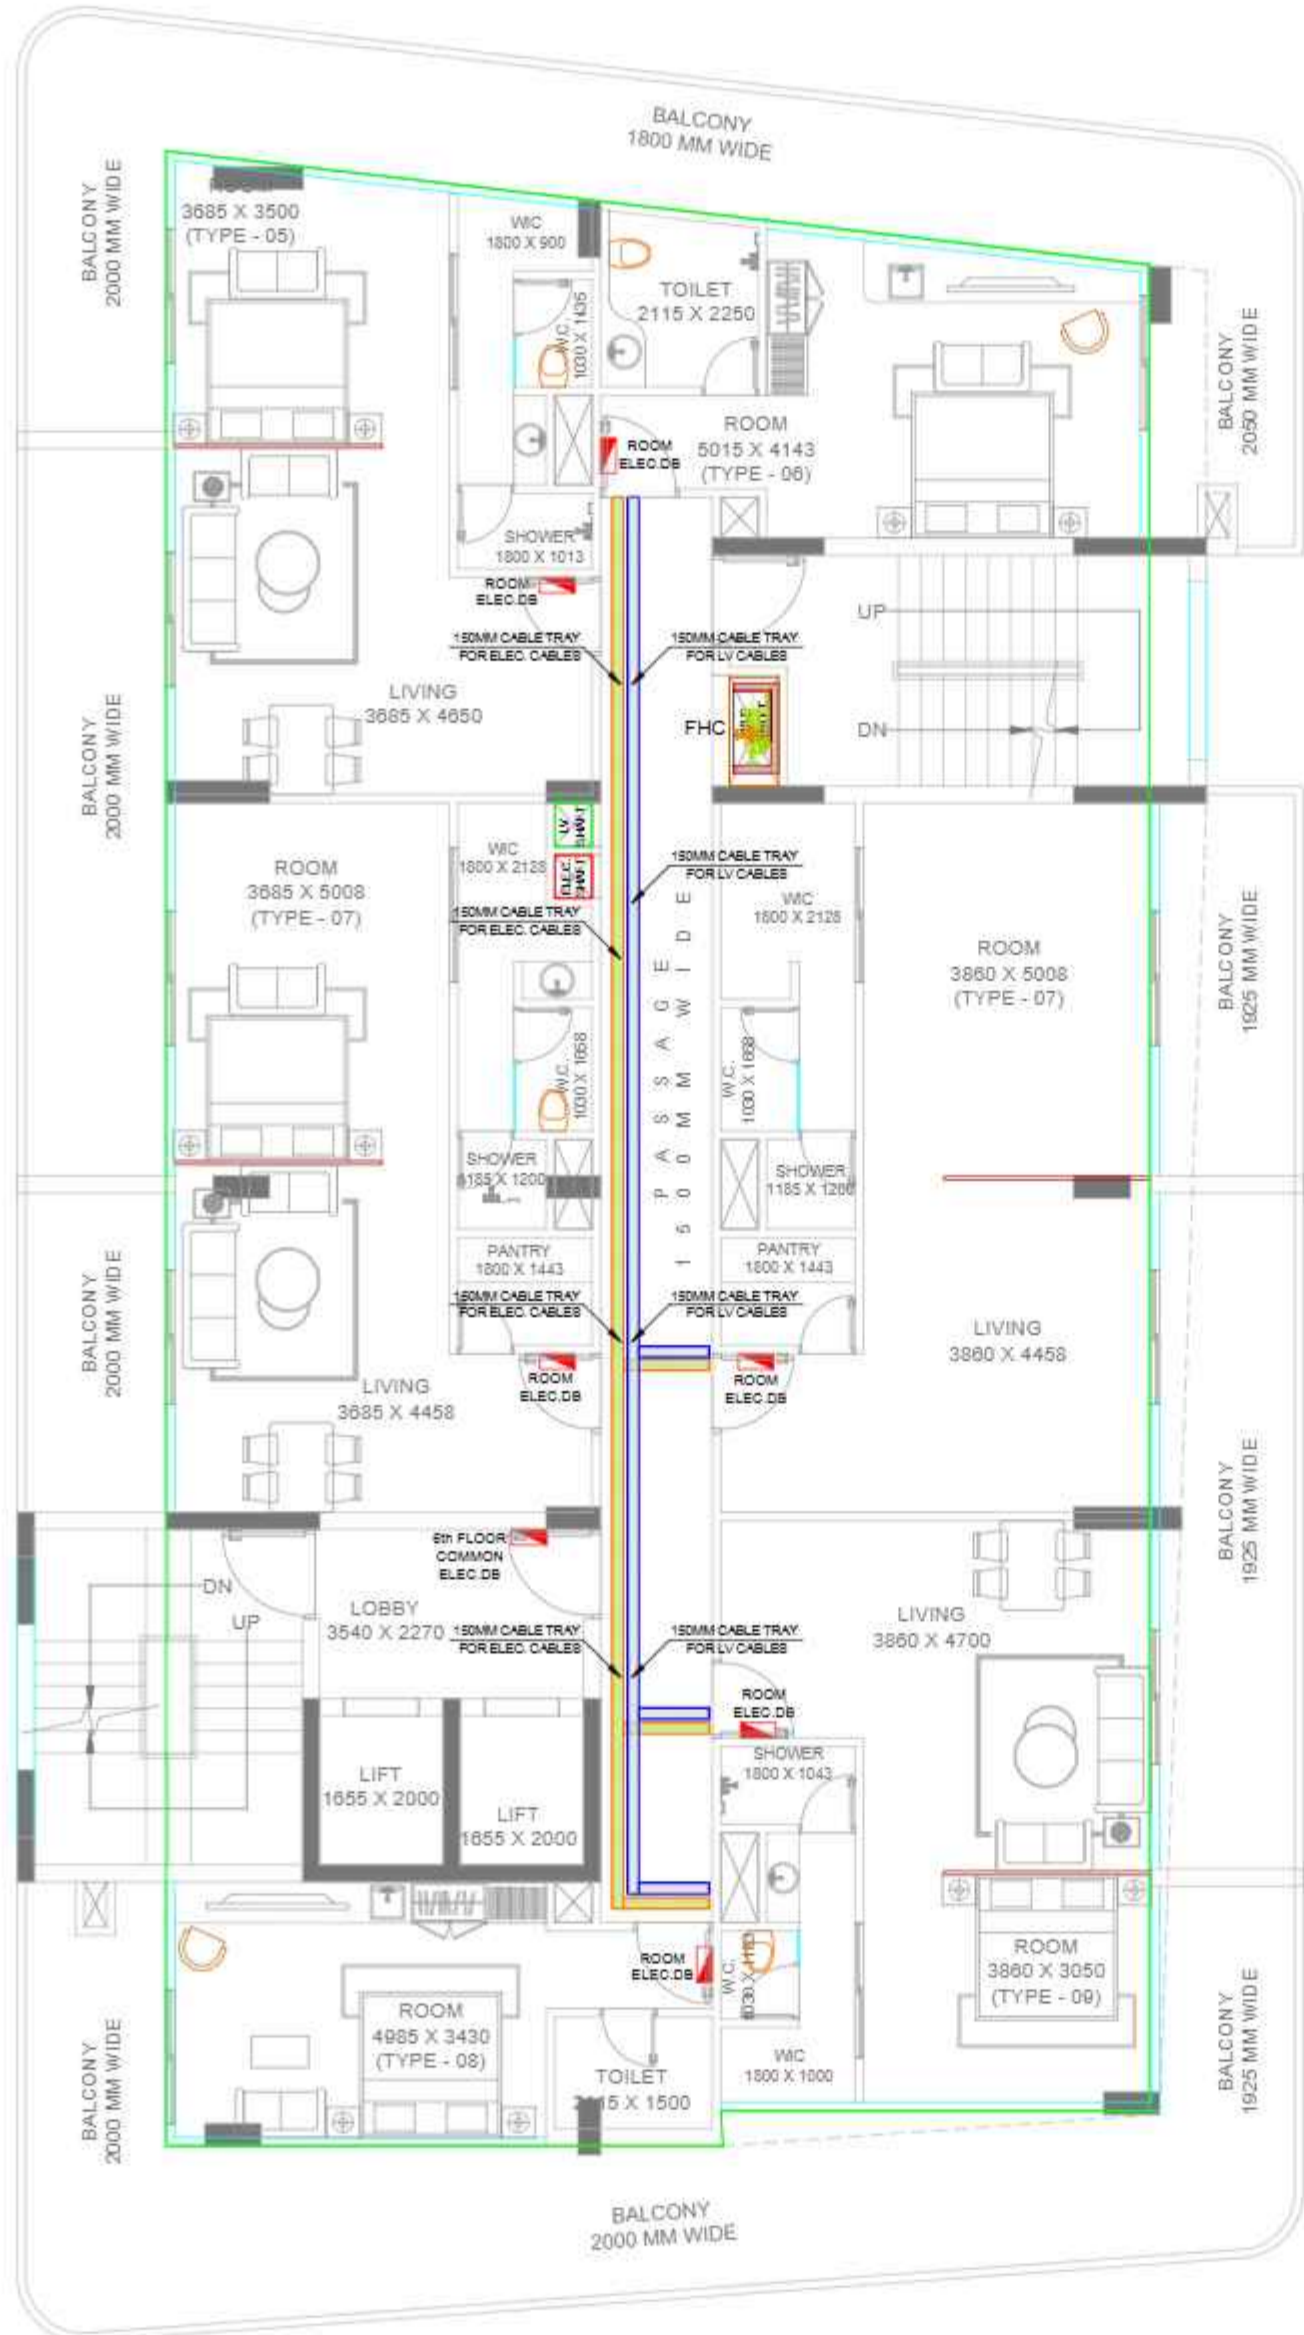

Handwritten signature

Avighna Associates
Architects, Interior Designers & Planners
Varanasi

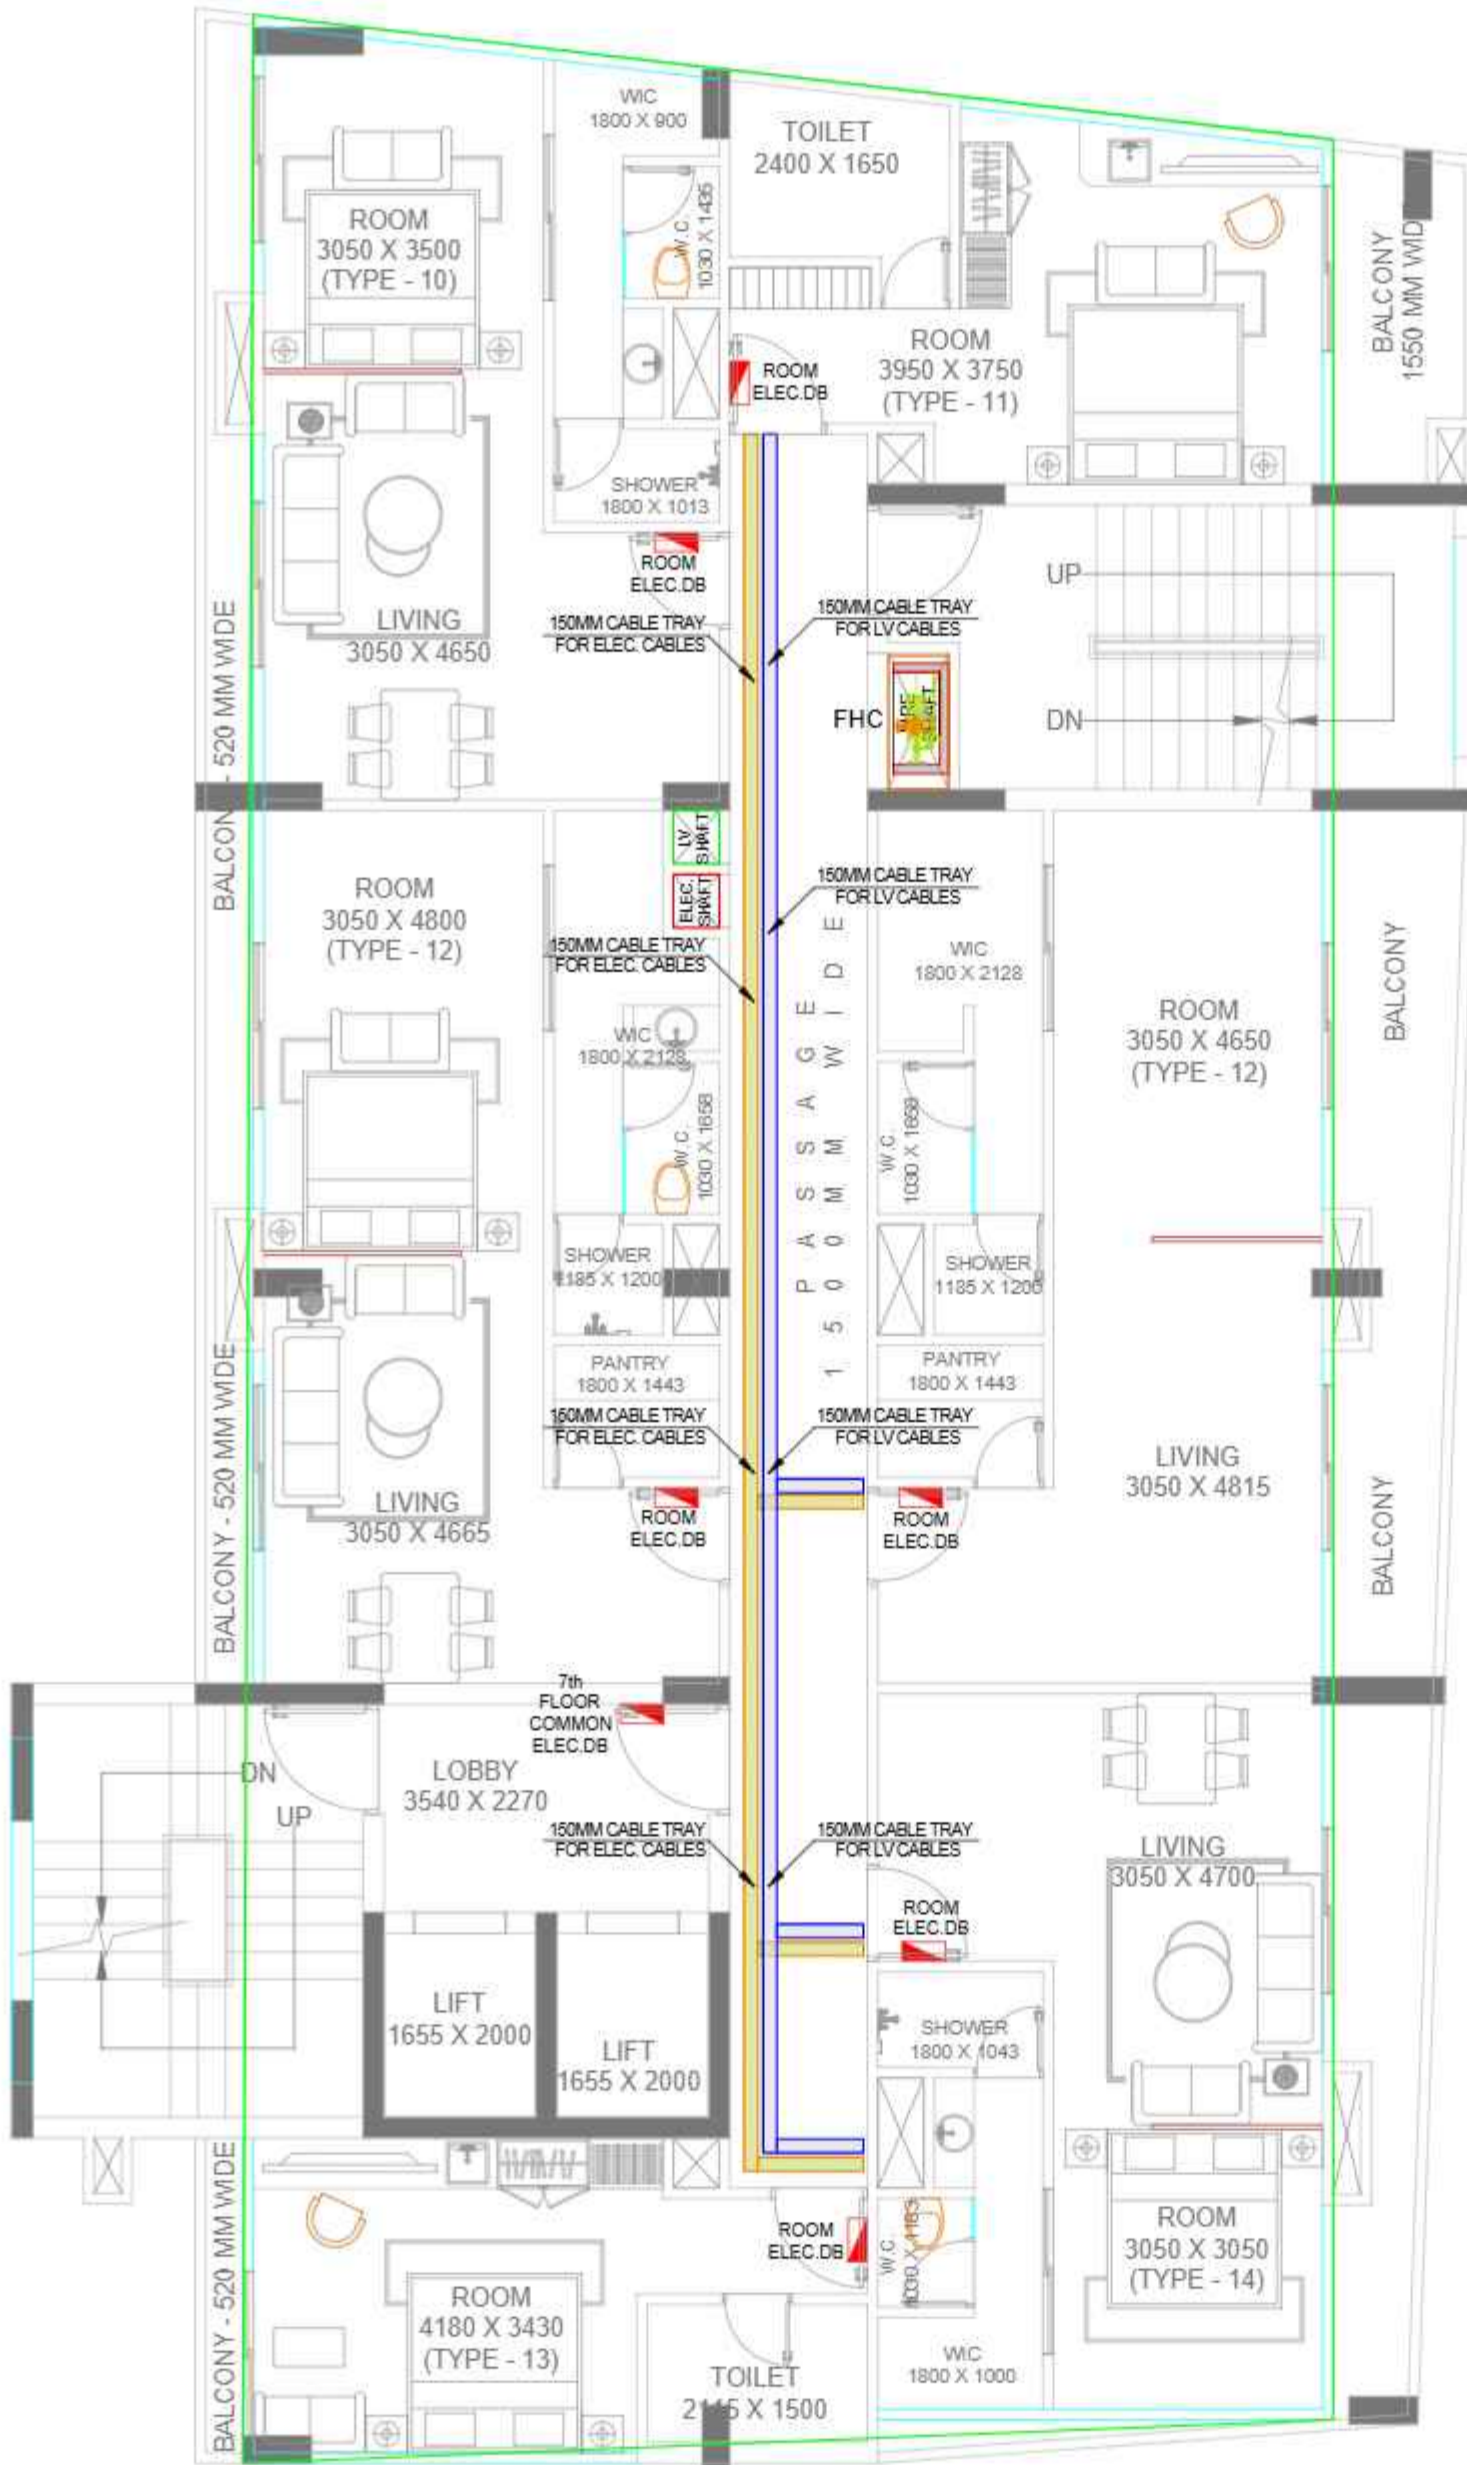

General Notes

1. THIS DRAWING IS ONLY FOR PRESENTATION PURPOSE.
2. THIS DRAWING AND DESIGN IS CREATED BY AVIGHNA STUDIO. NO PORTION MAY BE USED OR REPRODUCED WITHOUT THEIR WRITTEN PERMISSION.
3. ARCHITECT MUST BE INFORMED OF ANY ADDITIONAL INFORMATION REQUIRED OR IN CASE OF ANY DISCREPANCY.
4. THIS DRAWING IS TO BE READ IN CONJUNCTION WITH THE DESIGNERS SPECIFICATIONS AND CONDITIONS OF CONTRACT.
5. ALL DIMENSIONS ARE IN MM U.N.O.
6. ALL DIMENSIONS ARE TO BE READ NOT SCALED.

SYMBOL	DESCRIPTION
[Symbol]	DISTRIBUTION BOX
[Symbol]	SWITCH BOARD (24 SOCKET & SWITCHES)
[Symbol]	15A SOCKET WITH SWITCH
[Symbol]	24 POWER SOCKET WITH SWITCH
[Symbol]	BELL PUSH ON/OFF
[Symbol]	CEILING EXHAUST FAN
[Symbol]	24V AC
[Symbol]	TOILET MIRROR LIGHT 1x12w
[Symbol]	KEY TAG 4x2"
[Symbol]	TELEPHONE AS PER FURNITURE LAYOUT
[Symbol]	CEILING LIGHT
[Symbol]	POLE LIGHT
[Symbol]	WALL BRACKET LED LIGHT 4x2"
[Symbol]	1 x 14 W MIRROR LIGHT 7x7"
[Symbol]	24V WALL LIGHT SWITCH USE CHARGING TYPE C CHARGING SWITCH FOR CEILING LIGHT @ HT. 2.0
[Symbol]	24V WALL LIGHT SWITCH SWITCH FOR CEILING LIGHTS, TELEPHONE, 24V AC SWITCH, SKIRTING LIGHT @ HT. 2.0
[Symbol]	24V SOCKET - 1 NO. (24V SWITCH, TV COAXIAL SOCKET, LAN @ HT 4.0)
[Symbol]	SIDE WALL SPRINKLER HEAD
[Symbol]	PENDENT SPRINKLER HEAD
[Symbol]	SMOKE DETECTOR
[Symbol]	SKIRTING LIGHT 4x2"
[Symbol]	2 NO. 15A SWITCH SOCKET - 1 NO. 24V SWITCH FOR LIGHT @ HT. 2.0
[Symbol]	SPIKE LIGHT
[Symbol]	3 x 1.5 SQMM LIGHT CONTROL CU WIRE
[Symbol]	3 x 1.5 SQMM 2 WAY LIGHT CONTROL WIRE
[Symbol]	3 x 2.5 SQMM CU WIRE FOR AC IDU
[Symbol]	3 x 4.0 SQMM CU WIRE FOR POWER CIRCUIT
[Symbol]	3 x 2.5 SQMM CU WIRE FOR LIGHT CIRCUIT
[Symbol]	CAT5 LAN WIRE RJ45 JACK TO LAN SWITCH
[Symbol]	2 PAIR TELEPHONE WIRE RJ11 JACK TO TTE
[Symbol]	RGB TV CABLE SETUP BOX TO TV SPLITTER
[Symbol]	CAT5 CCTV CABLE CCTV CAMERA TO NVR

PROJECT-
PROPOSED STUDIO APARTMENT

CLIENT-
CORAL GROUP

DESIGN TITLE-
ELECTRICAL LAYOUT - 7TH FLOOR

DRAWING NO.: SCALE:
N.T.S.

DEALT BY - CHECKED BY -
VISHNU KUMAWAT


DATE: 13-09-2025 **NORTH:** [North Arrow]

MEP-
cube consultant
A-8, PATH NO. 4, JAMUNA NAGAR,
SODALA, JAIPUR-302008,
MAIL: - cubemep@gmail.com,
Ph. No. 0141 2221089
Mob. No. +91 9214308430

ARCHITECT-
avighna associates
ARCHITECTS, INTERIOR DESIGNERS & PLANNERS -
Studio: 2nd floor block 2 office no 203, Vidyapeeth, Varanasi, India
+91 522 221 010, U.P.
Phone: 9453332295
Email: avighna@avighnaassociates.com



Avighna Associates
Architects, Interior
Designers & Planners
Varanasi

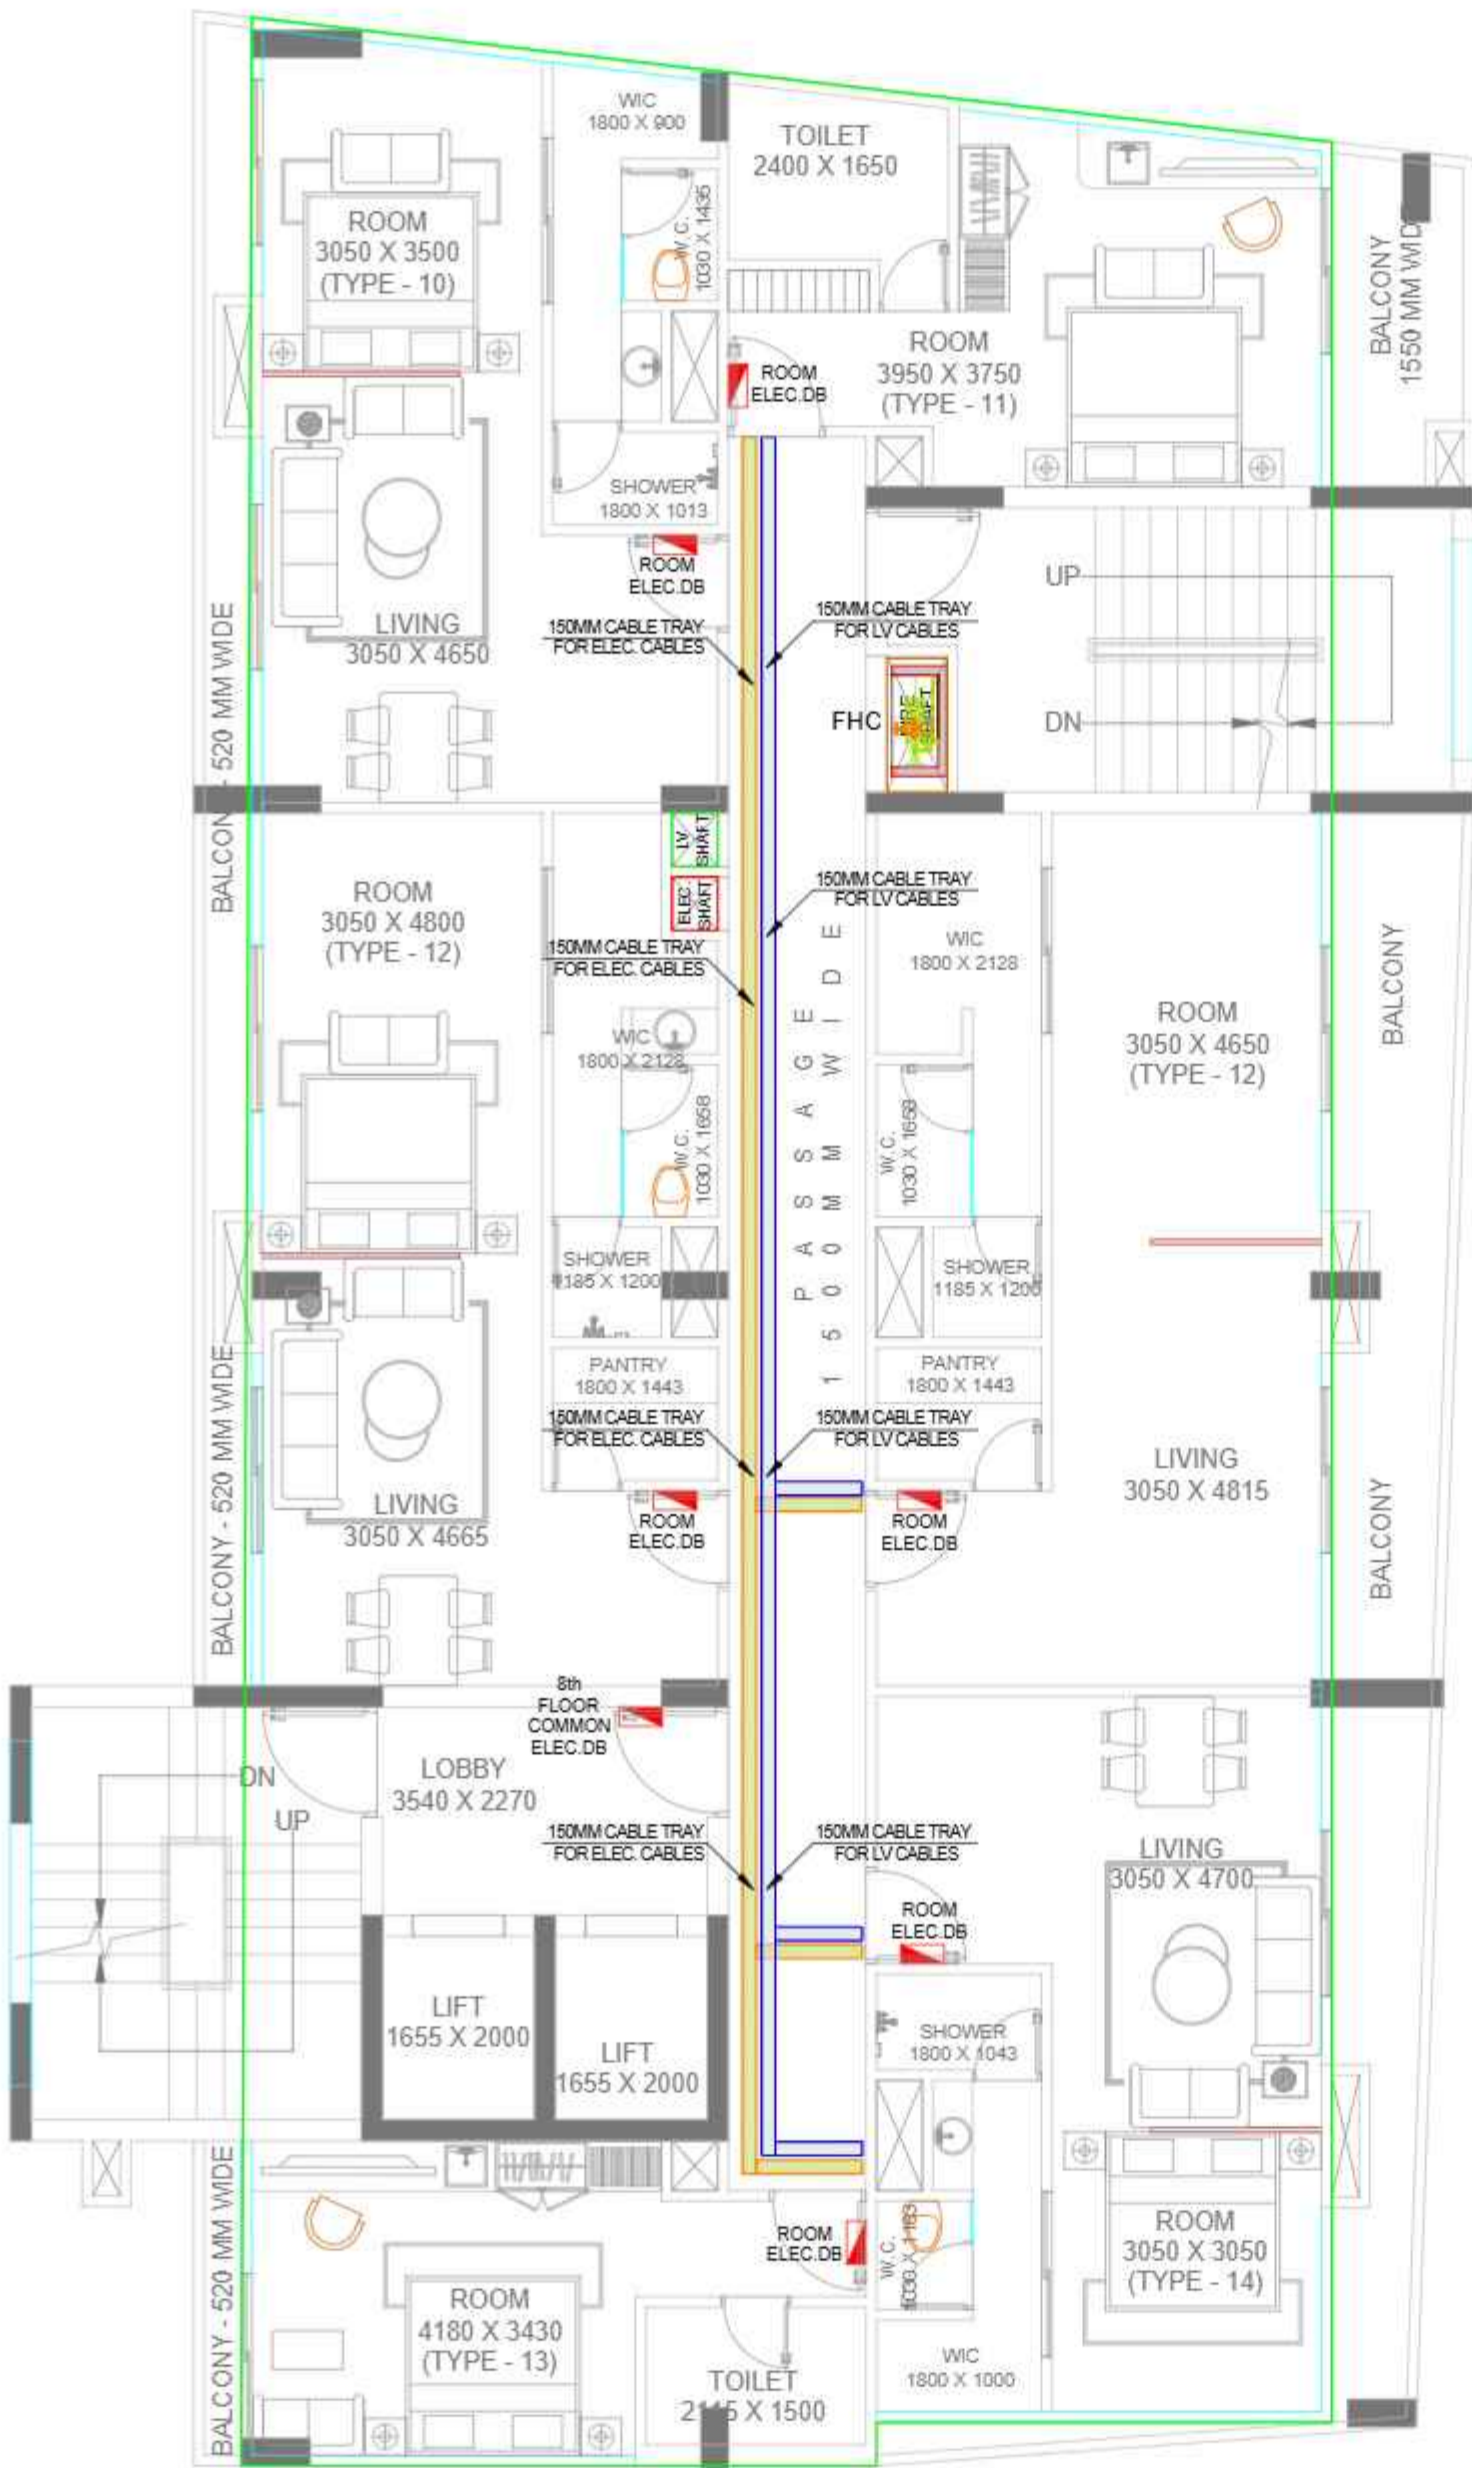

General Notes

1. THIS DRAWING IS ONLY FOR PRESENTATION PURPOSE.
2. THIS DRAWING AND DESIGN IS CREATED BY AVIGHNA STUDIO. NO PORTION MAY BE USED OR REPRODUCED WITHOUT THEIR WRITTEN PERMISSION.
3. ARCHITECT MUST BE INFORMED OF ANY ADDITIONAL INFORMATION REQUIRED OR IN CASE OF ANY DISCREPANCY.
4. THIS DRAWING IS TO BE READ IN CONJUNCTION WITH THE DESIGNERS SPECIFICATIONS AND CONDITIONS OF CONTRACT.
5. ALL DIMENSIONS ARE IN MM U.N.O.
6. ALL DIMENSIONS ARE TO BE READ NOT SCALED.

SYMBOL	DESCRIPTION
[Symbol]	DISTRIBUTION BOX
[Symbol]	SWITCH BOARD (24 SOCKET & SWITCHES)
[Symbol]	15 A SOCKET WITH SWITCH
[Symbol]	24 POWER SOCKET WITH SWITCH
[Symbol]	BELL PUSH ON/OFF
[Symbol]	CEILING EXHAUST FAN
[Symbol]	8P/1T AC
[Symbol]	TOILET MIRROR LIGHT 1x12w
[Symbol]	KEY TAG 4x7"
[Symbol]	TELEPHONE AS PER FURNITURE LAYOUT
[Symbol]	CEILING LIGHT
[Symbol]	POLE LIGHT
[Symbol]	WALL BRACKET LED LIGHT 4x7"
[Symbol]	1 x 14 W MIRROR LIGHT 7x7"
[Symbol]	24 SS WALL LIGHT SWITCH USE CHARGING TYPE C CHARGING SWITCH FOR CEILING LIGHT @ HT. 2.0
[Symbol]	24 SS WALL LIGHT SWITCH SWITCH FOR CEILING LIGHTS, TELEPHONE, 24 AC SWITCH SKIRTING LIGHT @ HT. 2.0
[Symbol]	24 NOS SOCKET - 1 NOS 15A SWITCH, TV COAXIAL SOCKET, LAN @ HT 4"
[Symbol]	SIDE WALL SPRINKLER HEAD
[Symbol]	PENDENT SPRINKLER HEAD
[Symbol]	SMOKE DETECTOR
[Symbol]	SKIRTING LIGHT 4x7"
[Symbol]	2 NOS 15A SWITCH SOCKET - 1 NOS 24 SWITCH FOR LIGHT @ HT 2.0
[Symbol]	SPIKE LIGHT
[Symbol]	3 x 1.5 SQMM LIGHT CONTROL CU WIRE
[Symbol]	3 x 1.5 SQMM 2 WAY LIGHT CONTROL WIRE
[Symbol]	3 x 2.5 SQMM CU WIRE FOR AC (DU)
[Symbol]	3 x 4.0 SQMM CU WIRE FOR POWER CIRCUIT
[Symbol]	3 x 2.5 SQMM CU WIRE FOR LIGHT CIRCUIT
[Symbol]	CAT6 LAN WIRE RJ45 JACK TO LAN SWITCH
[Symbol]	2 PAIR TELEPHONE WIRE RJ11 JACK TO TTE
[Symbol]	RDS TV CABLE SETUP BOX TO TV SPLITTER
[Symbol]	CAT6 COAXIAL CABLE COAXIAL CAMERA TO NVR

**PROJECT-
PROPOSED STUDIO APARTMENT**

**CLIENT-
CORAL GROUP**

**DESIGN TITLE-
ELECTRICAL LAYOUT - 8TH FLOOR**

DRAWING NO: _____ SCALE: **N.T.S.**

DEALT BY: **VISHNU KUMAWAT** CHECKED BY: _____

DATE: **13-09-2025** NORTH:

MEP-


 A-8, PATH NO. 4, JAMUNA NAGAR, SODALA, JAIPUR-302008, MAIL: - cubemep@gmail.com, Ph. No. 0141 2221089, Mob. No. +91 9214308430.

ARCHITECT-

avighna associates
 ARCHITECTS, INTERIOR DESIGNERS & PLANNERS
 Studio: 2nd floor block 2 office no 203, Vidyapeeth, Indira Nagar, Varanasi, U.P.
 Phone: 9453332295
 Email: avighna@avighnaassociates.com

Handwritten signature

Avighna Associates
 Architects, Interior Designers & Planners
 Varanasi

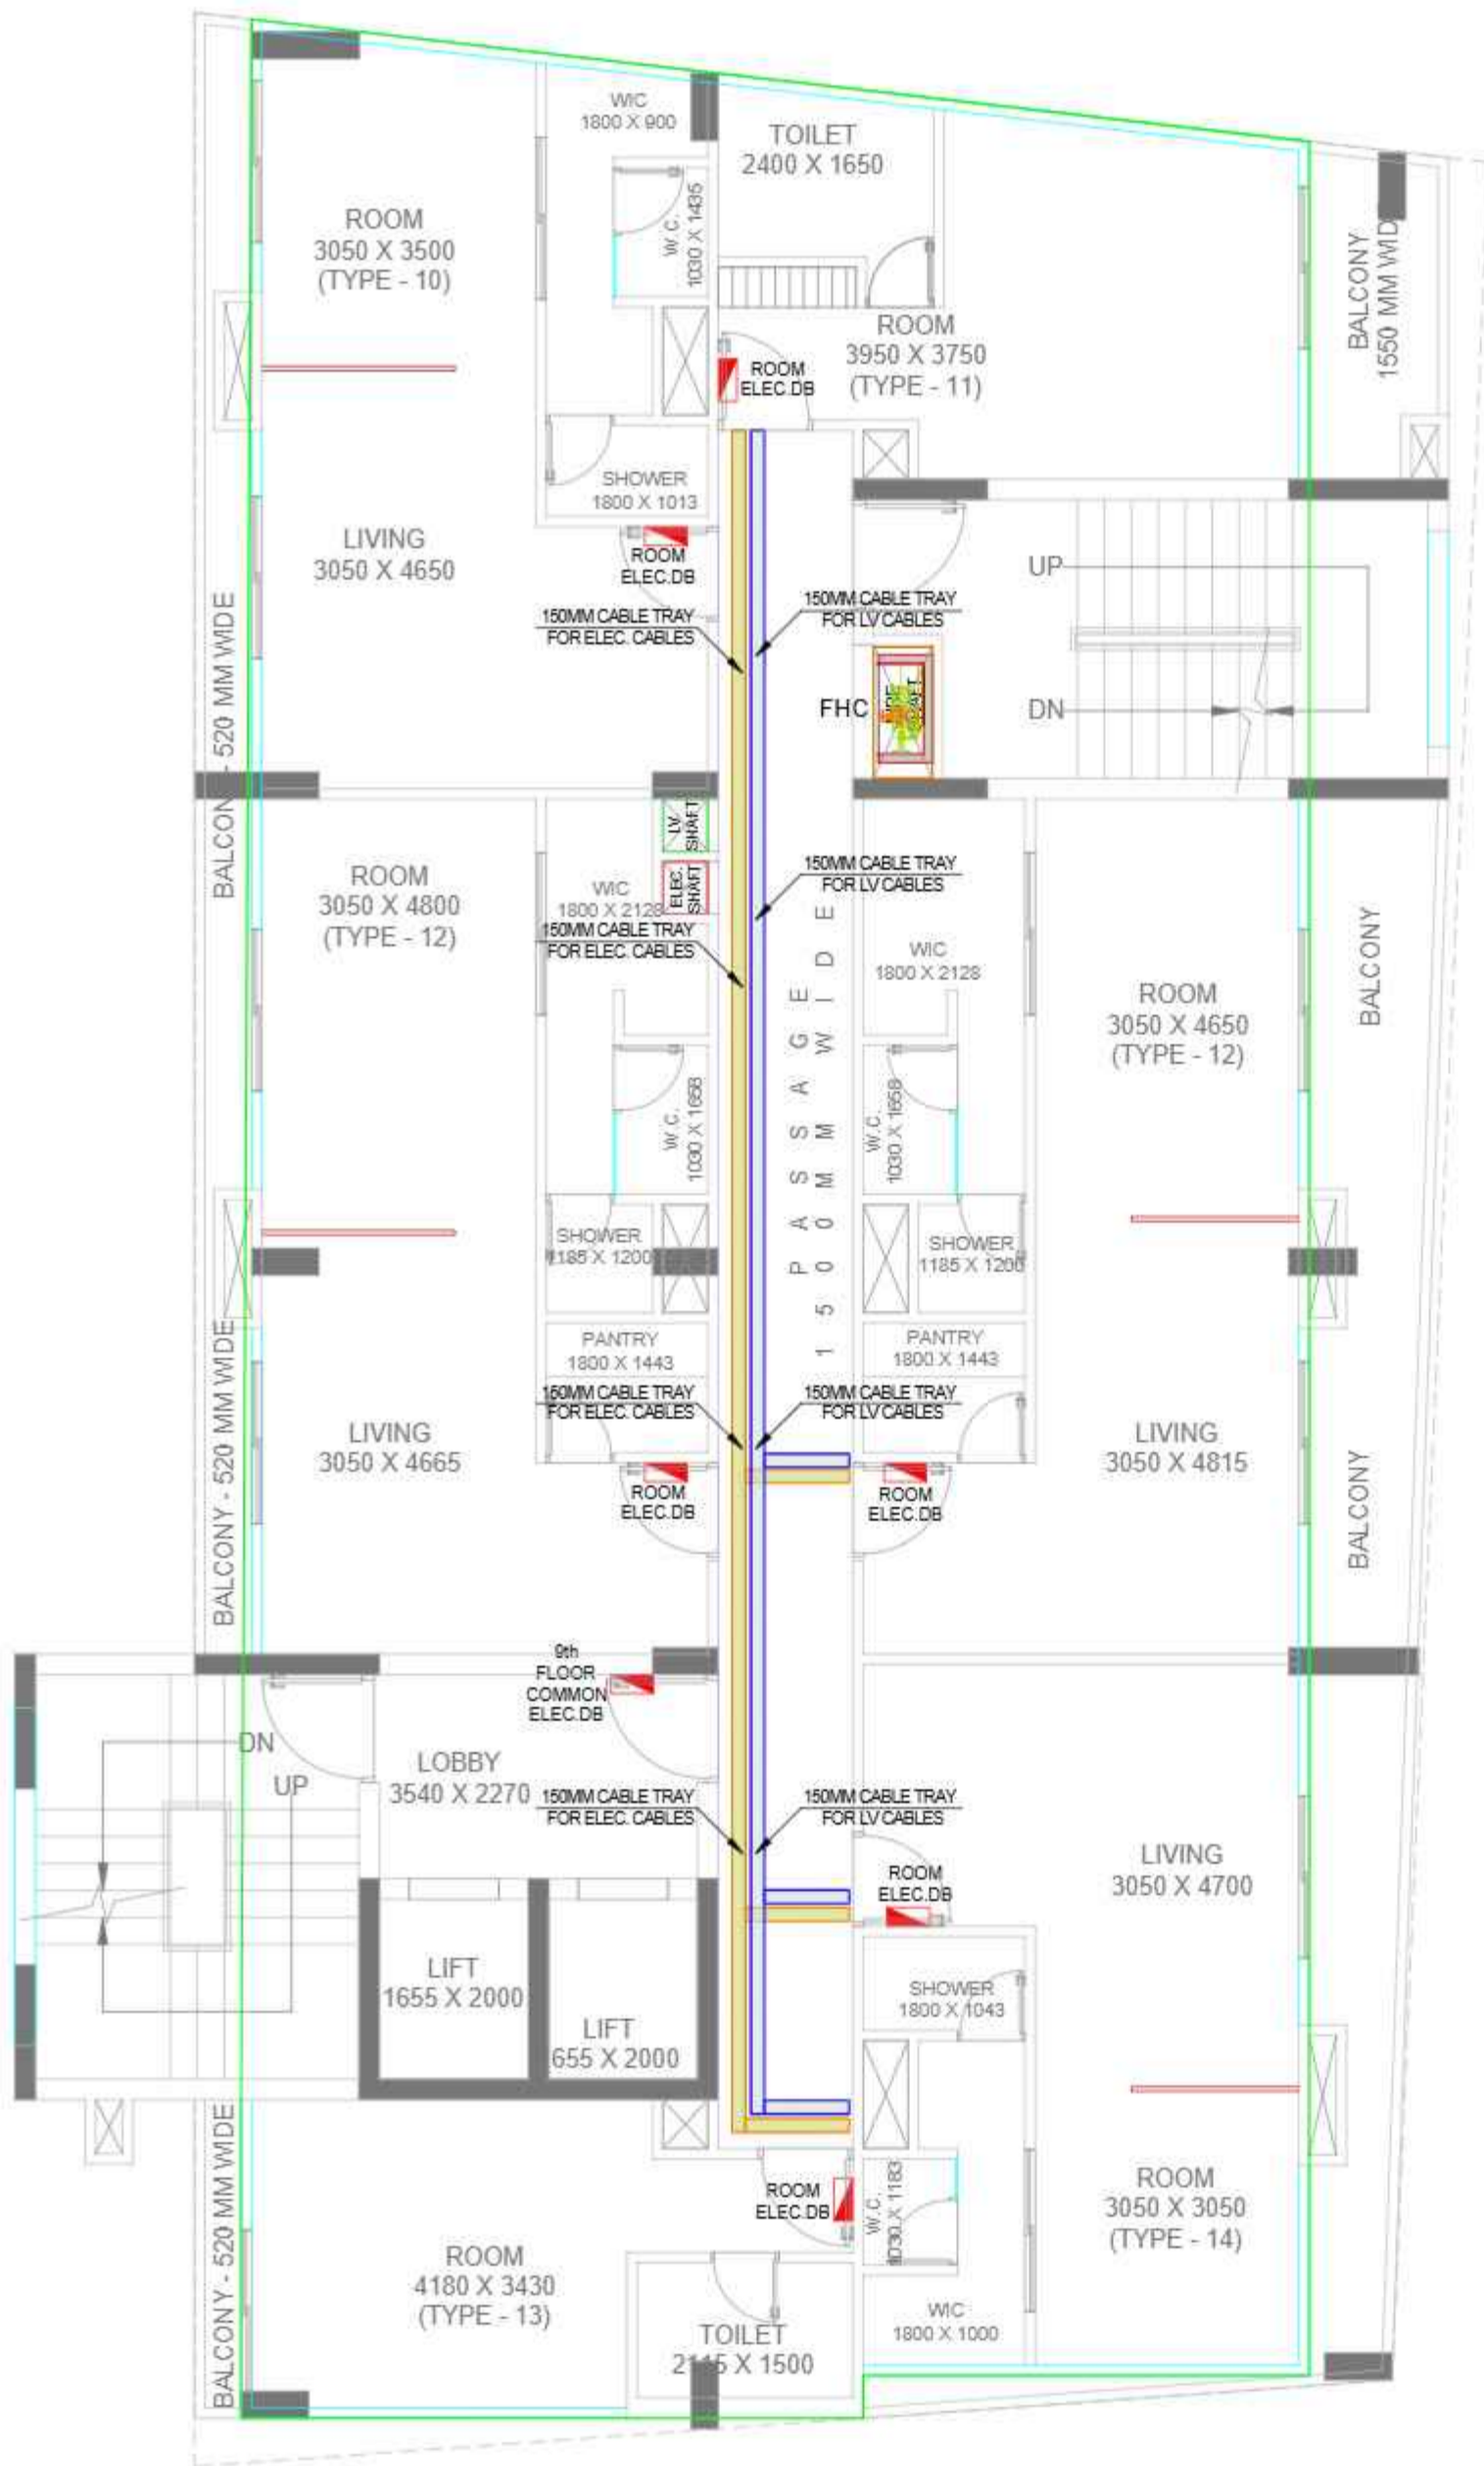

General Notes

1. THIS DRAWING IS ONLY FOR PRESENTATION PURPOSE.
2. THIS DRAWING AND DESIGN IS CREATED BY AVIGNA STUDIO. NO PORTION MAY BE USED OR REPRODUCED WITHOUT THEIR WRITTEN PERMISSION.
3. ARCHITECT MUST BE INFORMED OF ANY ADDITIONAL INFORMATION REQUIRED OR IN CASE OF ANY DISCREPANCY.
4. THIS DRAWING IS TO BE READ IN CONJUNCTION WITH THE DESIGNERS SPECIFICATIONS AND CONDITIONS OF CONTRACT.
5. ALL DIMENSIONS ARE IN MM U.N.O.
6. ALL DIMENSIONS ARE TO BE READ NOT SCALED.

SYMBOL	DESCRIPTION
[Symbol]	DISTRIBUTION BOX
[Symbol]	SWITCH BOARD (54 SOCKET & SWITCHES)
[Symbol]	15 A SOCKET WITH SWITCH
[Symbol]	24 POWER SOCKET WITH SWITCH
[Symbol]	BELL PUSH ONE WAY
[Symbol]	CEILING EXHAUST FAN
[Symbol]	SPLIT AC
[Symbol]	TOILET MIRROR LIGHT 1x12w
[Symbol]	KEY TAG 4x0"
[Symbol]	TELEPHONE AS PER FURNITURE LAYOUT
[Symbol]	CEILING LIGHT
[Symbol]	POLE LIGHT
[Symbol]	WALL BRACKET LED LIGHT 4x0"
[Symbol]	1 x 14 W MIRROR LIGHT 7x0"
[Symbol]	24 SS WALL LIGHT SWITCH USE CHARGING TYPE C CHARGING SWITCH FOR CEILING LIGHT @T. 20
[Symbol]	24 SS WALL LIGHT SWITCH (SWITCH FOR CEILING LIGHTS, TELEPHONE, 234 AC SWITCH, SKIRTING LIGHT @T. 20)
[Symbol]	24 INCH SOCKET - 1 NOS (24 SWITCH, TV COAXIAL SOCKET, LAN @T. 40)
[Symbol]	SIDE WALL SPRINKLER HEAD
[Symbol]	PENDENT SPRINKLER HEAD
[Symbol]	SMOKE DETECTOR
[Symbol]	SKIRTING LIGHT 4x0"
[Symbol]	2 NOS 15A SWITCH SOCKET - 1 NOS (24 SWITCH FOR LIGHT @T. 30)
[Symbol]	SPIKE LIGHT
[Symbol]	3 x 1.5 SQMM LIGHT CONTROL CU WIRE
[Symbol]	3 x 1.5 SQMM 2 WAY LIGHT CONTROL WIRE
[Symbol]	3 x 2.5 SQMM CU WIRE FOR AC (DU)
[Symbol]	3 x 4.0 SQMM CU WIRE FOR POWER CIRCUIT
[Symbol]	3 x 2.5 SQMM CU WIRE FOR LIGHT CIRCUIT
[Symbol]	CAT5 LAN WIRE RJ45 JACK TO LAN SWITCH
[Symbol]	2 PAIR TELEPHONE WIRE RJ11 JACK TO TTE
[Symbol]	RDS TV CABLE SETUP BOX TO TV SPLITTER
[Symbol]	CAT5 CCTV CABLE CCTV CAMERA TO NVR

**PROJECT-
PROPOSED STUDIO APARTMENT**

**CLIENT-
CORAL GROUP**

**DESIGN TITLE-
ELECTRICAL LAYOUT - 9TH FLOOR**

DRAWING NO: SCALE:
N.T.S.

DEALT BY - CHECKED BY -
VISHNU KUMAWAT

DATE: NORTH:
13-09-2025

MEP-
cube consultant
A-8, PATH NO. 4, JAMUNA NAGAR,
SODALA, JAIPUR-302008,
MAIL - cubemep@gmail.com,
Ph. No. 0141 2221089
Mob. No. +91 9214308430

ARCHITECT-
avigna associates
ARCHITECTS, INTERIOR DESIGNERS & PLANNERS -
Studio: 2nd floor block 2 office no 203, Vidyapeeth, Indira Nagar,
221012, U.P.
Phone: 9443332295
Email: avigna@avignastudio.com

Handwritten signature
SIGRA
Avigna Associates
Architects, Interior
Designers & Planners
Varanasi



General Notes

1. THIS DRAWING IS ONLY FOR PRESENTATION PURPOSE.
2. THIS DRAWING AND DESIGN IS CREATED BY AVIGHNA STUDIO. NO PORTION MAY BE USED OR REPRODUCED WITHOUT THEIR WRITTEN PERMISSION.
3. ARCHITECT MUST BE INFORMED OF ANY ADDITIONAL INFORMATION REQUIRED OR IN CASE OF ANY DISCREPANCY.
4. THIS DRAWING IS TO BE READ IN CONJUNCTION WITH THE DESIGNERS SPECIFICATIONS AND CONDITIONS OF CONTRACT.
5. ALL DIMENSIONS ARE IN MM U.N.O.
6. ALL DIMENSIONS ARE TO BE READ NOT SCALED.

SYMBOL	DESCRIPTION
	DISTRIBUTION BOX
	SWITCH BOARD (24 SOCKET & SWITCHES)
	15A SOCKET WITH SWITCH
	24 POWER SOCKET WITH SWITCH
	BELL PUSH DOWN UNIT
	CEILING EXHAUST FAN
	SPLIT AC
	TOILET MIRROR LIGHT 1x12w
	KEY TAG 4x4"
	TELEPHONE AS PER FURNITURE LAYOUT
	CEILING LIGHT
	POLE LIGHT
	WALL BRACKET LED LIGHT 4x4"
	1 x 14 W MIRROR LIGHT 7x7"
	24 SS WALL LIGHT SWITCH USE CHARGING TYPE C CHARGING SWITCH @ HT. 20"
	24 SS WALL LIGHT SWITCH SWITCHES FOR CEILING LIGHTS, TELEPHONE, 24 AC SWITCH, SKIRTING LIGHT @ HT. 20"
	24 NBS SOCKET - 1 NOS 24 SWITCH, TV COAXIAL SOCKET, LAN @ HT 4"
	SIDE WALL SPRINKLER HEAD
	PENDENT SPRINKLER HEAD
	SMOKE DETECTOR
	SKIRTING LIGHT 4x4"
	2 NOS 15A SWITCH SOCKET - 1 NOS 24 SWITCH FOR LIGHT @ HT 36"
	SPIKE LIGHT
	3 x 1.5 SQMM LIGHT CONTROL CU WIRE
	3 x 1.5 SQMM 2 WAY LIGHT CONTROL WIRE
	3 x 2.5 SQMM CU WIRE FOR AC (DU)
	3 x 4.0 SQMM CU WIRE FOR POWER CIRCUIT
	3 x 2.5 SQMM CU WIRE FOR LIGHT CIRCUIT
	CAT5 LAN WIRE RJ45 JACK TO LAN SWITCH
	2 PAIR TELEPHONE WIRE RJ11 JACK TO TTE
	ROH TV CABLE SETUP BOX TO TV SPLITTER
	CAT5 CCTV CABLE CCTV CAMERA TO NVR

PROJECT-
PROPOSED STUDIO APARTMENT

CLIENT-
CORAL GROUP

DESIGN TITLE-
ELECTRICAL LAYOUT - TERRACE FLOOR

DRAWING NO.:	SCALE: N.T.S.
DEALT BY - VISHNU KUMAWAT	CHECKED BY -
DATE: 13-09-2025	NORTH:

MEP-

A-8, PATH NO. 4, JAMUNA NAGAR,
SODALA, JAIPUR-302008,
MAIL - cubemep@gmail.com,
Ph. No. 0141 2221089
Mob. No. +91 9214308430

ARCHITECT-

avighna associates
- ARCHITECTS, INTERIOR DESIGNERS & PLANNERS -
Studio: 2nd floor block 2 office no 205, Vidyasagar, Malviya, Jaipur
+91 9214308430
phone: 9443332295
email: avighna@avighnaassociates.com

Handwritten signature



Avighna Associates
Architects, Interior
Designers & Planners
Varanasi