


UNIT - 3B+2T(TYPE-2)

UNIT - 2B+2T(TYPE-3)

UNIT - 2B+2T(TYPE-1)

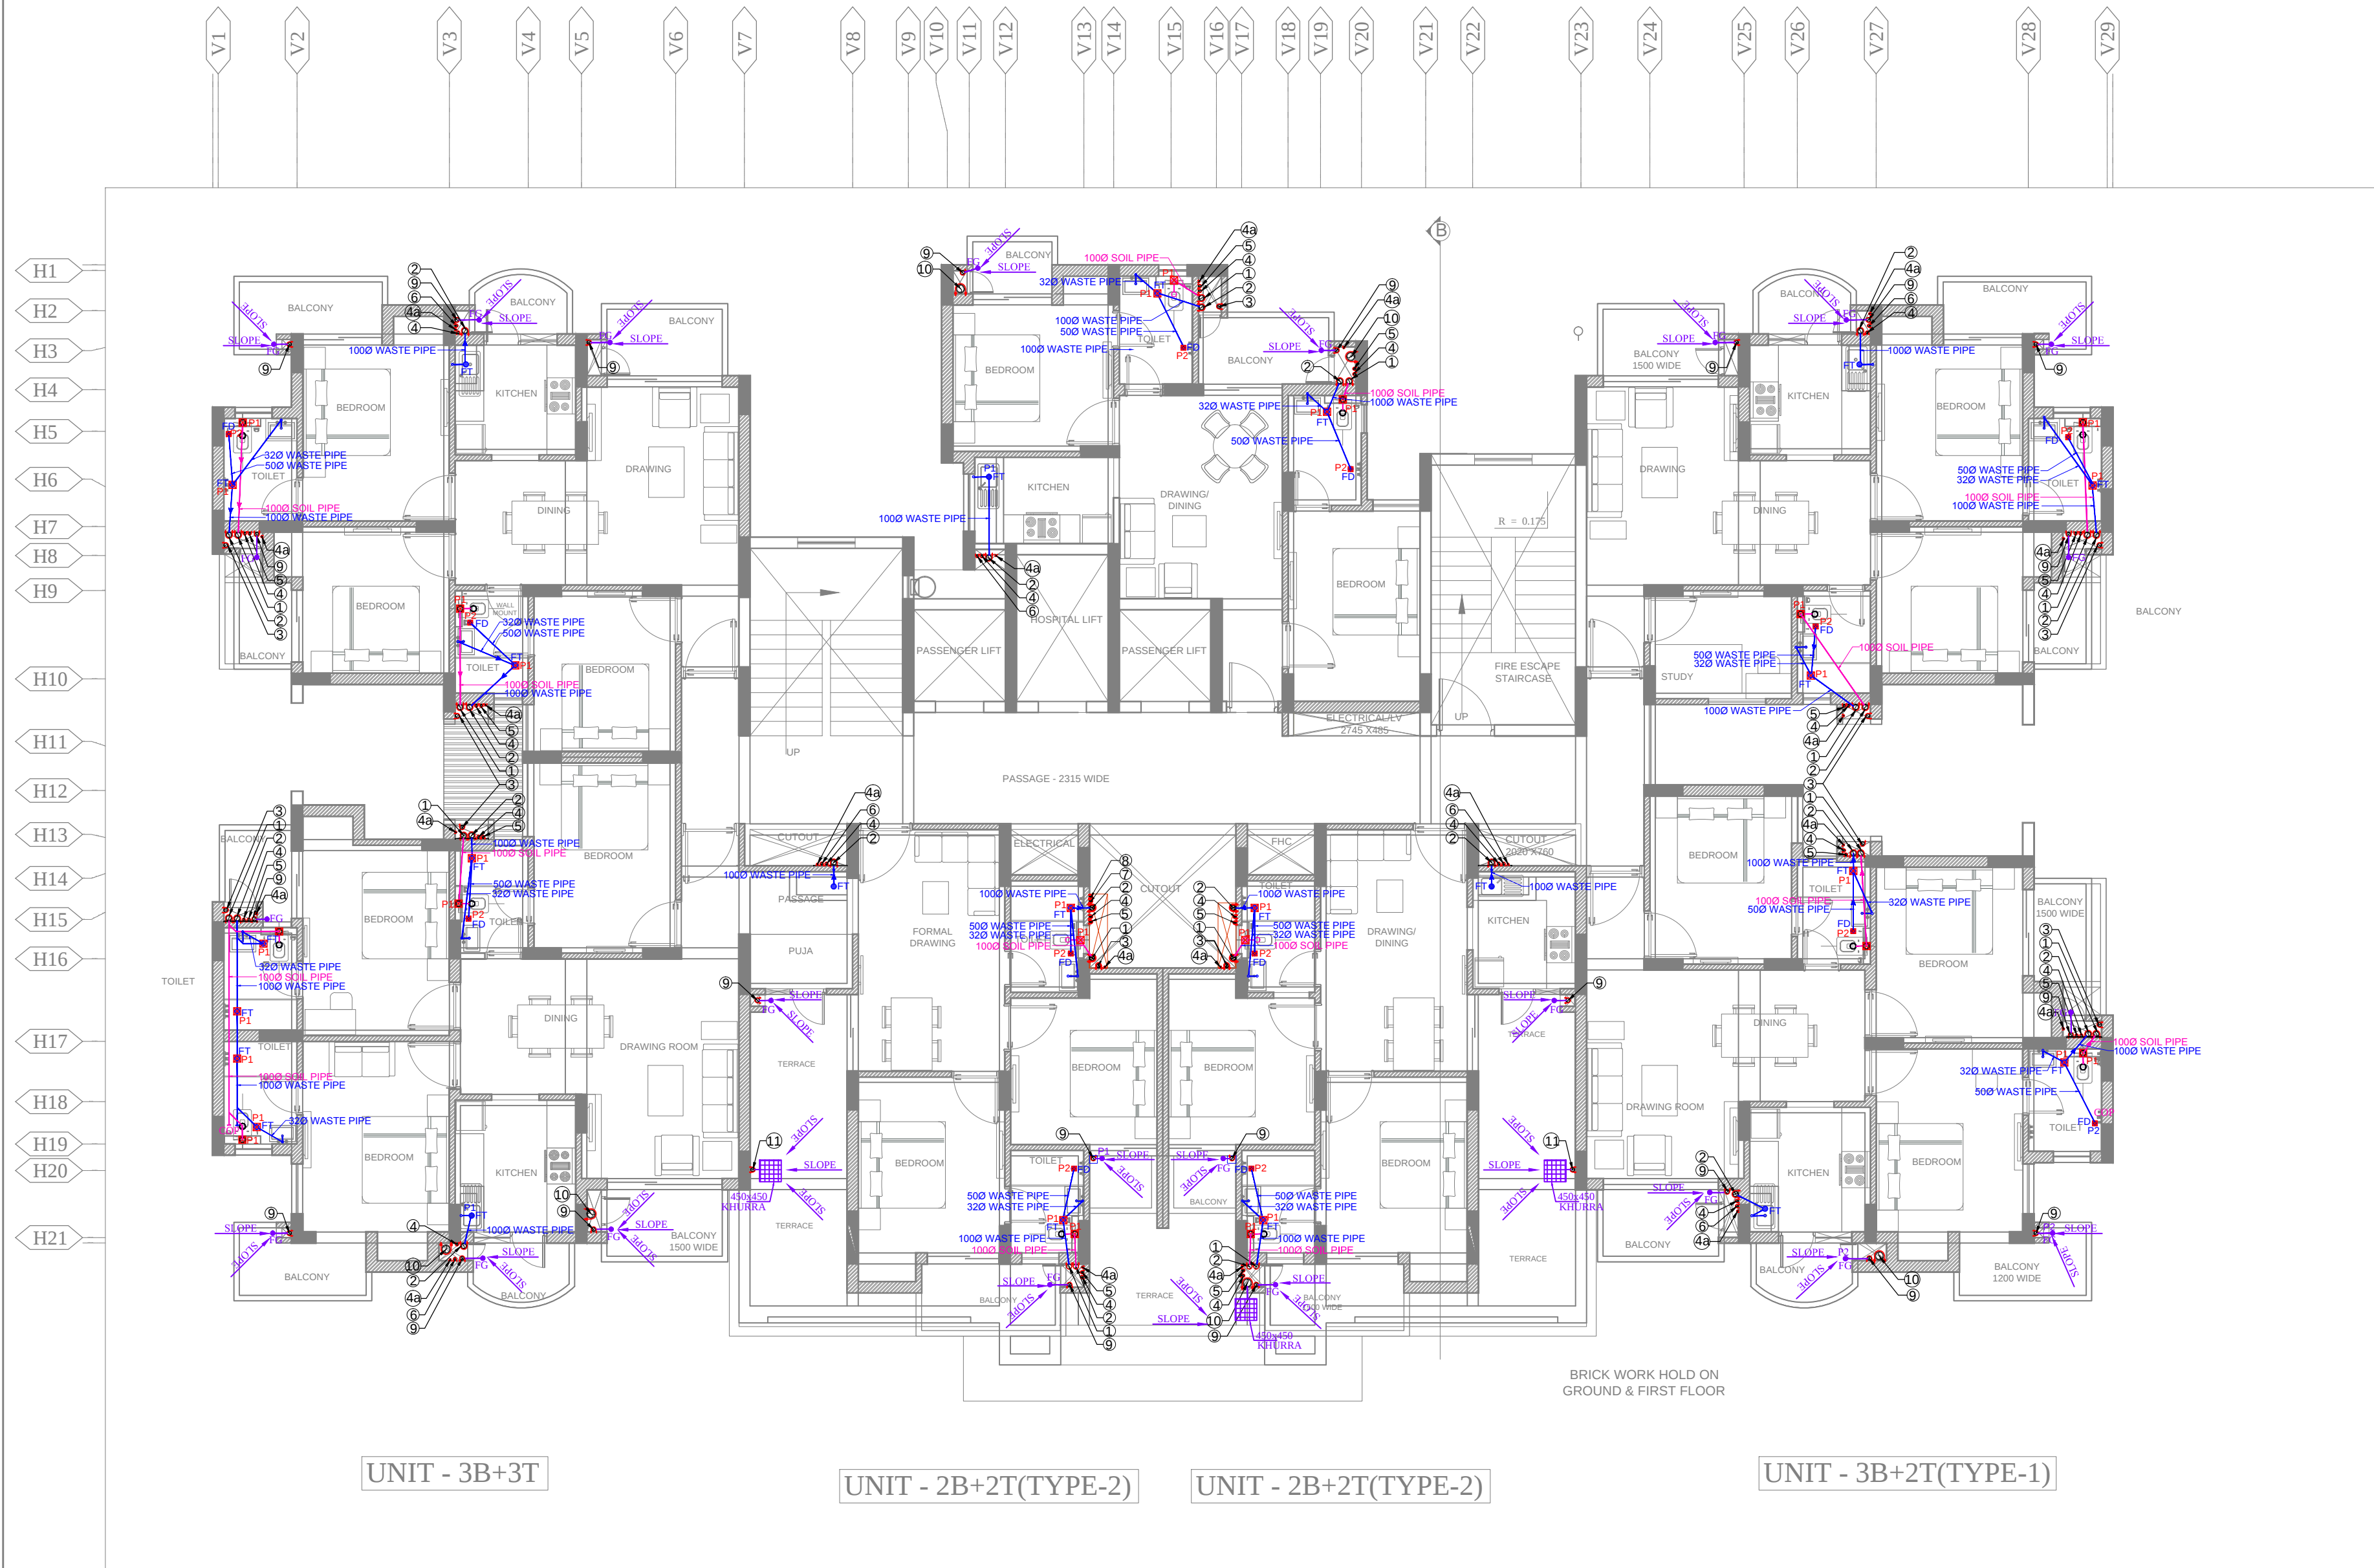

PLUMBING LEGEND

1.	1000 SOIL PIPE
2.	1000 WASTE PIPE
3.	750 VENT PIPE
4.	DOMESTIC WATER SUPPLY PIPE
4a.	DOMESTIC WATER HYDROMATIC
5.	FLUSHING WATER SUPPLY PIPE
6.	HOT WATER SUPPLY PIPE
7.	DOMESTIC WATER RISER PIPE
8.	FLUSHING WATER RISER PIPE
9.	750 RAIN WATER PIPE (BALCONY)
10.	1500 RAIN WATER PIPE
11.	1000 RAIN WATER PIPE
DWS	DOMESTIC WATER SUPPLY
FWS	FLUSHING WATER SUPPLY
HWS	HOT WATER SUPPLY
FD	FLOOR DRAIN
FT	FLOOR TRAP
UT	URINAL TRAP
P1	150x150mm CUTOUT
P2	100x100mm CUTOUT

→	RAIN WATER PIPE
→	WASTE PIPE
→	SOIL PIPE
●	(FD) FLOOR DRAIN
●	(FT) FLOOR TRAP
●	(FG) FLOOR GRATING
⊠	P1 = 150X150mm CUT OUT
⊠	P2 = 100X100mm CUT OUT

M/S SHRI LAXMI ARCHCON PVT.LTD
NEW DELHI

PRINCIPAL ARCHITECTS :

DESIGN CHAIN
E-93 EAST OF KAILASH,
NEW DELHI 110065
TEL. 01146132888

MEP SERVICES CONSULTANT :

Acrobat Engineers Pvt.Ltd.

H.No. 19 Block-18
Basement Level, Spring Field Colony
Faridabad (Haryana)
Tel. : 0129-4056009
customerservice@acrobatengineers.com

PROJECT TITLE:-

GROUP HOUSING AT
INS-6/2B,
VASUNDHARA GHAZIABAD
AS
SHRI LAXMI CELEBRATION RESIDENCY

DRAWING TITLE

TYPICAL FLOOR PLAN
DRAINAGE LAYOUT

DATE 26-12-2016

DROWN BY GAURAV RAWAT

CHKD BY : VIRENDRA

SCALE A1@1:75

DRWG NO. AEA/P-177/TFP/DL-01