



This drawing is a "COPYRIGHT" contents of this drawing or part thereof may not be used or reproduced without the permission of the Architect

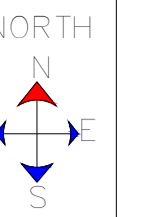


PROJECT  
PROPOSED GROUP HOUSING-02 IN  
OMAXE HITECH CITY , LUCKNOW U.P.

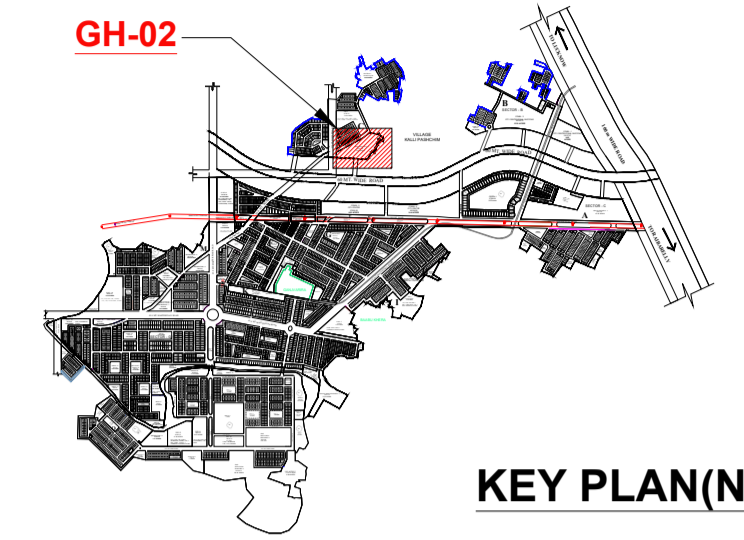

KEY PLAN(NTS)

LEGEND

SEWER LINE	
STORM WATER LINE	
DOMESTIC WATER RISER	
FLUSHING WATER RISER	
TUBE-WELL LINE	
MUNICIPAL WATER SUPPLY	
IRRIGATION LINE	
SEWER MANHOLES	
STORM MANHOLES	
GARDEN HYDRANT	

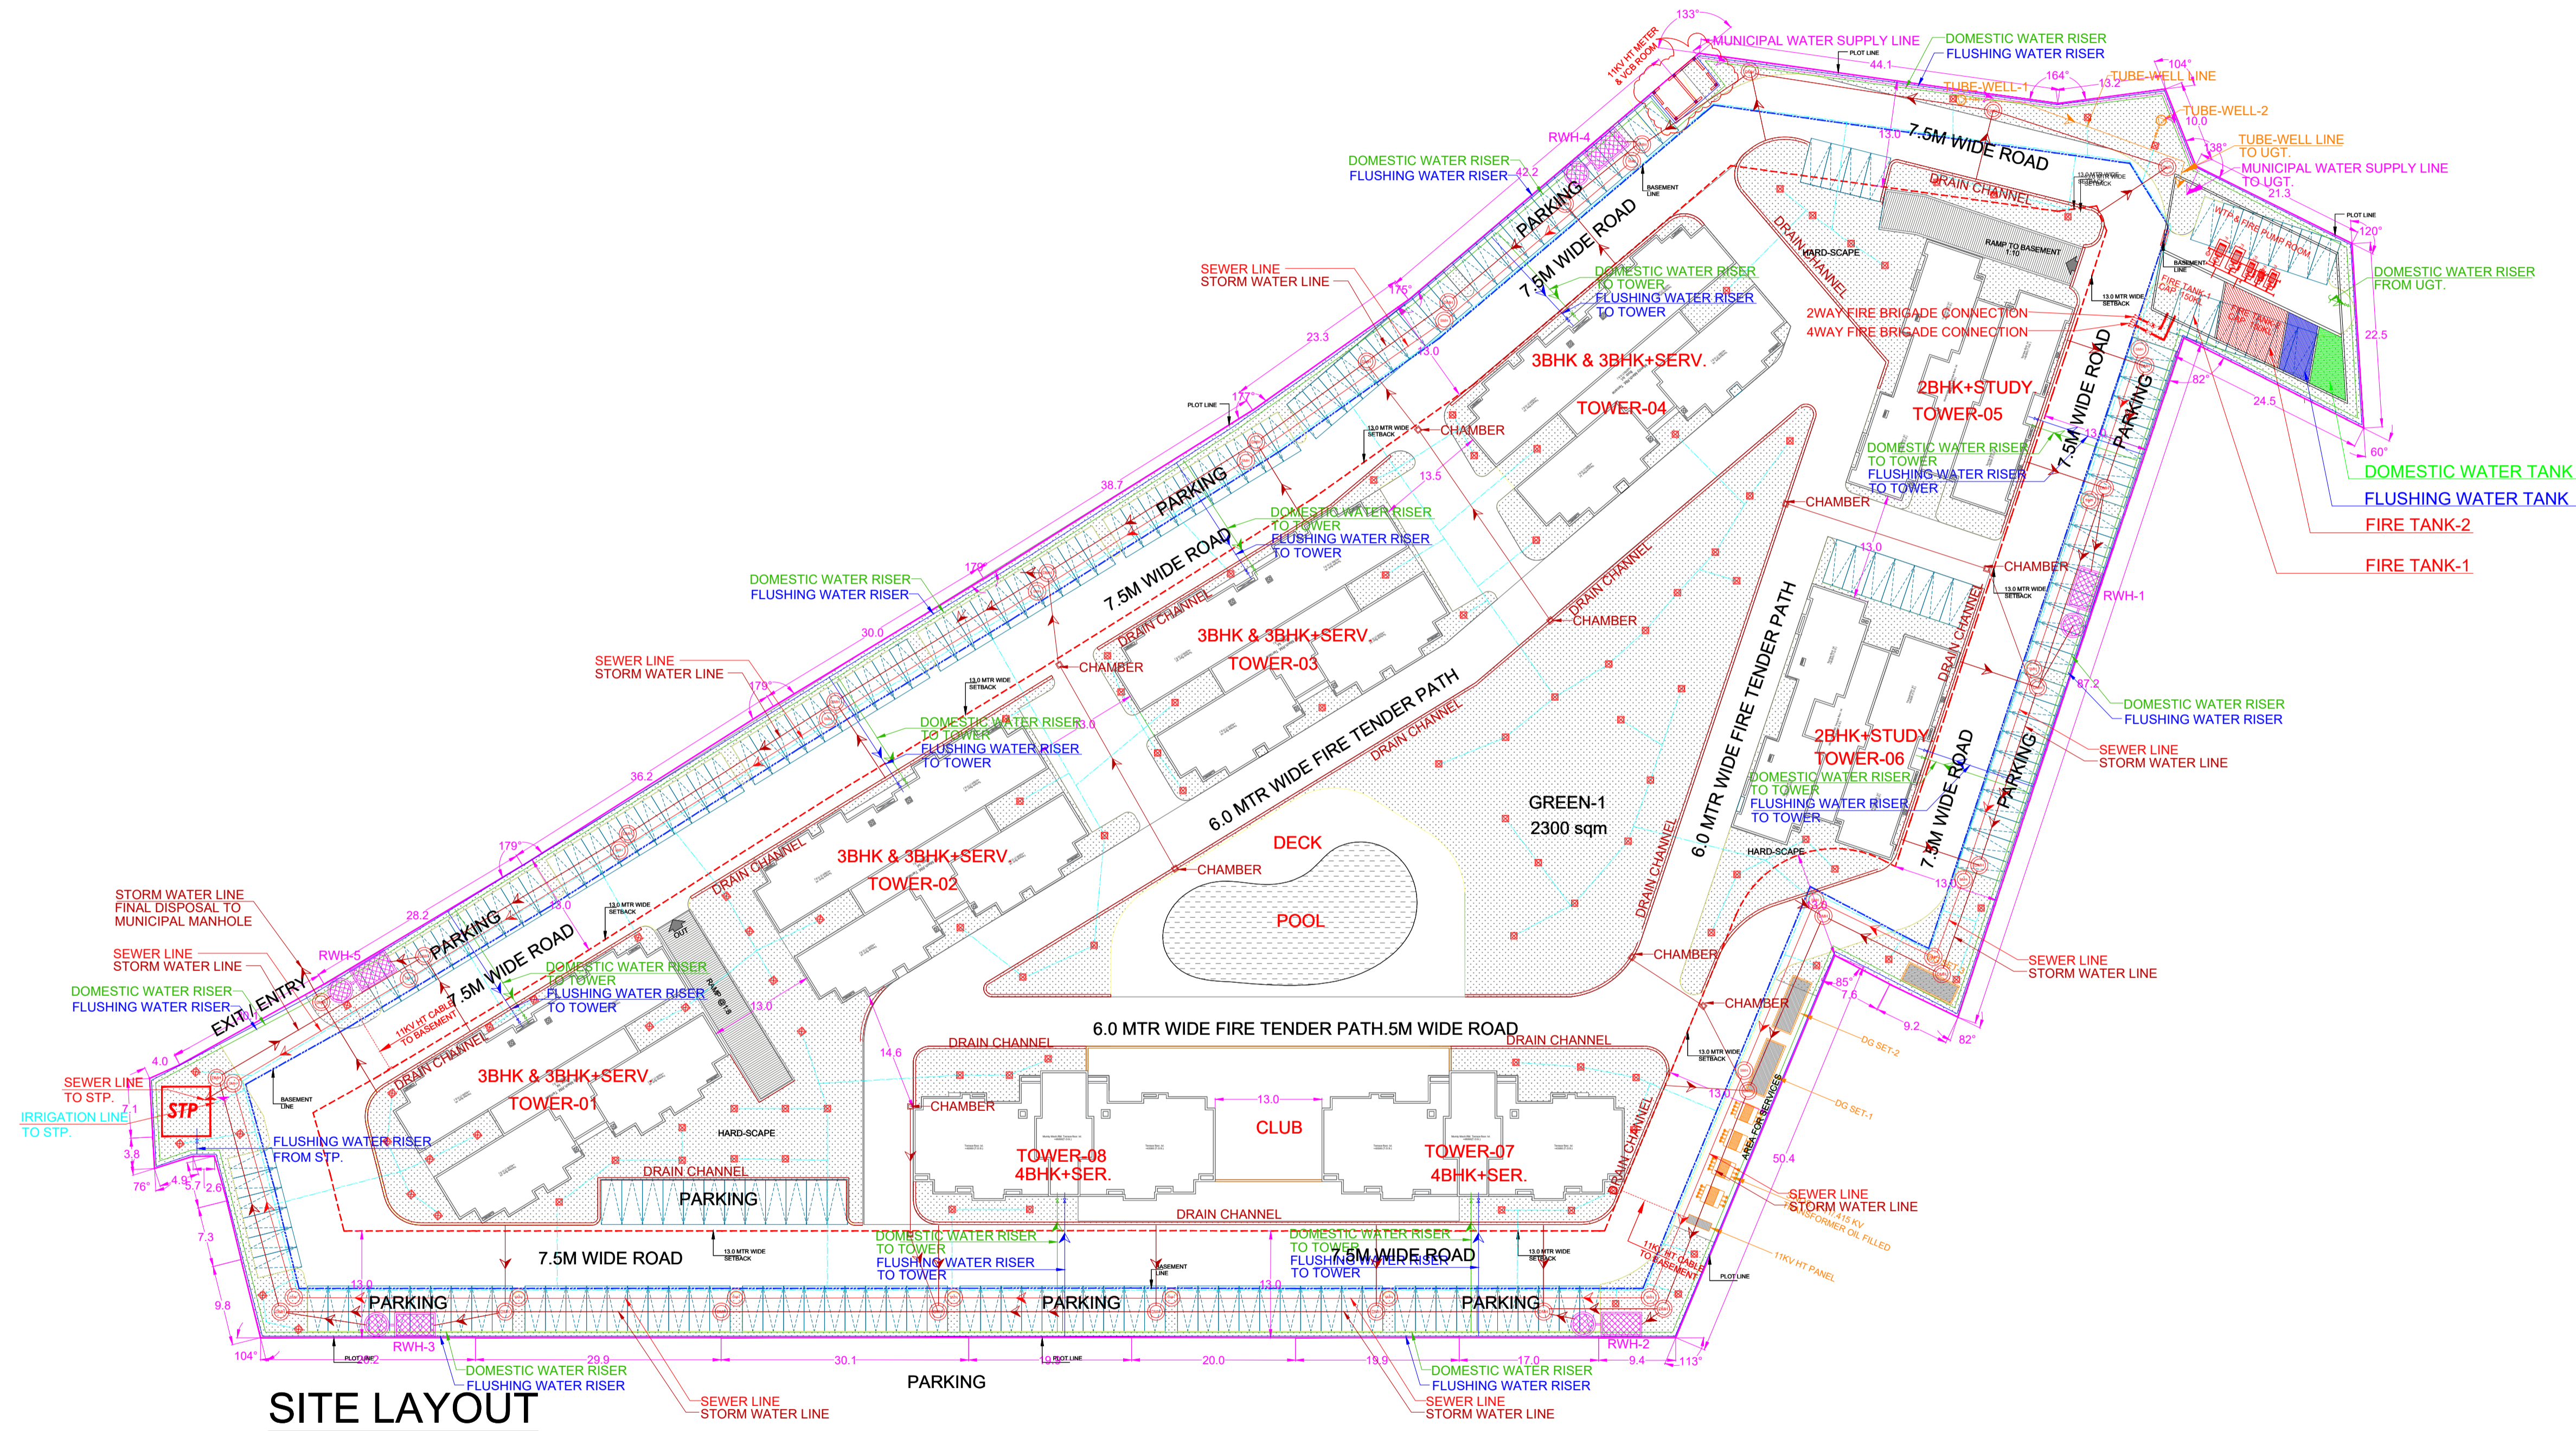

SITE LAYOUT

DRAWING TITLE

GROUP HOUSING-02  
SERVICES SITE PLAN

यह मानचित्र लखनऊ महायोजना २०३१ तथा भवन उपतिथि २००८ तथा संसोधित २०१६ संस्यक शासनदेशो के अनुरूप तैयार किया गया है

SCALE DATE

N.T.S. APRIL 2014

ARCHITECT CLIENT/ OWNERS

DRAWING NUMBER- LKO/HI-TECH/GH-02/SUB-01