


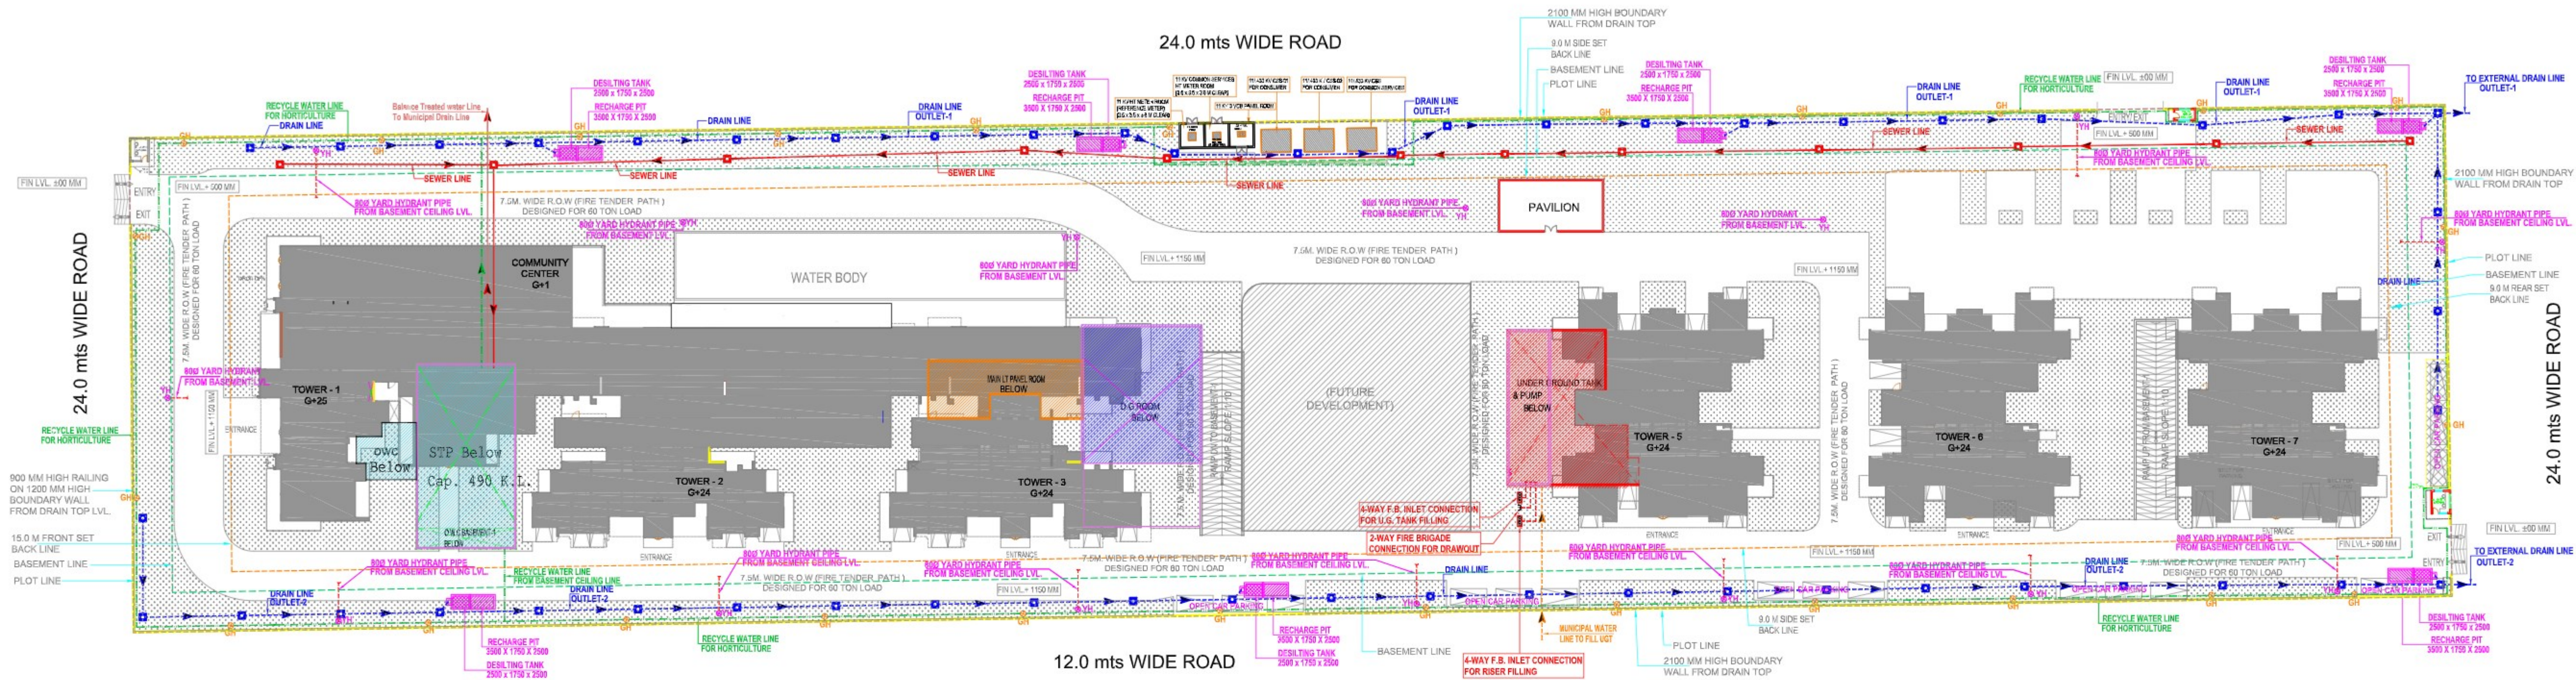

LEGEND :

S. No.	SYMBOL	DESCRIPTION
1.	M.H.	MANHOLE
2.	SEWER LINE	SEWER LINE
3.	BYPASS SEWER LINE	BYPASS SEWER LINE
4.	C.P.	CATCH PIT
5.	UNDER GROUND DRAIN	UNDER GROUND DRAIN
6.	RAIN WATER HARVESTING	RAIN WATER HARVESTING
7.	RECYCLED WATER SUPPLY PIPE LINE.	RECYCLED WATER SUPPLY PIPE LINE.
8.	RISING MAIN WATER PIPE LINE.	RISING MAIN WATER PIPE LINE.
9.	MUNICIPAL WATER SUPPLY PIPE LINE.	MUNICIPAL WATER SUPPLY PIPE LINE.
10.	ISOLATING VALVE	ISOLATING VALVE
11.	MASONRY CHAMBER FOR ISOLATING VALVE	MASONRY CHAMBER FOR ISOLATING VALVE
12.	PROPOSED TUBE WELL	PROPOSED TUBE WELL
13.	BASEMENT LINE	BASEMENT LINE
14.	GARDEN HYDRANT	GARDEN HYDRANT



LEGEND : FIRE SYSTEM

S. No.	SYMBOL	DESCRIPTION
1.	FIRE LINE	FIRE LINE
2.	YH	YARD HYDRANT 63 M.M. DIA. SINGLE HEADED HYDRANT VALVE WITH 2 NOS. 15 M. LONG, 53 M.M. DIA. FIRE HOSE PIPE & 1 NO. BRANCH PIPE WITH NOZZLE
3.	FIRE BRIGADE CONNECTION	FIRE BRIGADE CONNECTION
4.	BUTTERFLY VALVE	BUTTERFLY VALVE
5.	NONRETURN VALVE (CHECK VALVE)	NONRETURN VALVE (CHECK VALVE)
6.	ISOLATING VALVE WITH MASONARY CHAMBER	ISOLATING VALVE WITH MASONARY CHAMBER

OWNER
M/S LA BUILDTech PRIVATE LIMITED

SUBMISSION DRAWING

KEY PLAN

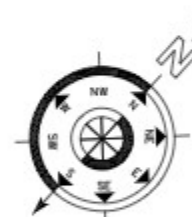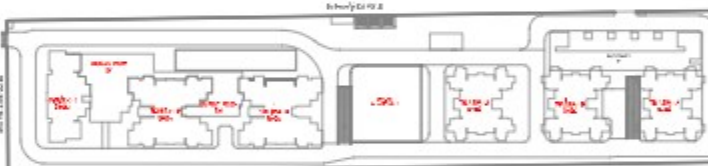

PROJECT
**PROPOSED GROUP HOUSING FOR
LA BUILDTech PRIVATE LIMITED AT PLOT
NO :- GH-05, SECTOR -12, GREATER
NOIDA, G.B. NAGAR, (U.P.)**

R0	27-06-2024	For SUBMISSION
Rev. No.	Date	Revision

Title
SITE PLAN.

Subtitle
EXTERNAL COMBINED SERVICES

Drawing released for
☐ APPROVAL ☒ SUBMISSION
☐ ADVANCE COPY ☐ CONSTRUCTION

Org. no. S-05 Drawn by PS



Scale 1:550 Designed by R.K.

Date June 2024 Checked by Anand Havella

Services Consultant
Cespl Consultants Pvt. Ltd.
Noida Office : B - 67, Sector - 67, Noida - 201 301
Tel : (0120) 3225400 / 3225401
e mail : mail@cespl.in, website : www.cespl.in



ARCHITECTS
Confluence
NEW DELHI, INDIA
F-1, FIRST FLOOR, MIRA CORPORATE SUITES,
ISHWAR NAGAR, NEW DELHI 110065
Ph: +91-11-28925884 cca@confluence.com Member of IGBC
Ph: +91-11-40504706 www.confluence.com ISO - 9001 : 2000
architecture urban design hospitality interiors

Annexure-K

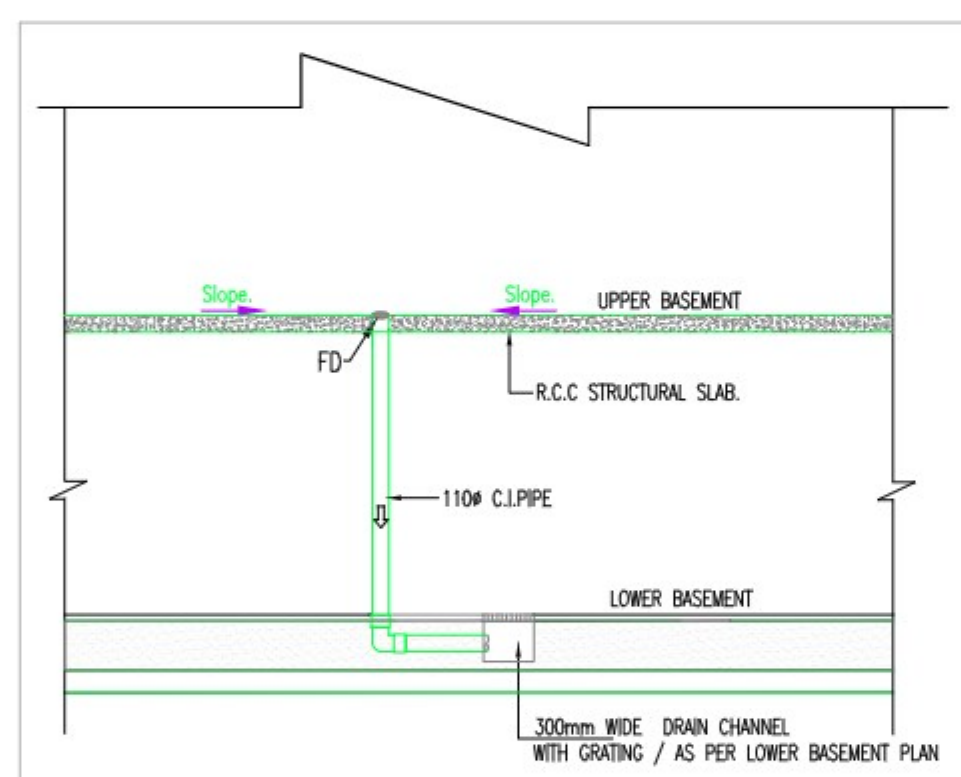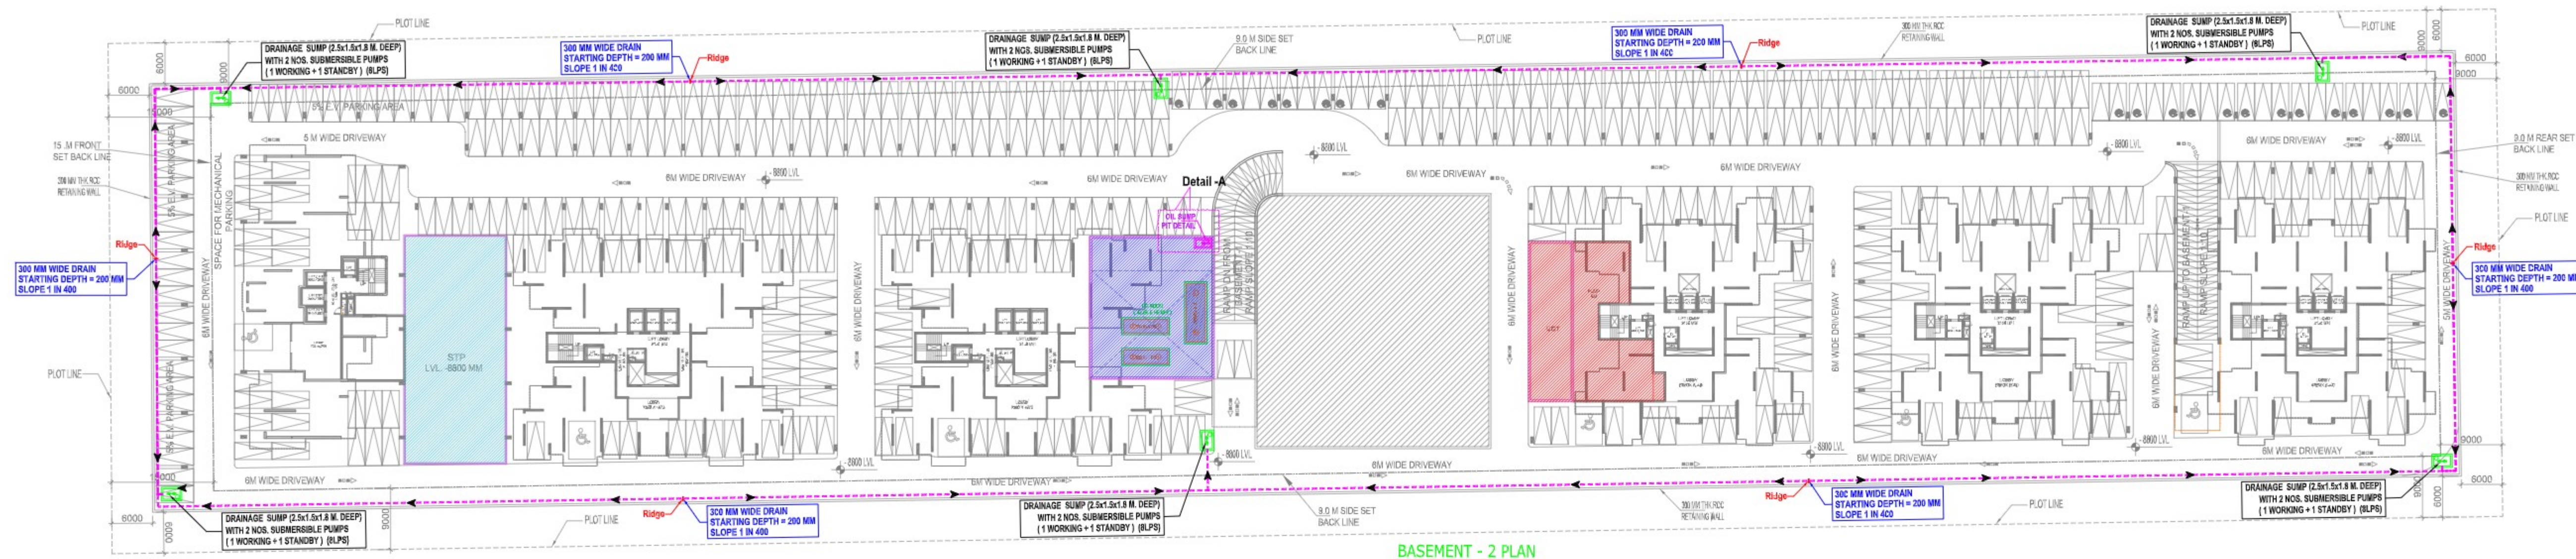


LEGEND : (DRAINAGE SYSTEM)

S. No.	SYMBOL	DESCRIPTION
1.		SURFACE DRAIN
2.	B. L.	BASEMENT LEVEL
3.	I. L.	INVERT LEVEL
4.	C. L.	CONNECTION LEVEL

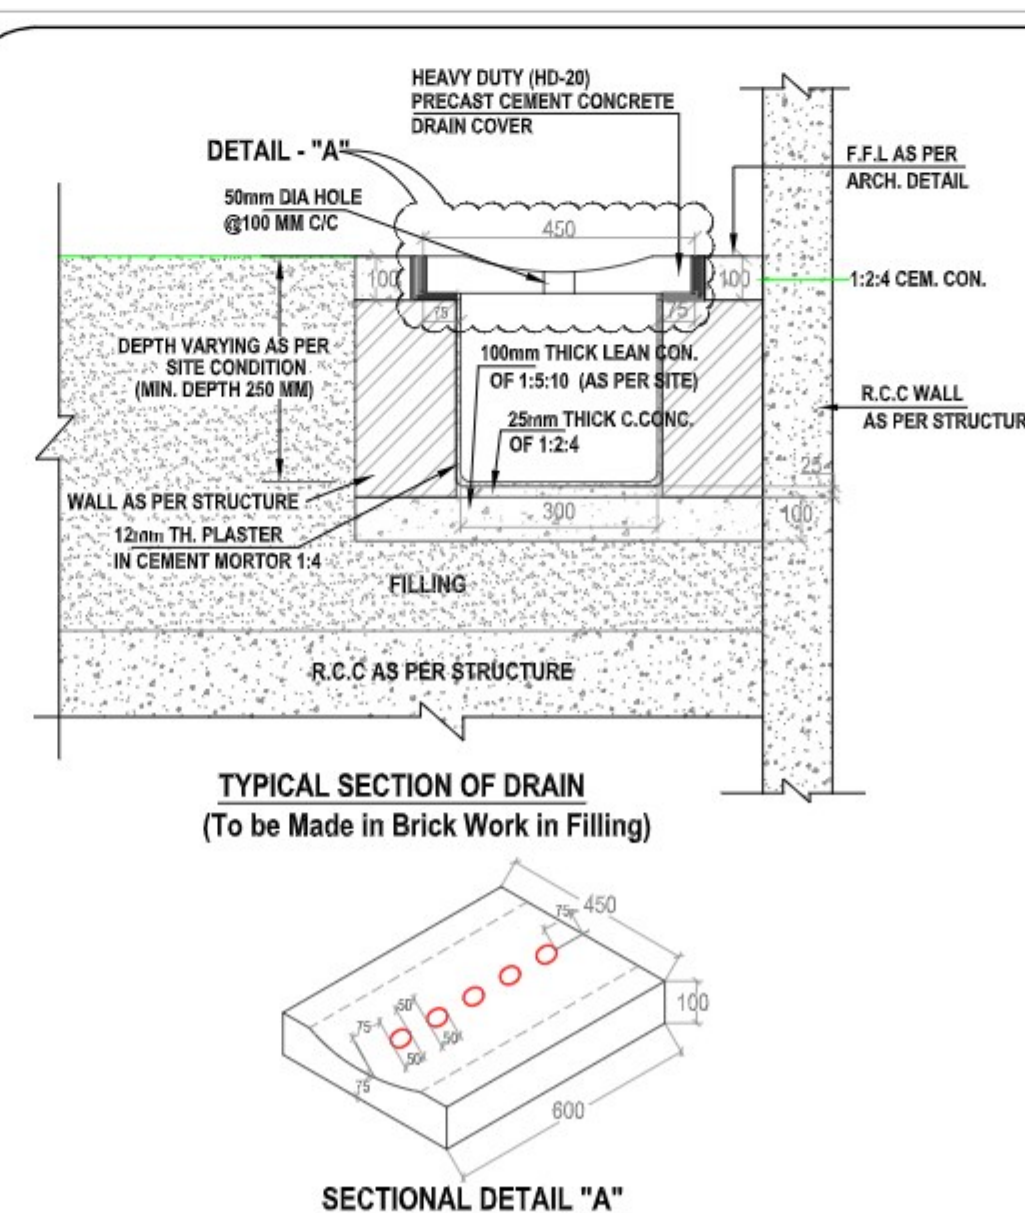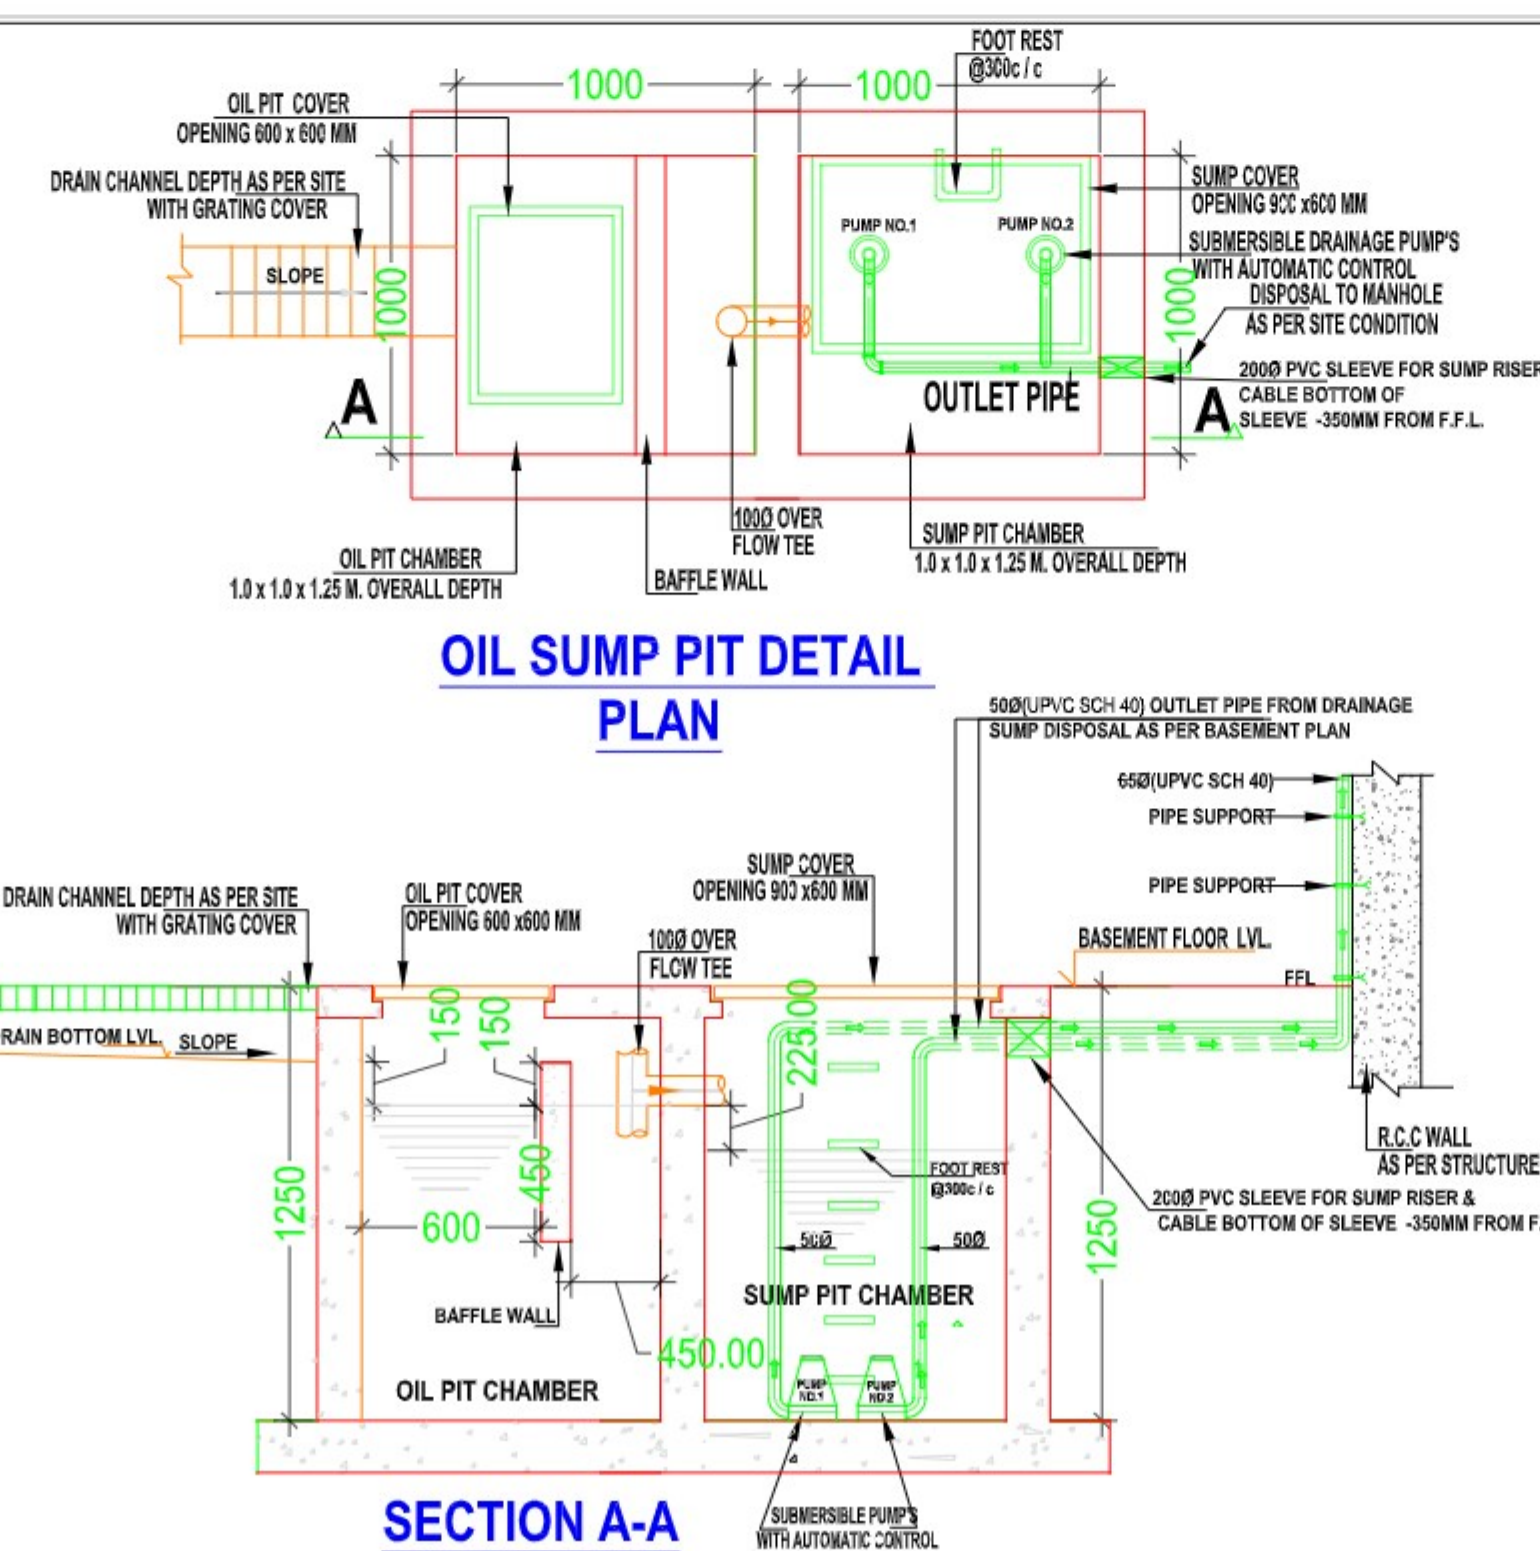

NOTE : KINDLY CO-ORDINATE BASEMENT DRAINAGE ROUTE & SUMP POSITION WITH BASEMENT COLUMN FOOTING PLAN AS PER STRUCTURAL DRAWING.

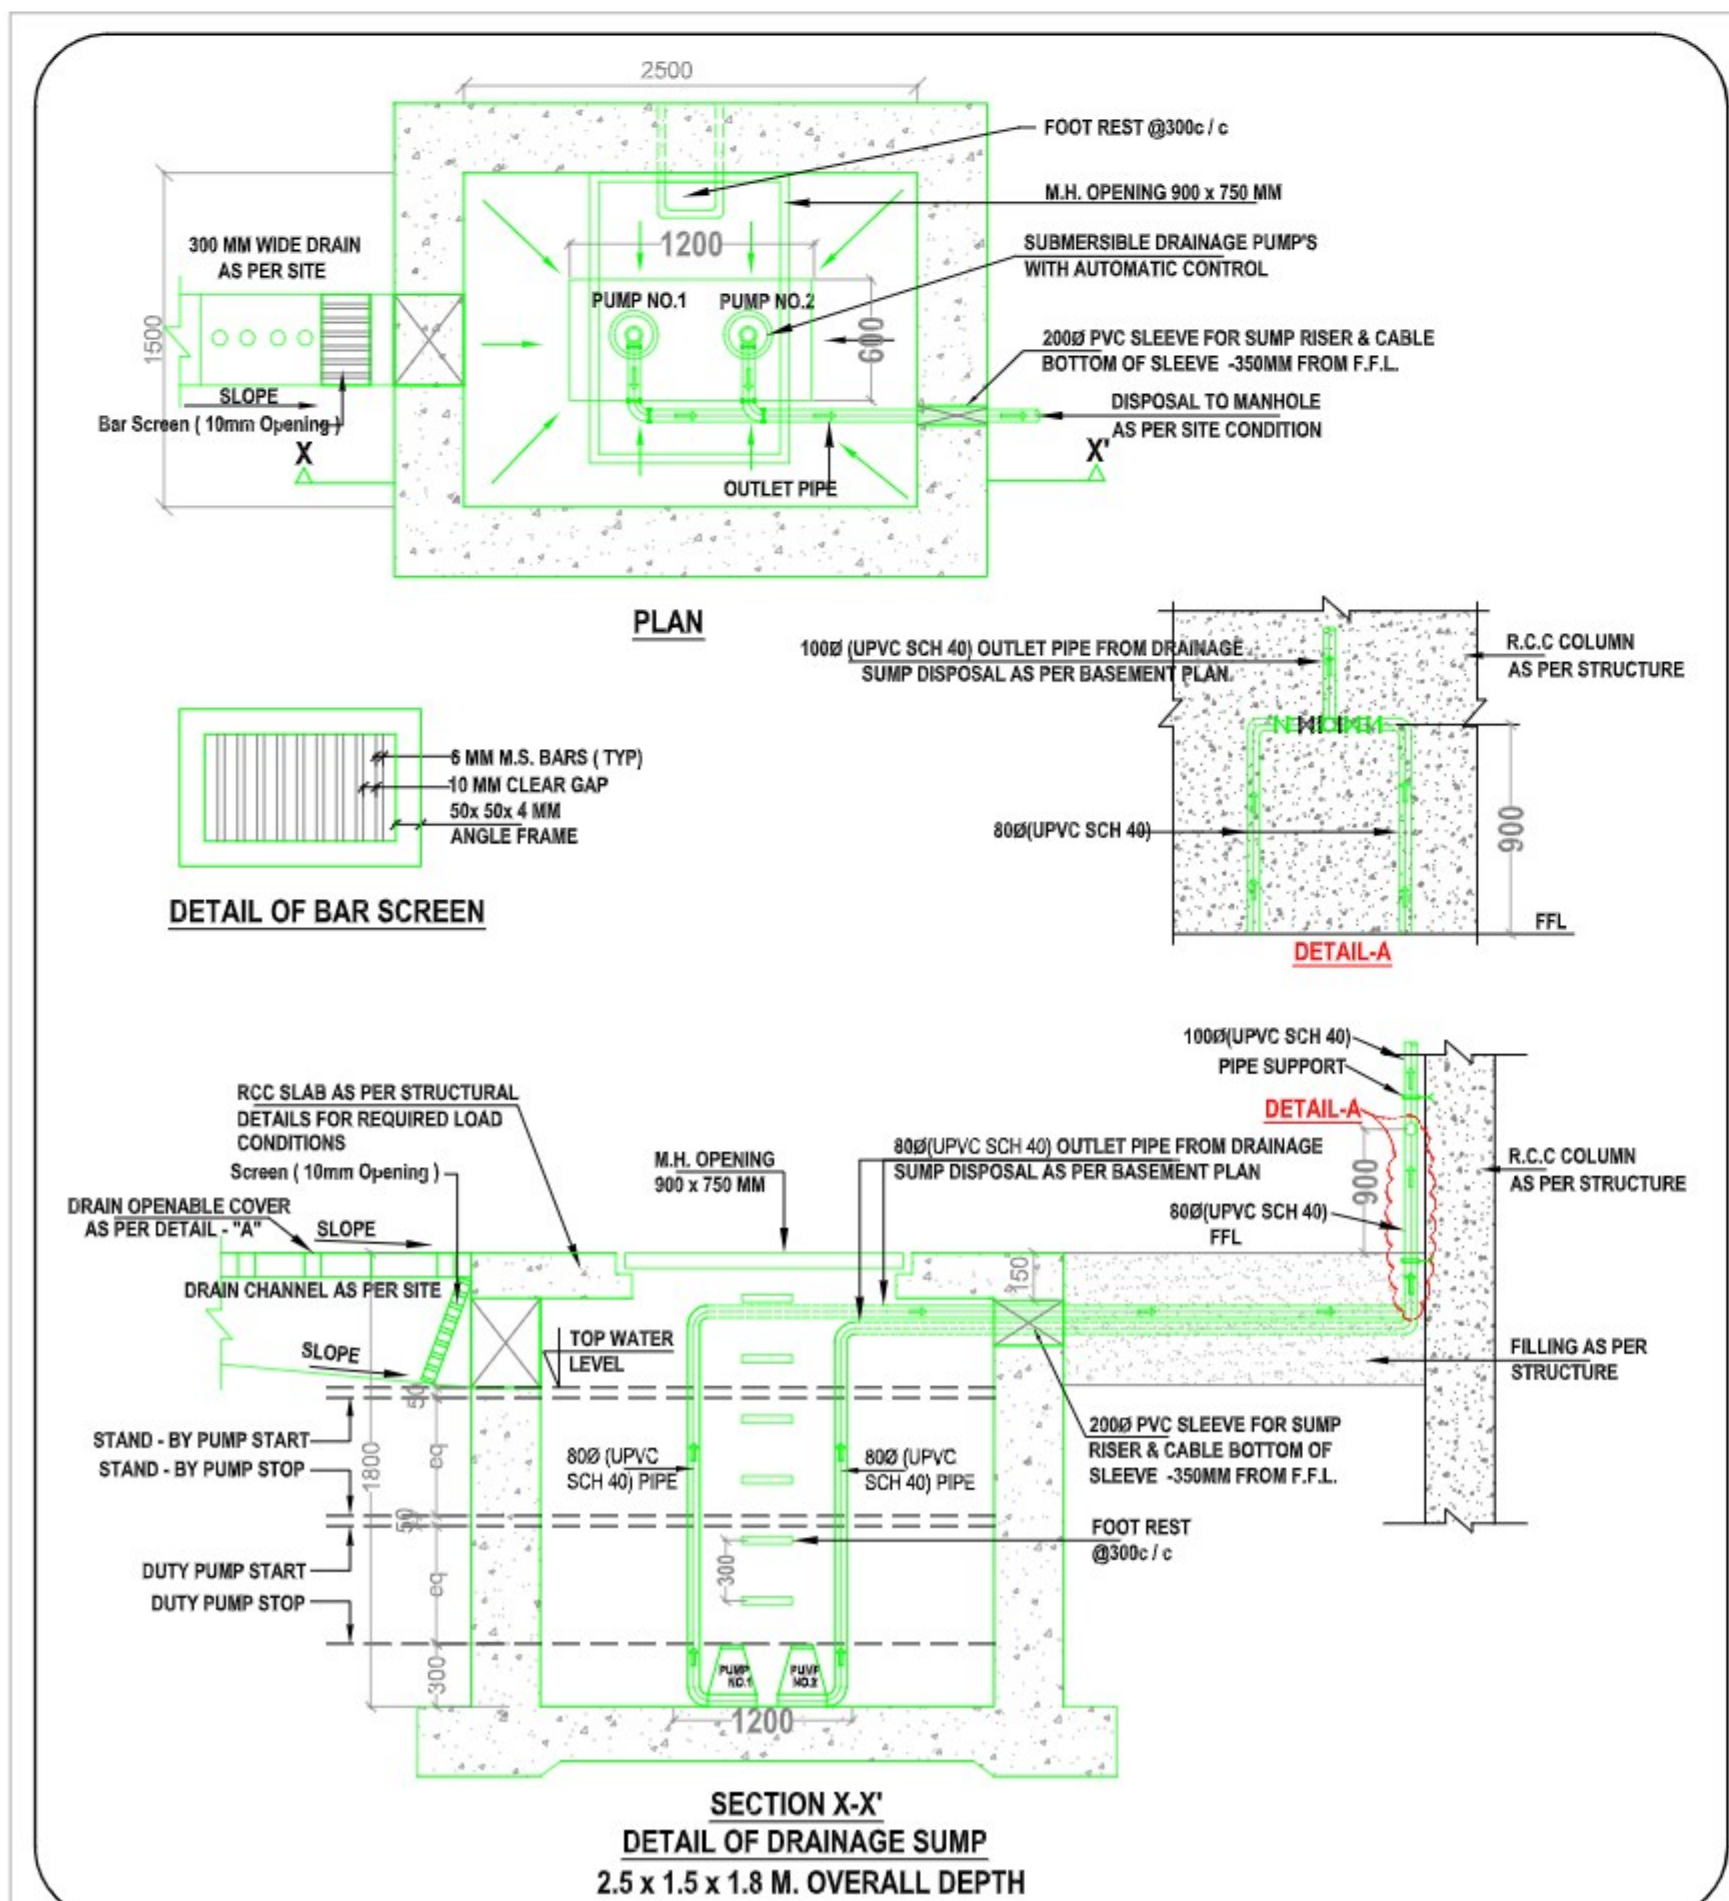

OWNER

M/S LA BUILDTECH PRIVATE LIMITED

SUBMISSION DRAWING

KEY PLAN



PROJECT

PROPOSED GROUP HOUSING FOR
LA BUILDTECH PRIVATE LIMITED AT PLOT
NO :- GH-05, SECTOR -12, GREATER
NOIDA, G.B. NAGAR, (U.P.)

R0	20-08-2024	For SUBMISSION
Rev. No.	Date	Revision

Title **BASEMENT PLAN**

Subtitle
BASEMENT -2 DRAINAGE PLAN

Drawing released for

☐ APPROVAL	☒ SUBMISSION
☐ ADVANCE COPY	☐ CONSTRUCTION

Drg. no. _____ Drawn by _____

Scale	Designed by
-------	-------------

Date	Checked by
------	------------

Services Consultant

Cespl Consultants Pvt. Ltd.

cespl
Noida Office : B - 67, Sector - 67, Noida - 201 301
Tel : (0120) 3225400 / 3225401
e mail : mail@cespl.in, website : www.cespl.in

ARCHITECTS

Confluence
NEW DELHI, INDIA

F-1, FIRST FLOOR, MIRA CORPORATE SUITES.

Ph- +91-11-26925684 ccs@inconfluence.com Member of IGBC
Ph- +91-11-40564768 www.inconfluence.com ISO - 9001 : 2000