


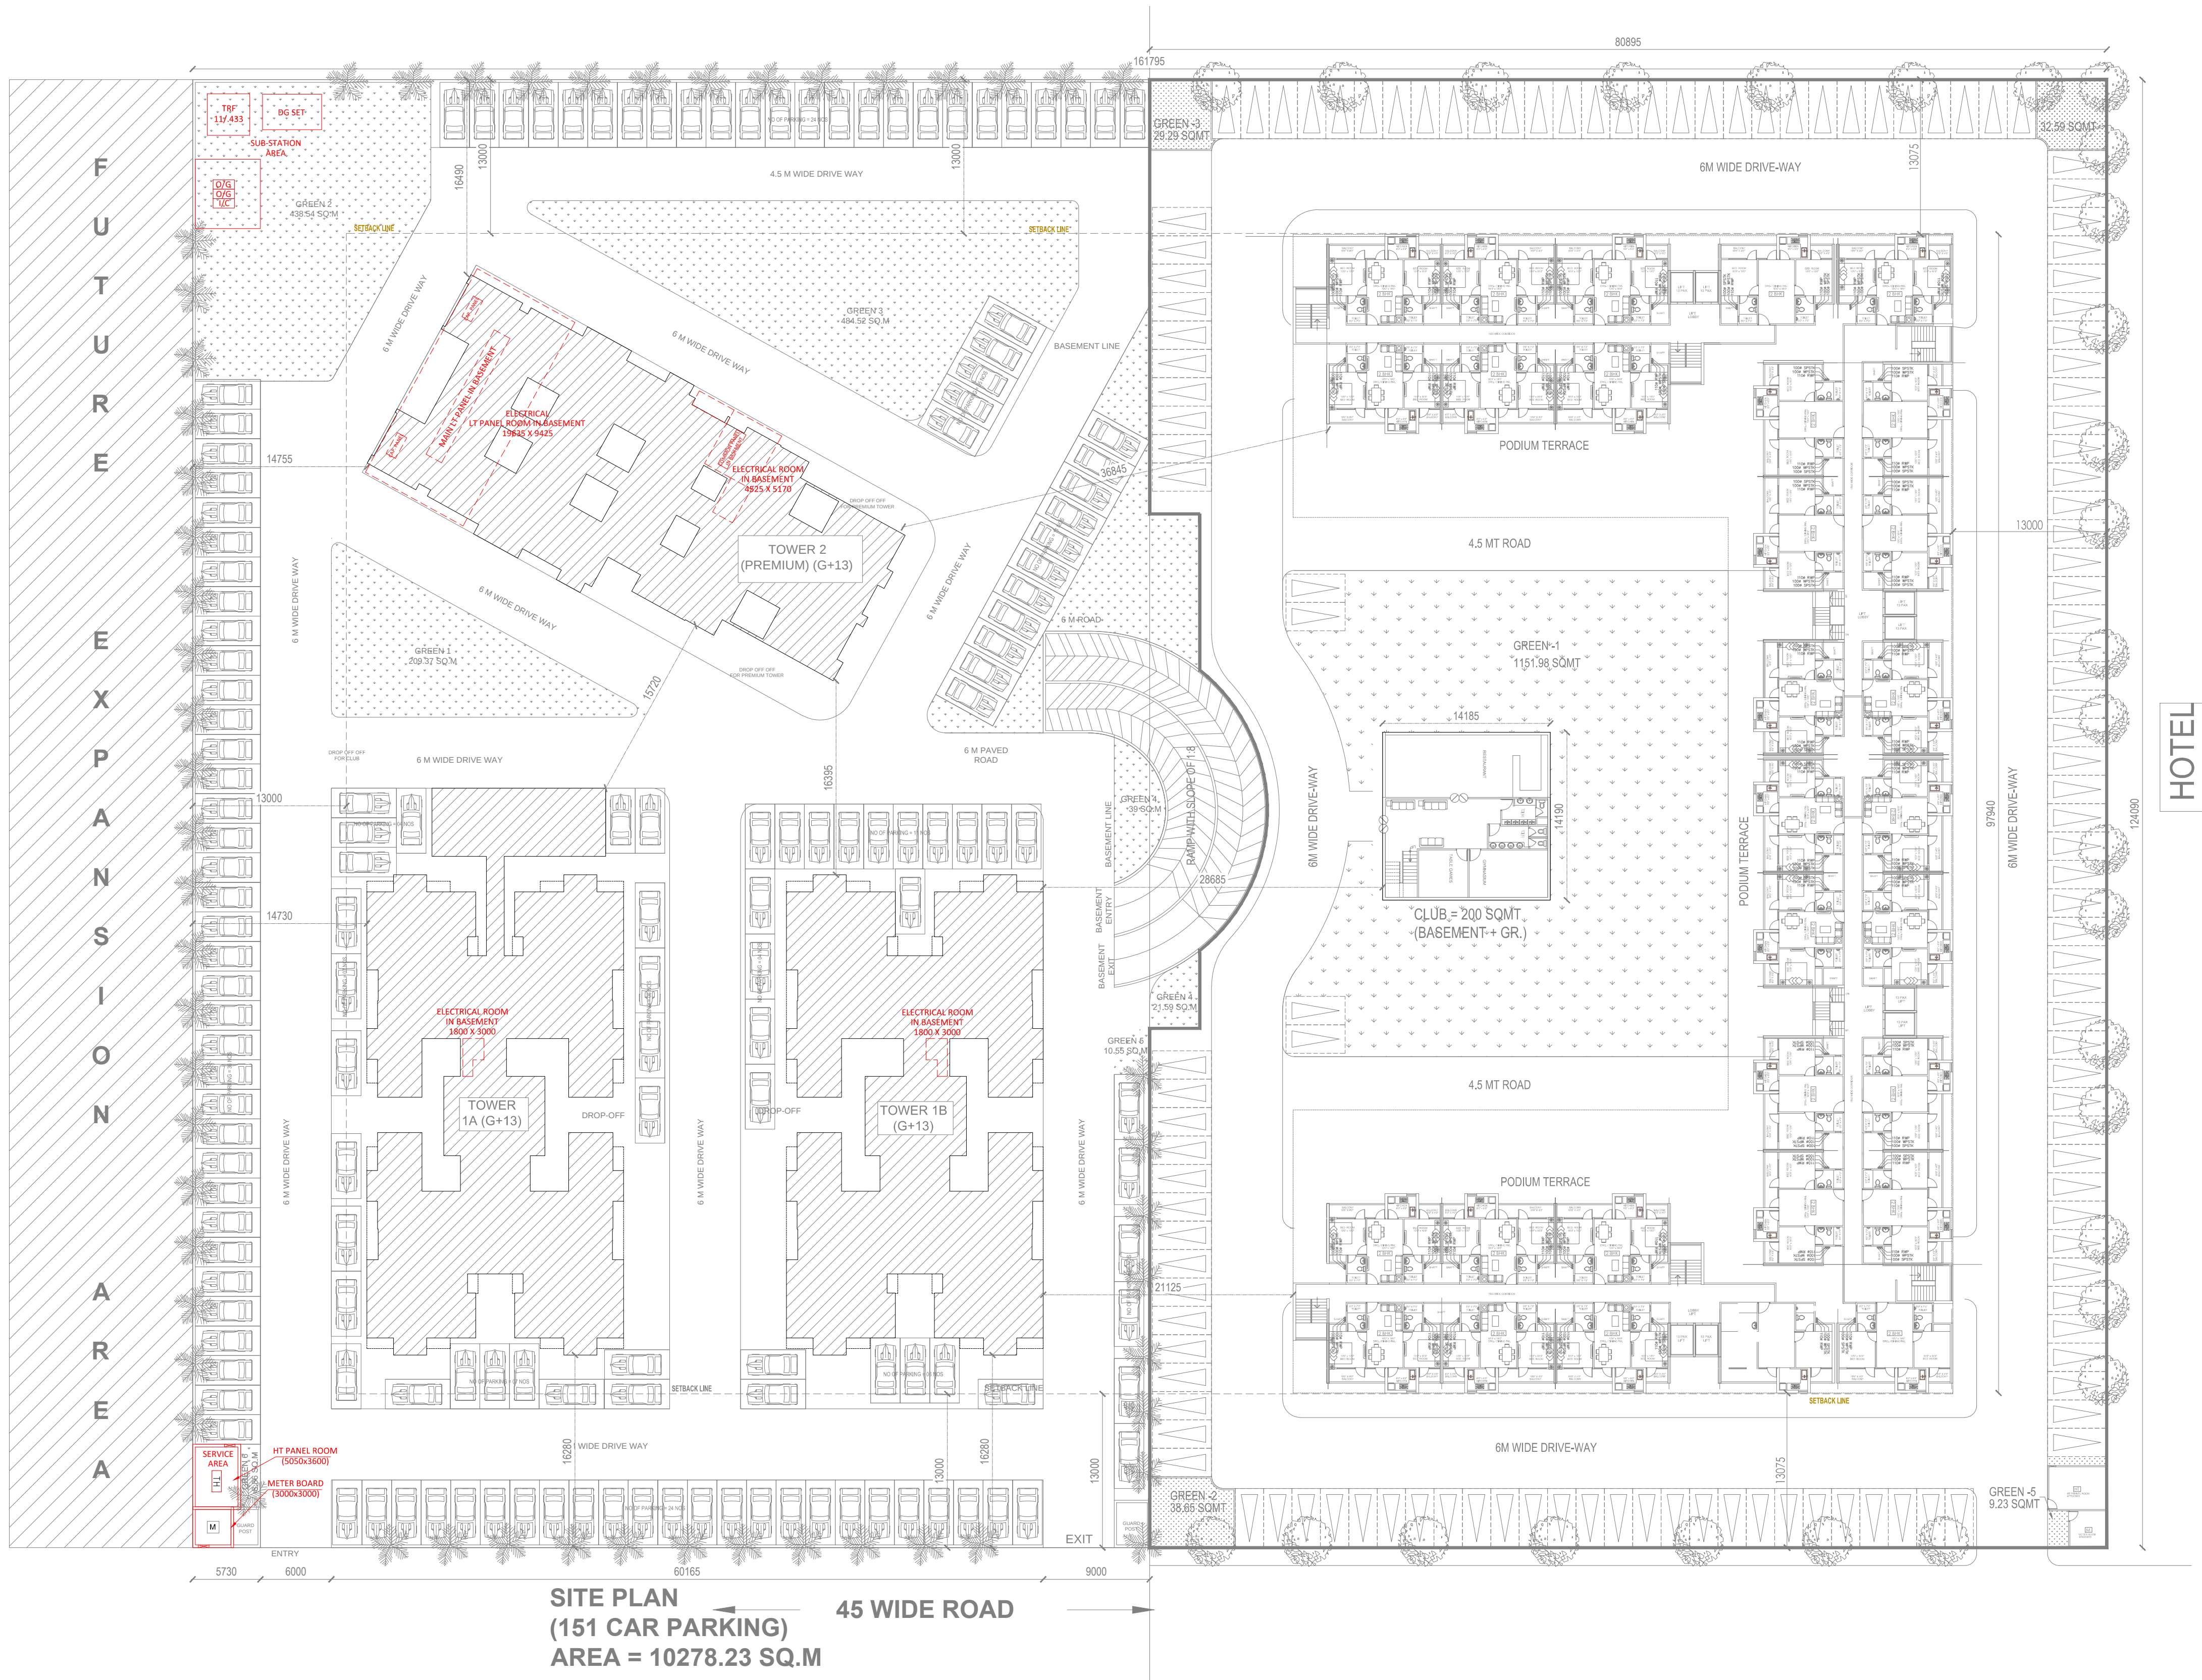

SITE PLAN
(151 CAR PARKING)
AREA = 10278.23 SQ.M

45 WIDE ROAD

This drawing is a "COPYRIGHT" contents
of this drawing or part thereof may
not be used or reproduced without
the permission of the Architect

NORTH

PROJECT

PROPOSED GROUP HOUSING - 1
AT SECTOR-F, POCKET-1
SUSHANT GOLF CITY
HI-TECH TOWNSHIP, LUCKNOW

NOTES

1. ALL DIM. ARE IN MM.
2. ALL FIRE CHECK DOORS ARE OF 2H RATING.

SUBMISSION DRAWING
(SERVICES PLAN)
(SITE ELECTRICAL PLAN)

DRAWING TITLE

SITE PLAN (SERVICES PLAN)

DEALT BY

PRAMOD

CHECKED BY

S.N.T

SCALE

1:300

DATE

JAN-2018

:g ekufp= y'kuA egk;ktuk 2031 rFkk Hkou mifot/k
2008 ;Fkk lo'kksfZ/kr 2011 ,oOk 2016 rFkk lE;d
'kklukns'kks ds vuq;i rS;kj fd;k x;k gSA

CONSULTANT

REPL
The Power of Knowledge
Rudrabhishek Enterprises Pvt.Ltd.
A - 6, SECTOR - 58 NOIDA - 201301, U.P.
PH 0120 - 4022333 FAX 0120 - 4022301

CLIENT/ OWNERS

ANSAL API
ANSAL PROPERTIES &
INFRASTRUCTURE LTD.
115, ANSAL BHAWAN,
16, K.G. MARG, NEW DELHI - 110001.

ARCHITECT'S SIGNATURE

OWNER'S SIGNATURE

DRAWING NUMBER - GH/HI-TECH/KO/SUB/EL-01