



LEGEND :


SYMBOL	DESCRIPTION	MOUNTING HEIGHT ABOVE FL. LVL.
	8 Way SPN DB	1100
	LIGHT POINT	2100
	5A/15A POWER	300
	15A POWER	300
	CEILING FAN	-
	CEILING LIGHT	-

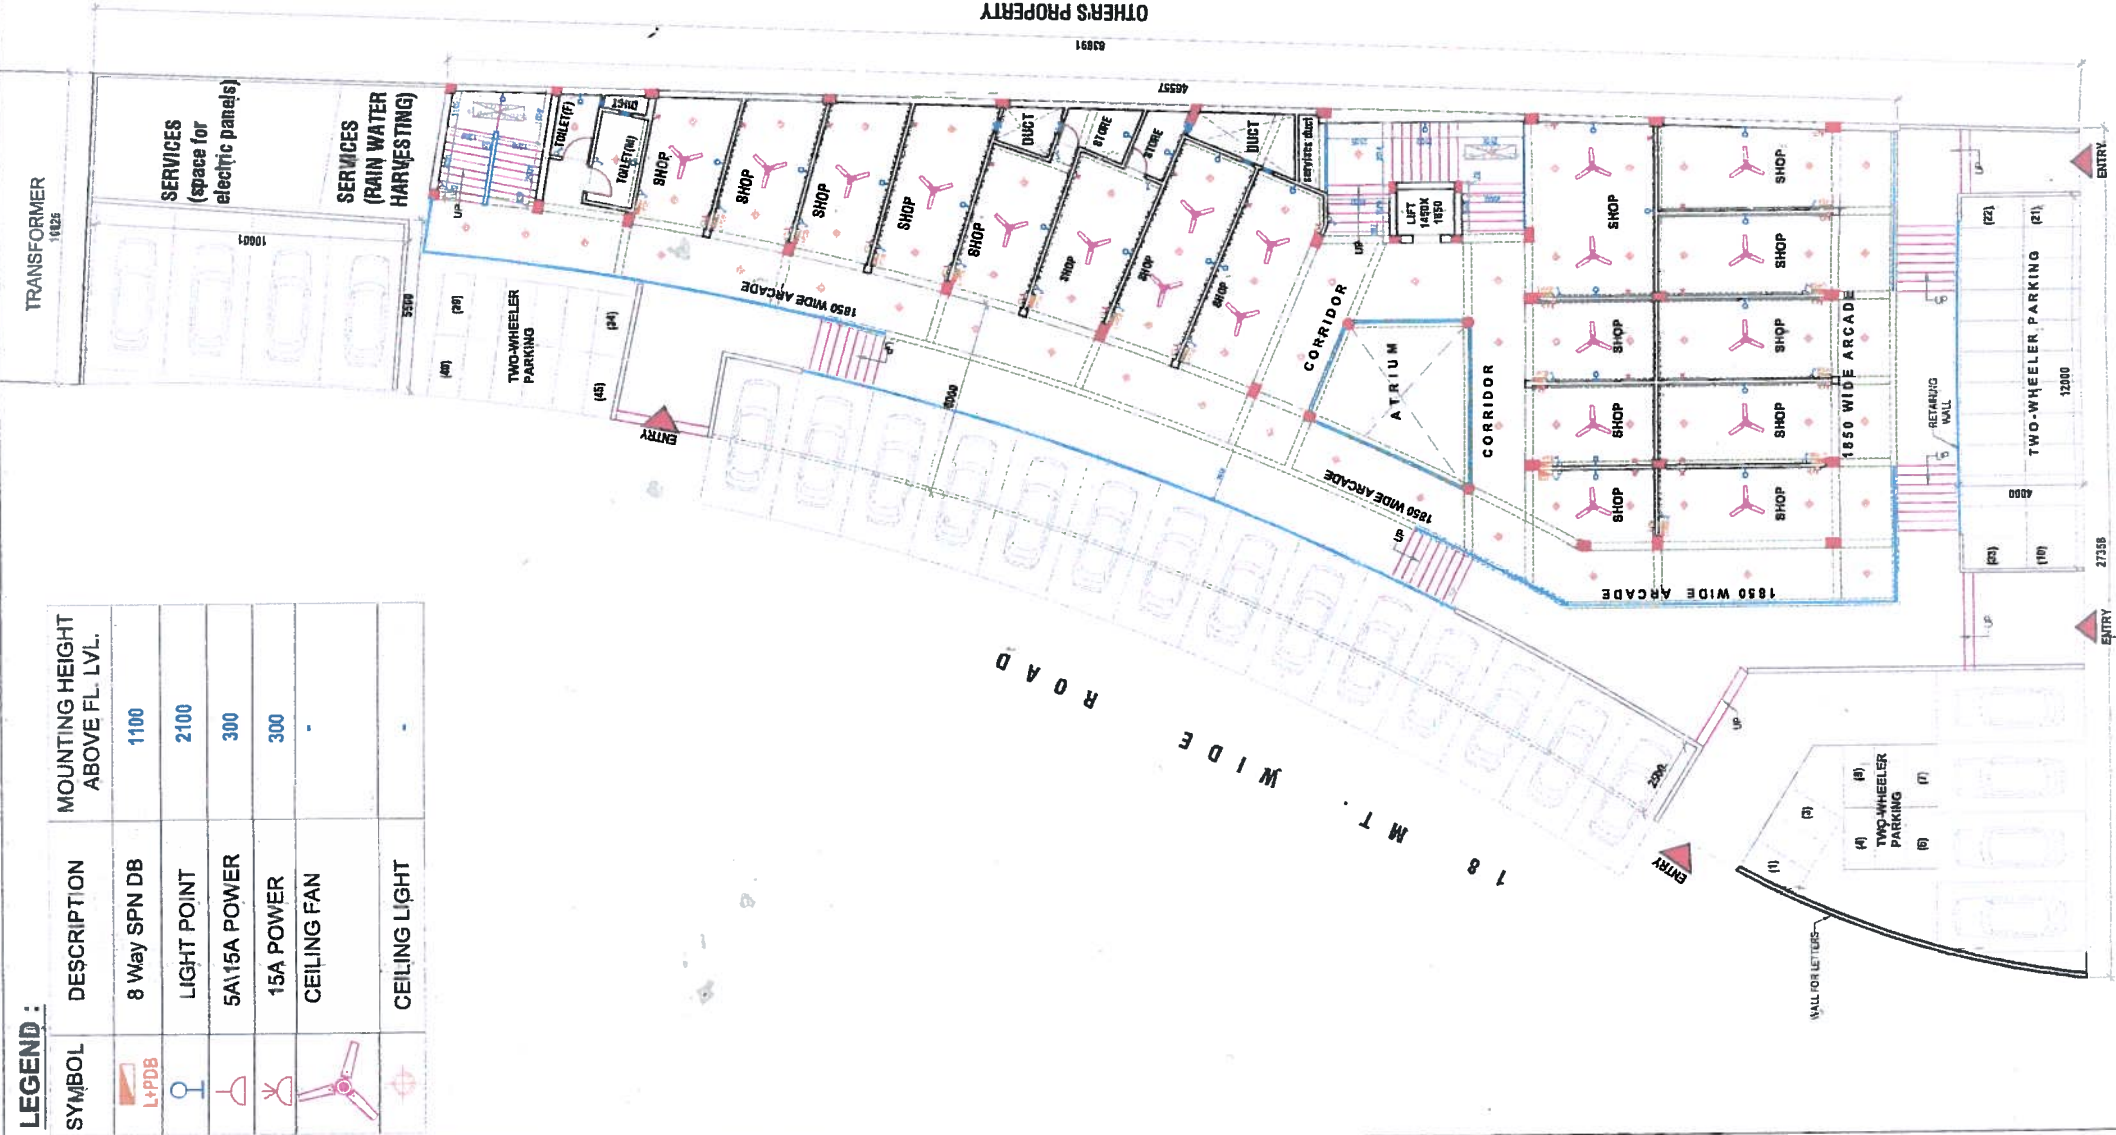

GROUND FLOOR PLAN

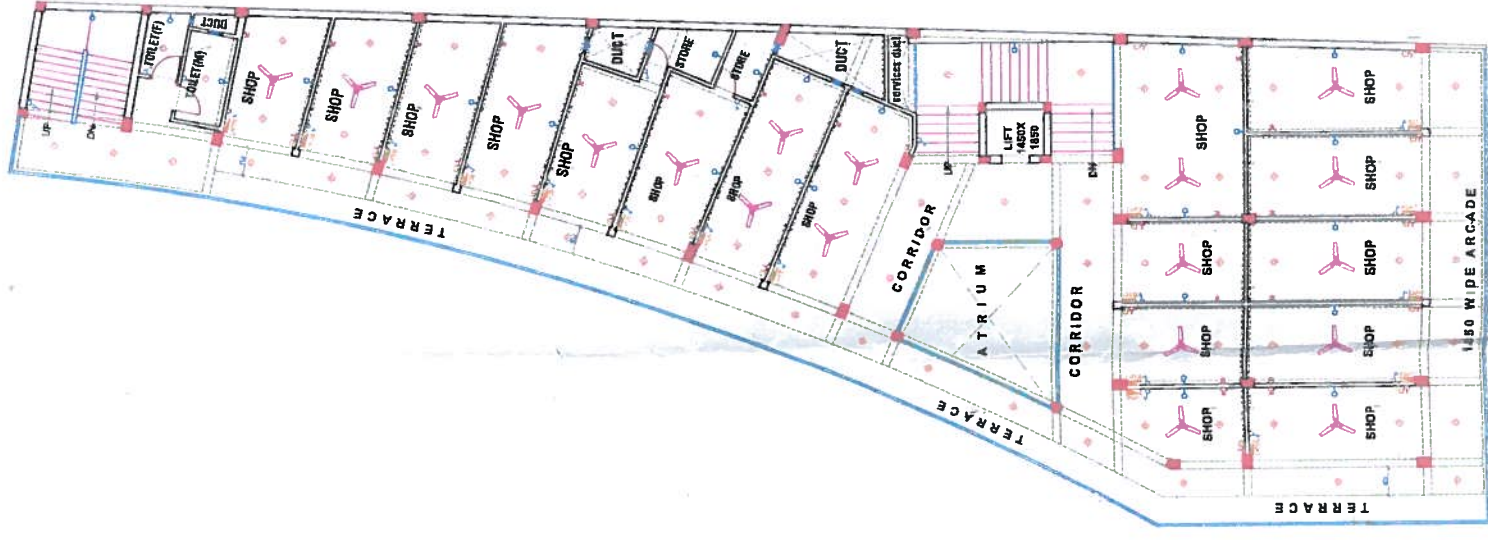

FIRST FLOOR PLAN

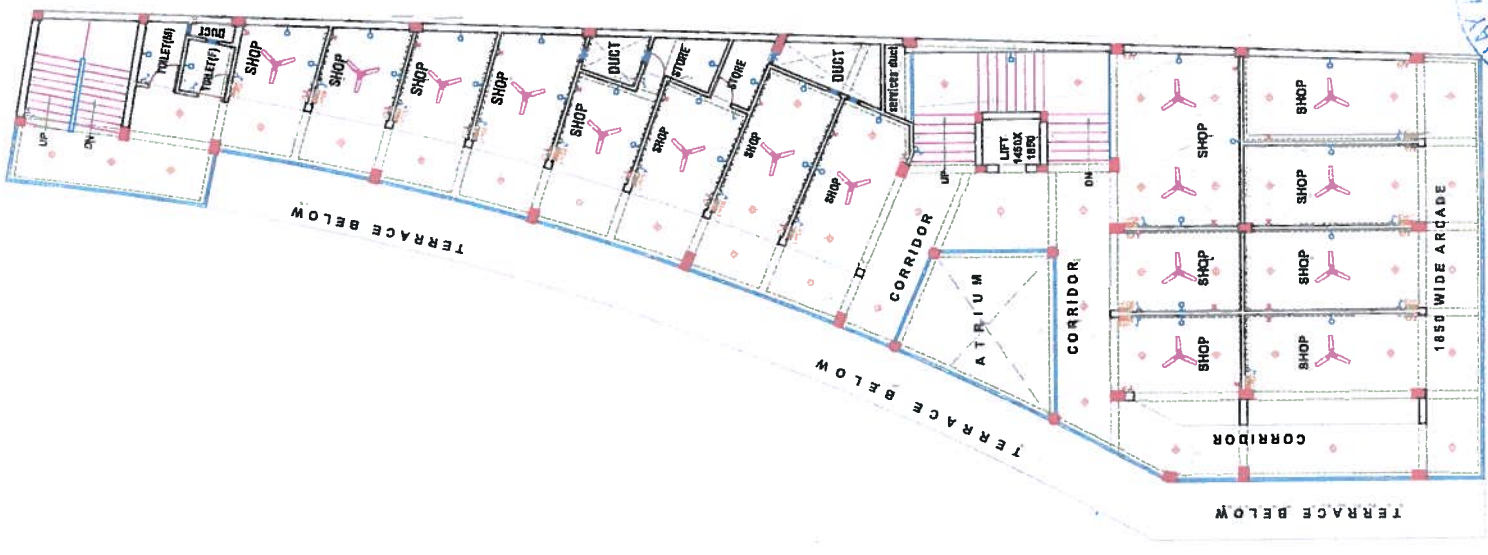

SECOND FLOOR PLAN

NOTES:
1. ALL DIMENSIONS ARE IN MM AND ONLY WRITTEN DIMENSIONS SHALL BE FOLLOWED.
2. DRAWINGS SHALL BE CHECKED BEFORE EXECUTION. INCONSISTENCY IF ANY SHALL BE BROUGHT TO THE NOTICE OF THE ARCHITECT IMMEDIATELY.

FOR APPROVAL
FOR ESTIMATION/TENDER
FOR CONSTRUCTION

No.	Revision	Date
ELECTRICAL LAYOUT		
PROJECT:		
PROPOSED LOCAL SHOPPING-ORO CITY, JANKIPURAM EXTENSION, GRAM-NADIAQM, TEHSIL-BANSU KA TALAQ-KURSI, ROAD-LICHKHOW		
Developer:		
M/S ORO CONSTRUCTIONS PVT. LTD.		
espace		
Air. Sanjay Kumar Gupta 108 F. Floor Corporate Chamber-1, Vishnu Kranti Gauri Nagar, Lucknow-226005, U.P. Phone: 0522-2222222, 0522-2222222 Email: space.oro@gmail.com		
Drawn by:	SGR	
Checked by:	SANJAY K. GUPTA	
Date:	19/11/2019	
Scale:	1:100	
Sheet no.:	ORO SHOPPING E-01	