


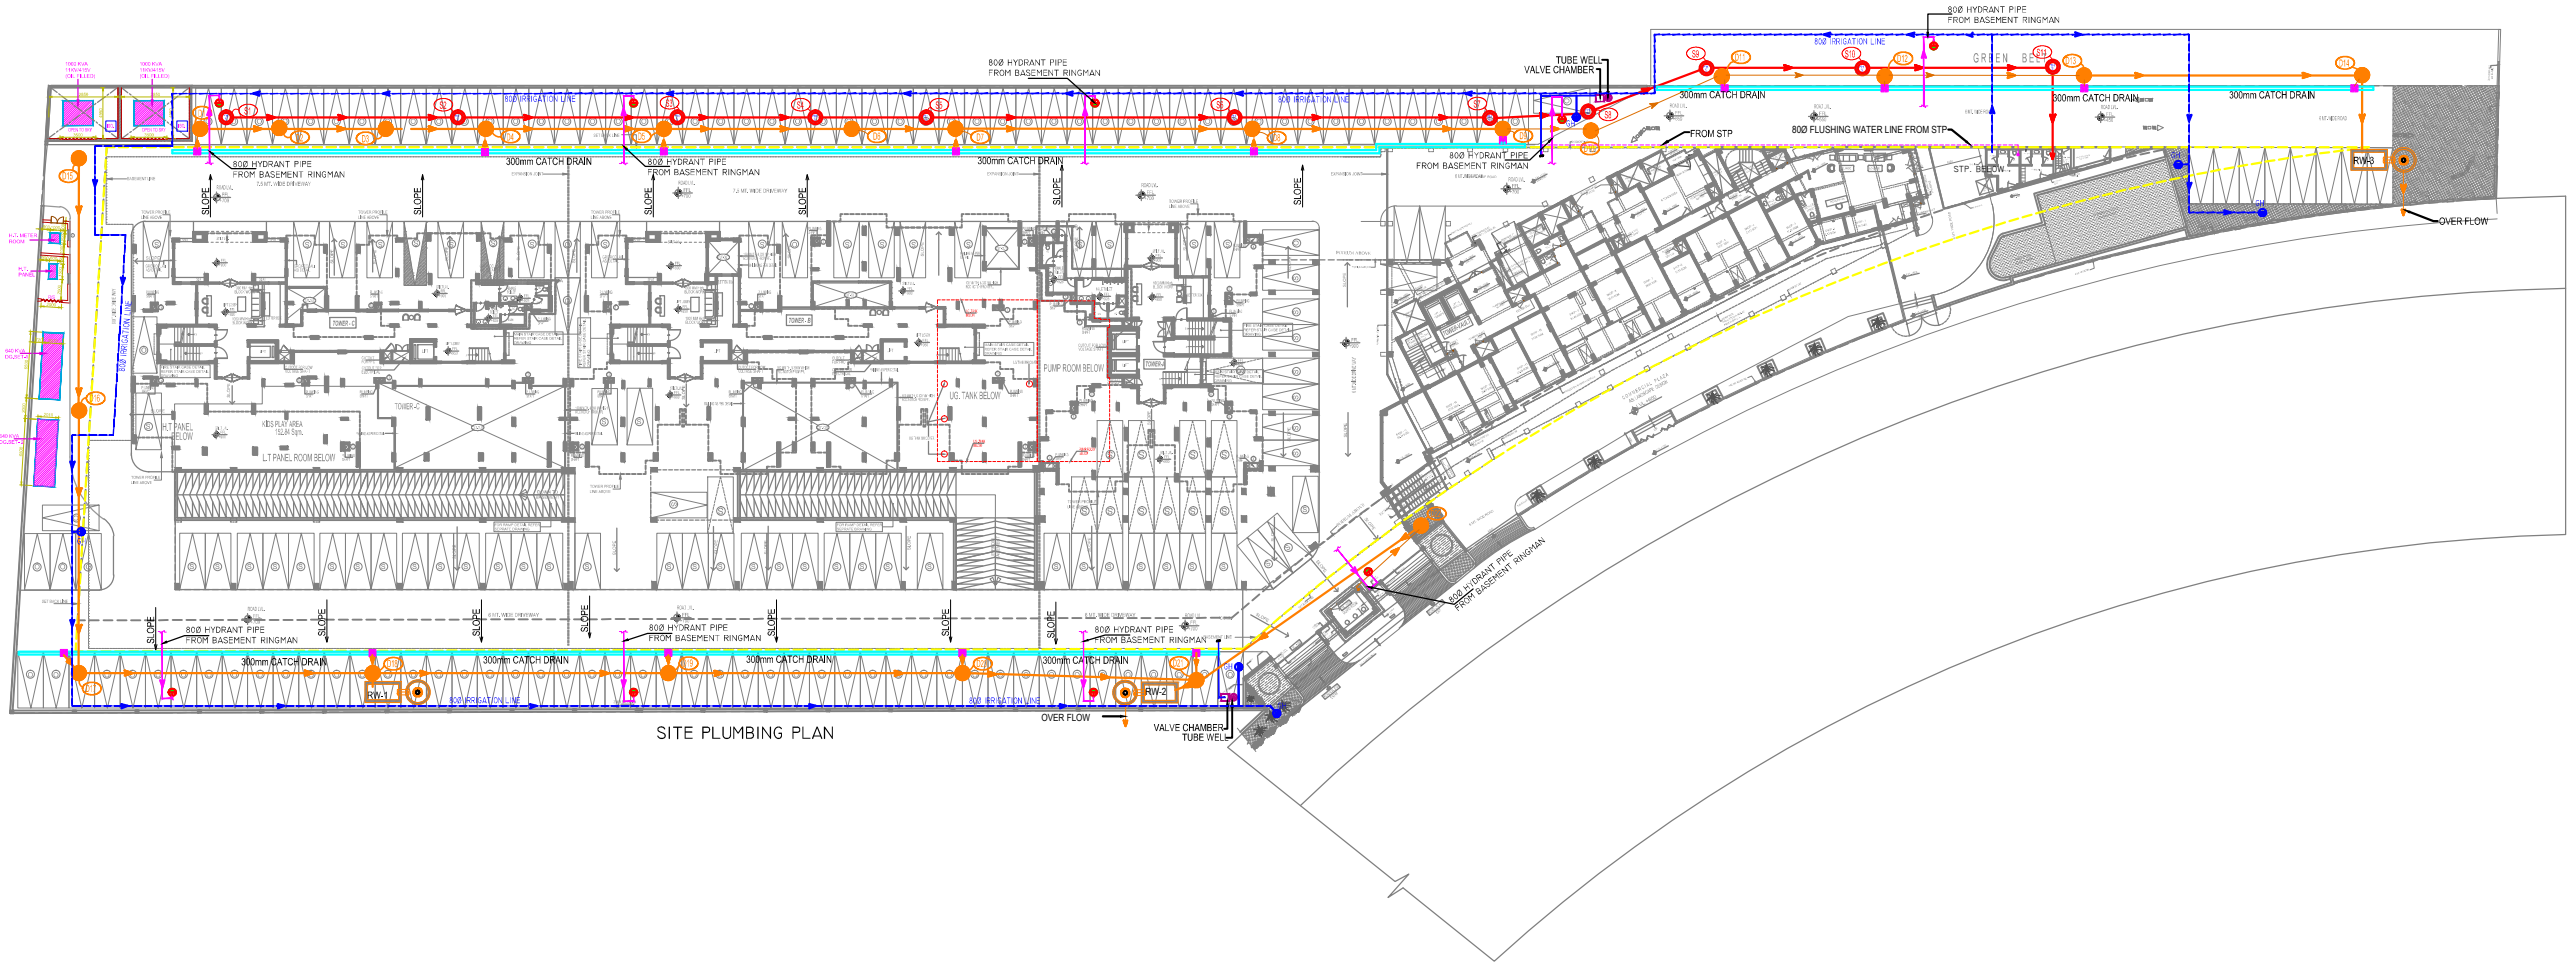

SITE PLUMBING PLAN

NORTH POINT			
THIS DRAWING IS A "COPYRIGHT" AND CONTENT OF THIS DRAWING OR PART THERE OF MAY NOT BE USED OR REPRODUCED WITHOUT THE PERMISSION OF THE ARCHITECT.			
NO. OF PRINT	DATE	ISSUED TO	REMARKS
REVISION	DATE	DESCRIPTION	BY

LEGEND		
1.	800mm HYDRANT PIPE	
2.	300mm CATCH DRAIN	
3.	800mm FLUSHING WATER LINE	
4.	300mm CATCH DRAIN WITH GENTLE SLOPE	
5.	800mm HYDRANT PIPE FROM BASEMENT RINGMAN	
6.	300mm CATCH DRAIN FROM BASEMENT RINGMAN	
7.	800mm FLUSHING WATER LINE FROM STP	
8.	300mm CATCH DRAIN FROM STP	
9.	800mm HYDRANT PIPE FROM BASEMENT RINGMAN	
10.	300mm CATCH DRAIN FROM BASEMENT RINGMAN	
11.	800mm FLUSHING WATER LINE FROM STP	
12.	300mm CATCH DRAIN FROM STP	
13.	800mm HYDRANT PIPE FROM BASEMENT RINGMAN	
14.	300mm CATCH DRAIN FROM BASEMENT RINGMAN	
15.	800mm FLUSHING WATER LINE FROM STP	
16.	300mm CATCH DRAIN FROM STP	
17.	800mm HYDRANT PIPE FROM BASEMENT RINGMAN	
18.	300mm CATCH DRAIN FROM BASEMENT RINGMAN	
19.	800mm FLUSHING WATER LINE FROM STP	
20.	300mm CATCH DRAIN FROM STP	
21.	800mm HYDRANT PIPE FROM BASEMENT RINGMAN	
22.	300mm CATCH DRAIN FROM BASEMENT RINGMAN	
23.	800mm FLUSHING WATER LINE FROM STP	
24.	300mm CATCH DRAIN FROM STP	
25.	800mm HYDRANT PIPE FROM BASEMENT RINGMAN	
26.	300mm CATCH DRAIN FROM BASEMENT RINGMAN	
27.	800mm FLUSHING WATER LINE FROM STP	
28.	300mm CATCH DRAIN FROM STP	
29.	800mm HYDRANT PIPE FROM BASEMENT RINGMAN	
30.	300mm CATCH DRAIN FROM BASEMENT RINGMAN	
31.	800mm FLUSHING WATER LINE FROM STP	
32.	300mm CATCH DRAIN FROM STP	
33.	800mm HYDRANT PIPE FROM BASEMENT RINGMAN	
34.	300mm CATCH DRAIN FROM BASEMENT RINGMAN	
35.	800mm FLUSHING WATER LINE FROM STP	
36.	300mm CATCH DRAIN FROM STP	
37.	800mm HYDRANT PIPE FROM BASEMENT RINGMAN	
38.	300mm CATCH DRAIN FROM BASEMENT RINGMAN	
39.	800mm FLUSHING WATER LINE FROM STP	
40.	300mm CATCH DRAIN FROM STP	
41.	800mm HYDRANT PIPE FROM BASEMENT RINGMAN	
42.	300mm CATCH DRAIN FROM BASEMENT RINGMAN	
43.	800mm FLUSHING WATER LINE FROM STP	
44.	300mm CATCH DRAIN FROM STP	
45.	800mm HYDRANT PIPE FROM BASEMENT RINGMAN	
46.	300mm CATCH DRAIN FROM BASEMENT RINGMAN	
47.	800mm FLUSHING WATER LINE FROM STP	
48.	300mm CATCH DRAIN FROM STP	
49.	800mm HYDRANT PIPE FROM BASEMENT RINGMAN	
50.	300mm CATCH DRAIN FROM BASEMENT RINGMAN	
51.	800mm FLUSHING WATER LINE FROM STP	
52.	300mm CATCH DRAIN FROM STP	
53.	800mm HYDRANT PIPE FROM BASEMENT RINGMAN	
54.	300mm CATCH DRAIN FROM BASEMENT RINGMAN	
55.	800mm FLUSHING WATER LINE FROM STP	
56.	300mm CATCH DRAIN FROM STP	
57.	800mm HYDRANT PIPE FROM BASEMENT RINGMAN	
58.	300mm CATCH DRAIN FROM BASEMENT RINGMAN	
59.	800mm FLUSHING WATER LINE FROM STP	
60.	300mm CATCH DRAIN FROM STP	
61.	800mm HYDRANT PIPE FROM BASEMENT RINGMAN	
62.	300mm CATCH DRAIN FROM BASEMENT RINGMAN	
63.	800mm FLUSHING WATER LINE FROM STP	
64.	300mm CATCH DRAIN FROM STP	
65.	800mm HYDRANT PIPE FROM BASEMENT RINGMAN	
66.	300mm CATCH DRAIN FROM BASEMENT RINGMAN	
67.	800mm FLUSHING WATER LINE FROM STP	
68.	300mm CATCH DRAIN FROM STP	
69.	800mm HYDRANT PIPE FROM BASEMENT RINGMAN	
70.	300mm CATCH DRAIN FROM BASEMENT RINGMAN	
71.	800mm FLUSHING WATER LINE FROM STP	
72.	300mm CATCH DRAIN FROM STP	
73.	800mm HYDRANT PIPE FROM BASEMENT RINGMAN	
74.	300mm CATCH DRAIN FROM BASEMENT RINGMAN	
75.	800mm FLUSHING WATER LINE FROM STP	
76.	300mm CATCH DRAIN FROM STP	
77.	800mm HYDRANT PIPE FROM BASEMENT RINGMAN	
78.	300mm CATCH DRAIN FROM BASEMENT RINGMAN	
79.	800mm FLUSHING WATER LINE FROM STP	
80.	300mm CATCH DRAIN FROM STP	
81.	800mm HYDRANT PIPE FROM BASEMENT RINGMAN	
82.	300mm CATCH DRAIN FROM BASEMENT RINGMAN	
83.	800mm FLUSHING WATER LINE FROM STP	
84.	300mm CATCH DRAIN FROM STP	
85.	800mm HYDRANT PIPE FROM BASEMENT RINGMAN	
86.	300mm CATCH DRAIN FROM BASEMENT RINGMAN	
87.	800mm FLUSHING WATER LINE FROM STP	
88.	300mm CATCH DRAIN FROM STP	
89.	800mm HYDRANT PIPE FROM BASEMENT RINGMAN	
90.	300mm CATCH DRAIN FROM BASEMENT RINGMAN	
91.	800mm FLUSHING WATER LINE FROM STP	
92.	300mm CATCH DRAIN FROM STP	
93.	800mm HYDRANT PIPE FROM BASEMENT RINGMAN	
94.	300mm CATCH DRAIN FROM BASEMENT RINGMAN	
95.	800mm FLUSHING WATER LINE FROM STP	
96.	300mm CATCH DRAIN FROM STP	
97.	800mm HYDRANT PIPE FROM BASEMENT RINGMAN	
98.	300mm CATCH DRAIN FROM BASEMENT RINGMAN	
99.	800mm FLUSHING WATER LINE FROM STP	
100.	300mm CATCH DRAIN FROM STP	

DRAWING FOR :-	
FTP	☐ FOR SUBMISSION
FAO	☐ FOR APPROVAL ONLY
FAC	☐ FOR ADVANCE COPY
GFC	☐ GOOD FOR CONSTRUCTION



CLIENT
OASIS BUILD MART (INDIA) PVT.LTD.

PROJECT

VENETIA HEIGHTS

PROPOSED GROUP HOUSING FOR OASIS BUILD MART (INDIA) PVT. LTD.
AT PLOT NO. HRA-12A AT I.A. SURAJPUR SITE-C (EXT.) HOUSING SECTOR PHASE-2, G.B. NAGAR, (U.P.)

DATE	PROJECT INCHARGE	CHECKED BY
10.08.2017	BHEEM	P. SHARMA
SCALE	DEALT BY	APPROVED BY
NTS	BHEEM	PKS

DRAWING TITLE

PLUMBING LAYOUT PLAN

CONSULTANTS

PEE CONSULTANTS

815-2, DOA PLATS
SHAHADRA, DELHI-49

Ph: +91-11-22818857
Fax: +91-11-22818857

www.peeconsultants.com
pee@peeconsultants.com

ARCHITECTS

Confluence

815-2, DOA PLATS
SHAHADRA, DELHI-49

Ph: +91-11-22818857
Fax: +91-11-22818857

www.confluencearchitects.com
confluence@confluencearchitects.com

DRAWING NO.	REVISION
PLSITE01	R0