



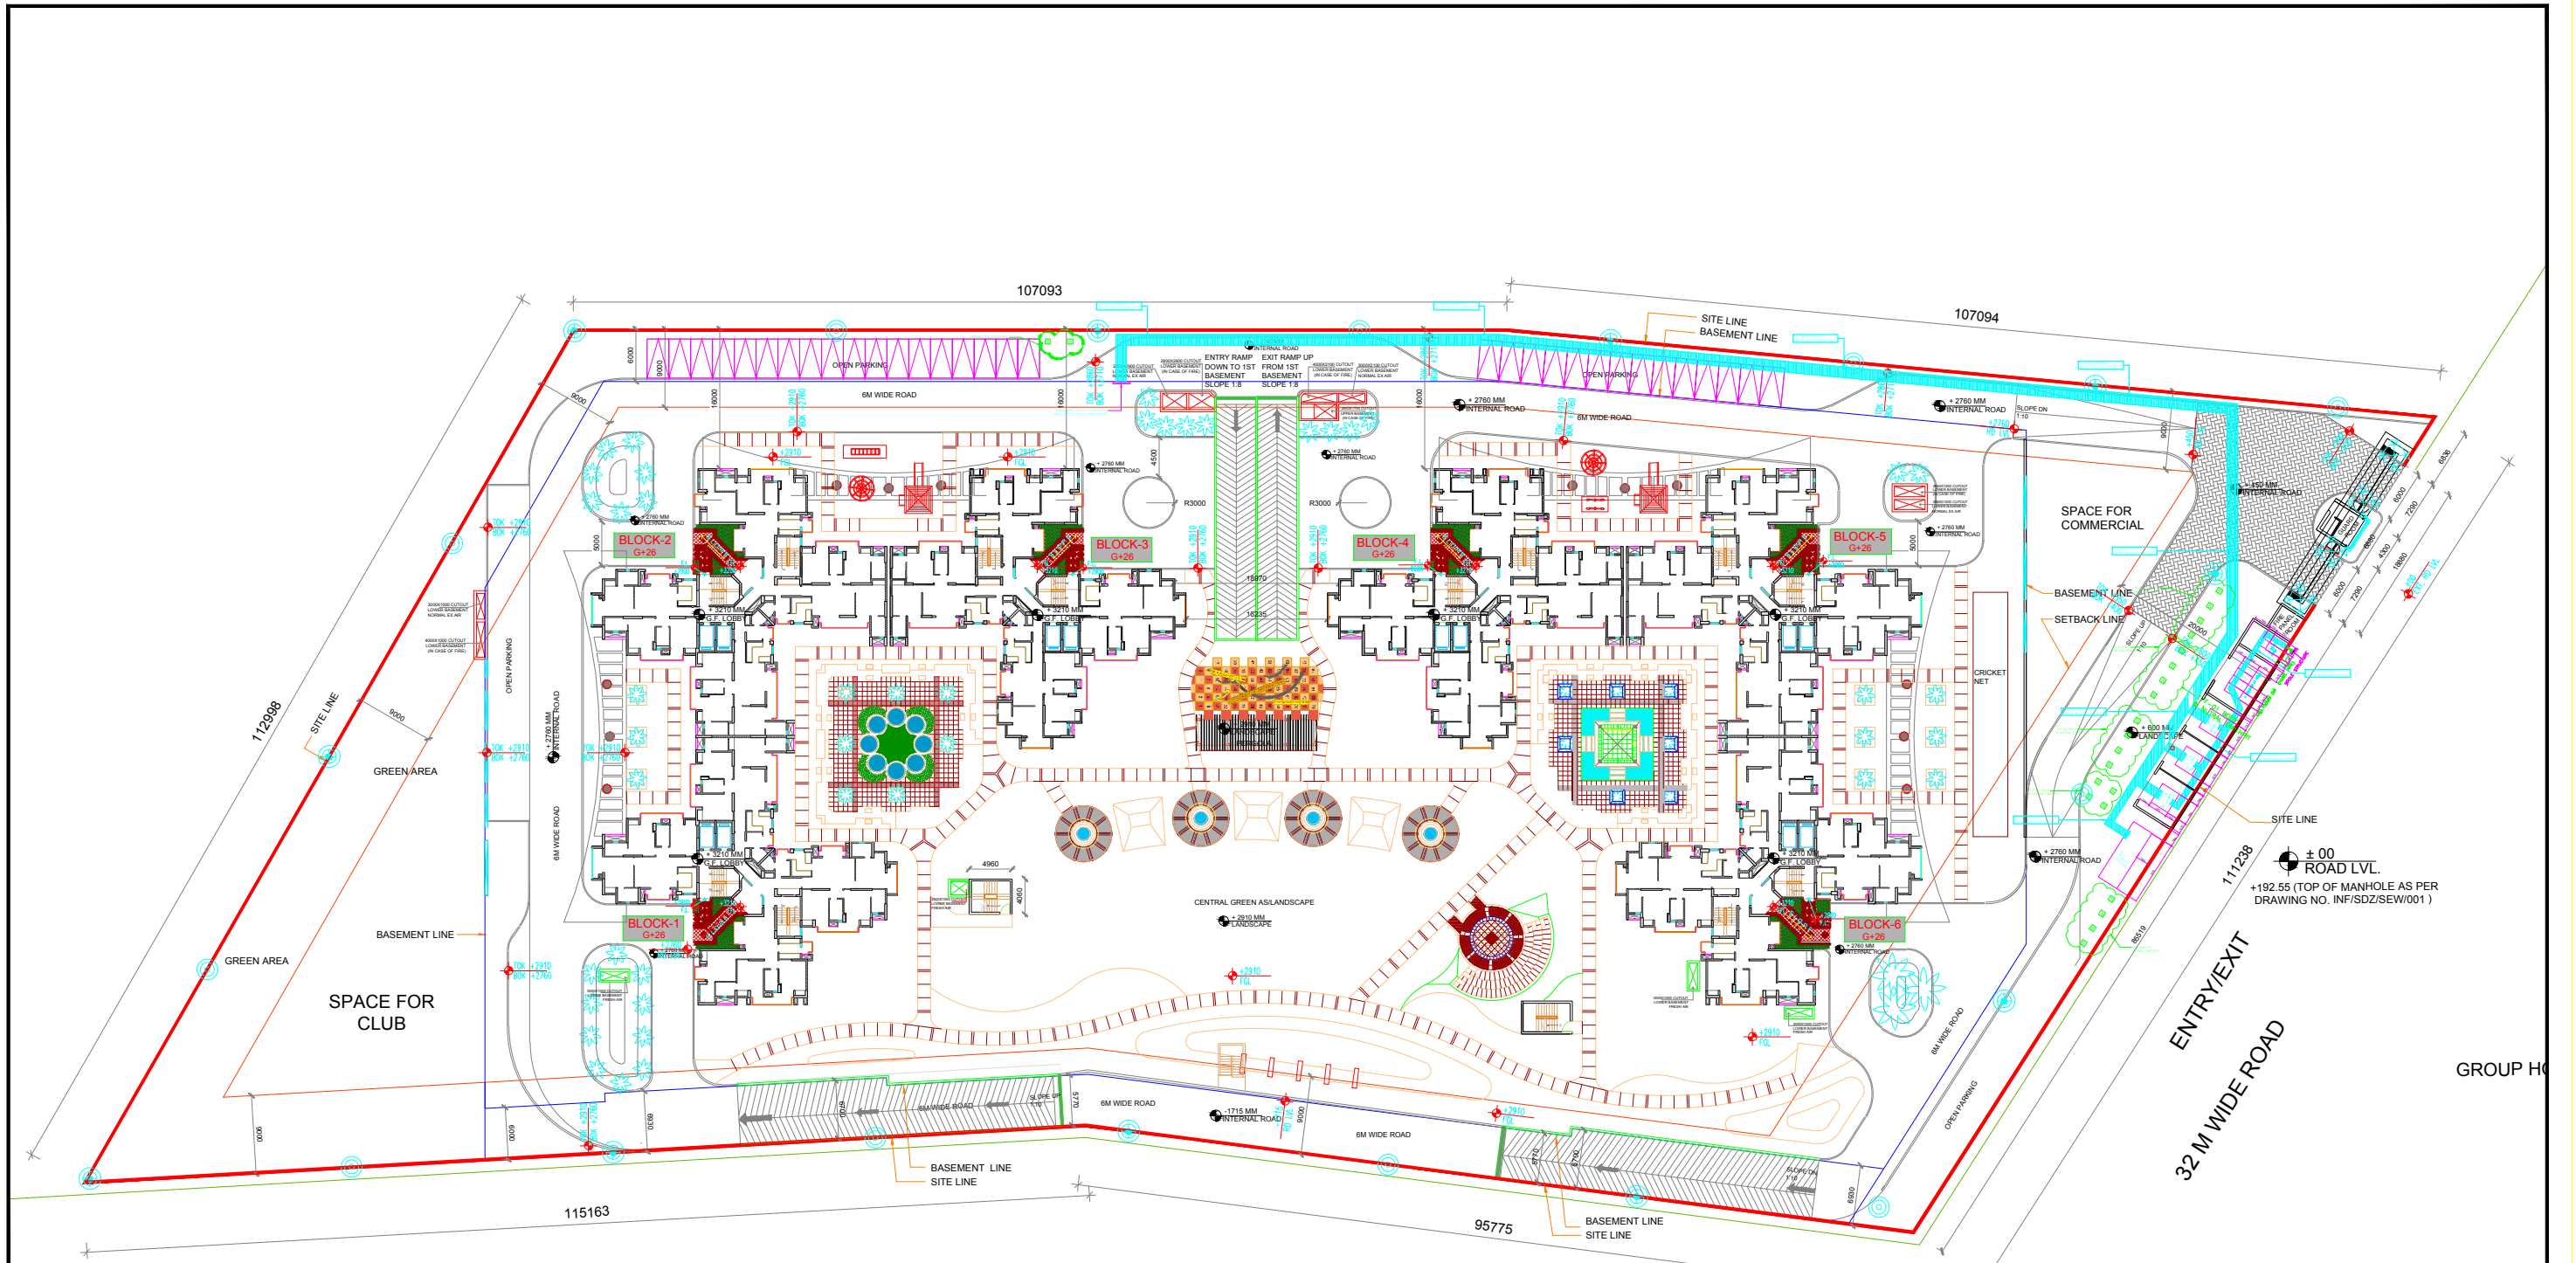

ELECTRICAL LEGEND	
1.	8Mtr HEIGHT POLE WITH 78W LED LIGHT WITH SOLLAR BECKUP
2.	8Mtr HEIGHT POLE WITH 78W LED LIGHT
3.	POST TOP LANTERN
4.	4Mtr HEIGHT POLE WITH 19W LED LIGHT
5.	FEEDER PILLAR

PROJECT
MIRAGE HOMES
PROPOSED GROUP HOUSING DEVELOPMENT ON PLOT NO. GH- F3, SECTOR 25, JAYPEE GREENS SPORTS CITY (SDZ,) DISTRICT GAUTAM BUDH NAGAR, U.P.
OWNER
IMPERIA HOMES PVT. LIMITED
A-25, MOHAN CO-OPERATIVE INDUSTRIAL ESTATE, MATHURA ROAD, NEW DELHI.

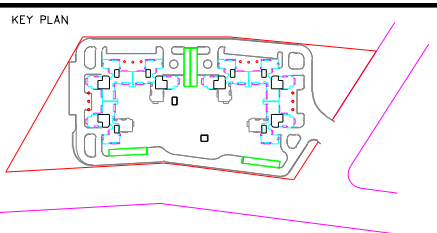

PHASE-2

This drawing & design is the copyright of the designer. No portion of this drawing may be reproduced without the written permission of the designers.

All dimensions are in millimeter unless otherwise specified. Dimensions shall not be scaled off the drawing.

This drawing shall be read in conjunction with structural and other service drawings along with relevant specifications.

Level +0.00 corresponds with the proposed from the access road level

Contractor shall check and verify all dimensions before commencing any construction work, and discrepancy or omission to be immediately reported to the architect of designer.

STRUCTURAL CONSULTANT
Technical Projects Consultants Pvt. Ltd.
B-74, Sector 07, Noida, U.P. - 201301 Tel: 0120-4308800

PLUMBING & FIRE FIGHTING CONSULTANT
Krim Engineering Services Pvt. Ltd.
E-705, Malviya Nagar, New Delhi-17 Tel: 011-2688 2249

ELECTRICAL CONSULTANT
RAD Infra 148 MBK COHS Sector-13, Dwarka New Delhi-75
Tel: 26168349 e-mail: radinfra2011@gmail.com

HVAC CONSULTANTS
MEP Design Point Hazrat Khair Village New Delhi -16
e-mail: mepdpoint@gmail.com

LANDSCAPE CONSULTANTS
S. J. A. Consultants N 11, Basement, Jangpura Ext. New Delhi 110014 Tel: 011-24320635 e-mail: mail@sjaconsultants.com

NO.	DATE	REVISION/DESCRIPTION	CHECKED	APPROVED
R1	20.12.16	SURFACE PARKING REV.	ASHWANI	R.K.
PROJECT COORDINATOR : A. N. PANGT				
DRAWN BY : KULBANT SHIN				
CHECKED BY : S.V.C				
APPROVED BY : RAJAT KAUSHAL				

DRAWING NAME
ELECTRICAL SUB-STATION LAYOUT SITE PLAN

DATE 23.12.2016 SCALE 1:300 REVISION R2 23.12.2016

DRAWING NO.
RAD/IMGH/EL/101A(ESS)

ARCHITECTS
ACPL
Architecture Management Planning
ISO 9001:2008

ACPL Design Ltd-103 South Extension-1-I-91 11 24622195
New Delhi 110048, India +91 11 24646709
E: contact@acplonline.com +91 11 24634069

NOTE: REFER SEPARATE DRAWINGS FOR LANDSCAPE, RAMP & STAIRCASE DETAILS