


50.00 M Wide Road

Proposed Project (PRATEEK GRAND BEGONIA (PHASE II))

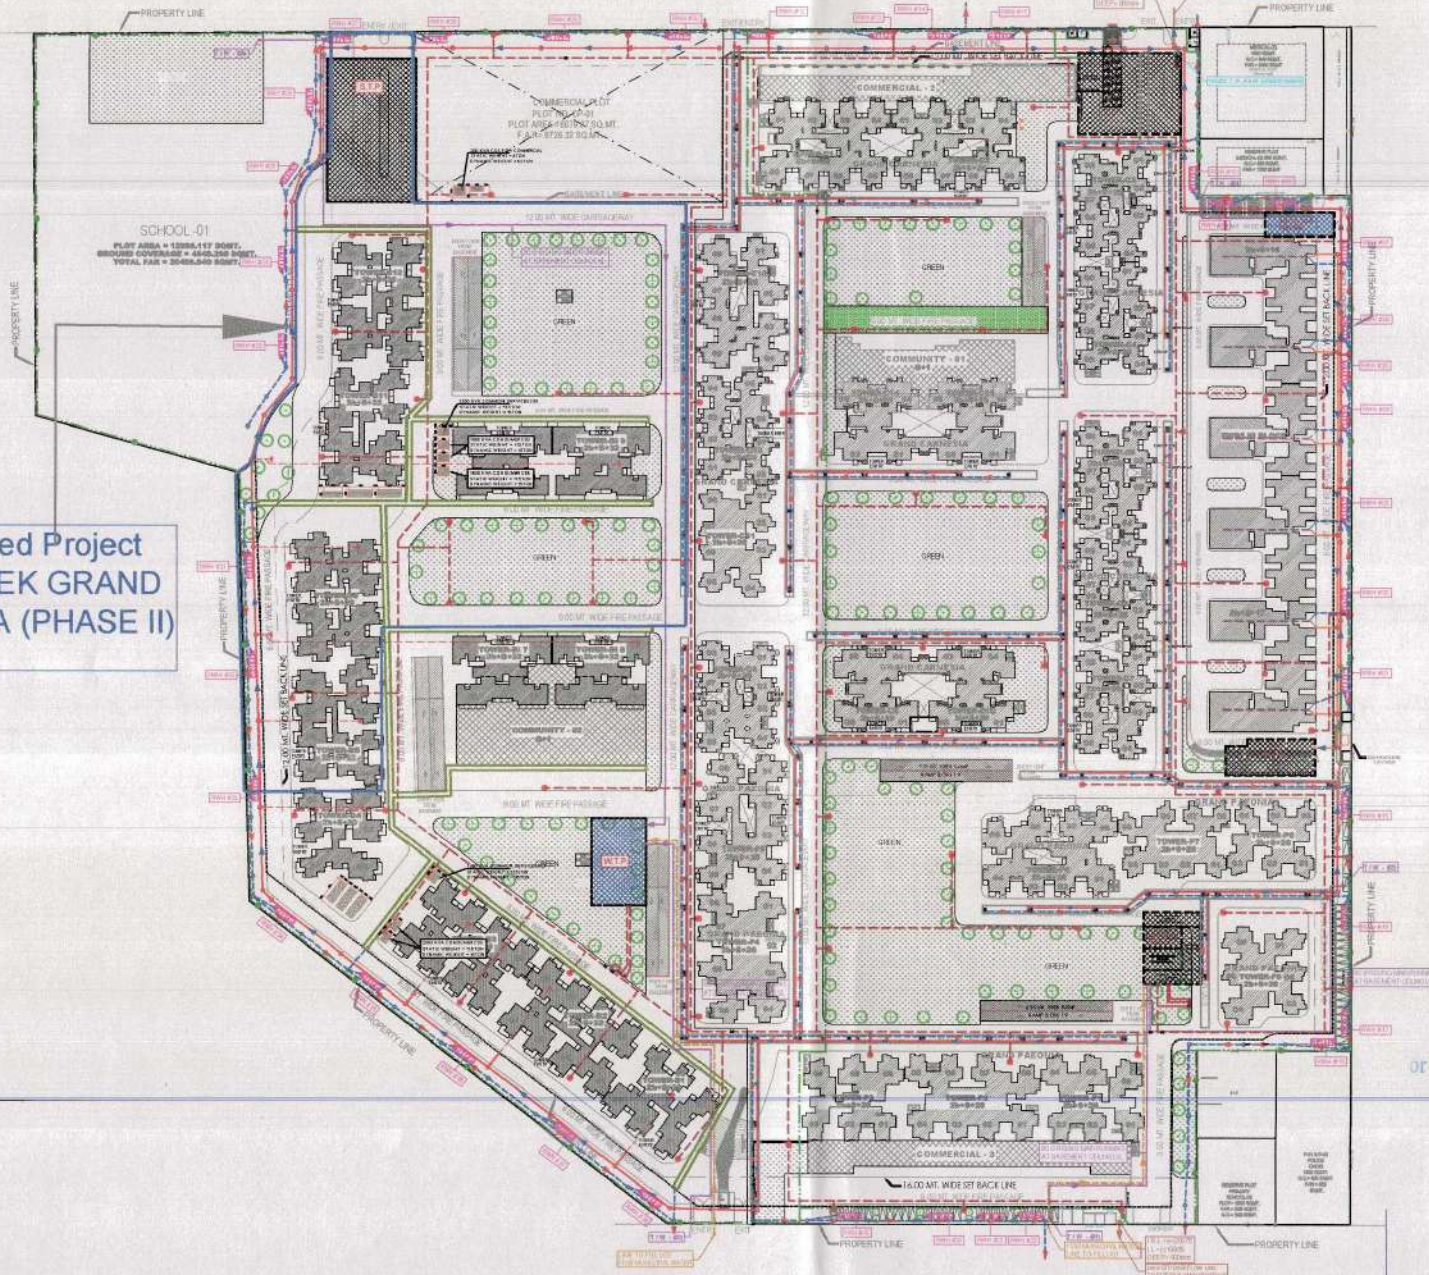

75.00 M Wide Road

LEGEND :		
S. No.	SYMBOL	DESCRIPTION
1	MH	MANHOLE
2	SEWER LINE	SEWER LINE
3	SEWER LINE (DW)	SEWER LINE (DW)
4	C.F.	CATCH PIT
5	UNDERGROUND PIPE/DRAIN	UNDERGROUND PIPE/DRAIN
6	RUN WATER HARVESTING	RUN WATER HARVESTING
7	STAINLESS STEEL	STAINLESS STEEL
8	UNDERGROUND PIPE/DRAIN	UNDERGROUND PIPE/DRAIN
9	UNDERGROUND PIPE/DRAIN	UNDERGROUND PIPE/DRAIN
10	UNDERGROUND PIPE/DRAIN	UNDERGROUND PIPE/DRAIN
11	UNDERGROUND PIPE/DRAIN	UNDERGROUND PIPE/DRAIN
12	UNDERGROUND PIPE/DRAIN	UNDERGROUND PIPE/DRAIN
13	UNDERGROUND PIPE/DRAIN	UNDERGROUND PIPE/DRAIN
14	UNDERGROUND PIPE/DRAIN	UNDERGROUND PIPE/DRAIN

LEGEND : FIRE SYSTEM		
S. No.	SYMBOL	DESCRIPTION
1	—	FIRE LINE
2	YH	YARD HYDRANT
3	—	FIRE BRIGADE CONNECTION
4	—	BUTTERFLY VALVE
5	—	WATER VALVE (CHECK VALVE)
6	—	ISOLATING VALVE WITH WISDOMARY CHAMBER

ALL YARD HYDRANT SHALL BE CONNECTED FROM BASEMENT HYDRANT PIPE

Rev. No.	Date	Revision

project
**PRATEEK GRAND CITY
SIDHARTH VIHAR , GHAZABAD**

title
SITE PLAN

subsite
EXTERNAL COORDINATED LAYOUT

drawing released for	APPROVAL	ADVANCE COPY	SUBMISSION	CONSTRUCTION
drp. no.	PCC/SP/PI-04	drawn by	S. Bhandari	
scale	1:50 @ A1	designed by	Shahin Shah	
date	02.05.2022	checked by	ANAND HAVELI	

architects
Architect Hafeez Contractor
18 Bark Street, Boreilly 3, Tel: +91 22 22841400 — Fax: +91 22 22841401
www.architecthfeezcontractor.com email: hafeez@hfeezcontractor.com

services consultant
Consummate Engineering Services (P) Ltd.
Head Office: B-47, Sector-47, Gurgaon-122002
Tel: 0124 2333333 (Ext. 101)
Lko. Office: H-20, Rohini Phase-I, Gurgaon-122001
e-mail: hsc@consummate.com website: www.consummate.com

or Prateek Realtors India Pvt. Ltd.
Authorised Sign