

यह स्वीकृत/निर्माण अनुमति है। 'पूनाता प्रमाण-पत्र' प्राप्त करने के बाद ही इस परिसर का आंशिक उपयोग किया जा सकेगा।





अपर सोवियत
इलाहाबाद विकास प्राधिकरण
इलाहाबाद

31514
14/11/18
बिनाशपुरी आभरण
इलाहाबाद विकास प्राधिकरण
इलाहाबाद



सहायक अभियन्ता
इलाहाबाद विकास प्राधिकरण
इलाहाबाद

अपर अभियन्ता
इलाहाबाद विकास प्राधिकरण
इलाहाबाद

1ST FLOOR PLAN

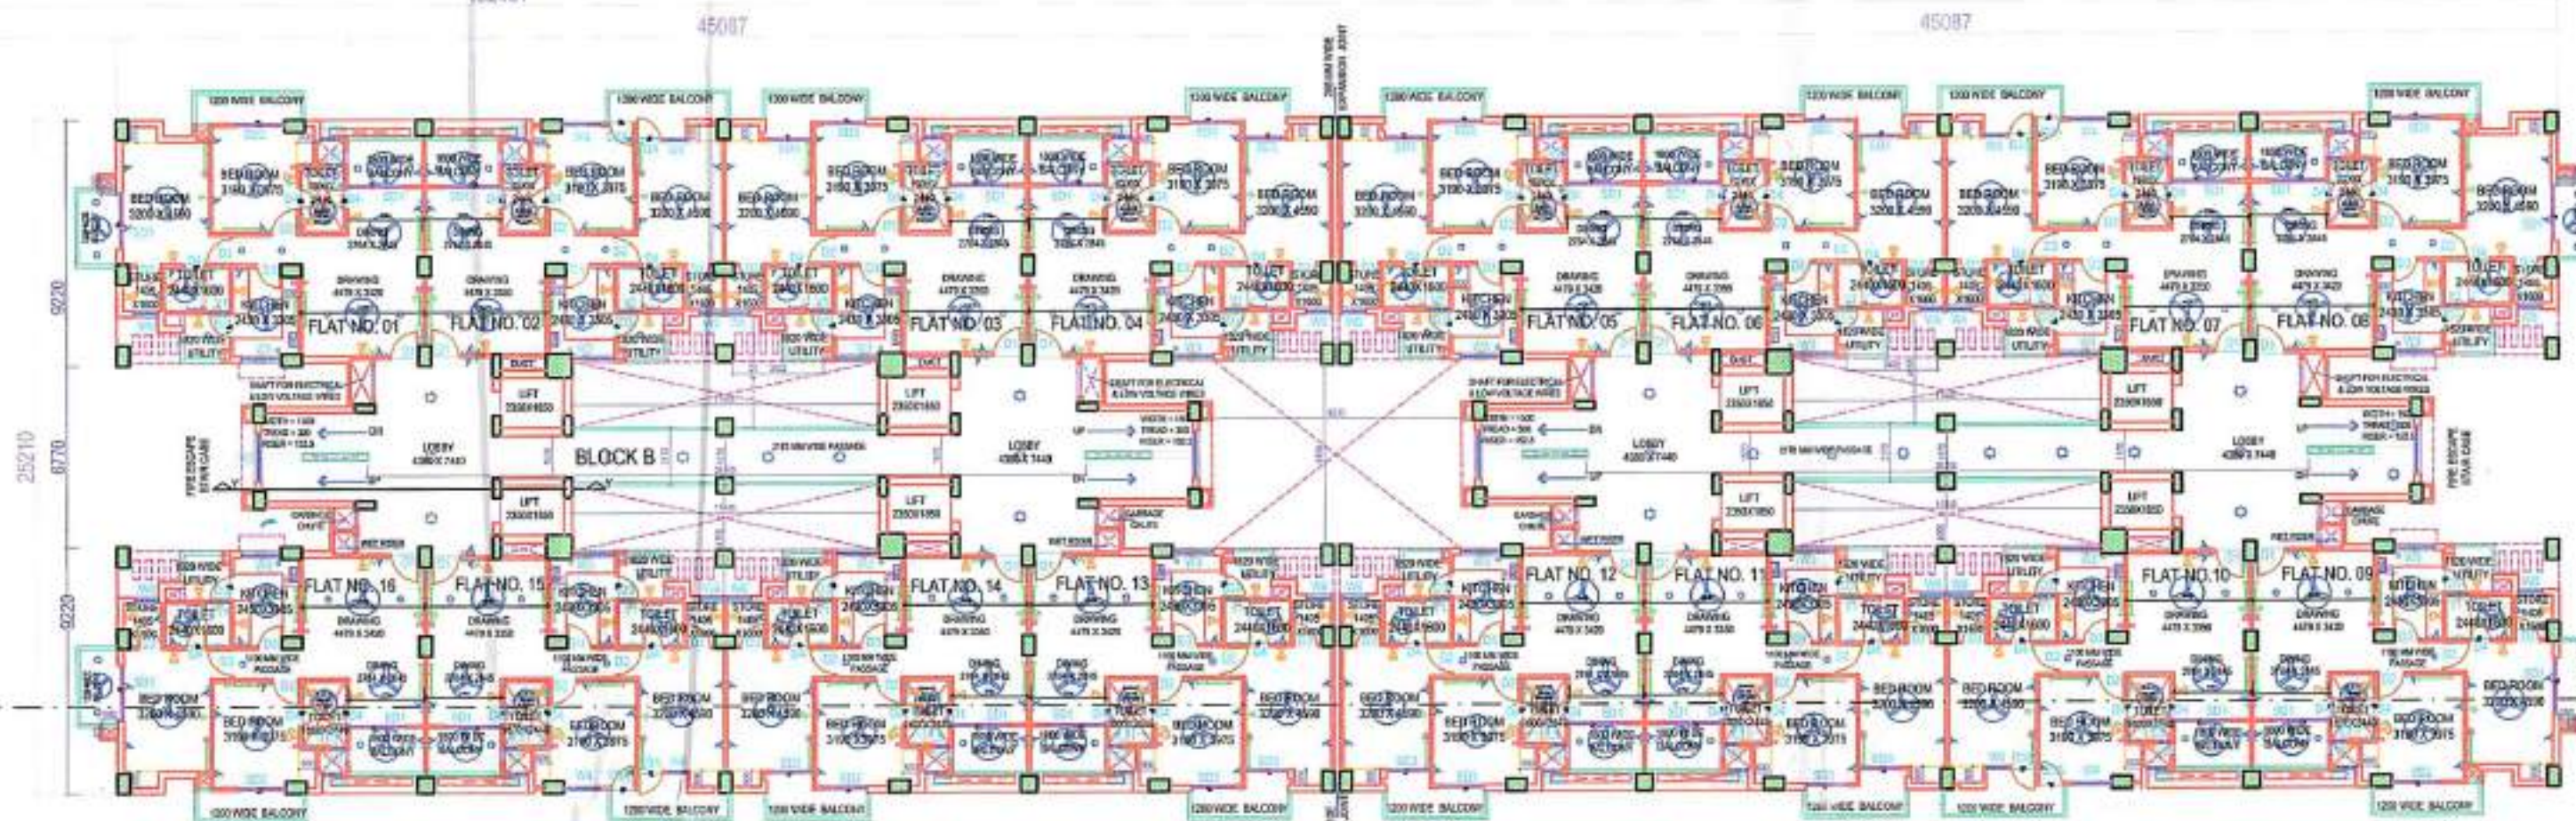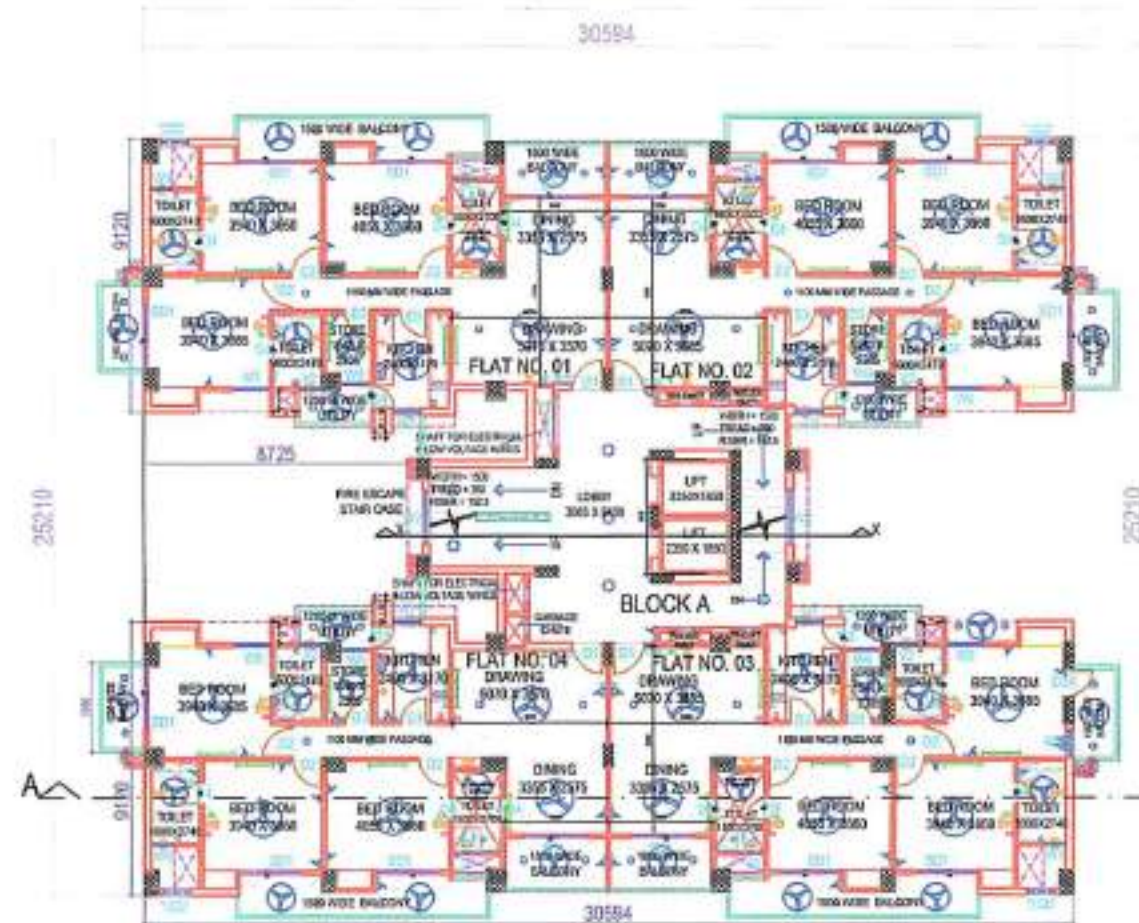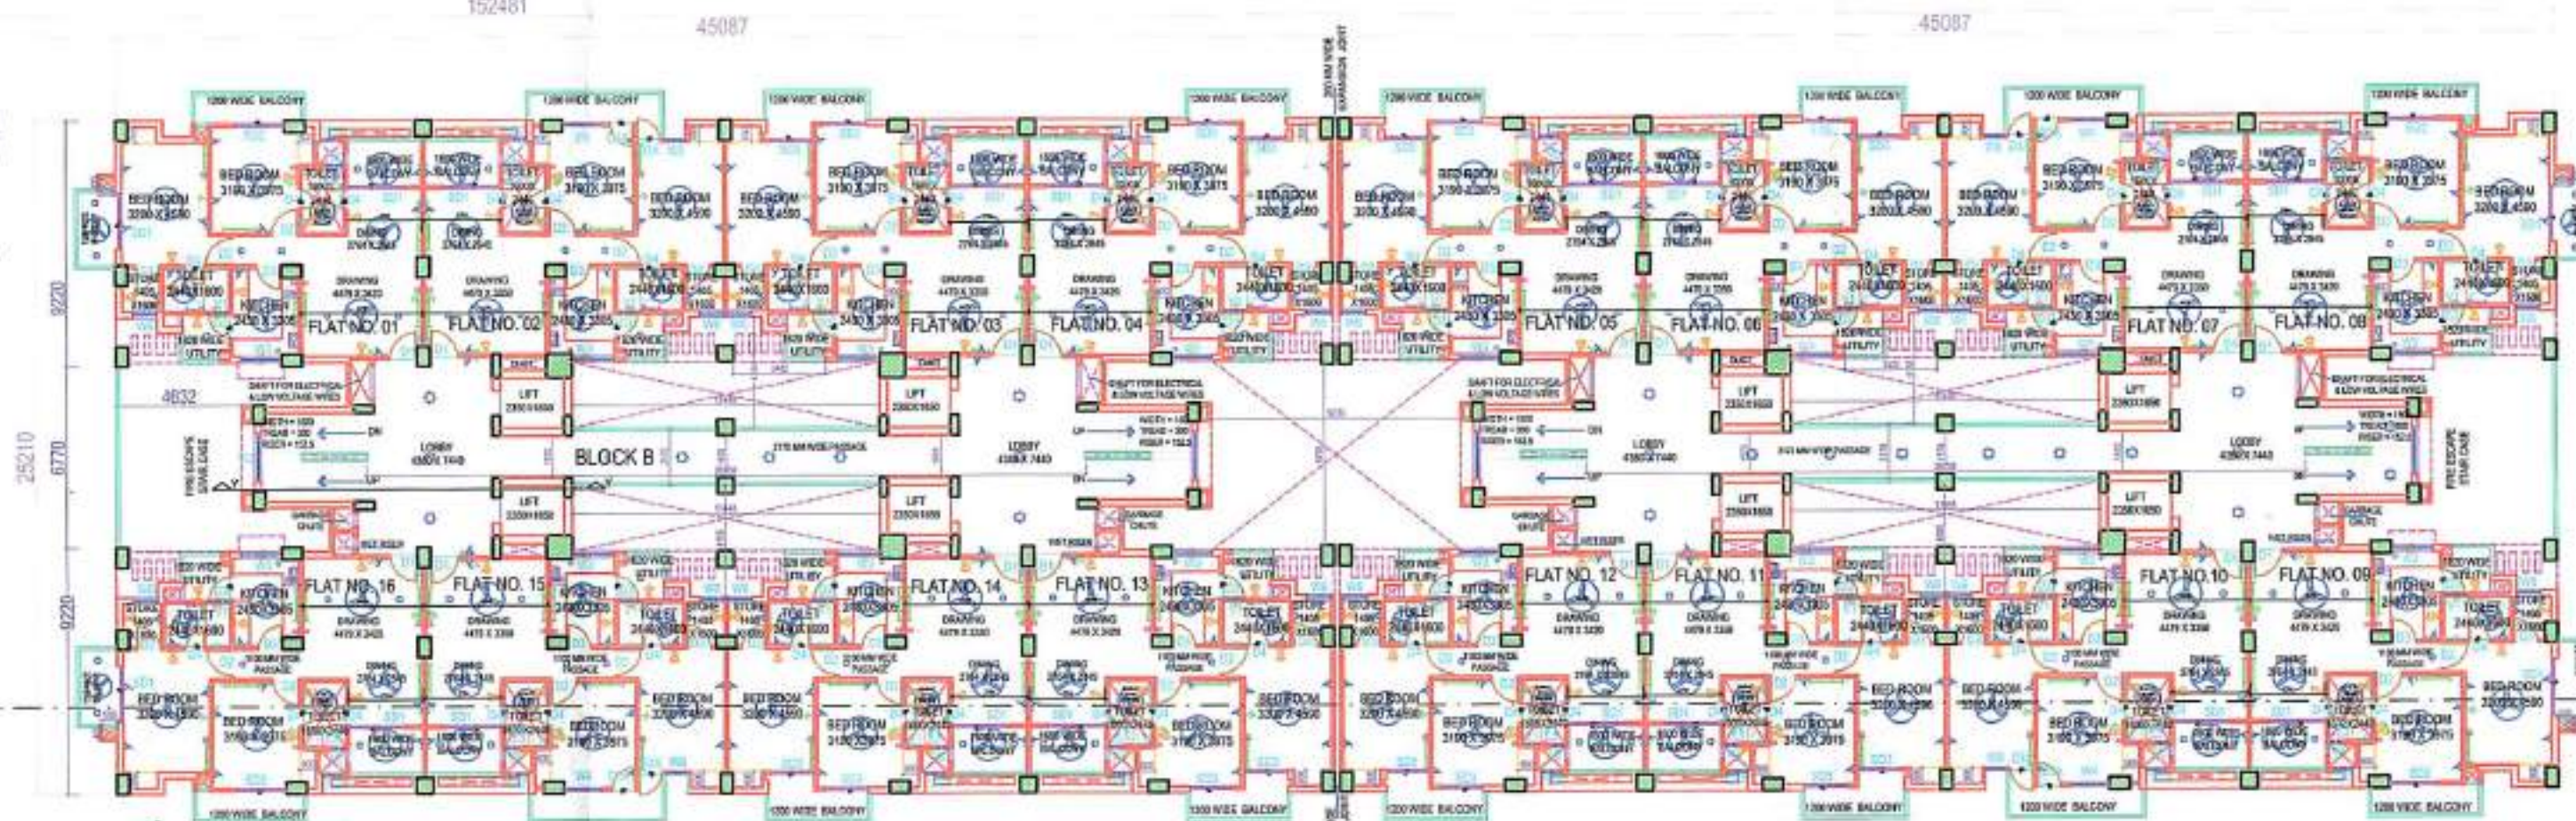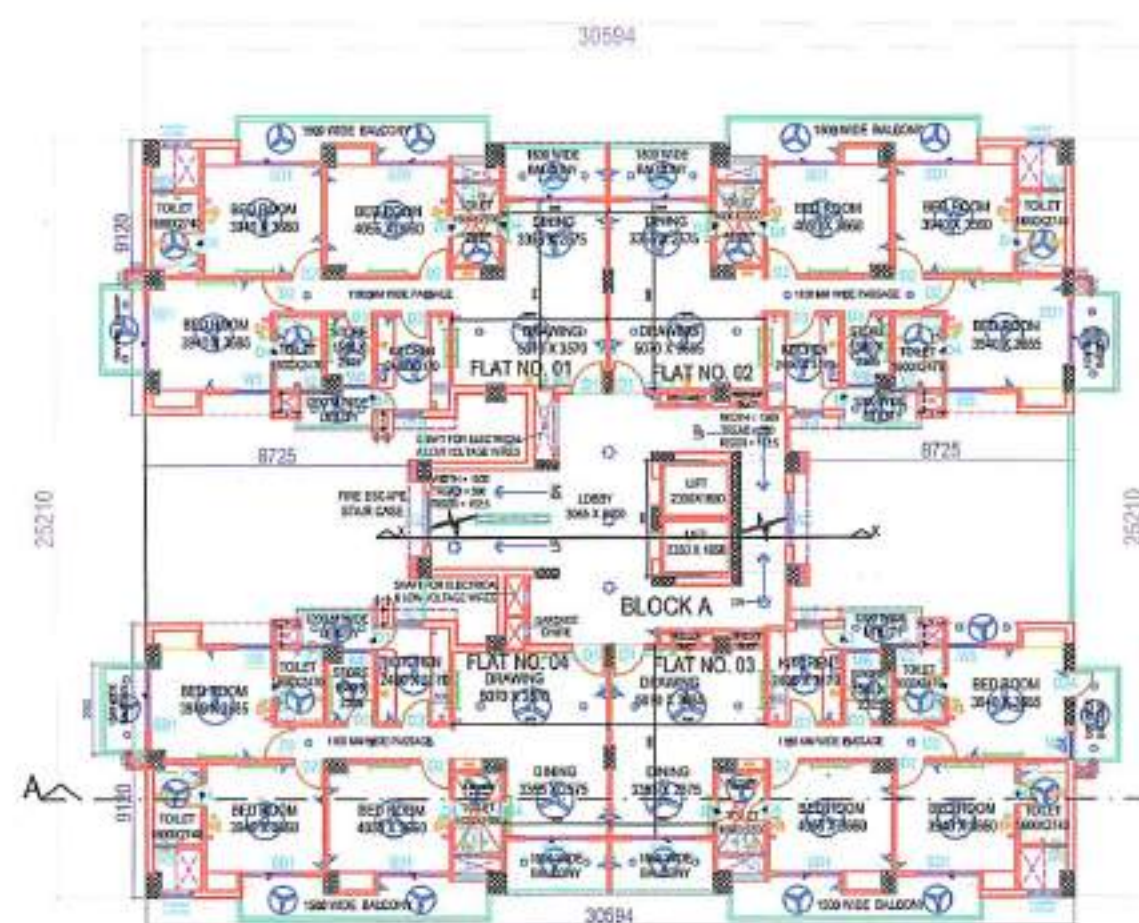

2ND,4TH,6TH,8TH,10TH,12TH FLOOR PLAN

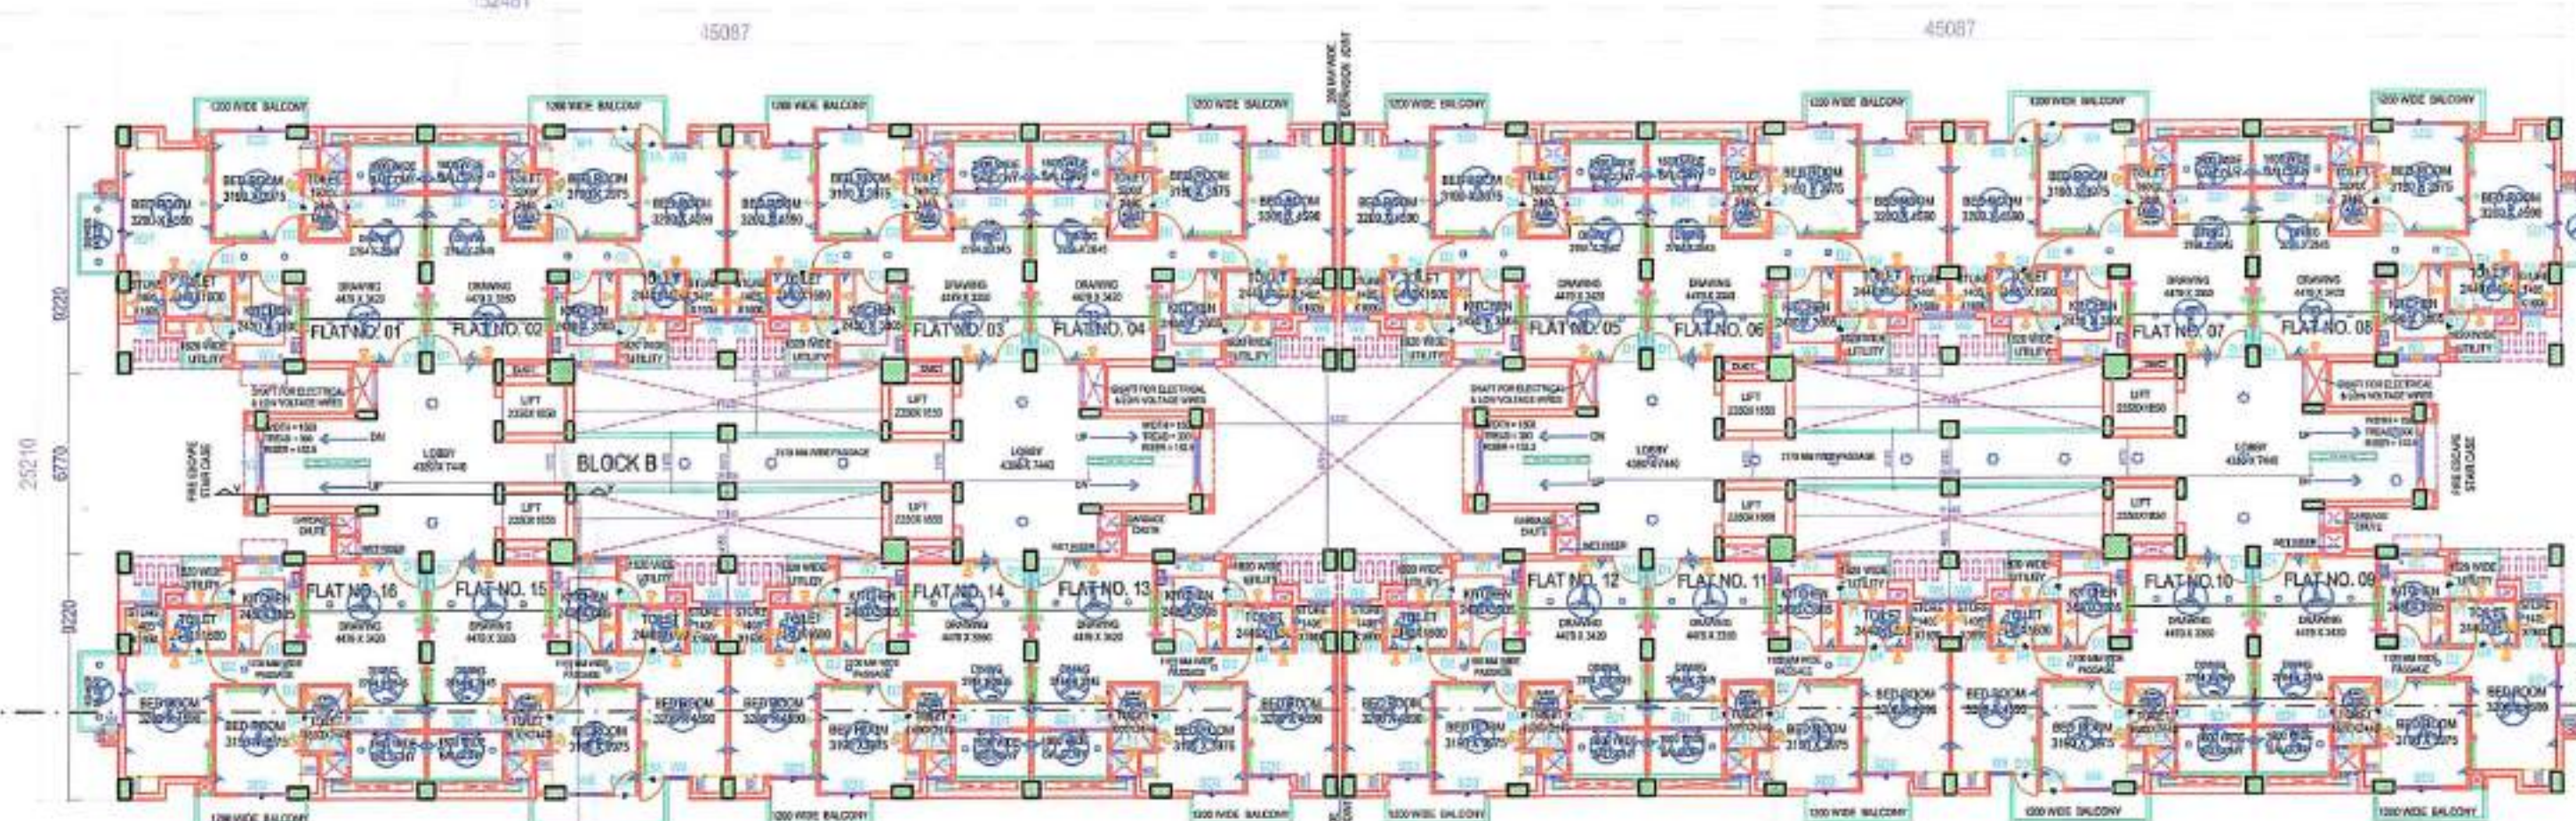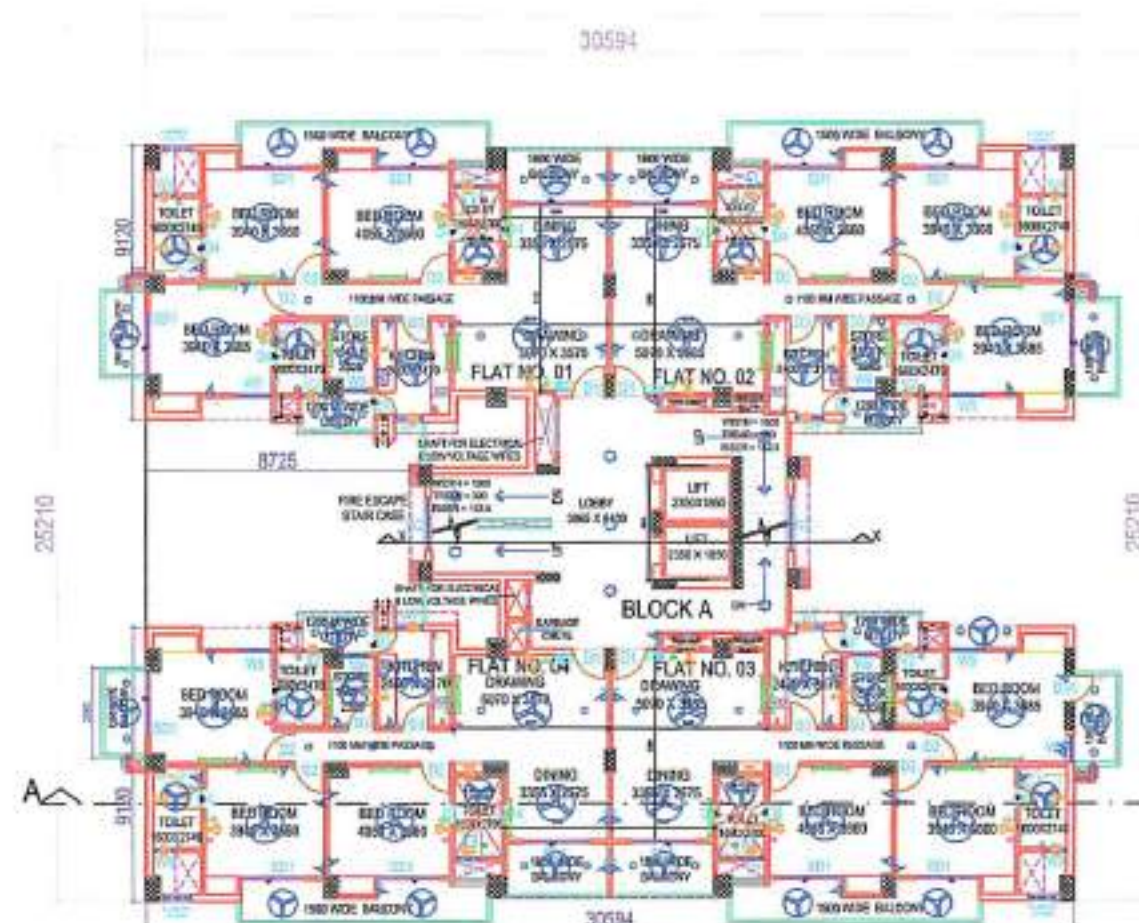

3RD,5TH,7TH,9TH,11TH FLOOR PLAN

PROPOSED NAMAN TOWER AT
SHERVANI LEGACY AT PART OF ARAZI
133, 134, 135, 142, 143, 144 MAUZA SULEM
SARAI, ARAZI NO. 1, 17 AND 18 MAUZA
JAIRAM PUR AND ARAZI NO. 442, 443 OF
MAUZA HARWARA ALLAHABAD.
DEVELOPED BY SHERVANI INDUSTRIAL
SYNDICATE LTD.

LEGEND :-

SYMBOL	DISCRIPTION	Q.T.Y
	CEILING FAN	
	EXHAUST FAN	
	1X28WATT(T5) FL FIXTURE	
	1X28WATT(T5) FL FIXTURE	
	WALL BRACKET FITTING	
	1X11W PL MIRROR LIGHT	
	BATTEN HOLDER/CEILING LIGHT	
	CEILING LIGHT	
	LIGHT PLUG OF 6 AMP.	
	POWER PLUG OF 16 AMP.	
	20 AMP. DP MCB SWITCH	
	CALL BELL	
	BELL PUSH	
	TV POINT	
	TELEPHONE POINT	
	SWITCH BOARD	
	MCB DISTRIBUTION	

Drawing Title
SUBMISSION DRAWING
ELECTRICAL(1)

OWNERS:
SHERVANI INDUSTRIAL SYNDICATE LTD
(Corporate Office)
Shervani Indl. Syndicate Ltd.,
2, Karpur Road, 201001

Drg. No. 11/17
(ELECTRICAL 1)

Scale 1 : 250

Date 04 JULY 2018



ARCHITECT SIGN.

Architect
MANISH GUJRAL
(B. Arch, F.I.V.)
TARANA NASEER
(B.Arch, M.Plan)
Architects and Interior
Designers

52/ 25 B MUIR ROAD, ALLAHABAD

PROPOSED NAMAN TOWER AT
SHERVANI LEGACY AT PART OF ARAZI
133, 134, 135, 142, 143, 144 MAUZA SULEM
SARAI, ARAZI NO. 1, 17 AND 18 MAUZA
JAIRAM PUR AND ARAZI NO. 442, 443 OF
MAUZA HARWARA ALLAHABAD.
DEVELOPED BY SHERVANI INDUSTRIAL
SYNDICATE LTD.

LEGEND :-

SYMBOL	DISCRIPTION	Q.T.Y
	CEILING FAN	
	EXHAUST FAN	
	1X28WATT(T5) FL FIXTURE	
	WALL BRACKET FITTING	
	1X11W PL MIRROR LIGHT	
	BATTEN HOLDER CEILING LIGHT	
	CEILING LIGHT	
	LIGHT PLUG OF 6 AMP	
	POWER PLUG OF 16 AMP	
	20 AMP DP MCB SWITCH	
	CALL BELL	
	BELL PUSH	
	TV POINT	
	TELEPHONE POINT	
	SWITCH BOARD	
	MCB DISTRIBUTION	

Drawing Title
SUBMISSION DRAWING
ELECTRICAL(2)

OWNERS:

SHERVANI INDUSTRIAL SYNDICATE LTD
(Corporate Affairs)
Sherwani Ind. Syndicate Ltd.,
3, Kirti Road, Allahabad-201001

Drg. No. 12/17
(ELECTRICAL 2)

Scale 1 : 250

Date 04 JULY 2018




ARCHITECT SIGN.


Architect

MANISH GUJRAL
(B. Arch, F.I.V.)
TARANA NASEER
(B.Arch, M.Plan)
Architects and Interior
Designers


52/ 25 B MUIR ROAD, ALLAHABAD

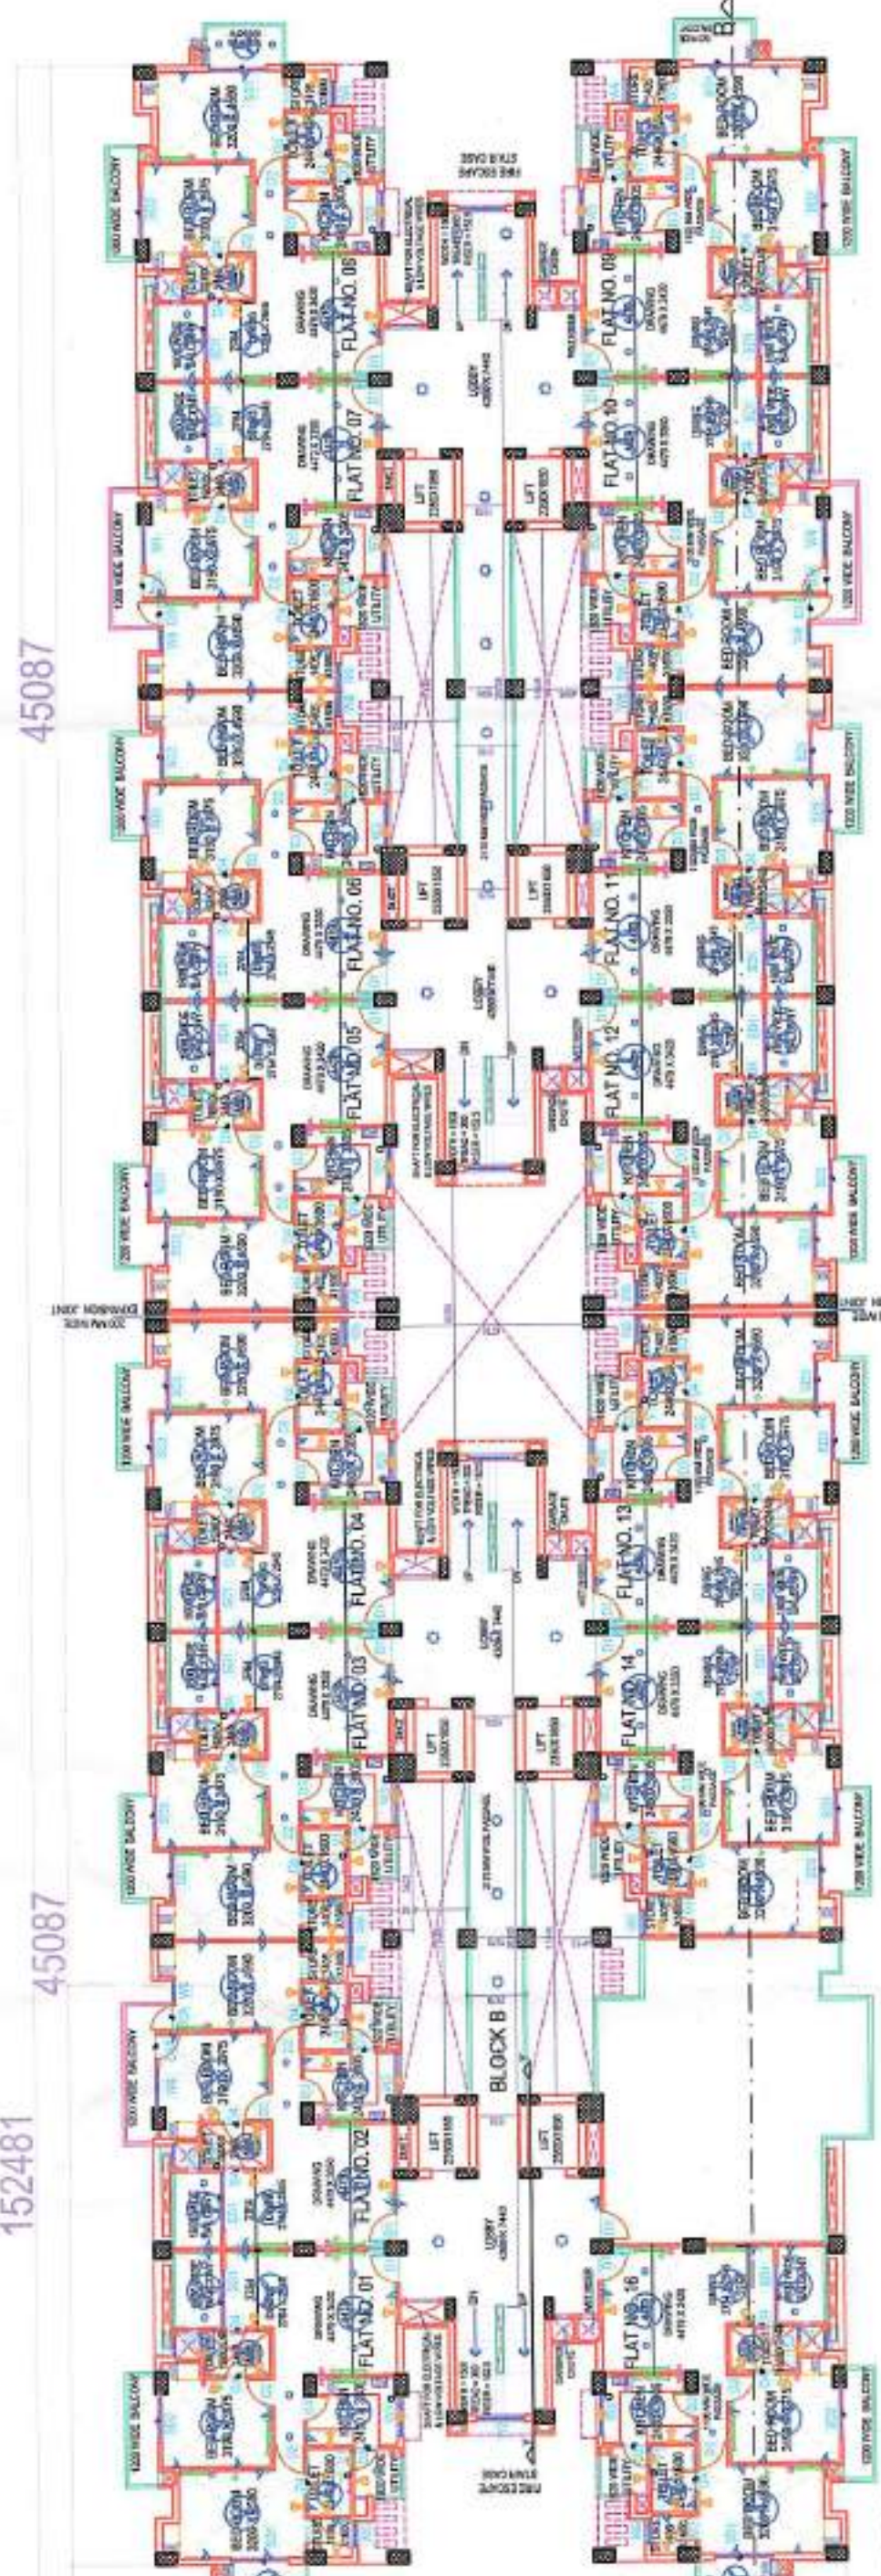

13TH FLOOR PLAN

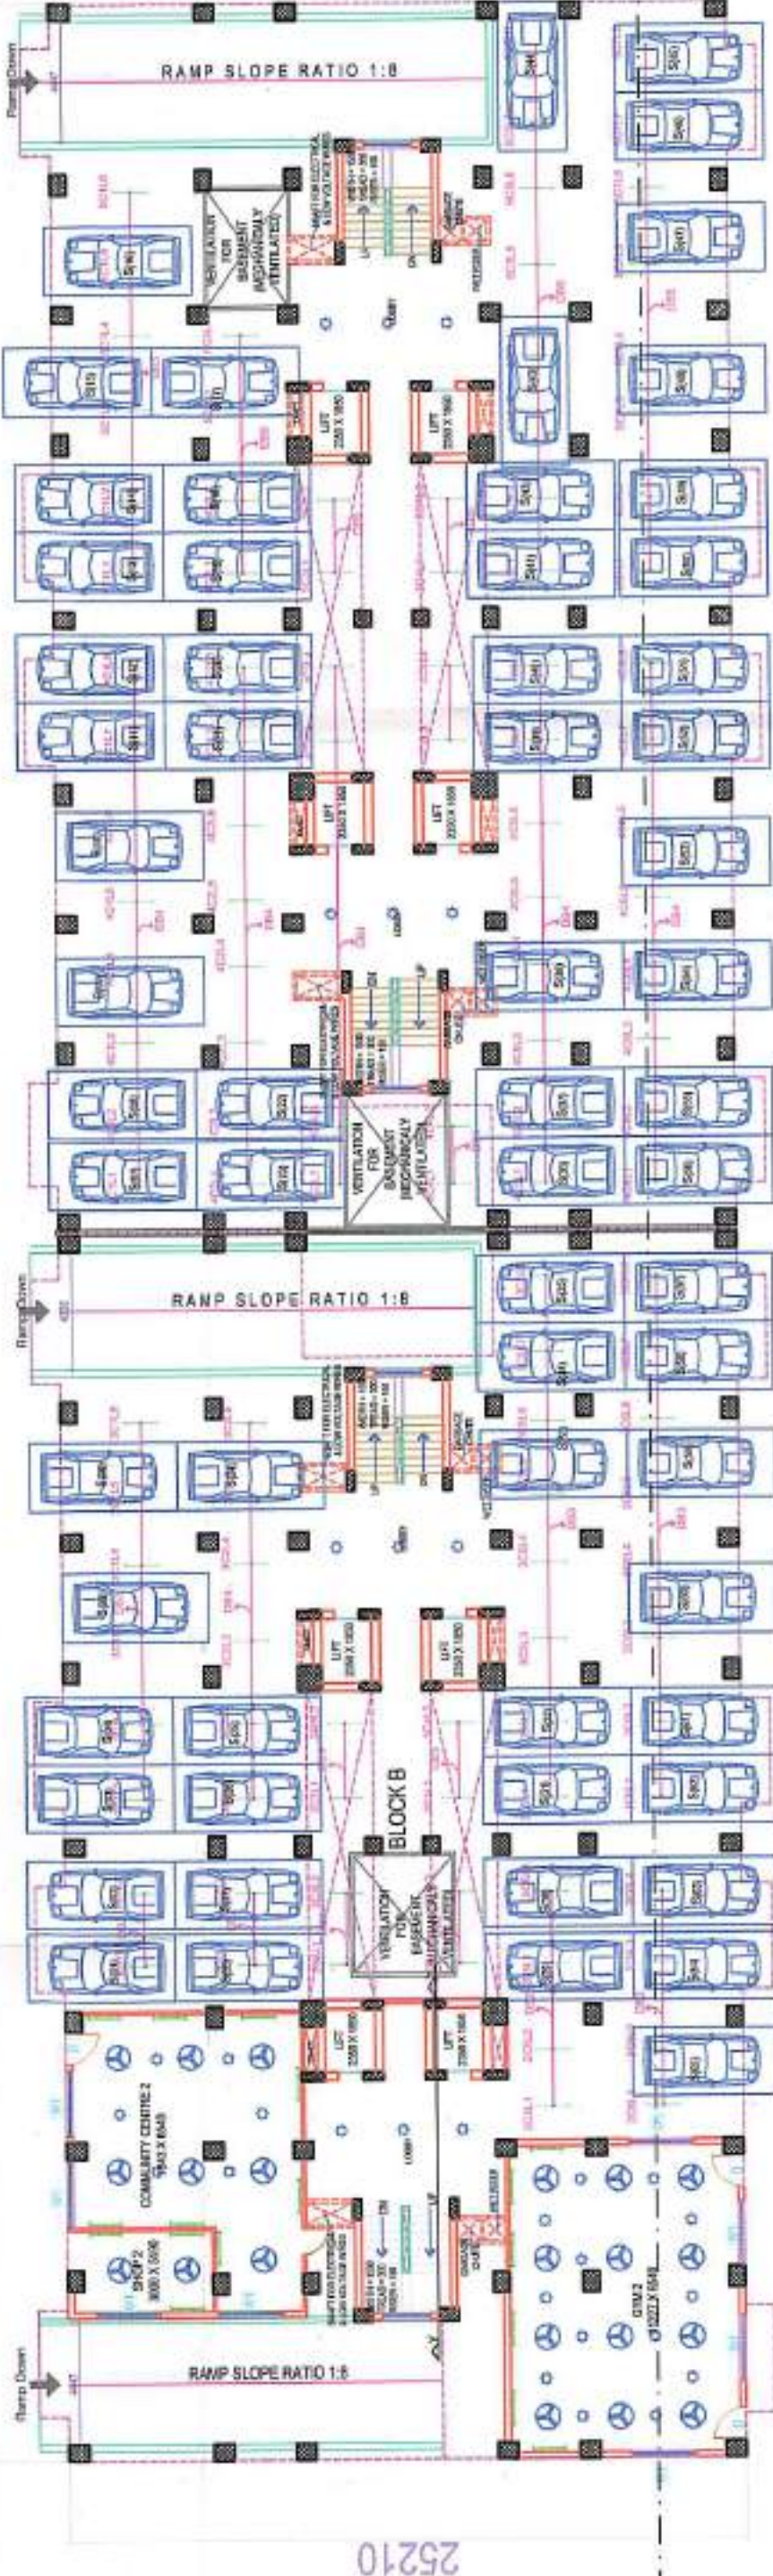

STILT FLOOR

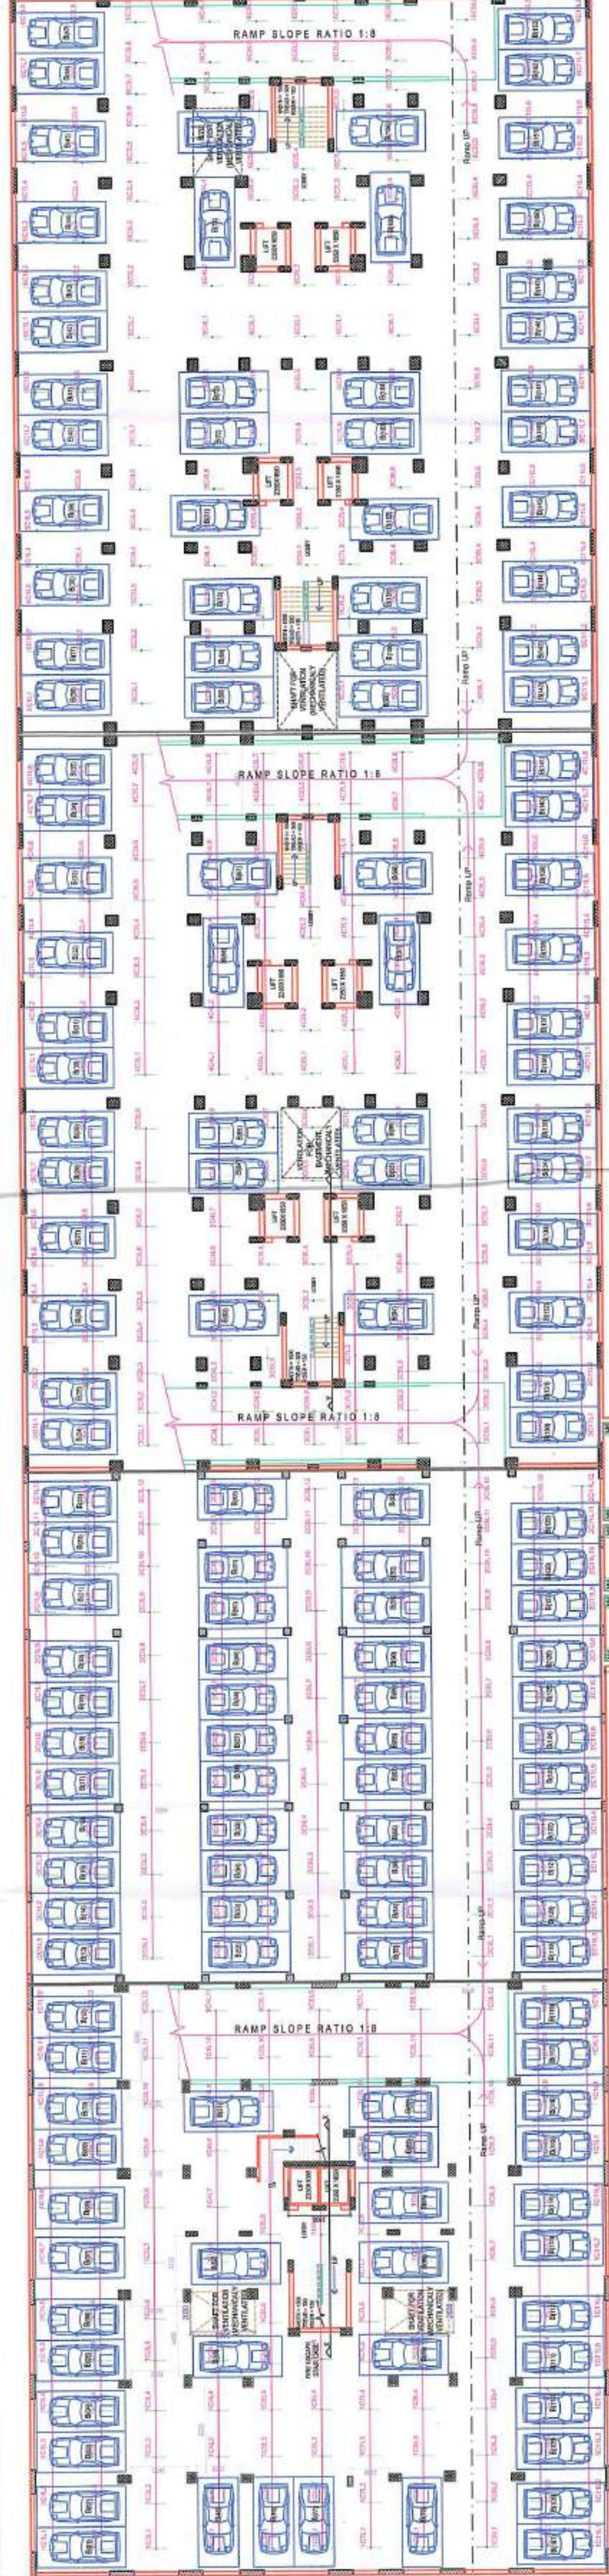

BASEMENT