


SINGLE LINE DIAGRAM (STELLAR-1422)

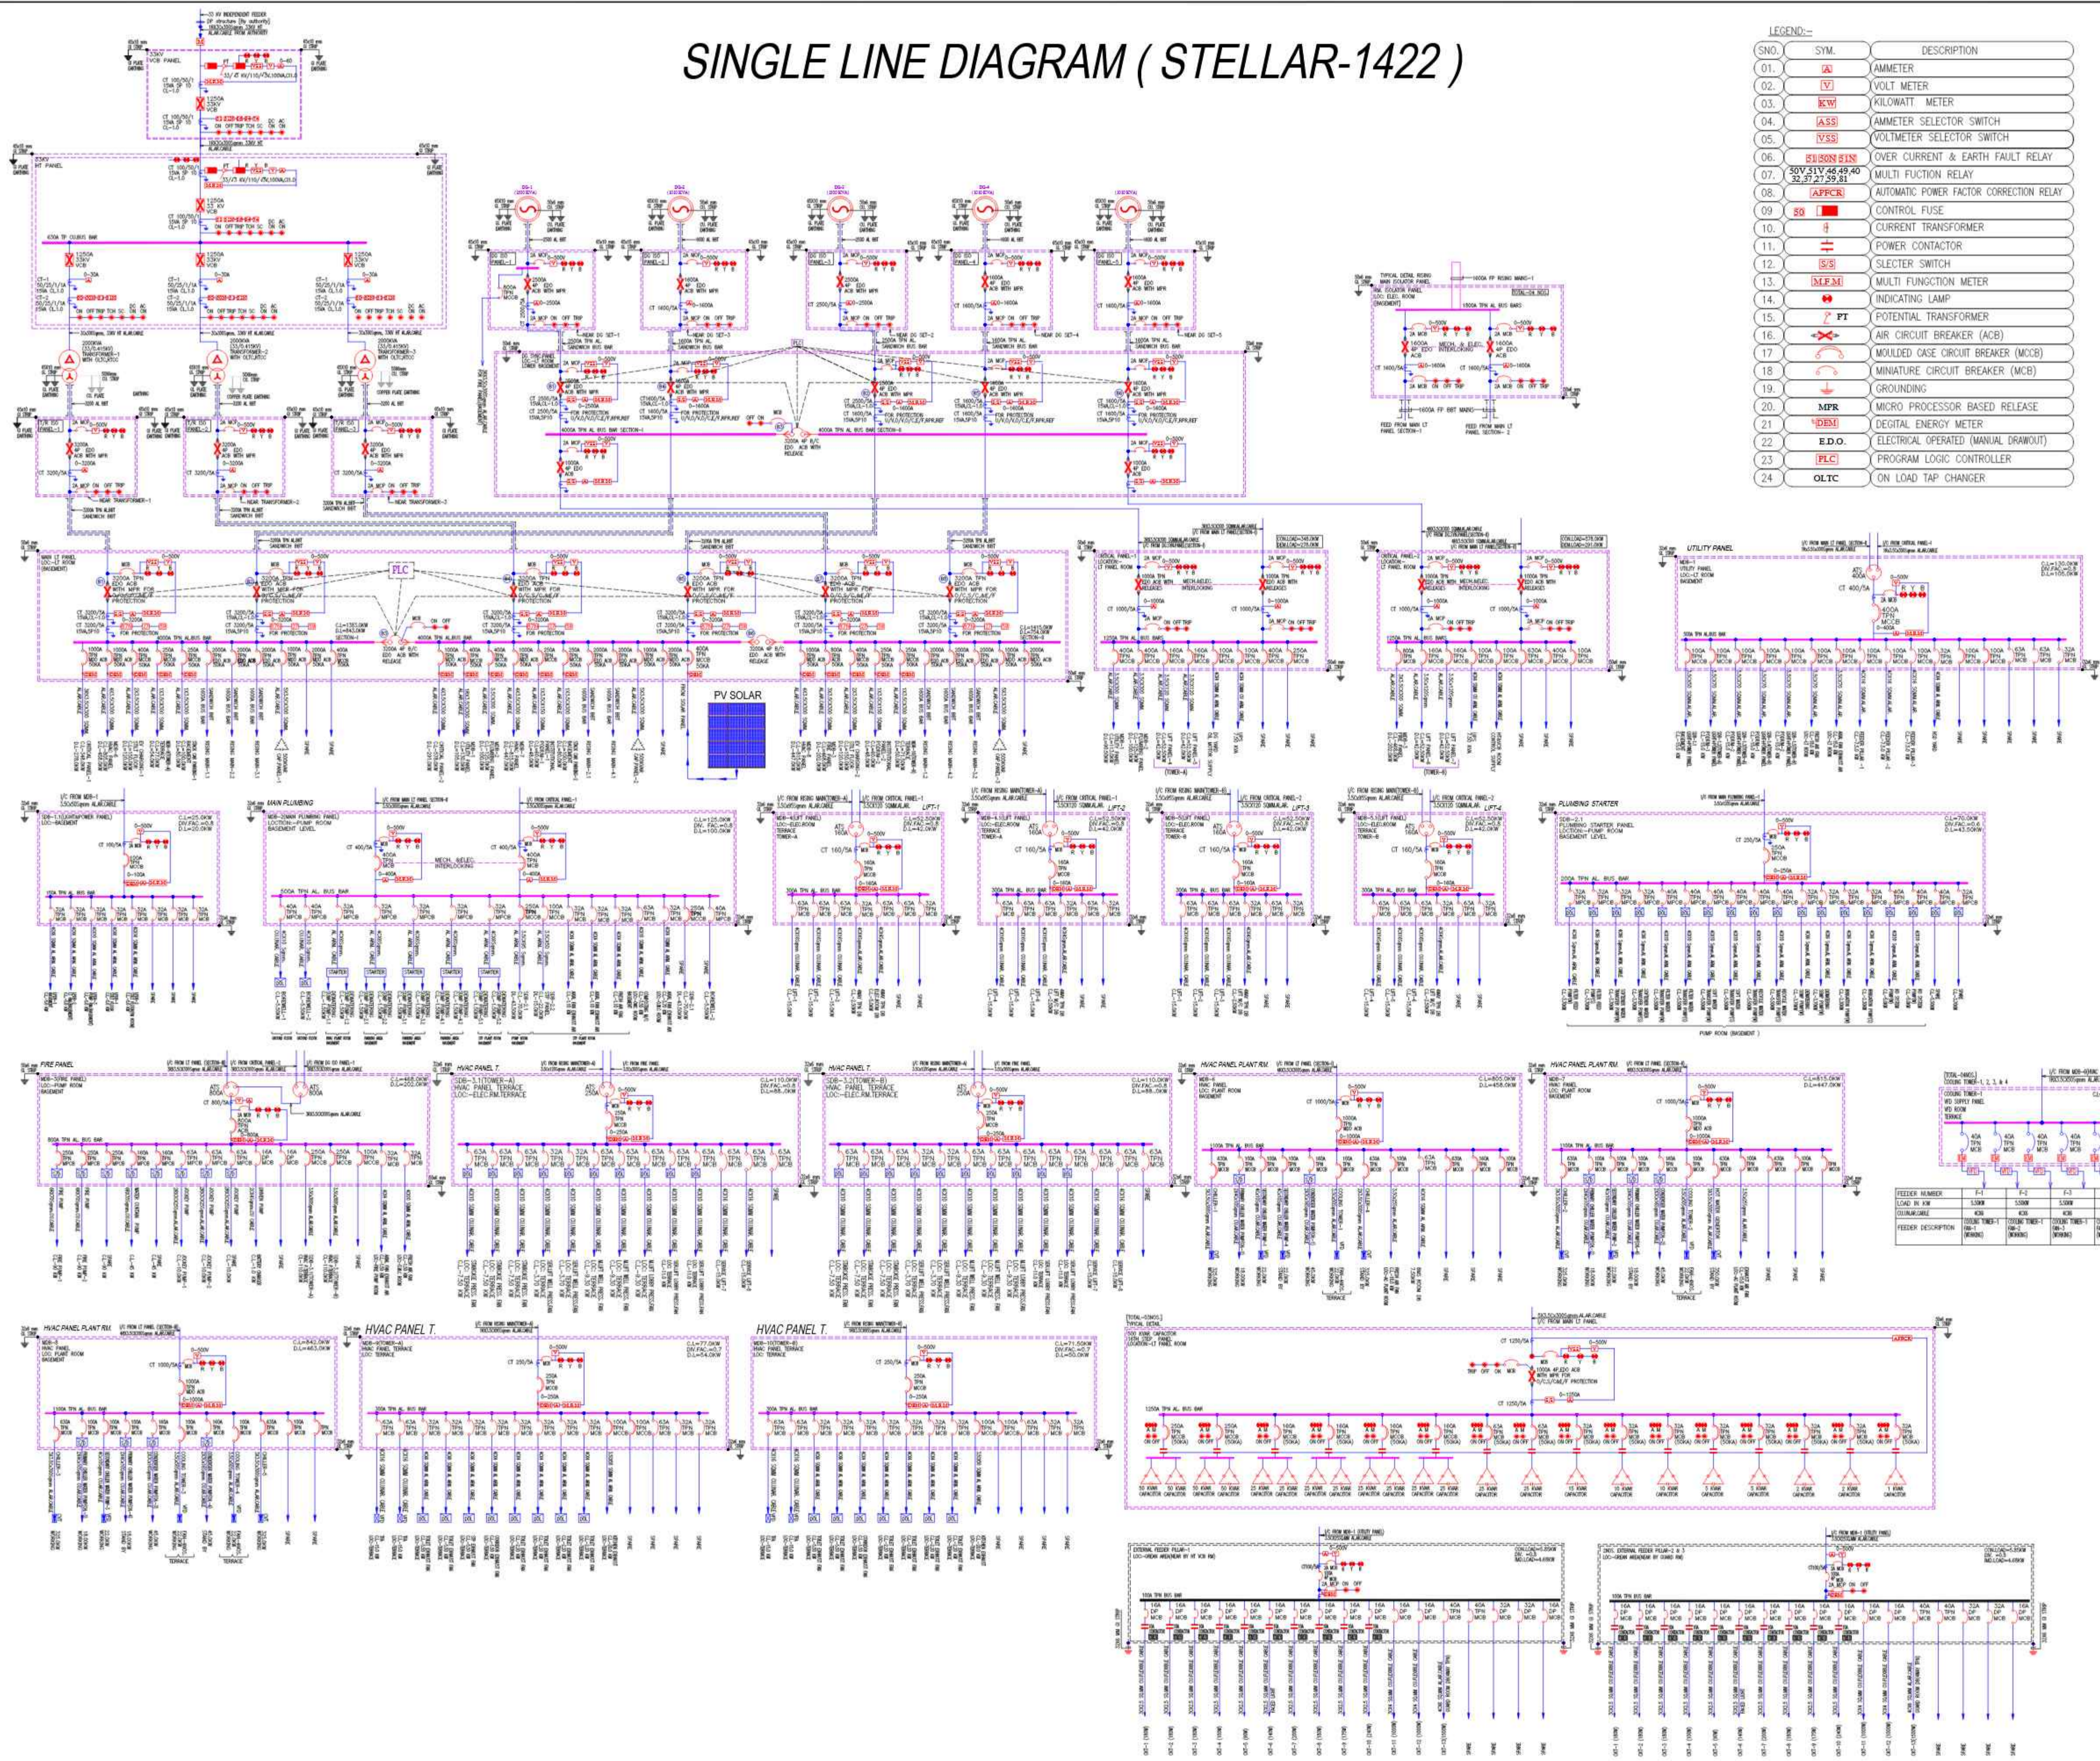

LEGEND:-

SNO.	SYM.	DESCRIPTION
01.	A	AMMETER
02.	V	VOLT METER
03.	KW	KILOWATT METER
04.	AS	AMMETER SELECTOR SWITCH
05.	VSS	VOLTMETER SELECTOR SWITCH
06.	OC	OVER CURRENT & EARTH FAULT RELAY
07.	SOV 31V 44 49 40	MULTI FUNCTION RELAY
08.	APFCR	AUTOMATIC POWER FACTOR CORRECTION RELAY
09.	CB	CONTROL FUSE
10.	CT	CURRENT TRANSFORMER
11.	PC	POWER CONTACTOR
12.	SS	SELECTOR SWITCH
13.	MFM	MULTI FUNCTION METER
14.	IL	INDICATING LAMP
15.	PT	POTENTIAL TRANSFORMER
16.	ACB	AIR CIRCUIT BREAKER (ACB)
17.	MCCB	MOULDED CASE CIRCUIT BREAKER (MCCB)
18.	MCB	MINIATURE CIRCUIT BREAKER (MCB)
19.	GRD	GROUNDING
20.	MFR	MICRO PROCESSOR BASED RELEASE
21.	DEM	DIGITAL ENERGY METER
22.	E.O.	ELECTRICAL OPERATED (MANUAL DRAWOUT)
23.	PLC	PROGRAM LOGIC CONTROLLER
24.	OLTC	ON LOAD TAP CHANGER

NOTES:
 1. THIS DRAWING IS THE PROPERTY OF SSPL AND SHALL NOT BE USED OR REPRODUCED IN ANY MANNER WITHOUT THEIR WRITTEN PERMISSION.
 2. THE EXECUTING TEAM IS REQUIRED TO CORRELATE ALL RELEVANT DRAWINGS AND ANY ERRORS OR DISCREPANCIES ARE TO BE BROUGHT TO THE NOTICE OF ELECTRICAL H.O BEFORE COMMENCEMENT OF WORK.
 3. ALL DIMENSIONS ARE IN MILLIMETERS UNLESS NOTED OTHERWISE.

PRINTED

REV.	DATE	NO. OF PRINT	REMARKS
R0	25.04.2024		ISSUED FOR APPROVAL

CLIENT : **STELLAR GROUP**

ARCHITECT & MEP CONSULTANT
Star Arc Design Pvt Ltd
 C-56/9, Sector-62, Noida-201308, (UP), INDIA.
 Phone : 0120-4330040, 4356783
 Fax : 0120-4330040, 2401435
 www.stellargroupindia.com

STRUCTURE CONSULTANT:
 PLUMBING & FIREFIGHTING CONSULTANT:

PROJECT : **STELLAR 1422 AT PLOT NO.2 SECTOR-142,NOIDA (UP)**

LANDSCAPE CONSULTANT :

WORKING DRAWING

SHEET TITLE : **ELECTRICAL SCHEMATIC DIAGRAM**

SCALE : N.T.S.	DWG NO- S1422-EL-SLD-01
DEALT : RAJESH	REVISION SUFFIX
CHKD : VIKRANT	R0
APPROVED : R M SHARMA	
DATE : 09.05.2024	