

ELECTRICAL LEGEND:-	
<u>SYM.</u>	<u>DESCRIPTION</u>
	WALL BRACKET LIGHT
	1X28W WALL TUBE LIGHT
	CEILING LIGHT
	EXHAUST FAN
	CEILING ROSE
	6A SOCKET WITH 6A SWITCH
	2NO. 6A SOCKET FOR TV
	TELEPHONE / DATA POINT
	TV POINT
	CEILING FAN - 1200MM DIA.
	BELL PUSH
	CALL BELL BUZZER
	6A ONE WAY SWITCH BOARD
	1 X 20W TUBE LIGHT
	16A,3/PIN SOCKET WITH 16A SWITCH
	DISTRIBUTION BOARD
	HOOTER CUM SPEAKER
	MANUAL CALL POINT

ISSUES			

REVISIONS			

PURPOSE OF DRAWING

G.F.C. : ☐ TENDER : ☐

 INFORMATION ONLY : ☐ APPROVAL ONLY : ☒

ARCHITECT SIGN :
OWNER SIGN :

WORKING DRAWING

PROJECT:
 PROPOSED MINI TOWNSHIP ORO COUNTY AT MADIYAON, LUCKNOW


Clients: **ORO COUNTY/DEV/W-01**

Architect & Associates:
espaces
Ar. SANJAY KR. GUPTA
108, CORPORATE CHAMBER-I,
VIBHUTI KHAND, GOMTI NAGAR, LUCKNOW
Ph.No.- 4065958, 09415114589
email-espace_arch@rediffmail.com

MEP Consultants:
PARADISE CONSULTANTS
PLOT NO. 96, POCKET-1, BASEMENT
JASOLA VIHAR NEW DELHI - 110025
PH+91-11-29943601, 41030619
E-mail: paradiseconsultants@gmail.com

DRAWING TITLE :	
EW S GROUND & SITE PLAN ELECTRICAL LAYOUT	
scale : 1:100 (A2)	drawn by : T.A.
date : 26/09/2022	checked by: A.R.
project no : -----	approved by : NAFEES
drawing no : EL-PC-ORO-II-EWS-101	
REVISION	Ro

[illegible]

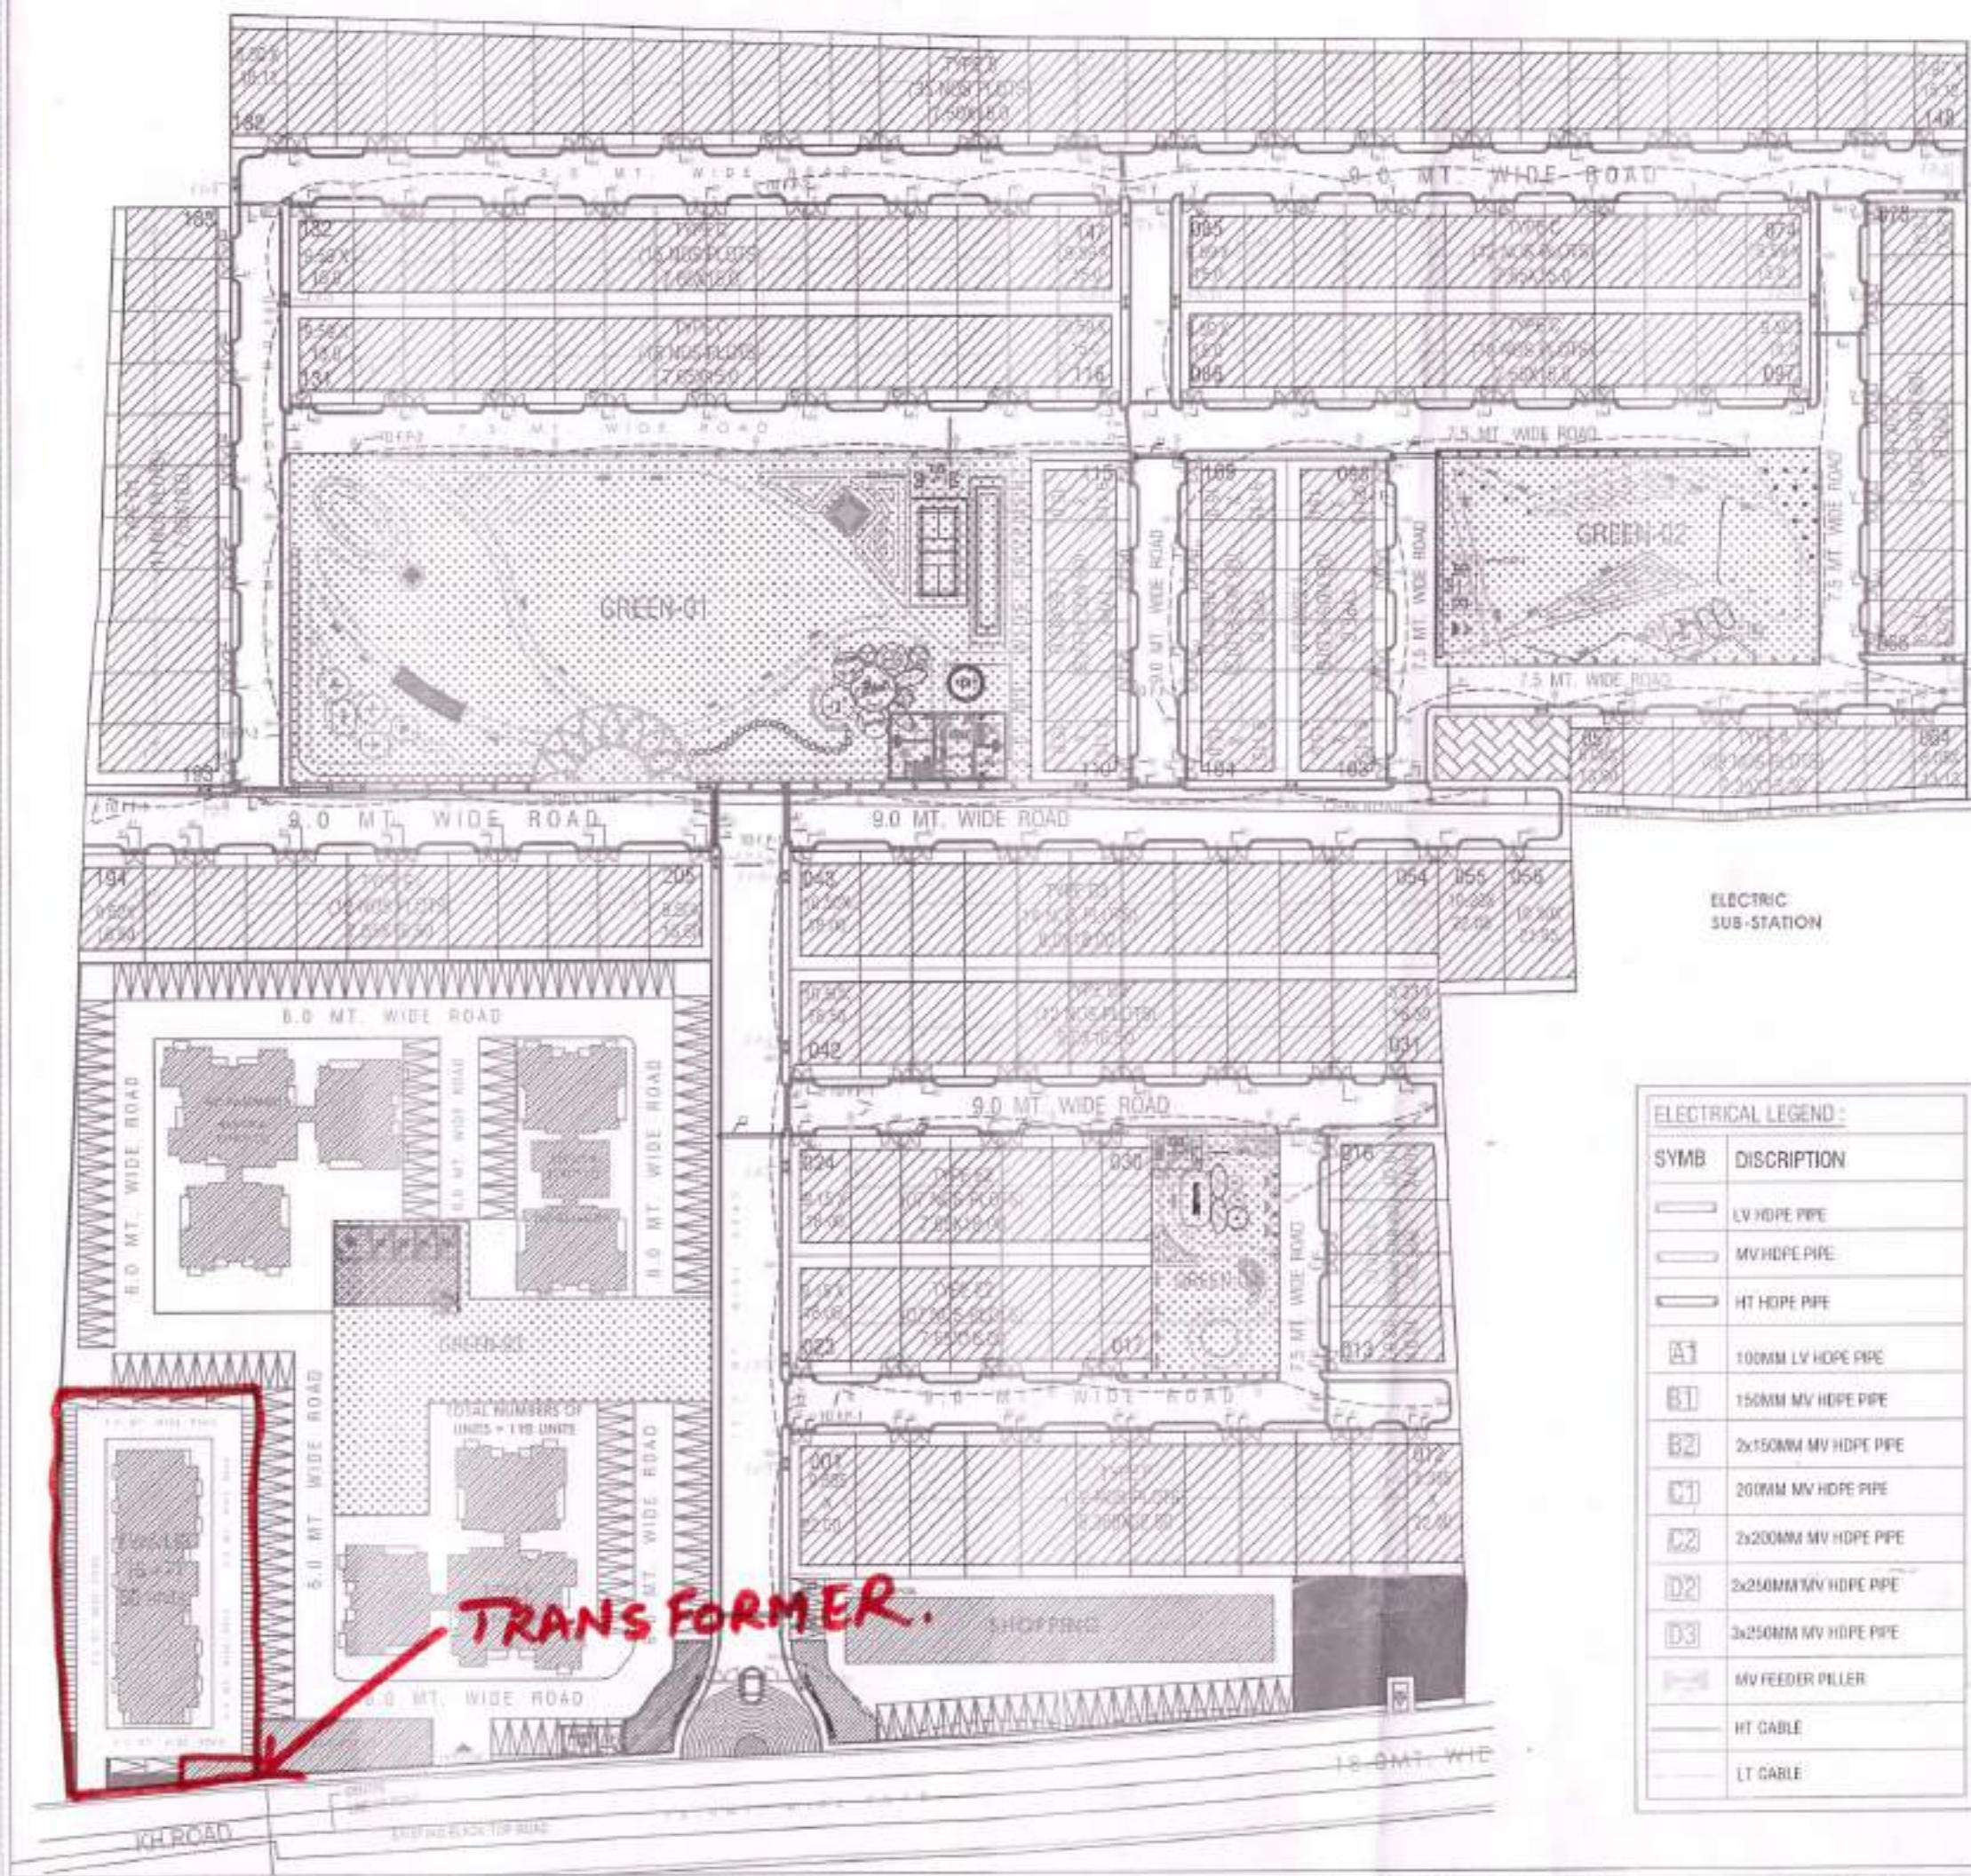

ELECTRIC
SUB-STATION

ELECTRICAL LEGEND :	
SYMB	DISCRIPTION
	LV HDPE PIPE
	MV HDPE PIPE
	HT HDPE PIPE
	100MM LV HDPE PIPE
	150MM MV HDPE PIPE
	2x150MM MV HDPE PIPE
	200MM MV HDPE PIPE
	2x200MM MV HDPE PIPE
	2x250MM MV HDPE PIPE
	3x250MM MV HDPE PIPE
	MV FEEDER PILLER
	HT CABLE
	LT CABLE

ELECTRICAL LEGEND :	
SYMBOL	DESCRIPTION
	FEEDER PILLER
	STREET LIGHT
	LT CABLE LINE
	HT CABLE LINE
	G.I.
	C.U.
	G.I.P.
	CHASSIS/BONDING

REVISIONS

NO.	DESCRIPTION	DATE

PURPOSE OF DRAWING

☐ INFO
☐ APPROVAL ONLY
☐ WORKING DRAWING

WORKING DRAWING

PROJECT: PROPOSED NEW TOWNSHIP OFFICE AT MADYATOL, LUSAKA

CLIENT: DRO II/DEV.W-01

DESIGNER & ASSOCIATES: **espaces**
 AL SHALAY AB SHITA
 VICE PRESIDENT CHAIRMAN
 VISION & DESIGN: DORT NAGAR, LUSAKA
 PH: +260 211 400 000, 204 111 450
 email: espaces_jeff@outlook.com

APP. CONSULTANTS: **PARADISE CONSULTANTS**
 14/20 MT. W. POCKET-1, BRIDGEMAN
 JACOLA WARD NEW DELHI - 110025
 PH: +91-11-2606301, 41330013
 E-mail: paradiseconsultants@gmail.com

DATE: 15/01/2020
 DRAWN BY: M.S.
 CHECKED BY: M.S.
 APPROVED BY: M.S.
 CREATING IN: EL-PC-DRO-II-R-104