


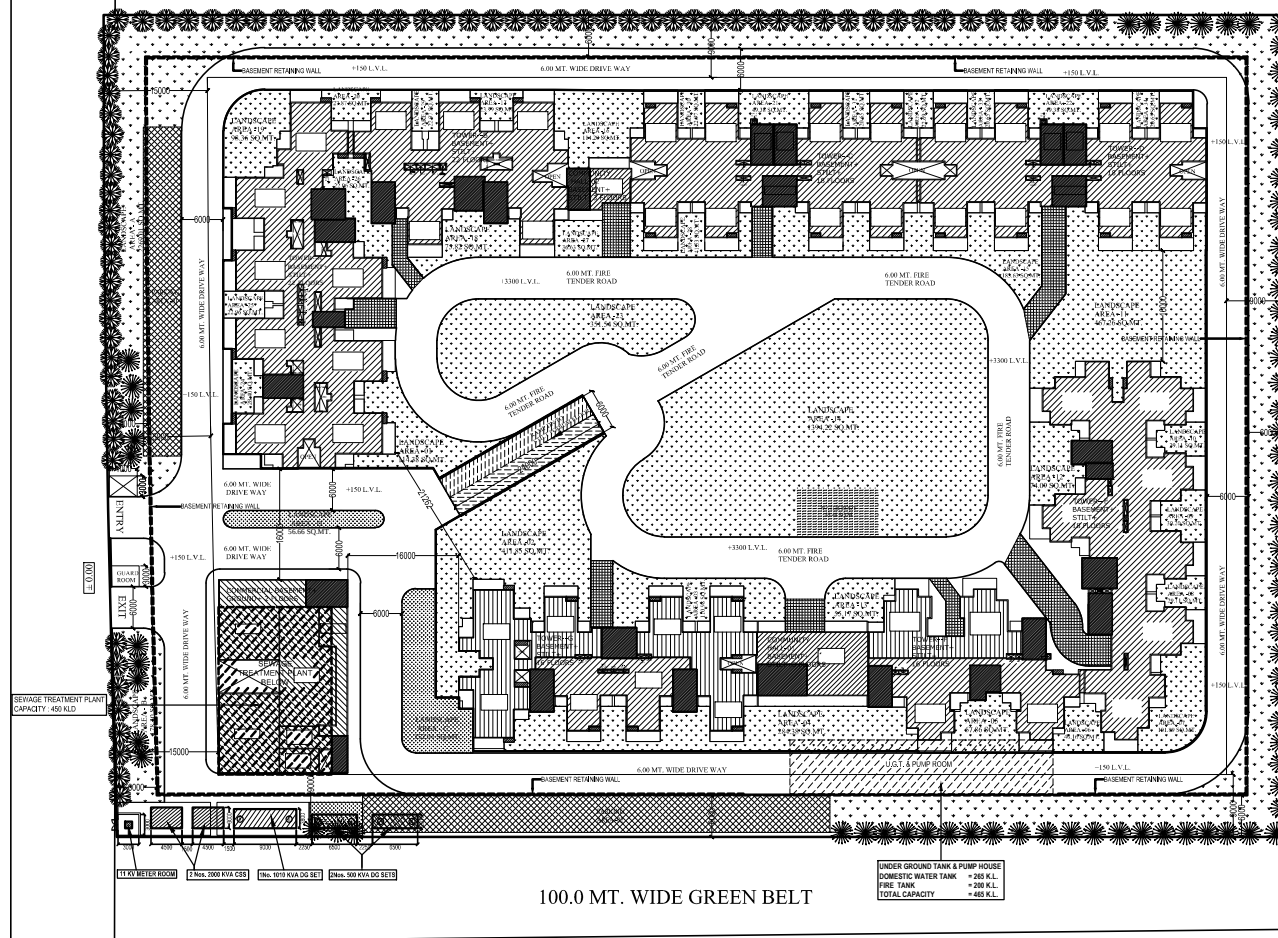

100.0 MT. WIDE GREEN BELT

130.0 MT. WIDE ROAD

[illegible]

project
VEGA
AT PLOT NO - GH - 08C, GREATER NOIDA (U.P.)

title
LAYOUT PLAN

subitle
ELECTRICAL SETTING-OUT AT SITE PLAN

drawing released for

☐ APPROVAL	☒ MUN.SUBMISSION
☐ ADVANCE COPY	☐ CONSTRUCTION

drg. no. VEGA / 13B14 / MS - ES - 04	drawn by Prem Saini
scale 1 : 350	designed by Badri Vishal
date 15.10.2014	checked by Anand Haveli

architects
Space Designers International
Architects Pvt. Ltd.
B - 34, SECTOR-67, NOIDA
PH : 0126-2484445-49, Mob: 9811070399, 9811336231
e-mail : spacesdi@gmail.com, www.spacedi.com

services consultant
Consummate Engineering Services (P) Ltd.
Noida Office : B - 67, Sector - 67, Noida - 201 301
Tel : (0120) 2593506 / (30 Lines)
Lko. Office : R 006, Rohtas Plumeria, Gomti Nagar, Lucknow
Tel : (0522) 6515455
e mail : mail@cespl.in, website : www.cespl.in