



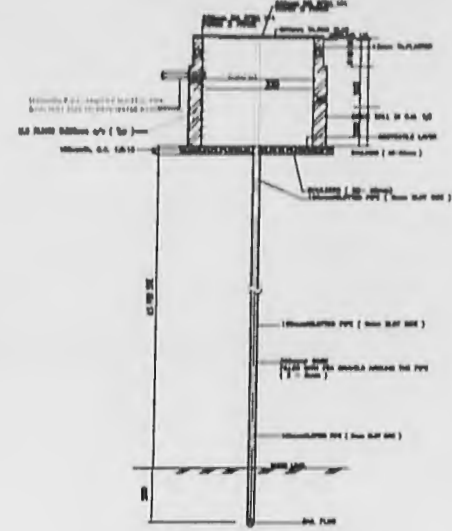

SECTION-R.R.
160mm dia. P.V.C. SLOTTED PIPE (6mm SLOT SIZE)

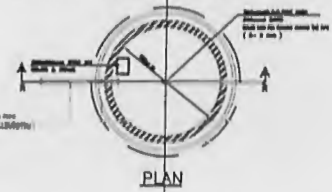

PLAN

RAIN WATER HARVESTING (RECHARGE SHAFT)
3000mm dia & 3000mm DEEP (EFFECTIVE DEPTH)

INSTITUTIONAL FACILITIES


1. waiting and transit areas
2. area designated for public utilities
3. travel services
4. telephone exchange
5. electric sub station
6. water works
7. export related facilities
8. canteen / restaurant
9. creche & day care centre
10. operation and maintenance by specialized agencies
11. training centre and library
12. health club and gym for users / residents for i.t. industries and i.t. enabled services
13. games / entertainment room for users / residents for i.t. industries and i.t. enabled services
14. banking and financial services
15. business and financial services
16. business centre/ conference facilities
17. shops
18. open eating kiosks

commercial use

1. shops
2. areas for storage, display and sale of merchandise
3. cinemas halls
4. hotels
5. restaurants
6. Open eating kiosks

residential use

1. residential uses
2. hostels
3. guest houses
4. staff Quarter

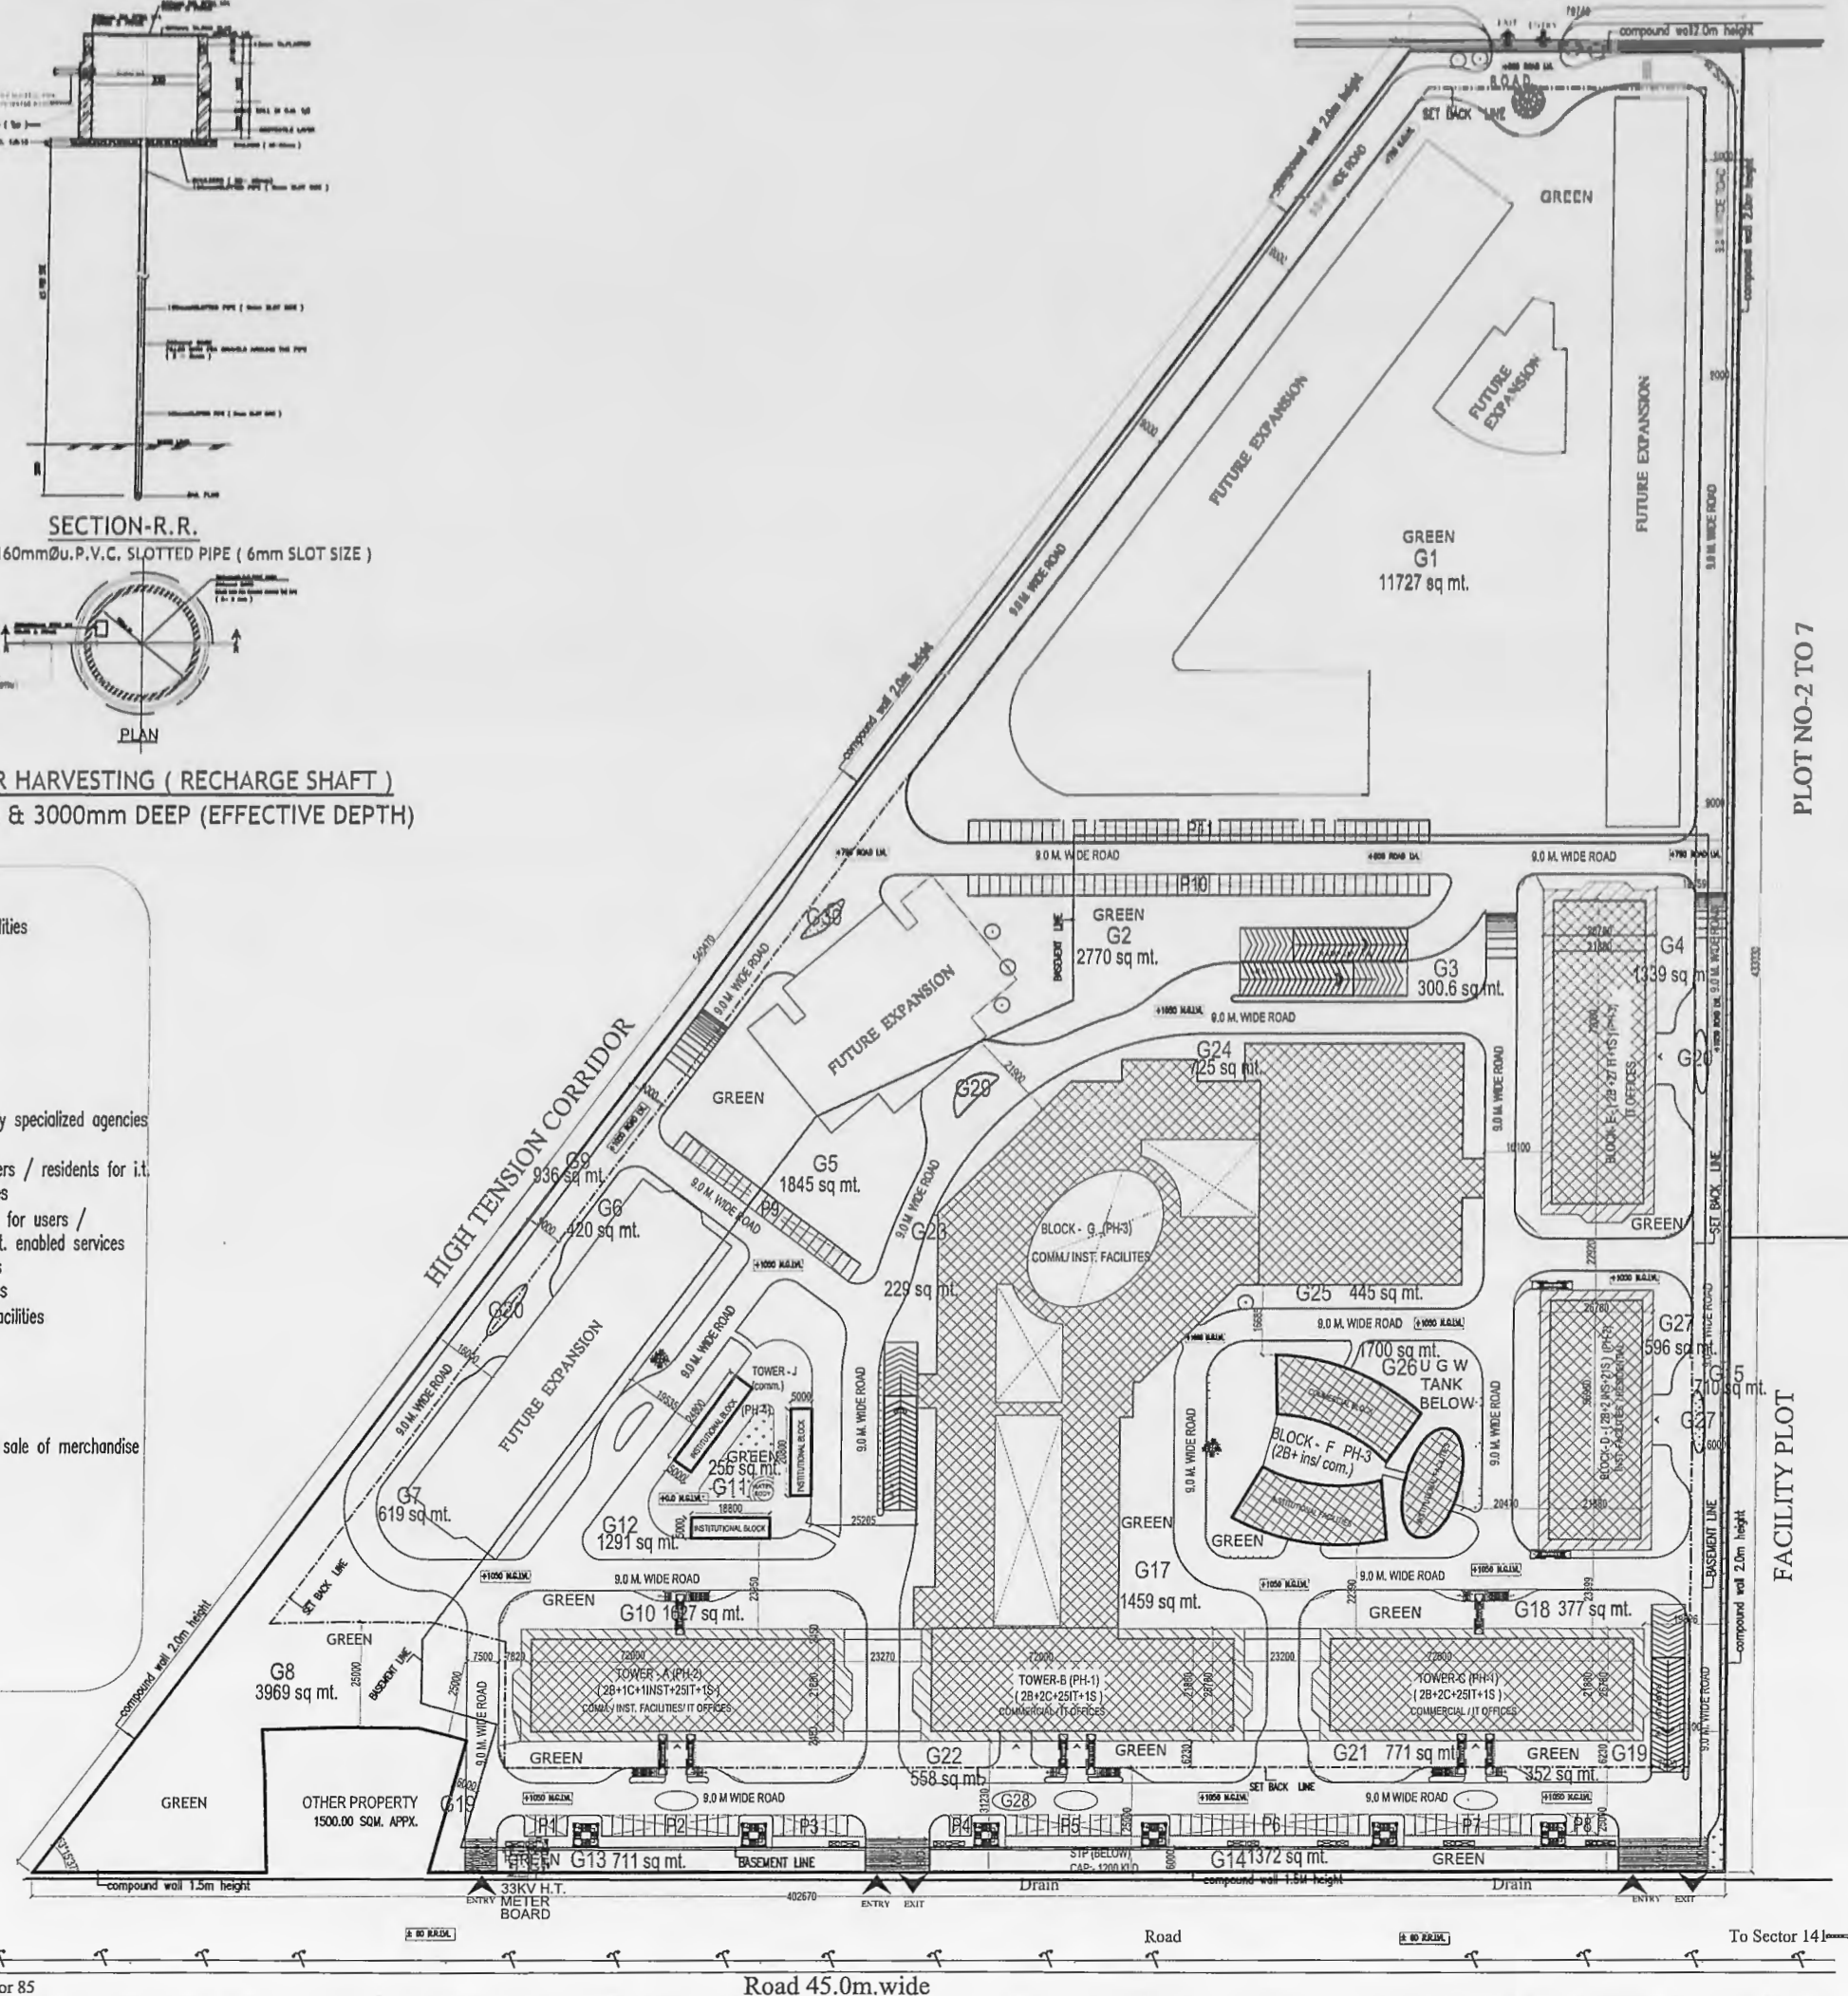

SCHEDULE OF DEVELOPMENT

- PHASE 1 - TOWER B AND TOWER C
PHASE 2 - TOWER A, TOWER D & TYPE 1, 2, 3
PHASE 3 - TOWER E, TOWER F, TOWER G,
PHASE 4 - FUTURE DEVELOPMENT (TOWER H, I & J)

Owner Sign

Architect Sign

SUBMISSION DRAWING

Title:-

SITE PLAN

Project:-

NOIDA WORLD ONE
Plot No. 1, Sector- 90,
Expressway, Noida.

Client:-

CBS INTERNATIONAL PROJECTS Pvt. Ltd.
Plot No. 1, Sector-90, Noida Expressway, Noida. Tel. 8862909090
Email: info@cbinternational.net - Website: www.noidaworldone.com

Architects:-

SPACE COMBINE
(An ISO 9001:2000 Certified)
Architects, Engineers, Planners
project management consult.
A1/112 SAFDARJUNG ENCLAVE,
NEW DELHI - 110029
PH : 011-46150000
E-mail: spacecombine
@rediffmail.com

Drawing released for:-

- ☐ APPROVAL ☒ SUBMISSION
☐ ADVANCE COPY ☐ CONSTRUCTION

drg. no.:

scale: 1:500

date: MAY 2017

drawn by:

ekd by:

