


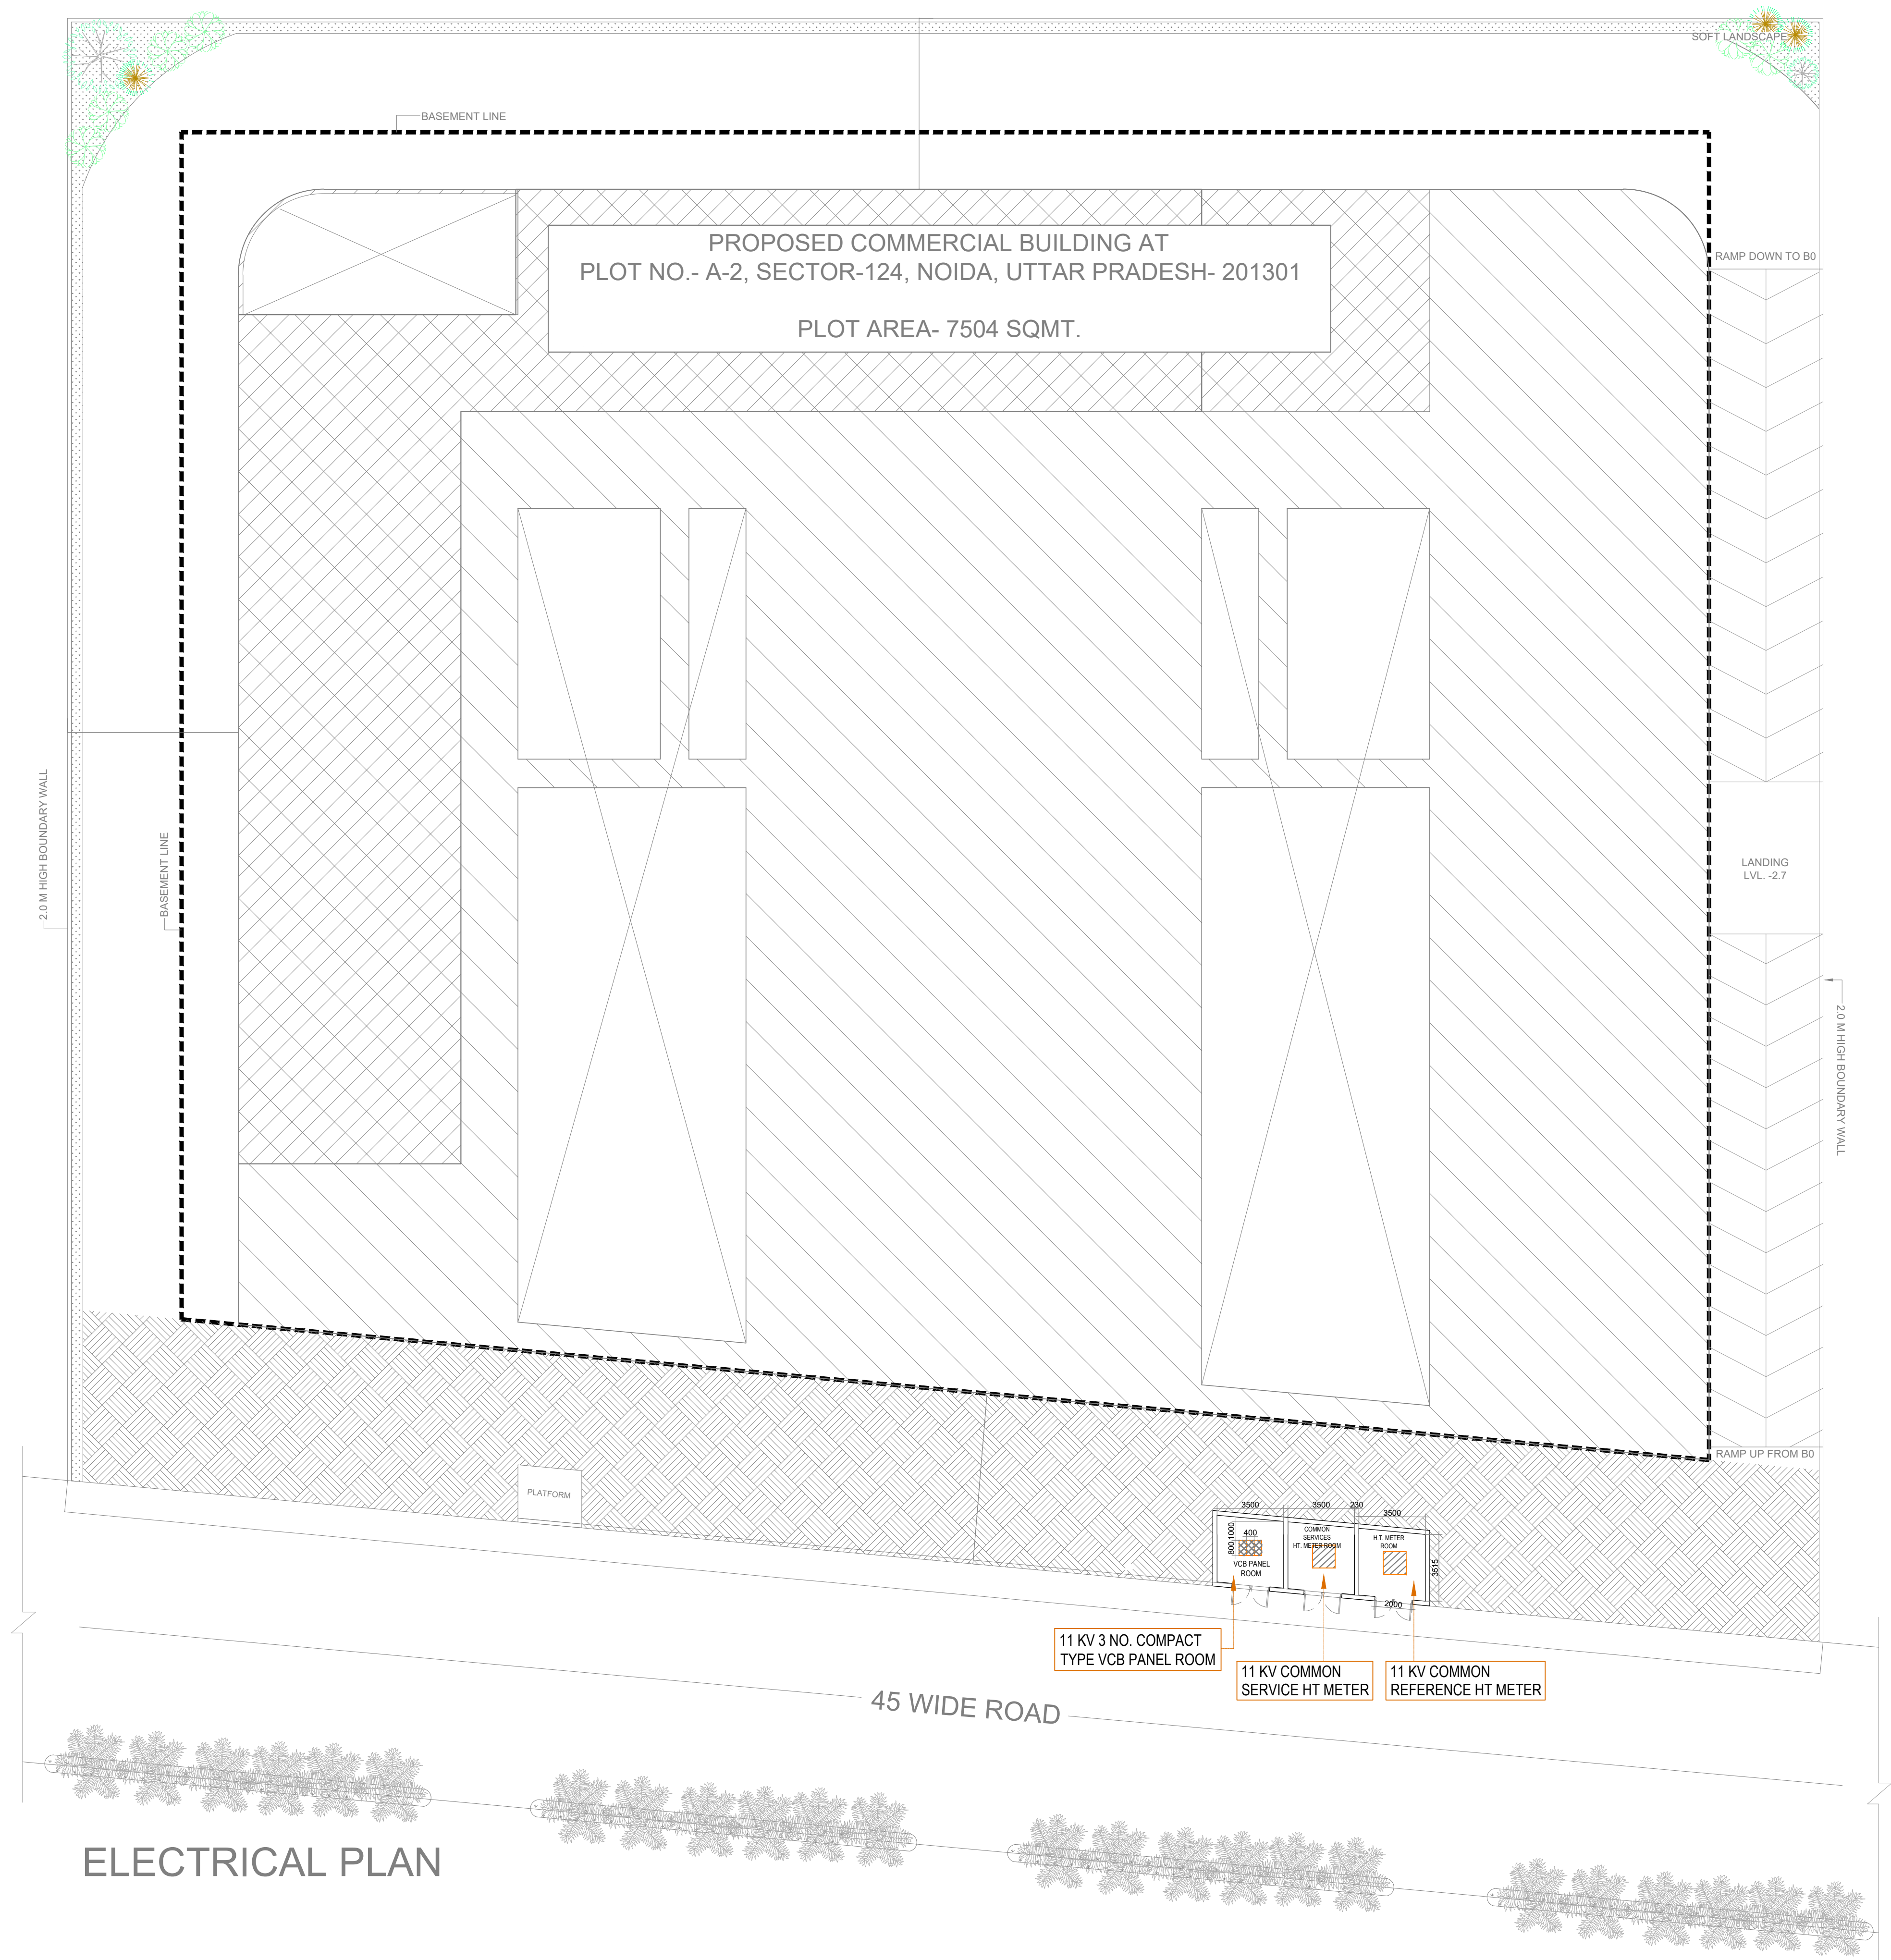

LEGEND :		
S. No.	SYMBOL	DESCRIPTION
1.		
2.		
3.		
4.		
5.		
6.		
7.		
8.		
9.		
10.		
11.		

OWNER'S SIGN:	ARCHITECT SIGN:	ORIENTATION:

OWNER:
CLEARLAKE PRIVATE LIMITED

LOCATION:
**PLOT NO. - A-2, SECTOR-124, NOIDA,
UTTAR PRADESH-201301**

Project
PROPOSED SUBMISSION
DRAWING FOR COMMERCIAL COMPLEX "DASNAC YUVA"
AT SECTOR-124, NOIDA, UTTAR PRADESH

Title
ELECTRICAL PLAN

Subtitle
EXTERNAL COMBINED SERVICES

Drawing released for
☐ APPROVAL ☒ SUBMISSION
☐ ADVANCE COPY ☐ CONSTRUCTION

Drg. no. **DASNAC124 / EX / S-05** Drawn by **Kulwant**

Scale **1 : 200** Designed by **R.K.**

Date **Aug. 2024** Checked by **Anand Havelia**

Architects
NIDA CONSULTANTS
architects, engineers, interior, project management
V-23/7/B, SECTOR-12, NOIDA, PH-0120-2535107
nidacconsultants.noida@gmail.com,

services consultant
Cespl Consultants Pvt. Ltd.
Noida Office : B - 67, Sector - 67, Noida - 201 301
cespl Tel : (0120) 3225400 / 3225401
e mail : mail@cespl.in, website : www.cespl.in