


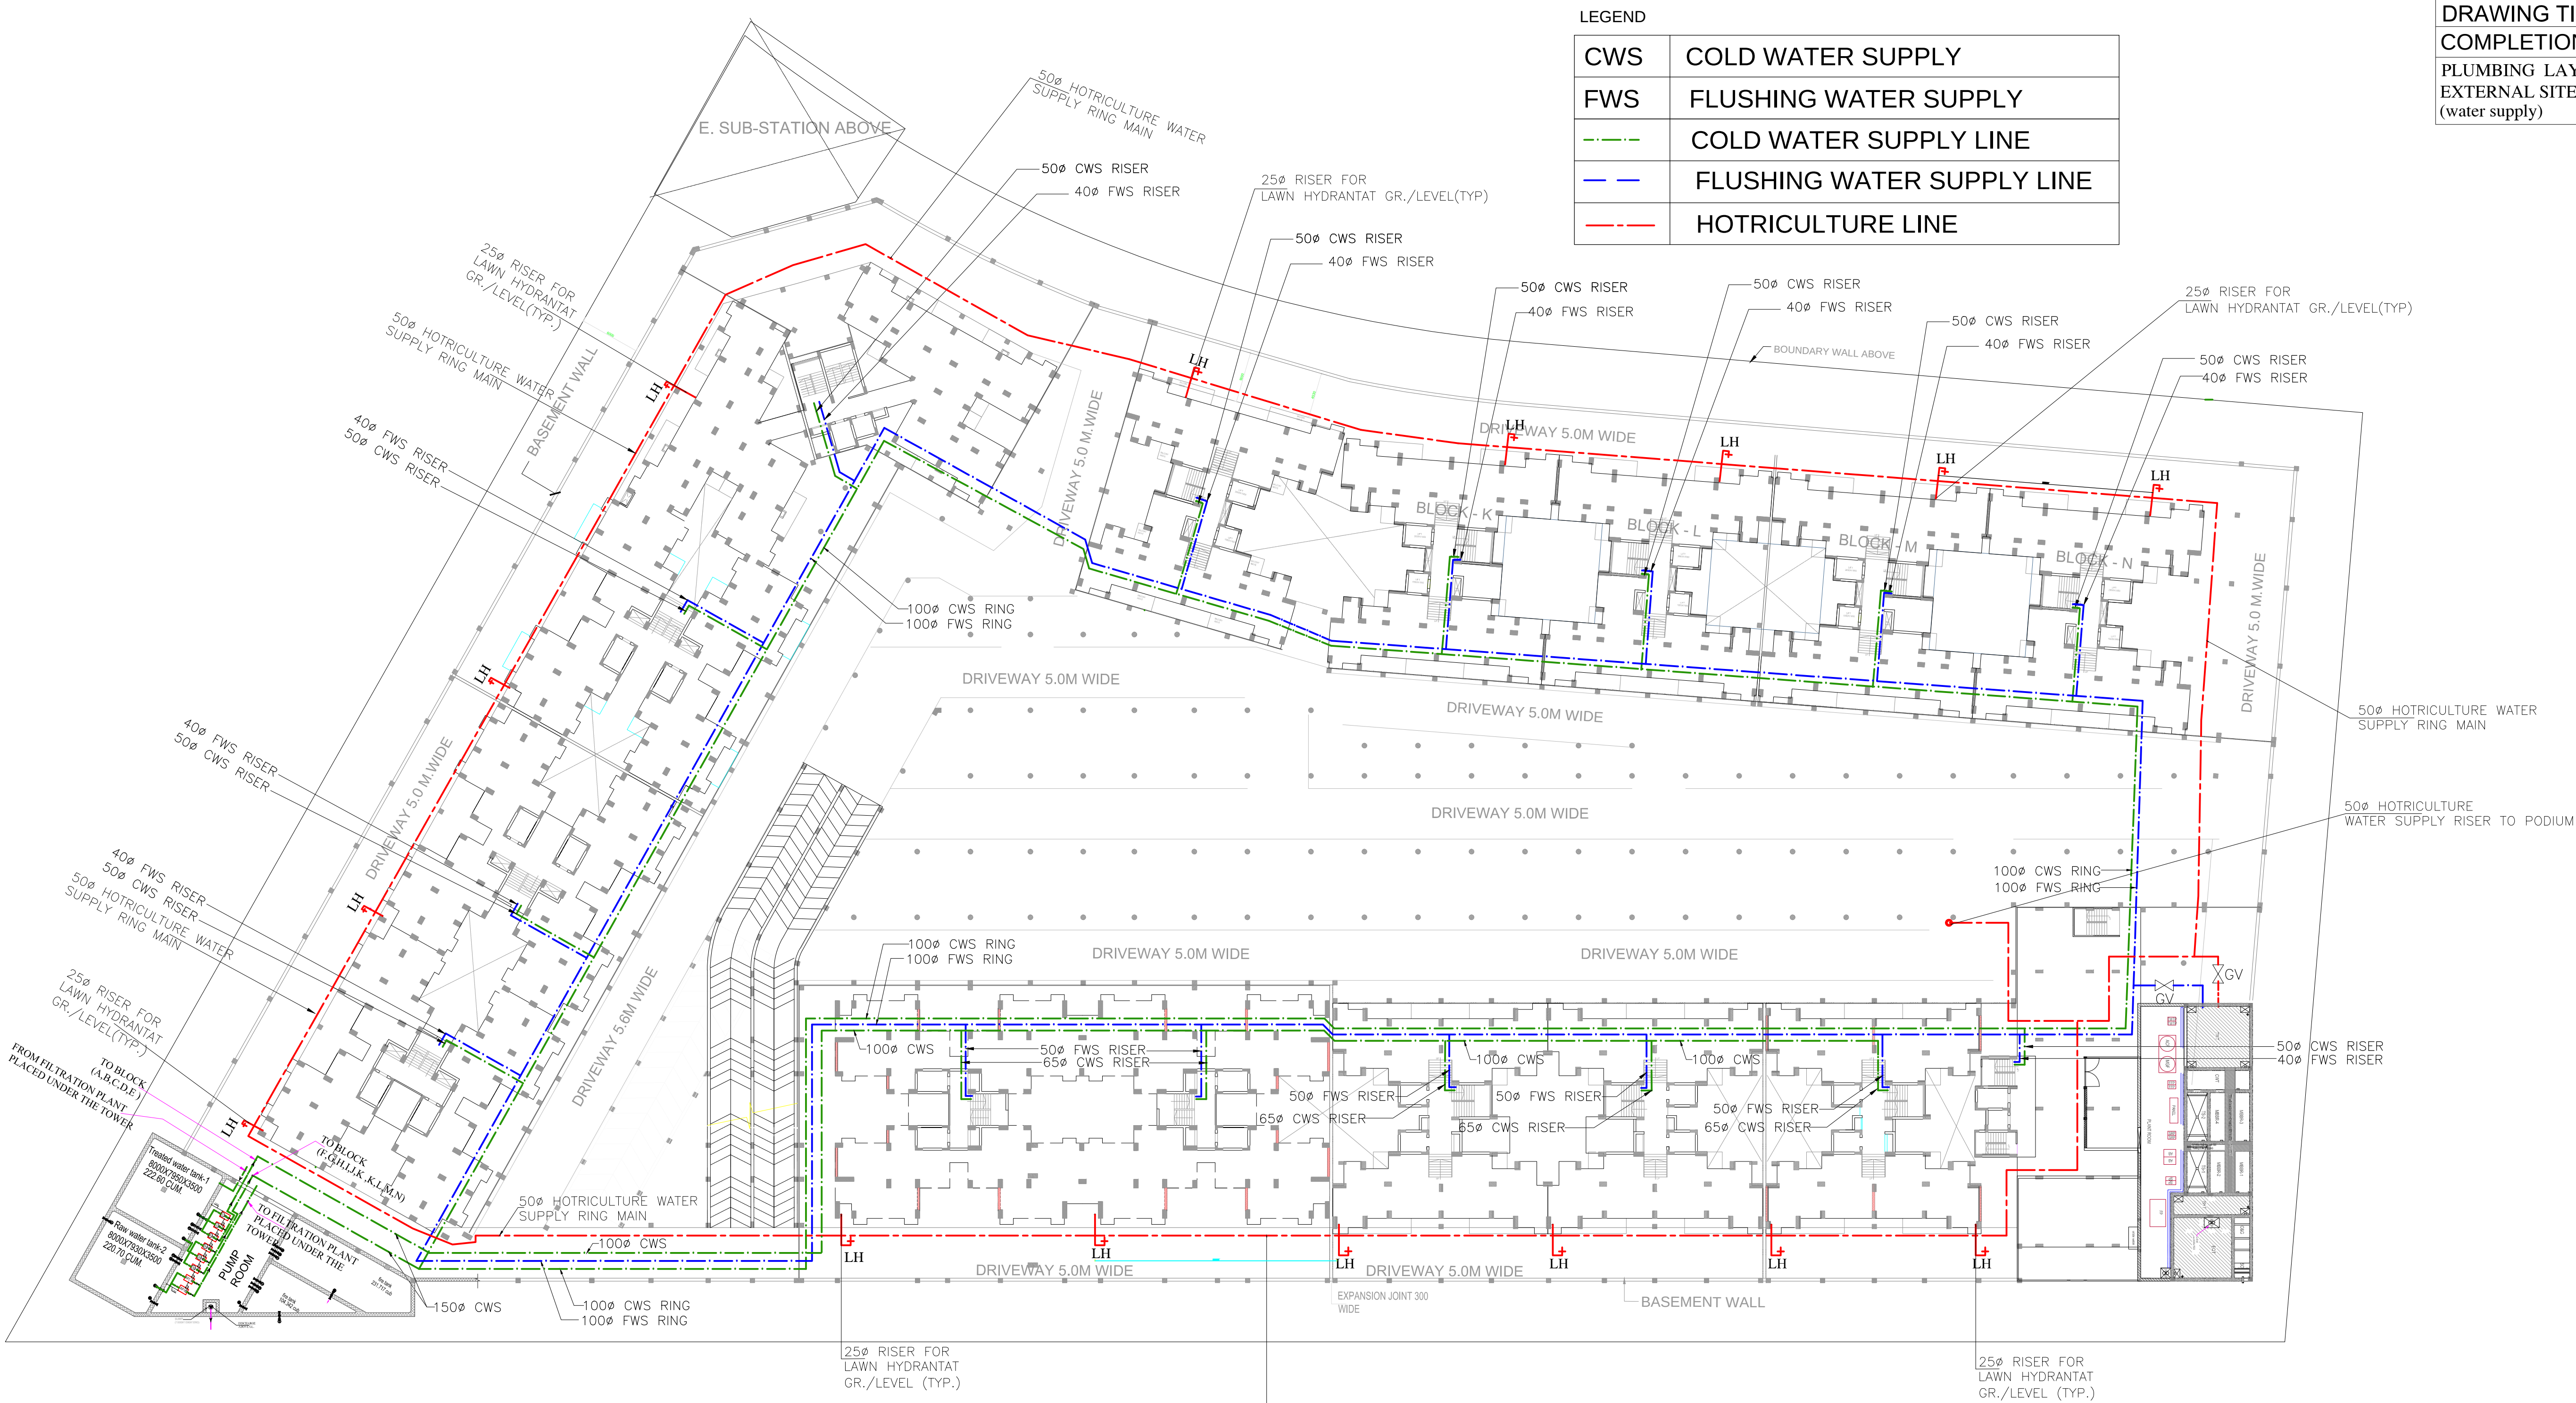

LEGEND	
CWS	COLD WATER SUPPLY
FWS	FLUSHING WATER SUPPLY
---	COLD WATER SUPPLY LINE
---	FLUSHING WATER SUPPLY LINE
---	HOTRICULTURE LINE

DRAWING TITLE	DRG. NO.
COMPLETION DRAWING	
PLUMBING LAYOUT	PL/EXT/WS/02
EXTERNAL SITE PLAN	
(water supply)	

PUMP DETAIL

	TAG NO.	CAPACITY	HEAD	SIZE		
D1	DOMESTIC PUMPS	500 LPM	@ 90M	600X900	FOR BLOCK A,B,C,D,E	2 WORKING 1 STAND BY
D2	DOMESTIC PUMPS	500 LPM	@ 90M	600X900		
D3	DOMESTIC PUMPS	500 LPM	@ 90M	600X900		
D4	DOMESTIC PUMPS	750 LPM	@ 70M	600X900	FOR BLOCK F,G,H,I,J,K,L, M,N,O	2 WORKING 1 STAND BY
D5	DOMESTIC PUMPS	750 LPM	@ 70M	600X900		
D6	DOMESTIC PUMPS	750 LPM	@ 70M	600X900		
RP1	RAW PUMPS	AS/WATER TEST RESULT		600X900		
RP2	RAW PUMPS	AS/WATER TEST RESULT		600X900		
	VALVE					
	NON RETURN VALVE					

PROJECT TITLE			
PROPOSED GROUP HOUSING GAUR CITY-2 AT PLOT NO GH-3I SECTOR 16-C, GREETER NOIDA			
PROMOTERS			
MS. JINDAL PROMOTERS/PLTD. THROUGH:-MR. J.P. CHAUHAN			
SCALE	NTS		DRG. NO.
DATE	JUL. 2017		PL/EXT/WS/02
DEALT	J.P. SHARMA	CHECKED	VG
ARCHITECT			
Design Axis architects T-10A ANI BAGH FARM HOUSE, NEAR SHAWATI TULAB ANDHERA WEST, MUMBAI, NEW DELHI - 110030 PH - 9811055563, 26644831, 26648146 EMAIL - vireshg@hotmail.com			
ARCHITECT'S SIGN.			
APPLICANT'S SIGN.			