


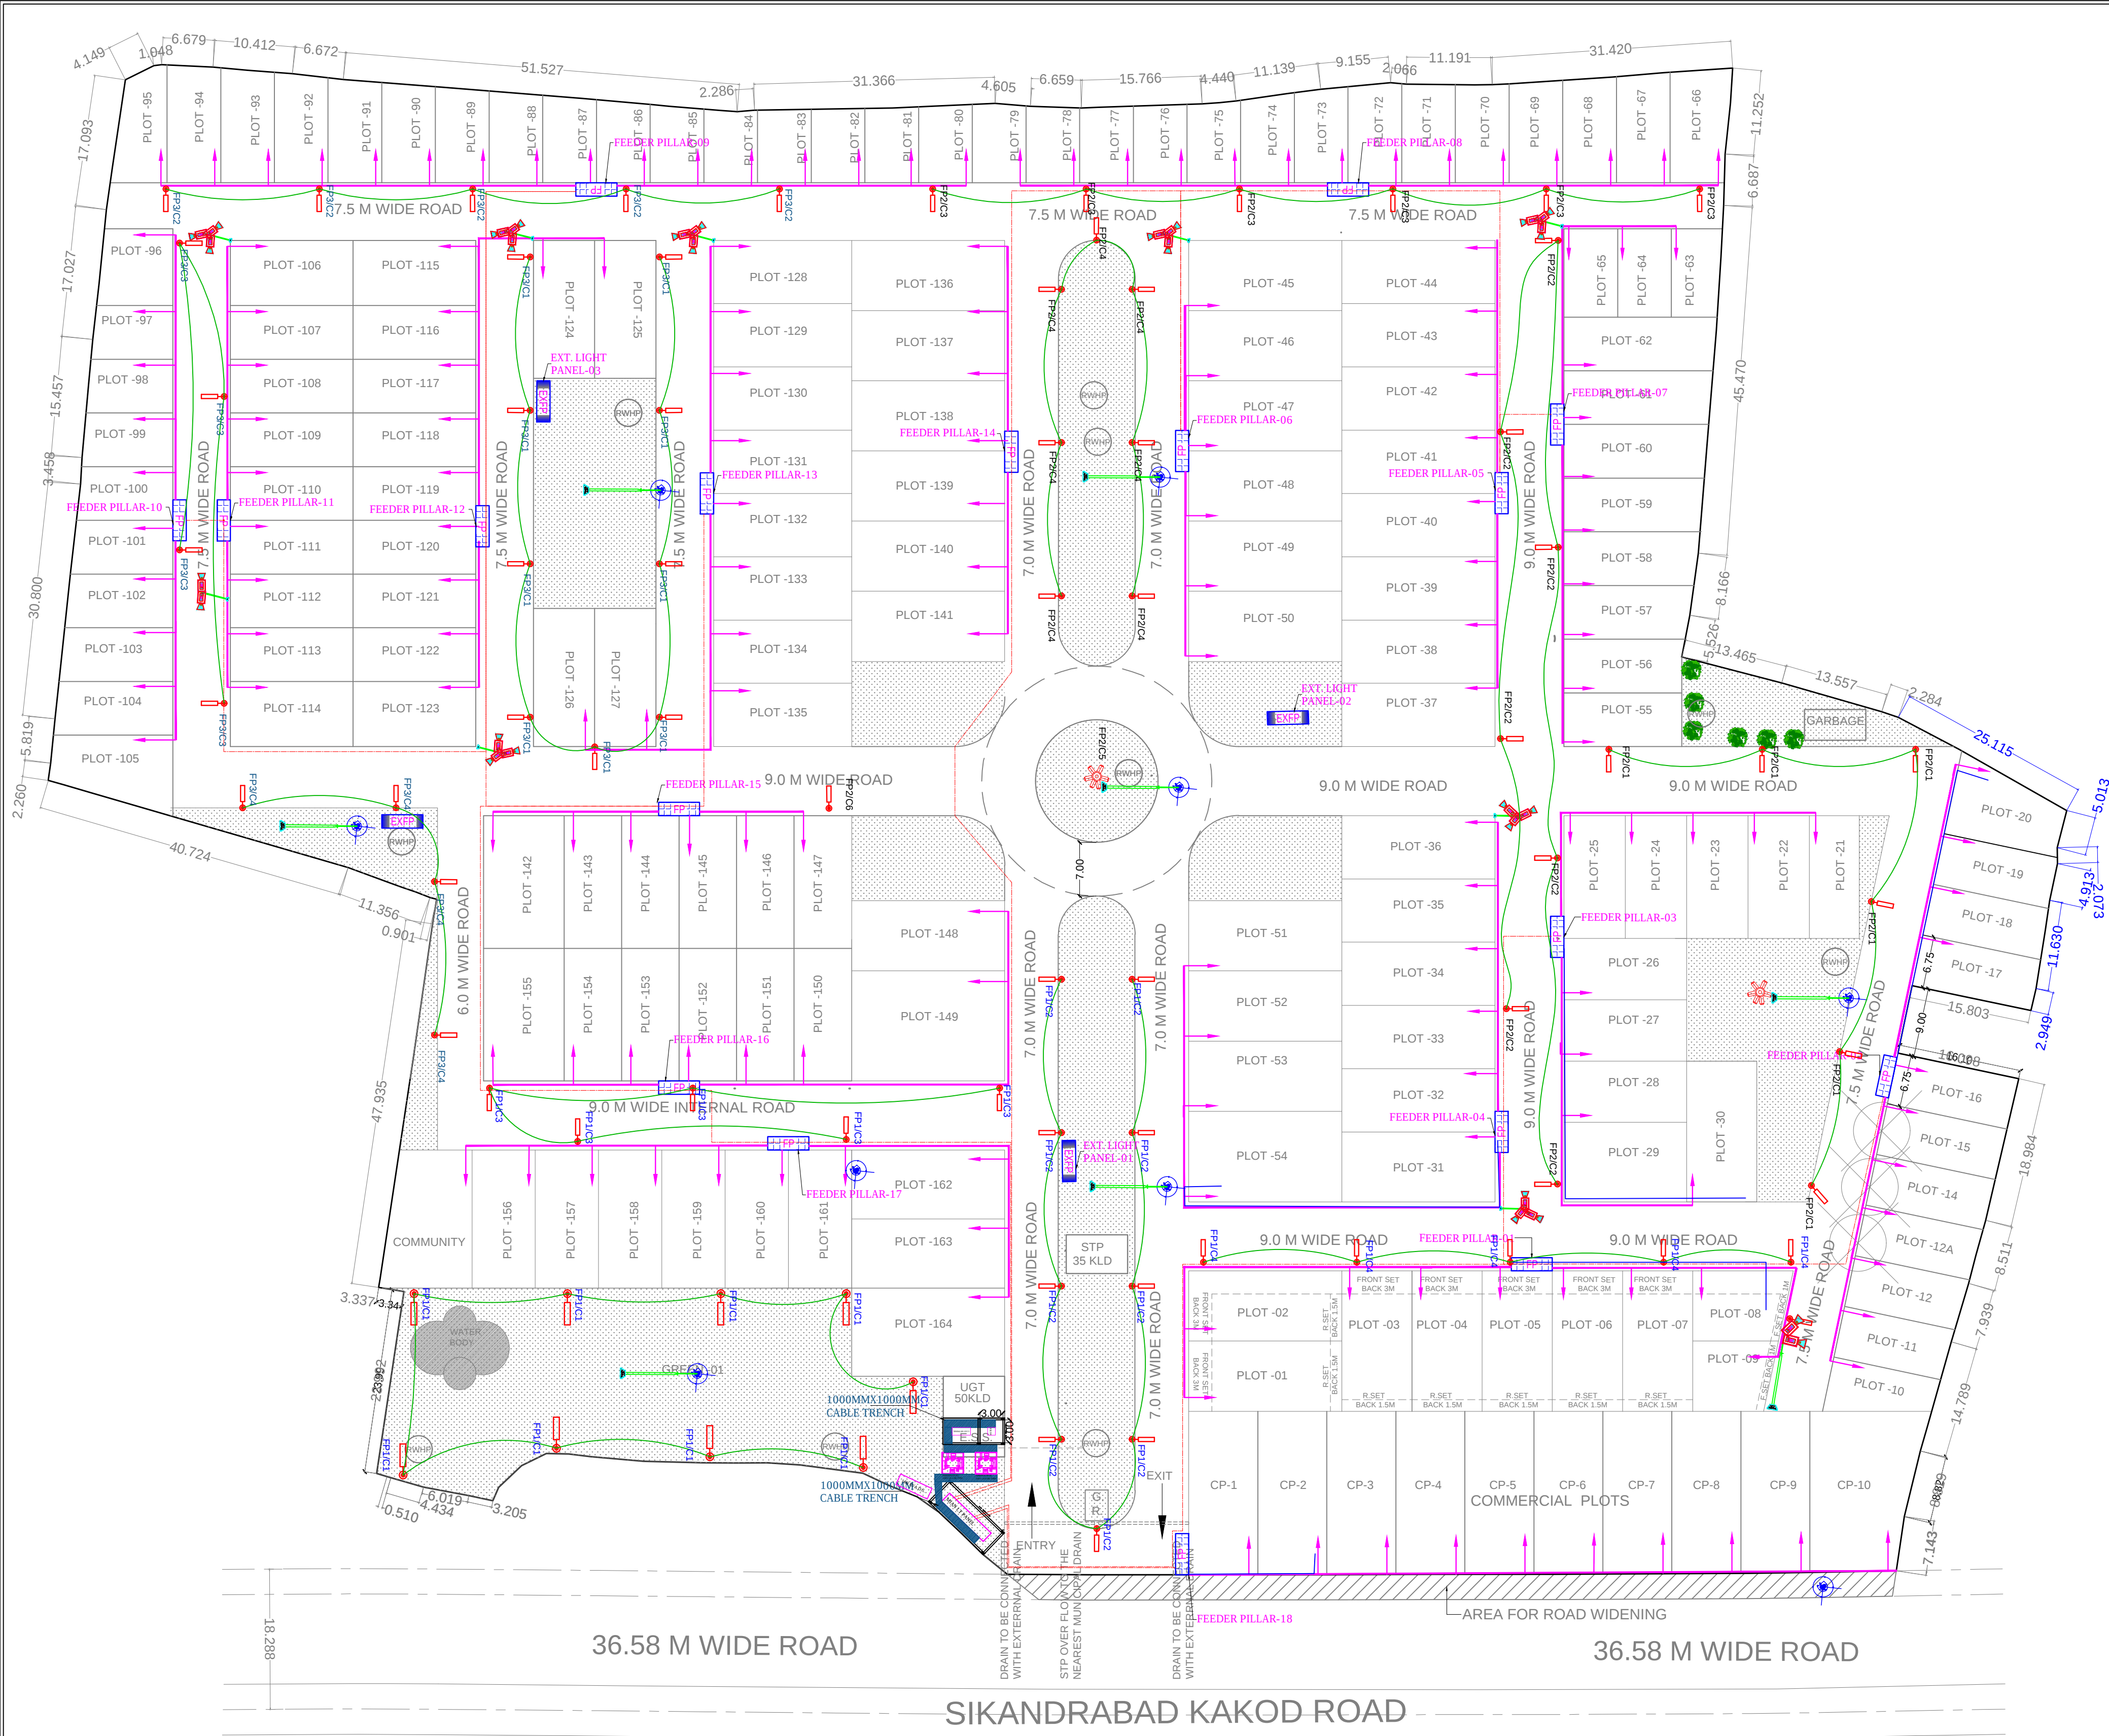

LEGEND :-

S.NO.	SYMBOL	DESCRIPTION
1.		LT PANEL TO FEEDER PILLAR ROUTE
2.		FEEDER PILLAR TO PLOTS CABLE ROUTES
3.		9M POLE BOUBLE ARM WITH 110W LED
4.		9M POLE SINGLE ARM WITH 110W LED
13.		16 M HIGH MAST LIGHT

LEGEND :-

S.NO.	SYMBOL	DESCRIPTION
1.		BULLET CAMERA
2.		PTZ CAMERA
3.		POLE

CLIENT SIGN :- 	ARCHITECT SIGN :-
--------------------	-----------------------

CLIENT :-
M/S HIRNOT GROUP ROYAL
SWARNJAYANTI PURAM, GHAZIABAD

PROJECT :-
PROPOSED PLOTTED DEVELOPMENT
'ICONIC ADDRESSES'
AT KHASRA NO. - 1830 AT
SIKANDRABAD, BULANDSHAHR

ARCHITECT :-

Creative
L I N E S
ARCHITECTURE - INTERIORS - LANDSCAPING
LGF-18, Mark Mall, Sector-4B,
Vasundhara, Ghaziabad, U.P., 201012
Mail :- creativelinesarchitects@gmail.com

DRAWING TITLE :-
SITE ELECTRICAL LAYOUT PLAN

DRAWN BY :- S.S.	CHECKED BY :- A.P.	NORTH:-
DATE :- 03.05.2026	SCALE :- 1:500	DWG NO. EL-01