
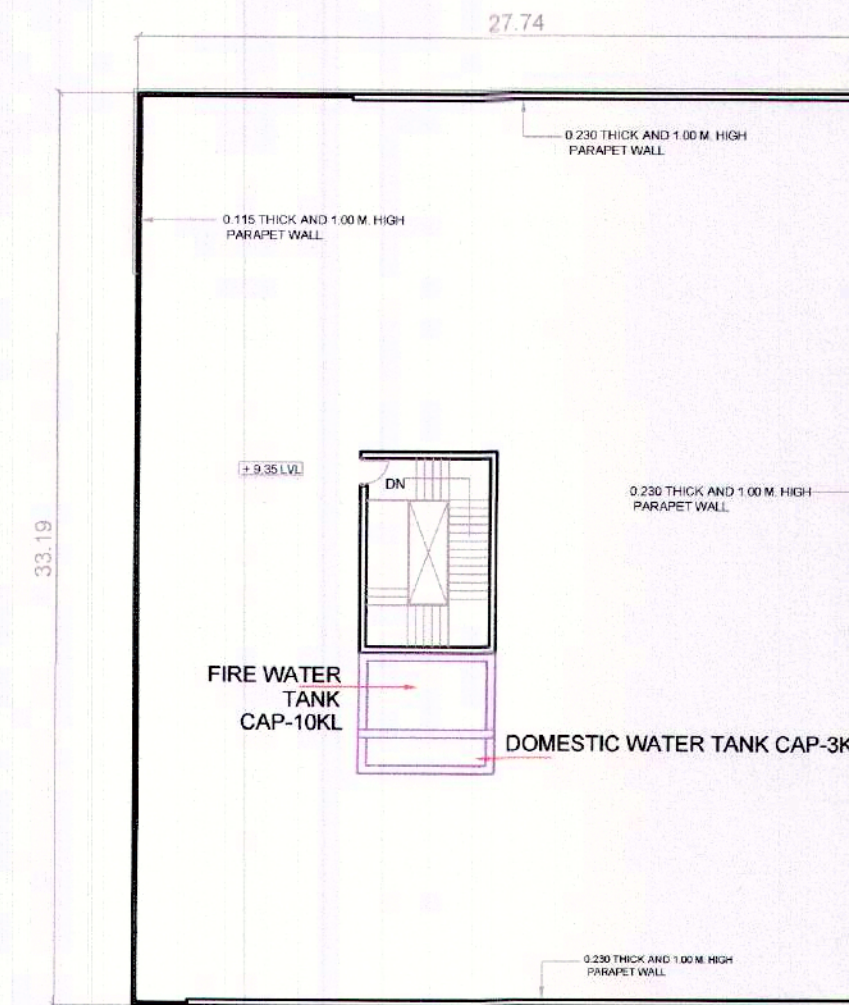
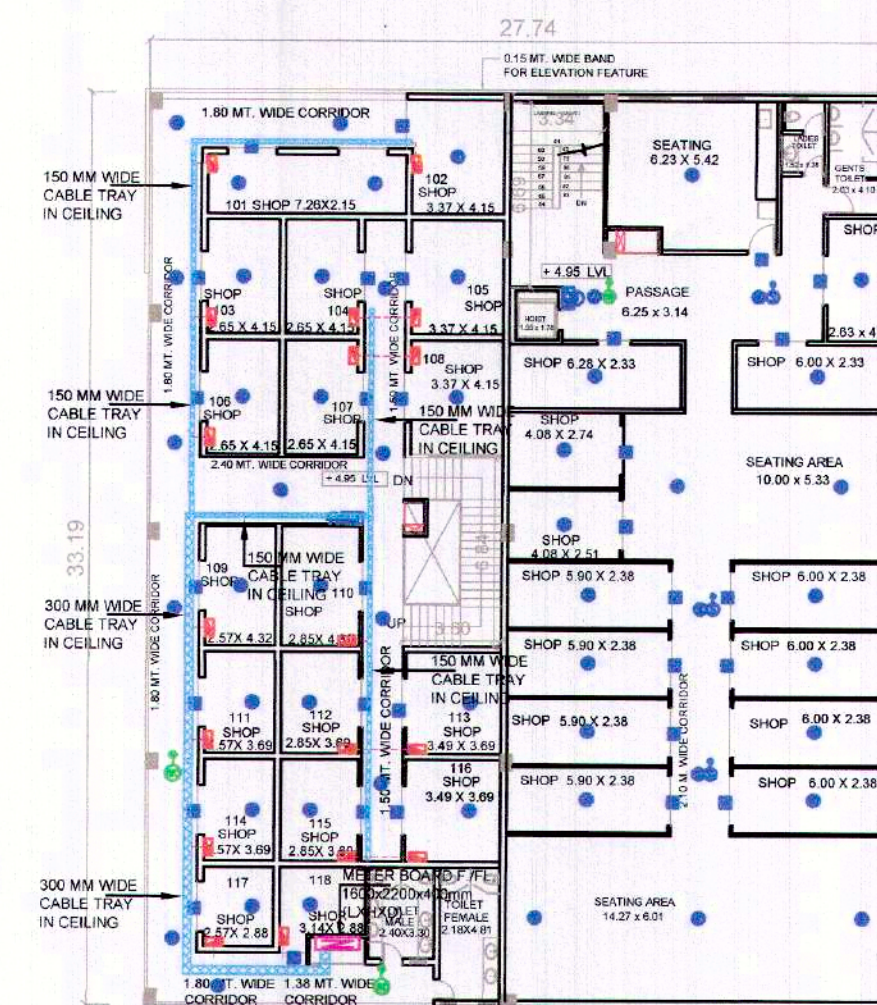


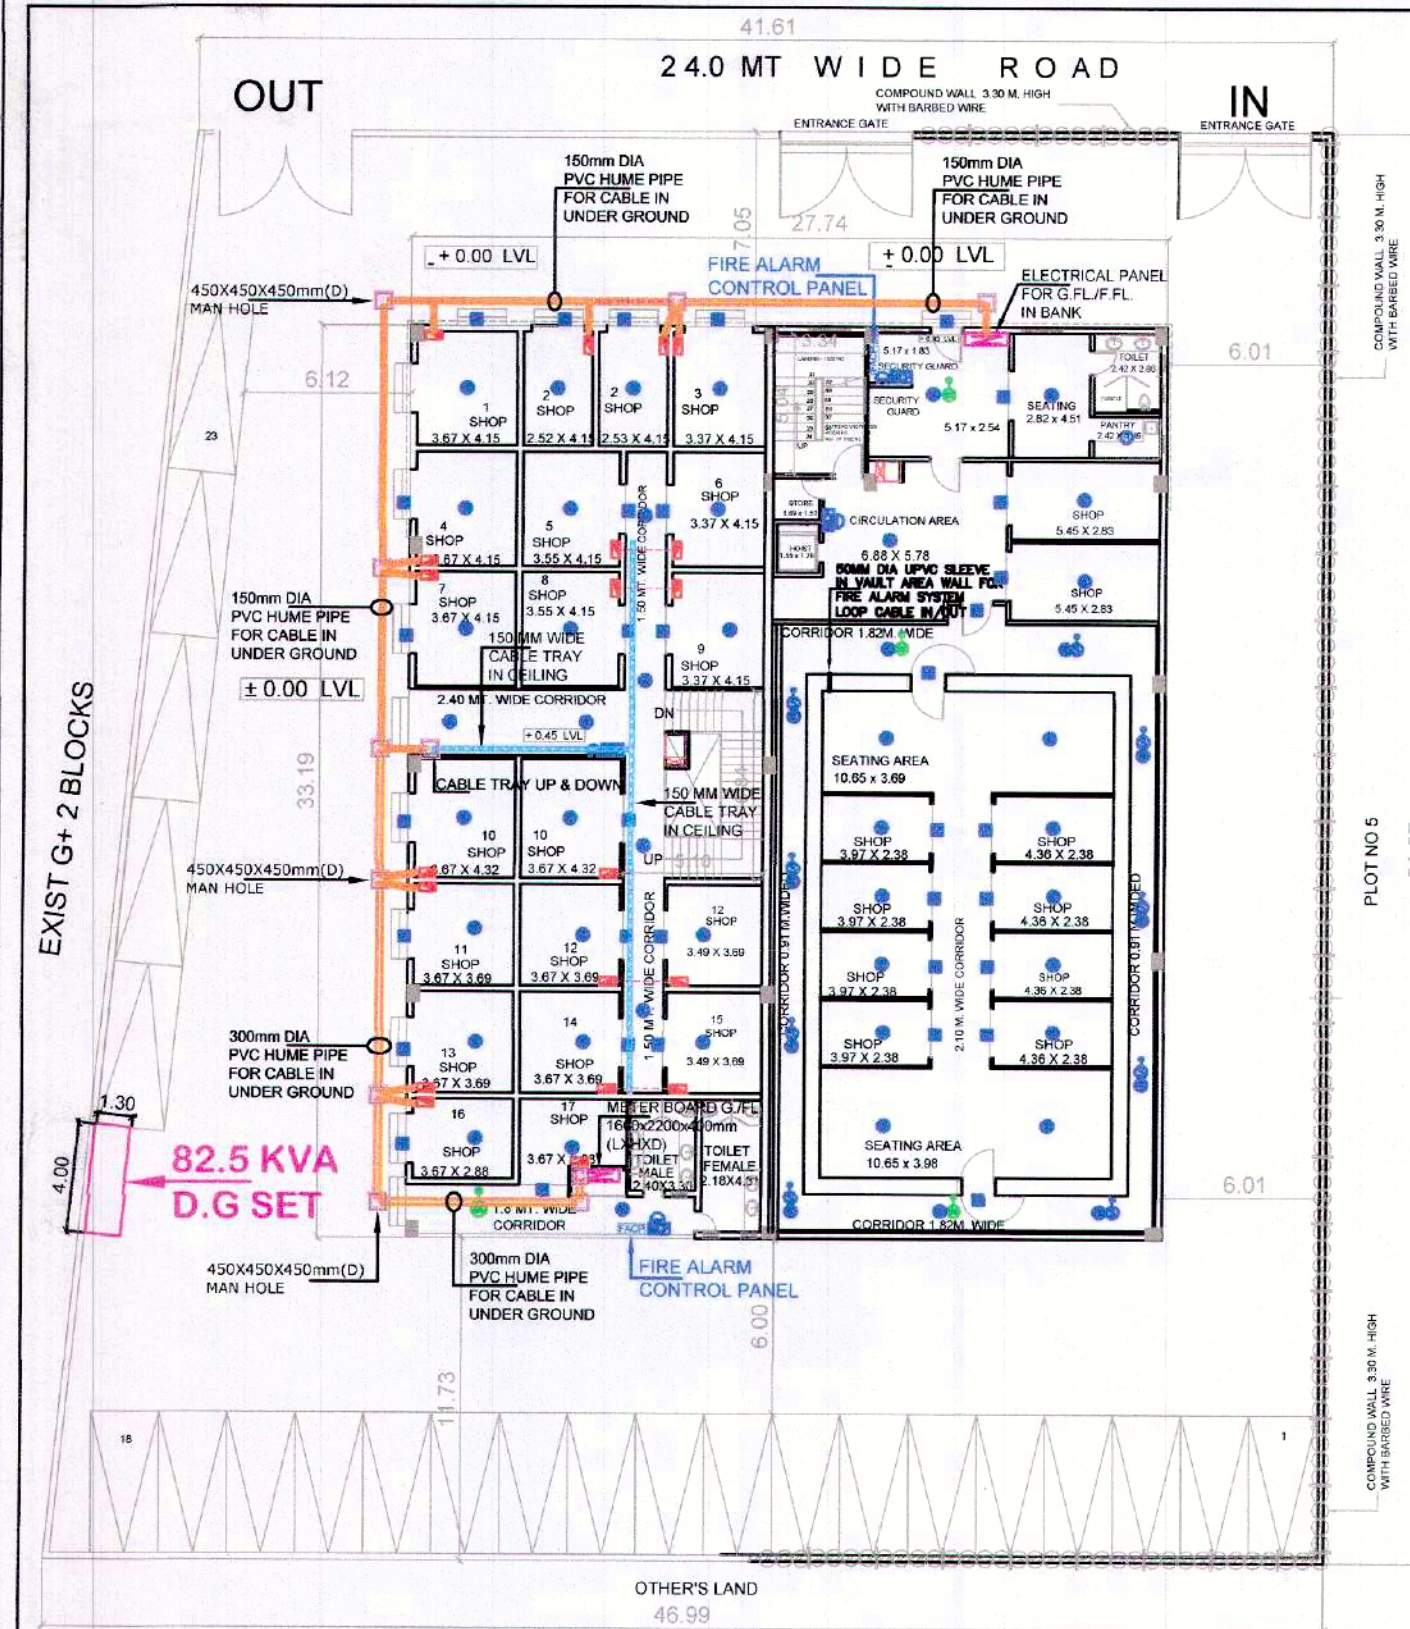


TOTAL PLOT AREA = 2302.23 SQMTS
PERM GRD. COVERAGE @ 40 % = 920.892 SQMTS
PROPOSED GRD. COVERAGE = 920.69 SQMTS i.e. 39.99 %
TOTAL FAR PERMISSIBLE @ 1.20 = 2762.676 SQMT

GROUND FLOOR COVERED AREA = 27.74x33.19 =920.69 SQ.MT.
FIRST FLOOR COVERED AREA = 27.74x33.19 =920.69 SQ.MT.
TOTAL COVERED AREA = 920.69 X 2 = 1841.38 SQ.MT. (0.799)

CAR PARKING DETAIL:
FOR COMMERCIAL @ 1.25 ECS PER 100 SQ.M. OF COVERED AREA
TOTAL COVERED AREA = 1841.38 SQ.MT.
PERMISSIBLE CAR PARKING = $1841.38/100 \times 1.25 = 23$ nos.
PROPOSED CAR PARKING = 23

FIRE ALARM LEGENDS	
	HEAT DETECTOR
	SMOKE DETECTOR
	SMOKE DETECTOR CEILING VOID WITH RI
	SMOKE DETECTOR CEILING VOID WITH FAULT ISOLATOR
	RESPONSE INDICATOR
	HOOTER
	MANUAL CALL POINT
	FIRE ALARM CONTROL PANEL
	300mm DIA PVC HUME PIPE
	150mm DIA PVC HUME PIPE
	300 MM WIDE CABLE TRAY
	150 MM WIDE CABLE TRAY
	450X450X450mm(D) MAN HOLE

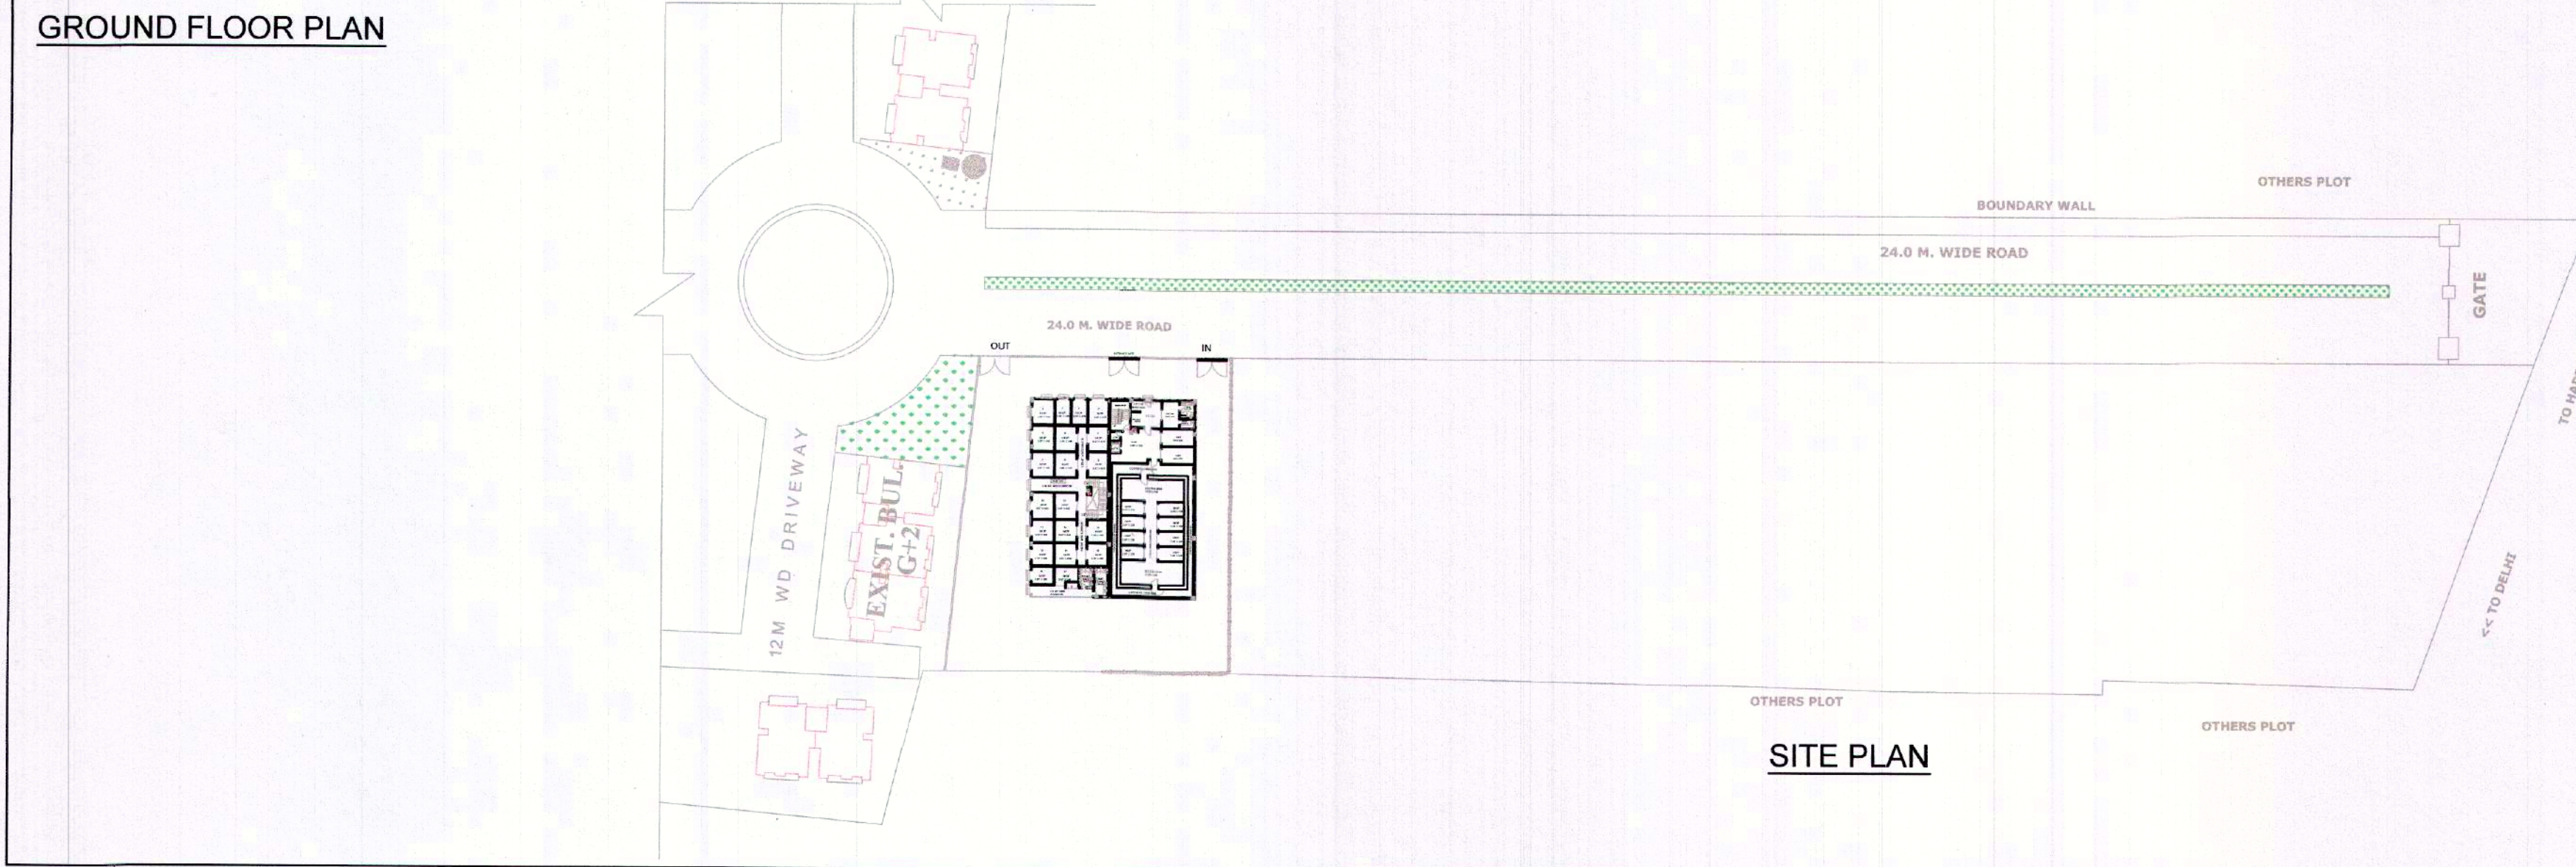

SUBMISSION DRAWING

PROJECT :
PROPOSED CONVENIENT SHOPPING
AT (VILLAGE JATAULI , ROSHAN PUR DORLLI)
ANSAL TOWN - MEERUT

TITLE: ELECTRICITY SUPPLY PLAN

DEALT BY:	DATE -
CHECKED BY:	SCALE: 1: 200
DRG NO. SERV./1052/MEERUT-AT/COM SUB/01	

For Ansal Housing & Construction Ltd.
(Authorized Signatory)

OWNER'S

ANSAL HOUSING LTD.
REGD. OFFICE: 606,INDRA PRAKASH
21,BARAKHAMBA ROAD
NEW DELHI - 110 001

BANPHOL RAGHUVANSHI
Architect

ARCHITECT

