



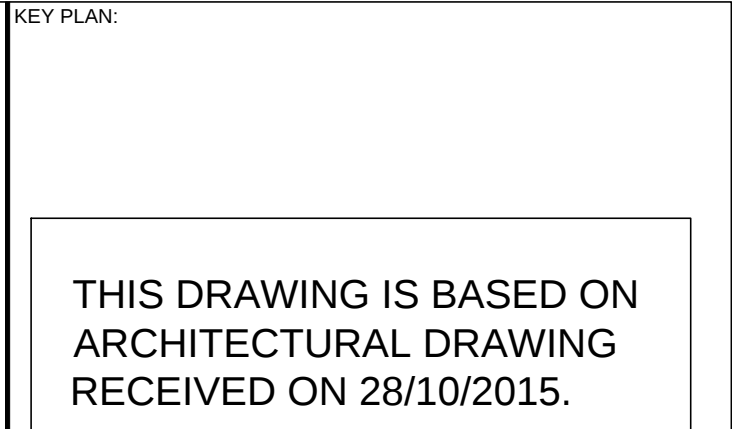

LEGEND SYMBOL	DESCRIPTION
	FRESH AIR DUCT
	EX. AIR DUCT
	PREES. DUCT
	AXIAL FLOW FAN
	MOTORIZED FIRE DAMPER
	CONTROL PANEL

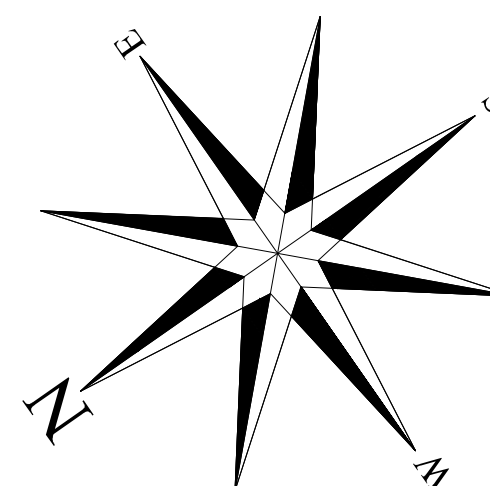

04-11-2015	ISSUED TO CLIENT & ARCHITECTS		BY EMAIL
27-10-2015	ISSUED TO CLIENT & ARCHITECTS		BY EMAIL
16-10-2015	ISSUED TO CLIENT & ARCHITECTS		BY EMAIL
06-10-2015	ISSUED TO CLIENT & ARCHITECTS		BY EMAIL
DATE	DRAWING ISSUED TO		NO. OF PRINTS
DRAWING ISSUED			
R6	04-11-2015	AS PER DISCUSSION IN MEETING AT MAHAGUN OFFICE ON 28.10.2015. COMMENTS INCORPORATED RECEIVED FROM CLIENT ON 23.10.2015.	U.K. O.S.A
R5	27-10-2015	REVISED MEP LAYOUT	U.K. O.S.A
R4	13-10-2015	REVISED MEP LAYOUT	U.K. O.S.A
R3	03-10-2015	BRAIN CHANNEL LOCATION SHIFT IN CENTER SUMP. DETAIL ADDED	U.K. O.S.A
R2	20-08-2015	REVISED AS PER NEW ARCHITECTURE / COMMENTS	M.R. R.K
R1	17-06-2015	REVISED AS PER NEW ARCHITECTURE / COMMENTS	M.R. R.K
R0	29-05-2015	FIRST ISSUE	M.R. R.K
REV.	DATE	DESCRIPTION	DRN. CKD.
REVISION			
ARCHITECT:		Architect Hafeez Contractor	
CLIENT:		MAHAGUN	
PROJECT:		MAHAGUN WISH TOWN AT NOIDA	
DRAWING TITLE:		ELECTRICAL LAYOUT SILT FLOOR PLANT	
SERVICES CONSULTANTS:			
A-197, Sector-63 Noida 201301 Uttar Pradesh, INDIA		T: +91 120 4049000 F: +91 120 4049001 www.abecom.com	
STATUS: SCHEMATIC STAGE			
SCALE: 1 : 250			
DATE: 29-05-2015			
DESIGNED BY: CPSUKKK			
DRAWN BY: CPSUKKK		CONTRACT NO: NODDI15021-SHT-10-0000-MEP-0004	
CHECKED BY: SSRKK/POSA		CONTRACT NO: NODDI15021	
APPROVED BY: PKC		SHT. NO. 01 NO OF SHT. 01 REVISION NO. R6	
© COPYRIGHT RESERVE			