
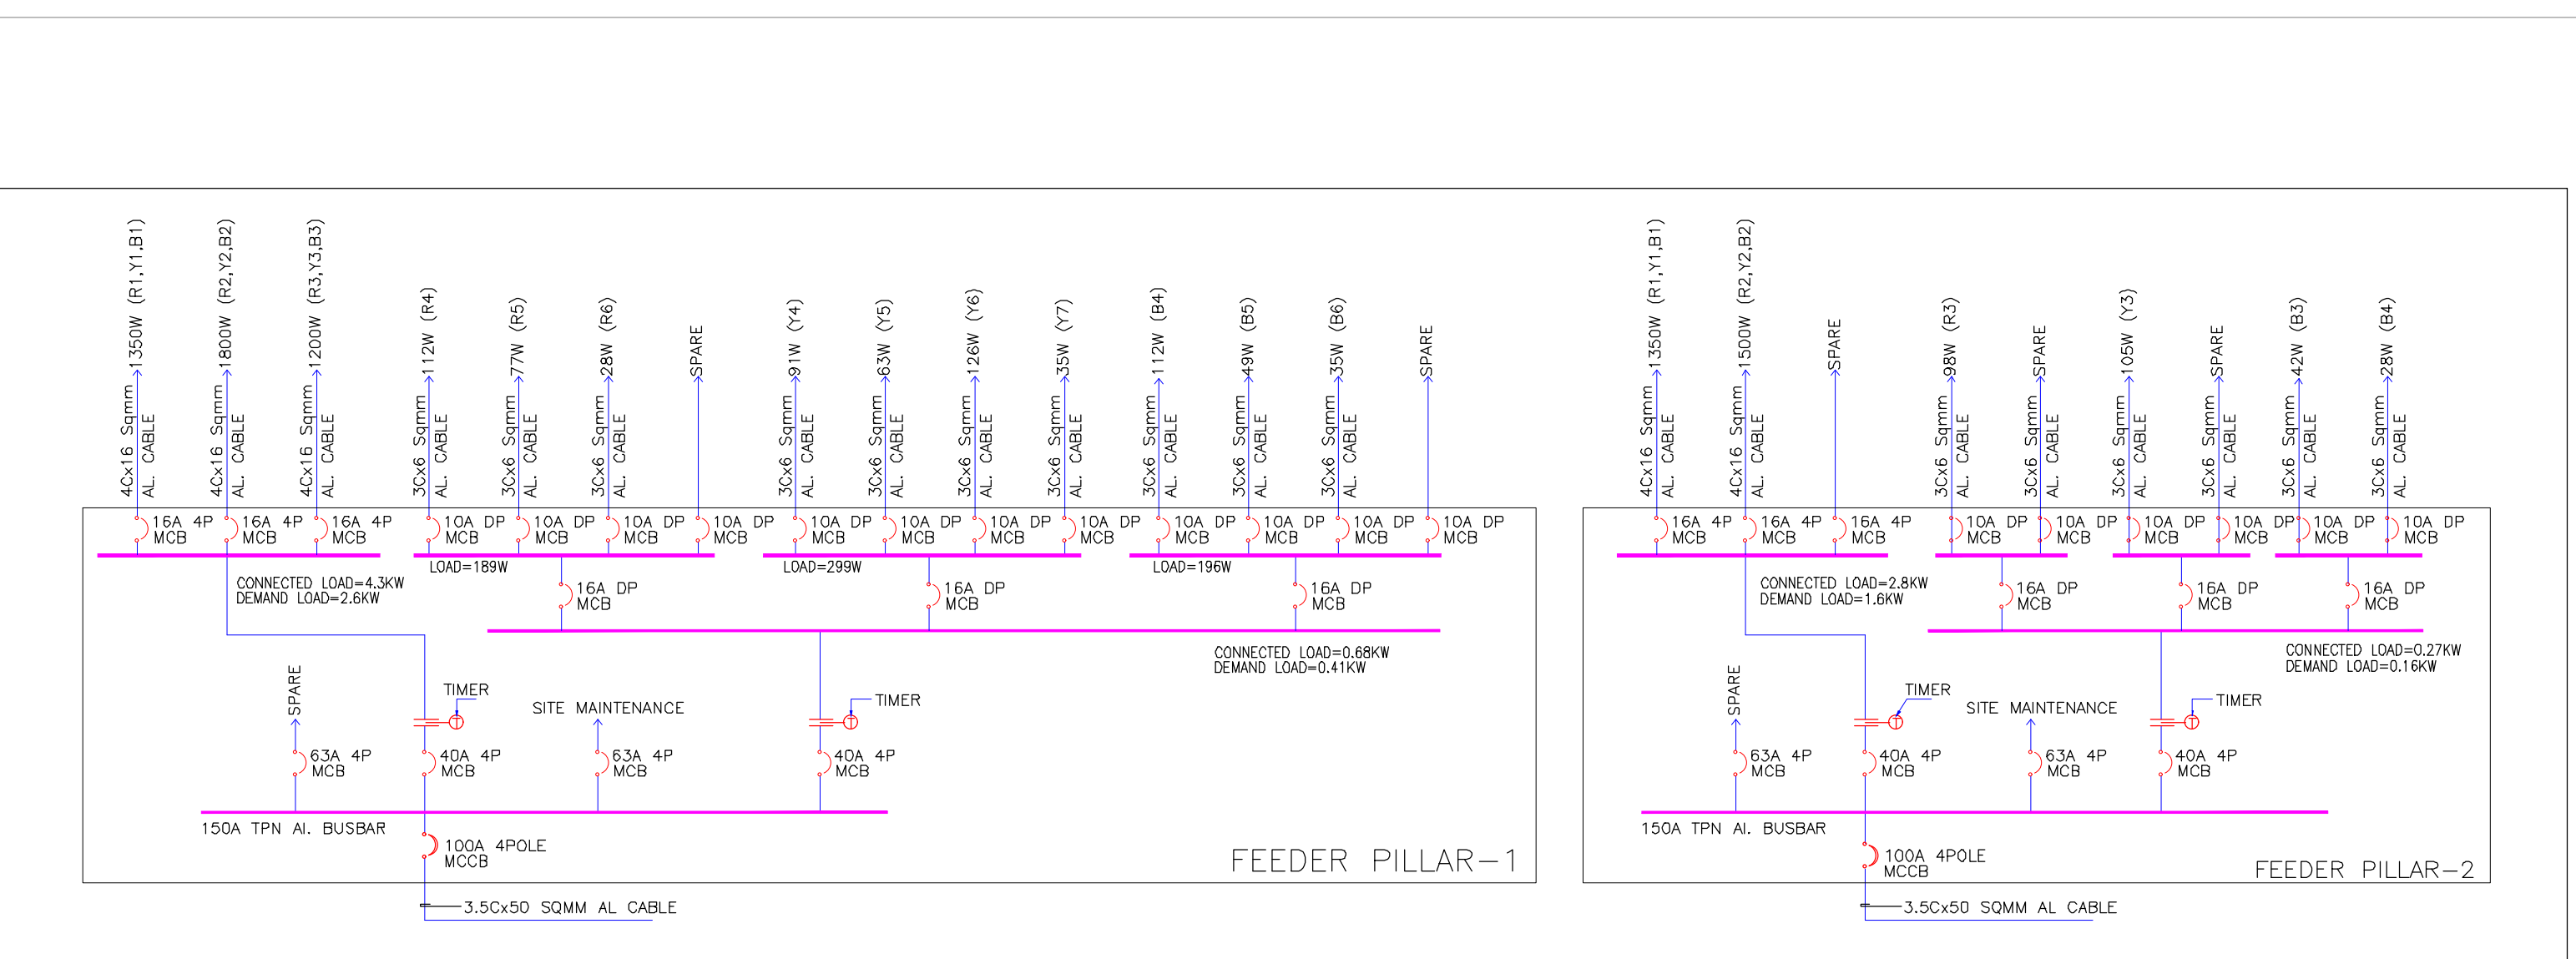


NOTE:-
ALL FOUNDATION SHELL BE VERIFY
BY STRUCTURE CONSULTANT

LEGEND :-

SYM.	DESCRIPTION
	EARTH PIT
	150 MM DIA HUME PIPE
	LT CABLE
	HT CABLE
	1x28W TUBE LIGHT
	SWITCH BOARD
	LIGHTING LOOPING

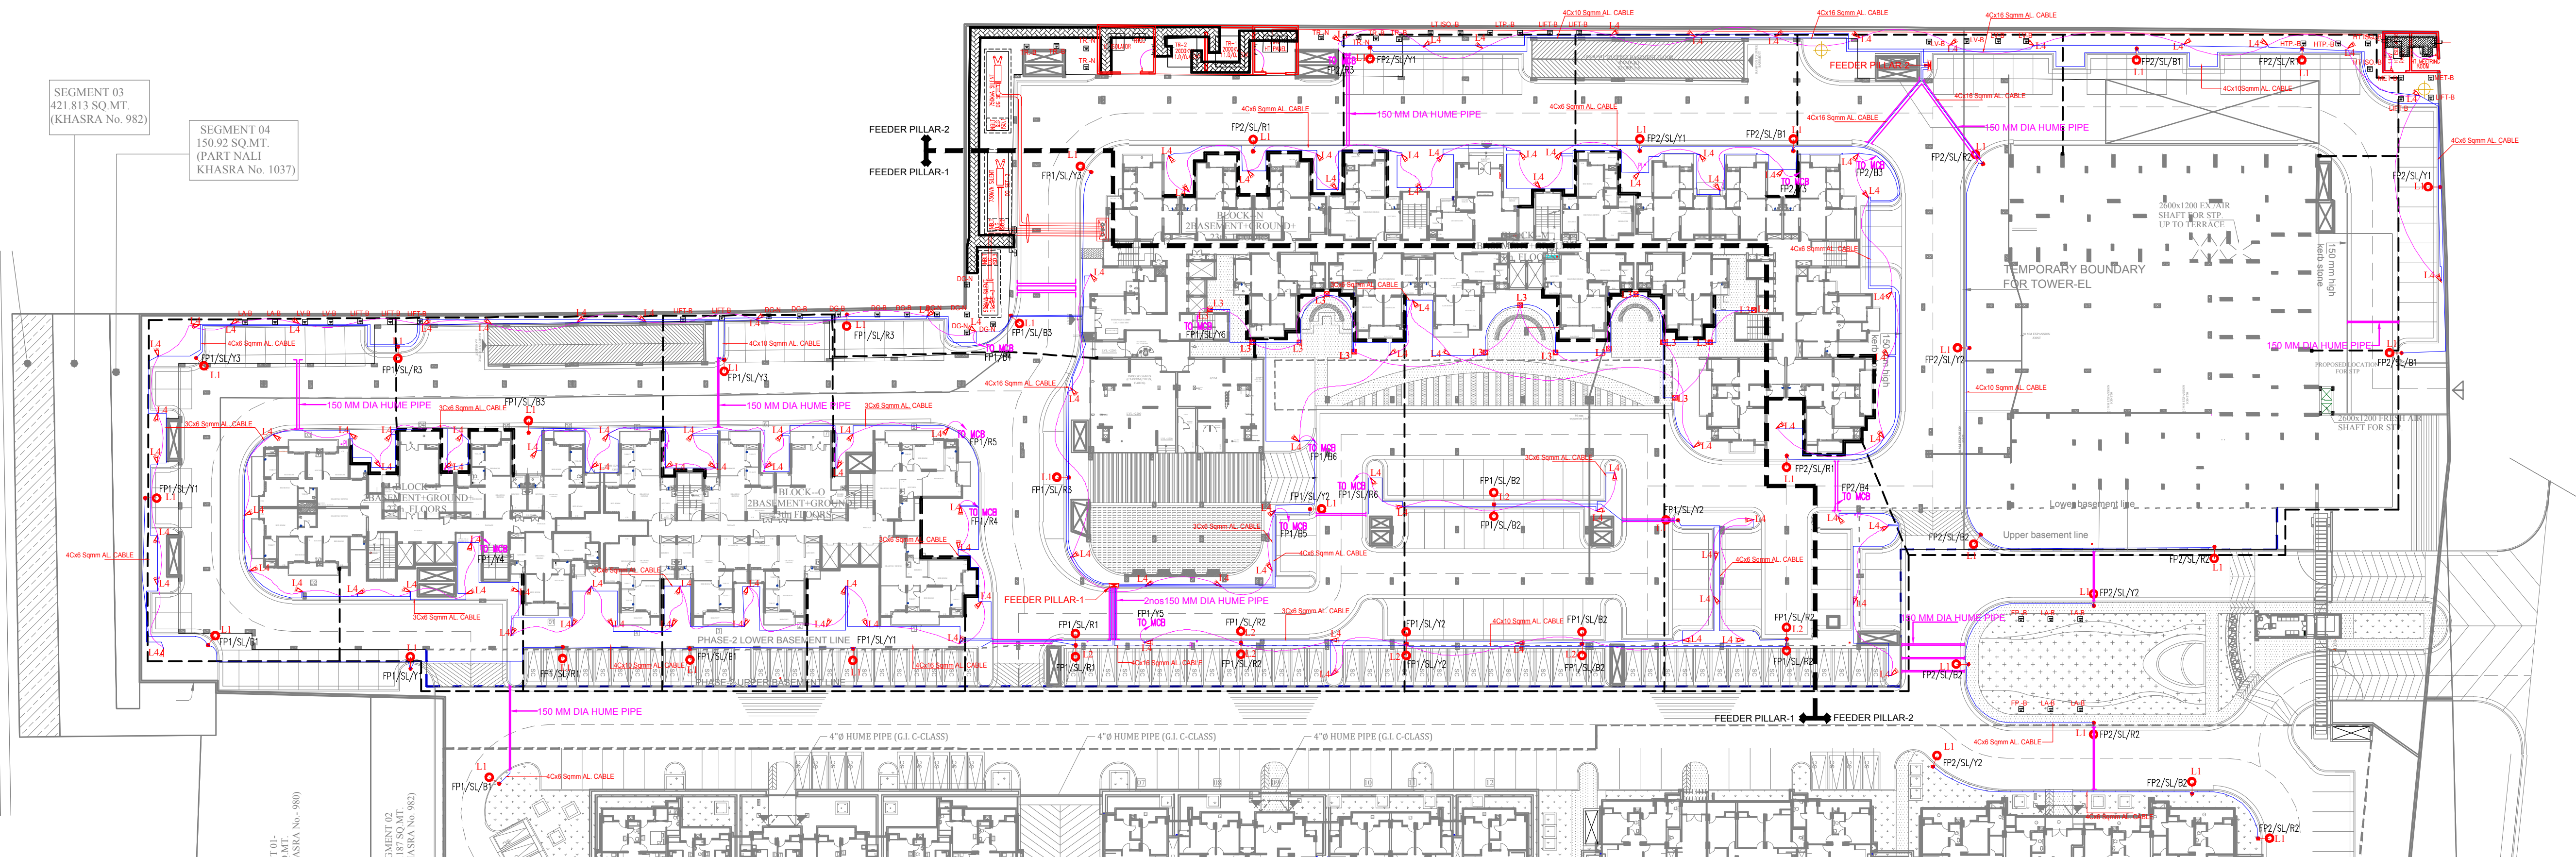

6M HIGH POLE LIGHT - L1	6M HIGH POLE LIGHT - L2	BOLLARDS - L3	SPIKE LIGHT - L4
QTY: 38 MODEL NO: LI-8435 (MODERN POLE LIGHT) HEIGHT: 6 M (INCLUDING FIXTURE) FIXING: OVER GROUND HOUSING: DIE CAST AL WITH POLYESTER FINISH FINISH: DIE-CAST ALUMINIUM RATING: IP 66 LAMP TYPE: MH/HPV(E-40BASE) WATTAGE: 1X150W LIGHT COLOUR: WARM WHITE MAKE: LUSTRE ILLUMINATIONS	QTY: 06 MODEL NO: LI-8435 (MODERN POLE LIGHT) HEIGHT: 6 M (INCLUDING FIXTURE) FIXING: OVER GROUND HOUSING: DIE CAST AL WITH POLYESTER FINISH FINISH: DIE-CAST ALUMINIUM RATING: IP 66 LAMP TYPE: MH/HPV(E-40BASE) WATTAGE: 1X150W LIGHT COLOUR: WARM WHITE MAKE: LUSTRE ILLUMINATIONS	QTY: 14 MODEL NO: LCO 1600-09 HEIGHT: 600 MM FIXING: SURFACE MOUNTED HOUSING: DIE CAST ALUMINIUM FINISH: BLACK IP RATING: IP 54 LAMP TYPE: 9W LED LIGHT COLOUR: WARM WHITE MAKE: LEGERO	QTY: 123 MODEL NO: LSO 307 FIXING: IN GROUND HOUSING: DIE CAST ALUMINIUM FINISH: BLACK IP RATING: IP 67 LAMP TYPE: 7W LED SUPPLY: 240 V LIGHT COLOR: WARM WHITE MAKE: LEGERO

PROJECT :-

MULTI STORY RESIDENTIAL COMPLEX
"AJNARA INTEGRITY"
AT, NOOR NAGAR,N.H-58 GHAZIABAD.

BUILDERS & PROMOTER :-

M/s AJNARA FARMS & SERVICES LTD.
502, 5th FLOOR,
SACHDEVA TOWER, PLOT No. 17,
KARKADOOMA COMMUNITY CENTER,
Delhi- 92.

ARCHITECTS :
Space Designers
Architects Pvt. Ltd.
5 / 1306 ,VASUNDHARA, GHAZIABAD
PH : 0120-4055214, Mob: 981070399 , 981535231
architects & planners e-mail: spacesd@gmail.com, www.spacedsi.com

MEP CONSULTANT:

Acrobat Engineers Pvt.Ltd.

AE
H.No. 19 Block-18
Basement Level Spring Field Colony
Fardabad (Haryana)
Tel : 0129-4056009
customerservice@acrobatengeers.com

DRAWING TITLE: EXTERNAL SITE PLAN
EXTERNAL LIGHTING LAYOUT

DRG. NO. AEA/P-141/ESP/EL-01

DATE - 07-11-2017

SCALE - A1@1:425

DEALT - ANGREJ SINGH

CHECKED BY SHER SINGH

REV. NO

R0

1

1