


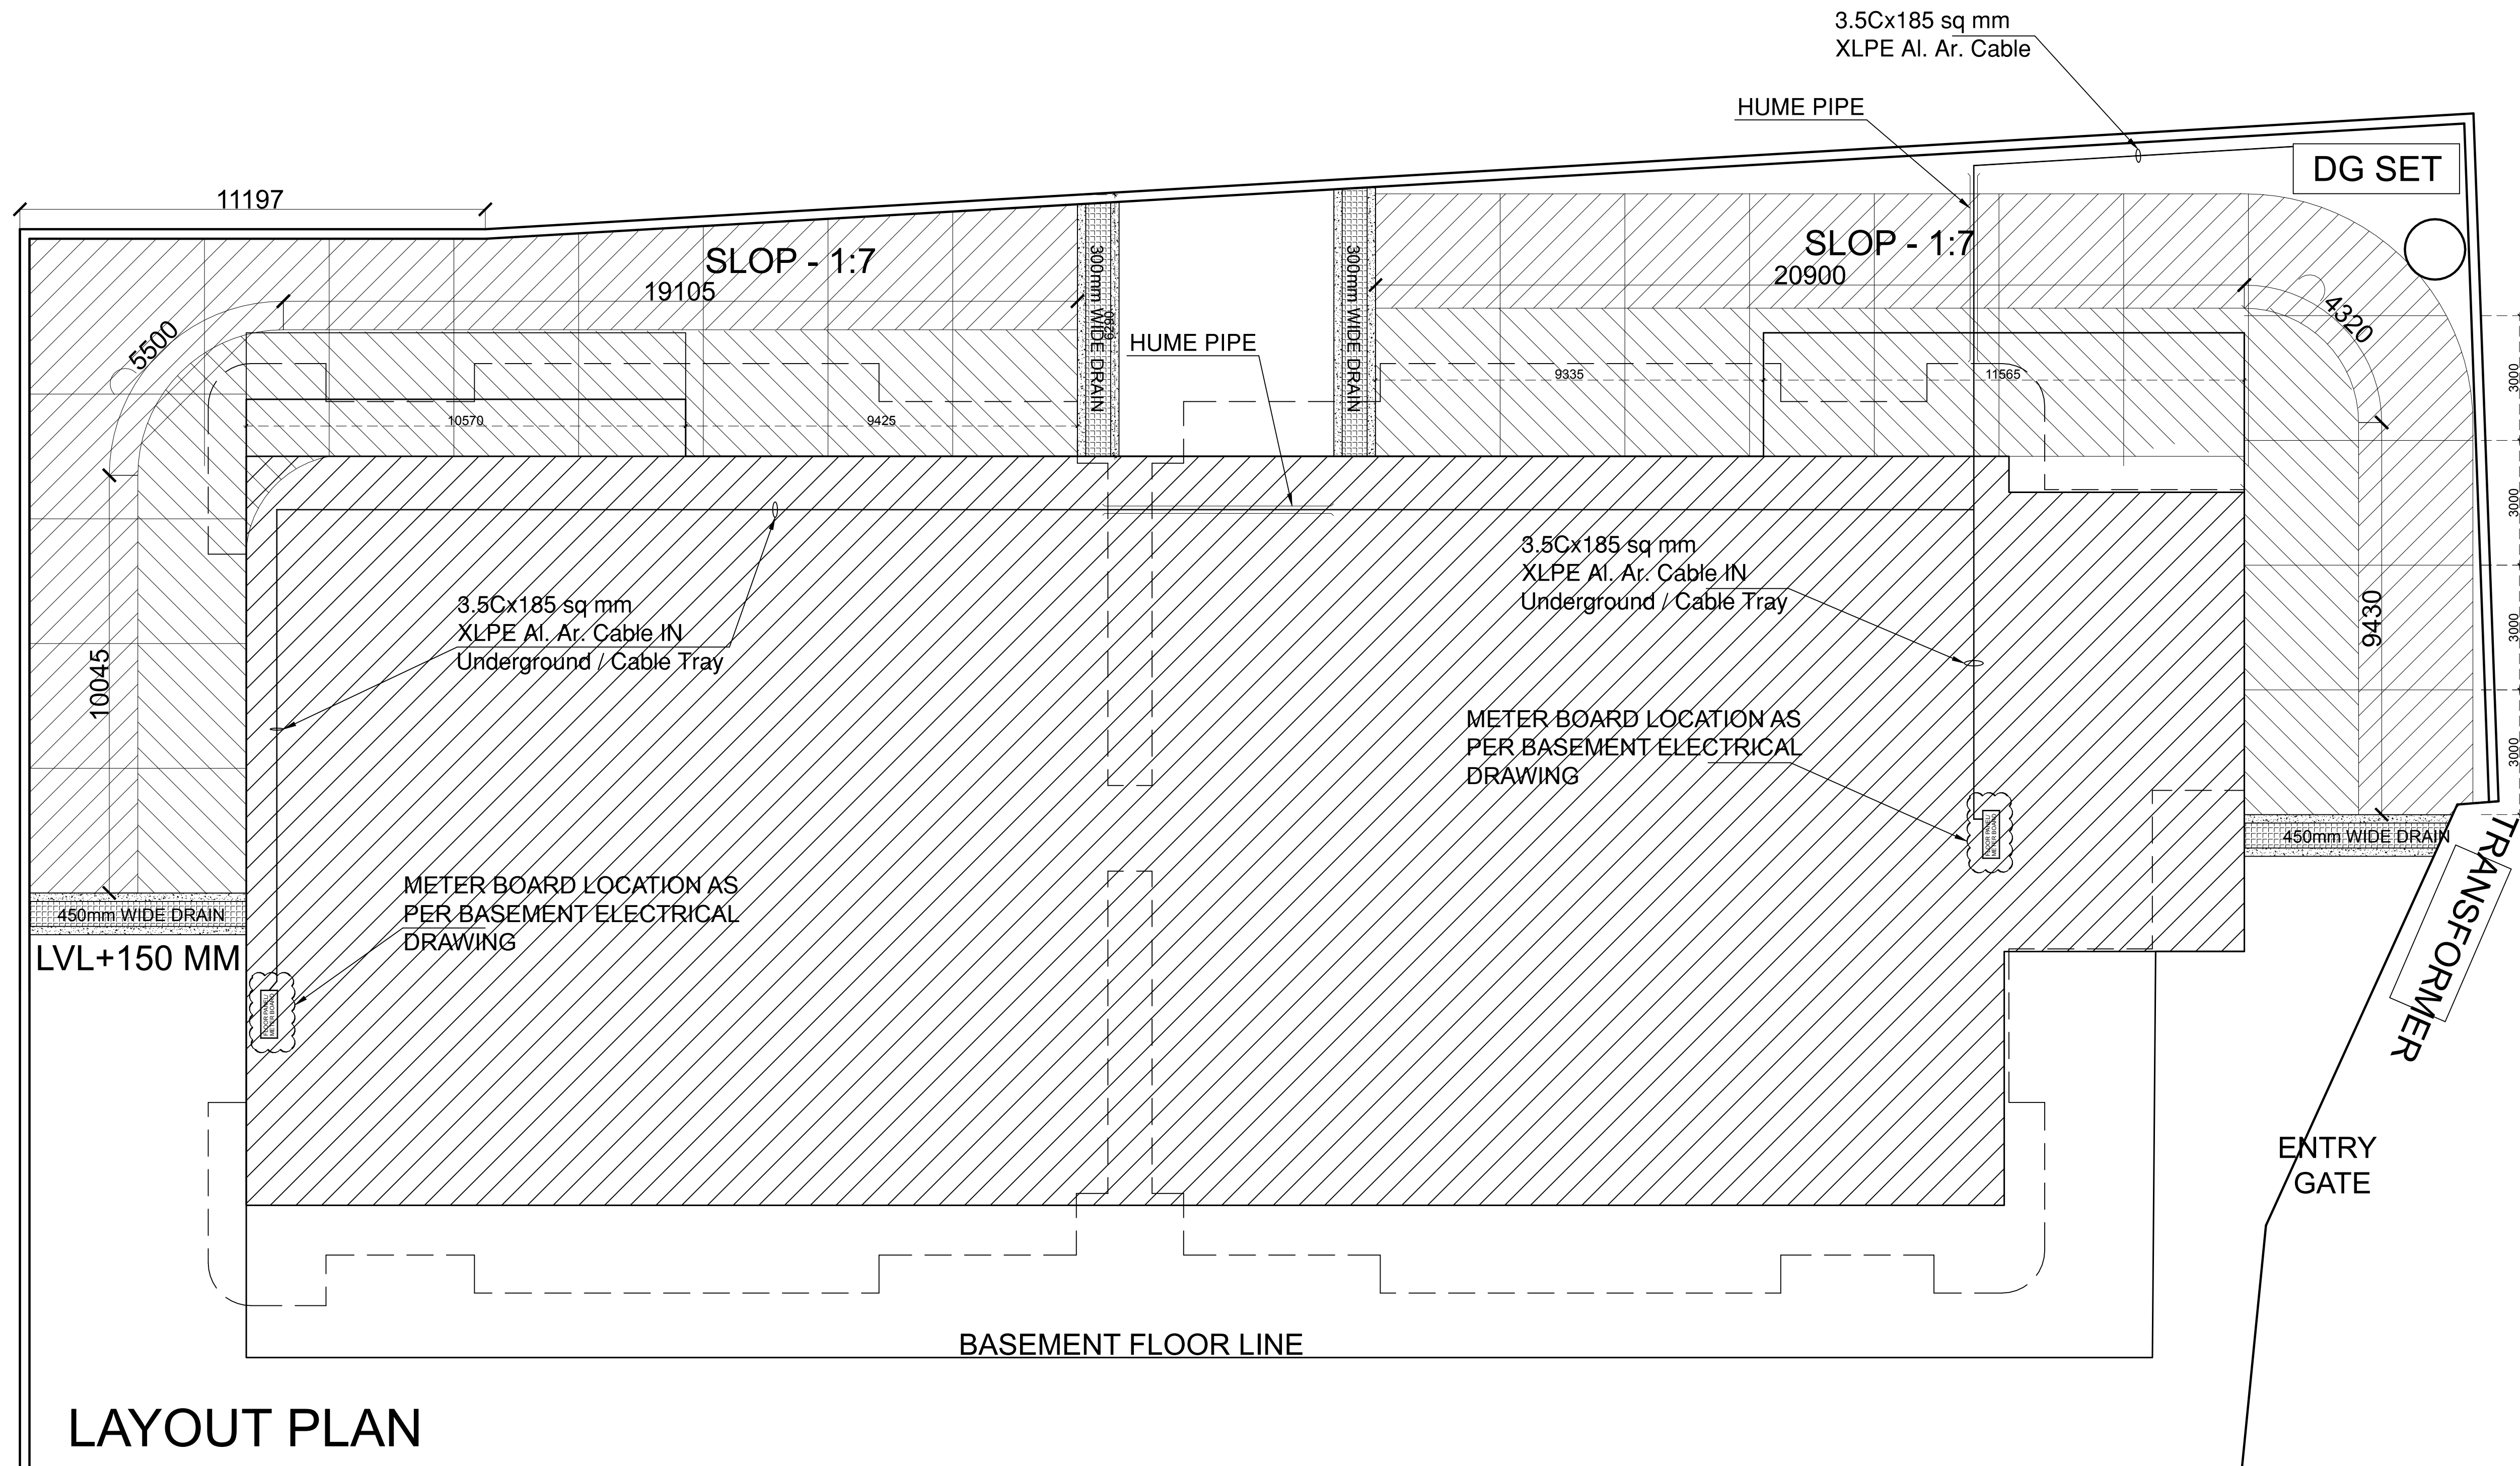

KEY PLAN

NOTES:

-	-	-
-	-	-
GFC	11.01.22	GOOD FOR CONSTRUCTION
AC	-	ADVANCE COPY
MARK	DATE	DESCRIPTION

MECHANICAL CONSULTANT-		
------------------------	--	--

ELECTRICAL CONSULTANT-

PLUMBING CONSULTANT-

STRUCTURE CONSULTANT-

ARCHITECTS-

PROJECT-
PROPOSED AKHILESH PLAZA

DRAWING TITLE-

SITE LAYOUT PLAN
ELECTRICAL LAYOUT

DRAWING PURPOSE-

WORKING DRAWING

JOB NO. - -----	DWG. REF. NO.- -	DATE- 11.01.22
SCALE- -----	REVISION- R0	DATE OF ISSUE- 11.01.22

DWG. NO.-	
-----------	--

	SHEET SIZE- A3	SHEET NO- 06
	DRAWN BY-	CHECKED BY-