


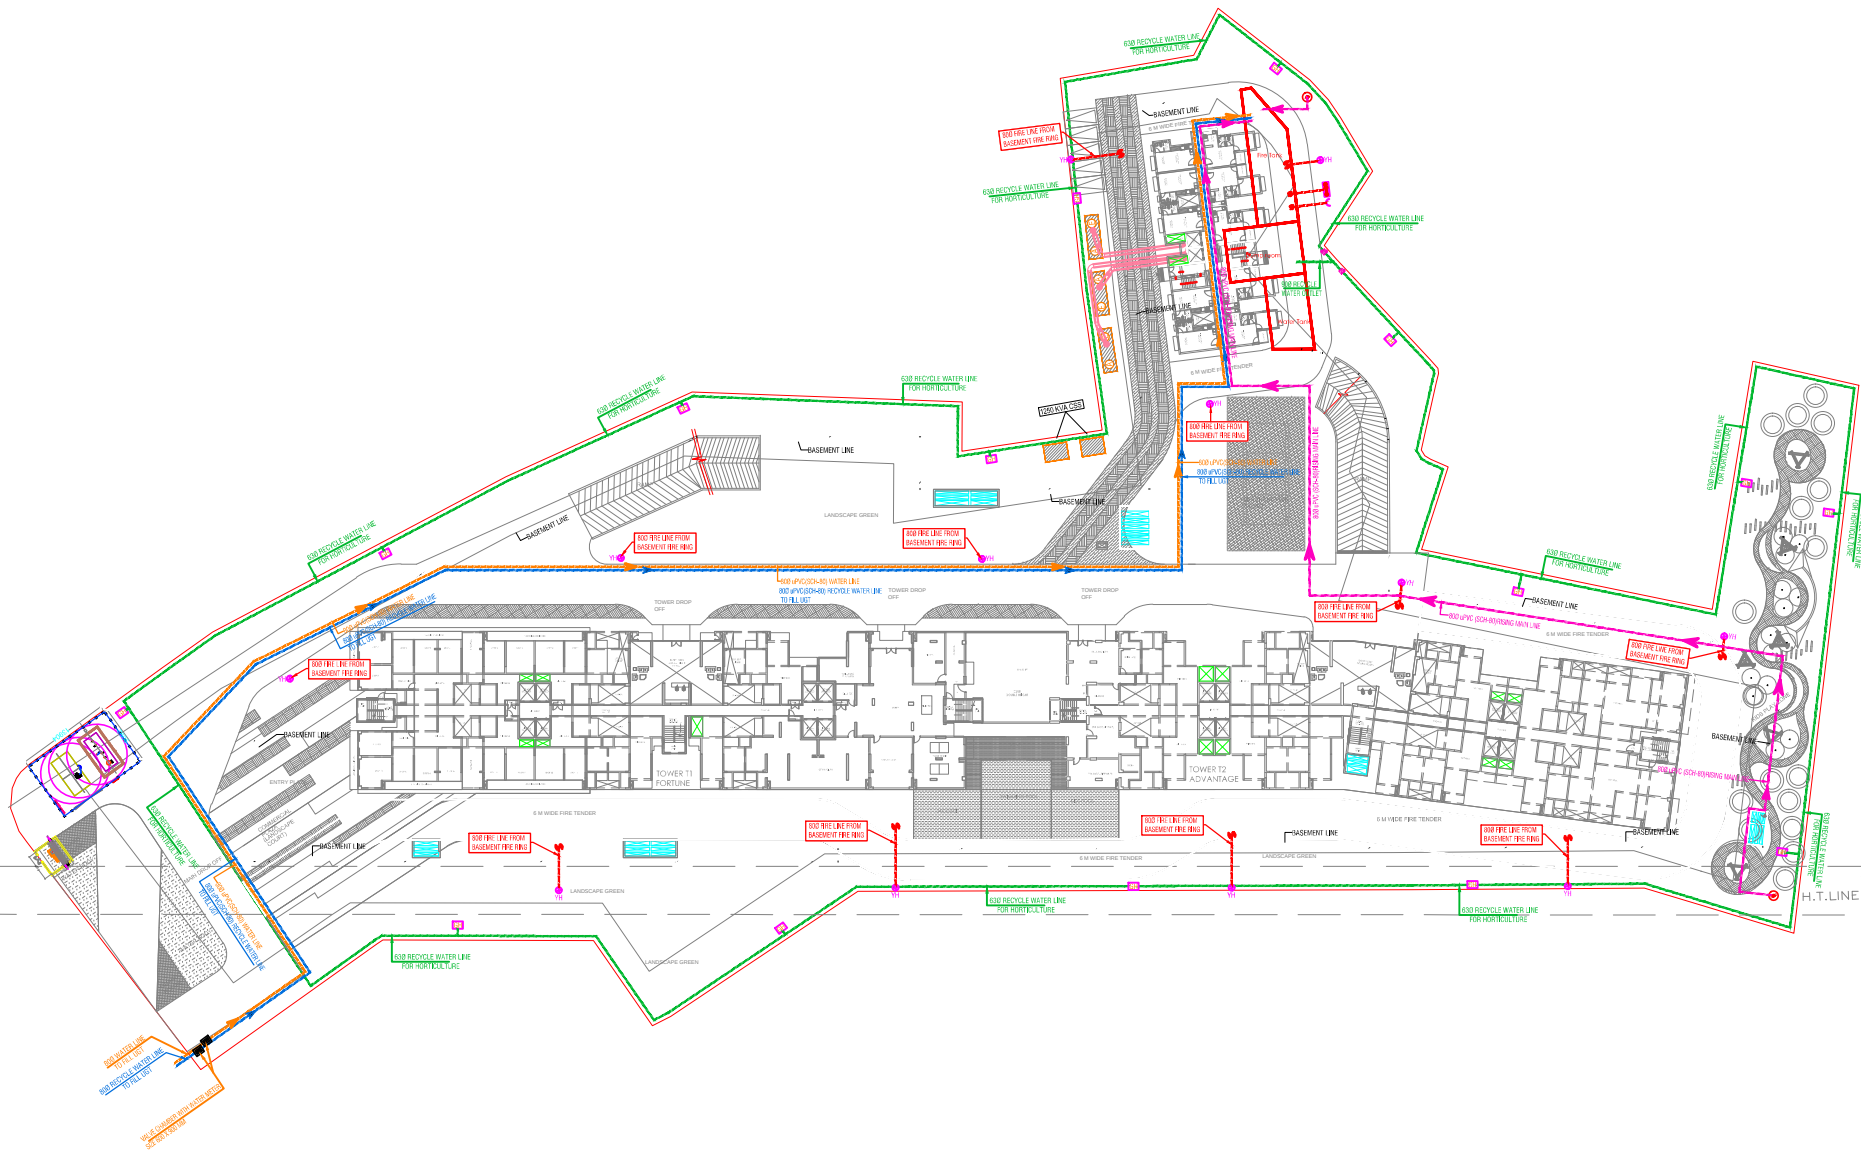

LEGEND :		
S. No.	SYMBOL	DESCRIPTION
1.		RECYCLED WATER SUPPLY PIPE LINE
2.		RECYCLED WATER SUPPLY PIPE LINE TO FILL LIST
3.		RIISING MAIN WATER PIPE LINE
4.		WATER SUPPLY PIPE LINE
5.		ISOLATING VALVE
6.		PROPOSED TUBE WELL
7.		BASEMENT LINE
8.		GARDEN HYDRANT

LEGEND : FIRE SYSTEM		
S. No.	SYMBOL	DESCRIPTION
1.		FIRE LINE
2.		YARD HYDRANT 63 MM. DIA. SINGLE HEADED HYDRANT VALVE WITH 2 NOS. 15 M. LONG, 63 M.M. DIA. FIRE HOSE PIPS & 1 NO. BRANCH PIPE WITH NOZZLE
3.		FIRE BRIGADE CONNECTION
4.		BUTTERFLY VALVE
5.		NONRETURN VALVE (CHECK VALVE)
6.		ISOLATING VALVE WITH MASONRY CHAMBER

Rev. no.	Date	Revision

Project
MAHAGUN MONTAGE
AT GH3 CROSSING REPUBLIK, NH24 GHAZIABAD U.P.

Title
SITE PLAN

Subtitle
EXTERNAL WATER SUPPLY SYSTEM

Drawing released for
☐ APPROVAL ☒ SUBMISSION
☐ ADVANCE COPY ☐ CONSTRUCTION

Drp. no. MONTAGE / EX / S-03 Drawn by Kulwant

Scale 1:420 Designed by R.K.

Date Sep. 2016 Checked by Anand Havella

Architects
HAFEZ CONTRACTOR

Services Consultant
Consummate Engineering Services (P) Ltd.

 Headquarters - B-67, Sector-67, Noida - 201 301
 Tel : (0120)6945300 / 23 Lines
 Fax : 0120-6945300
 e mail : mail@cespi.in, website : www.cespi.in