


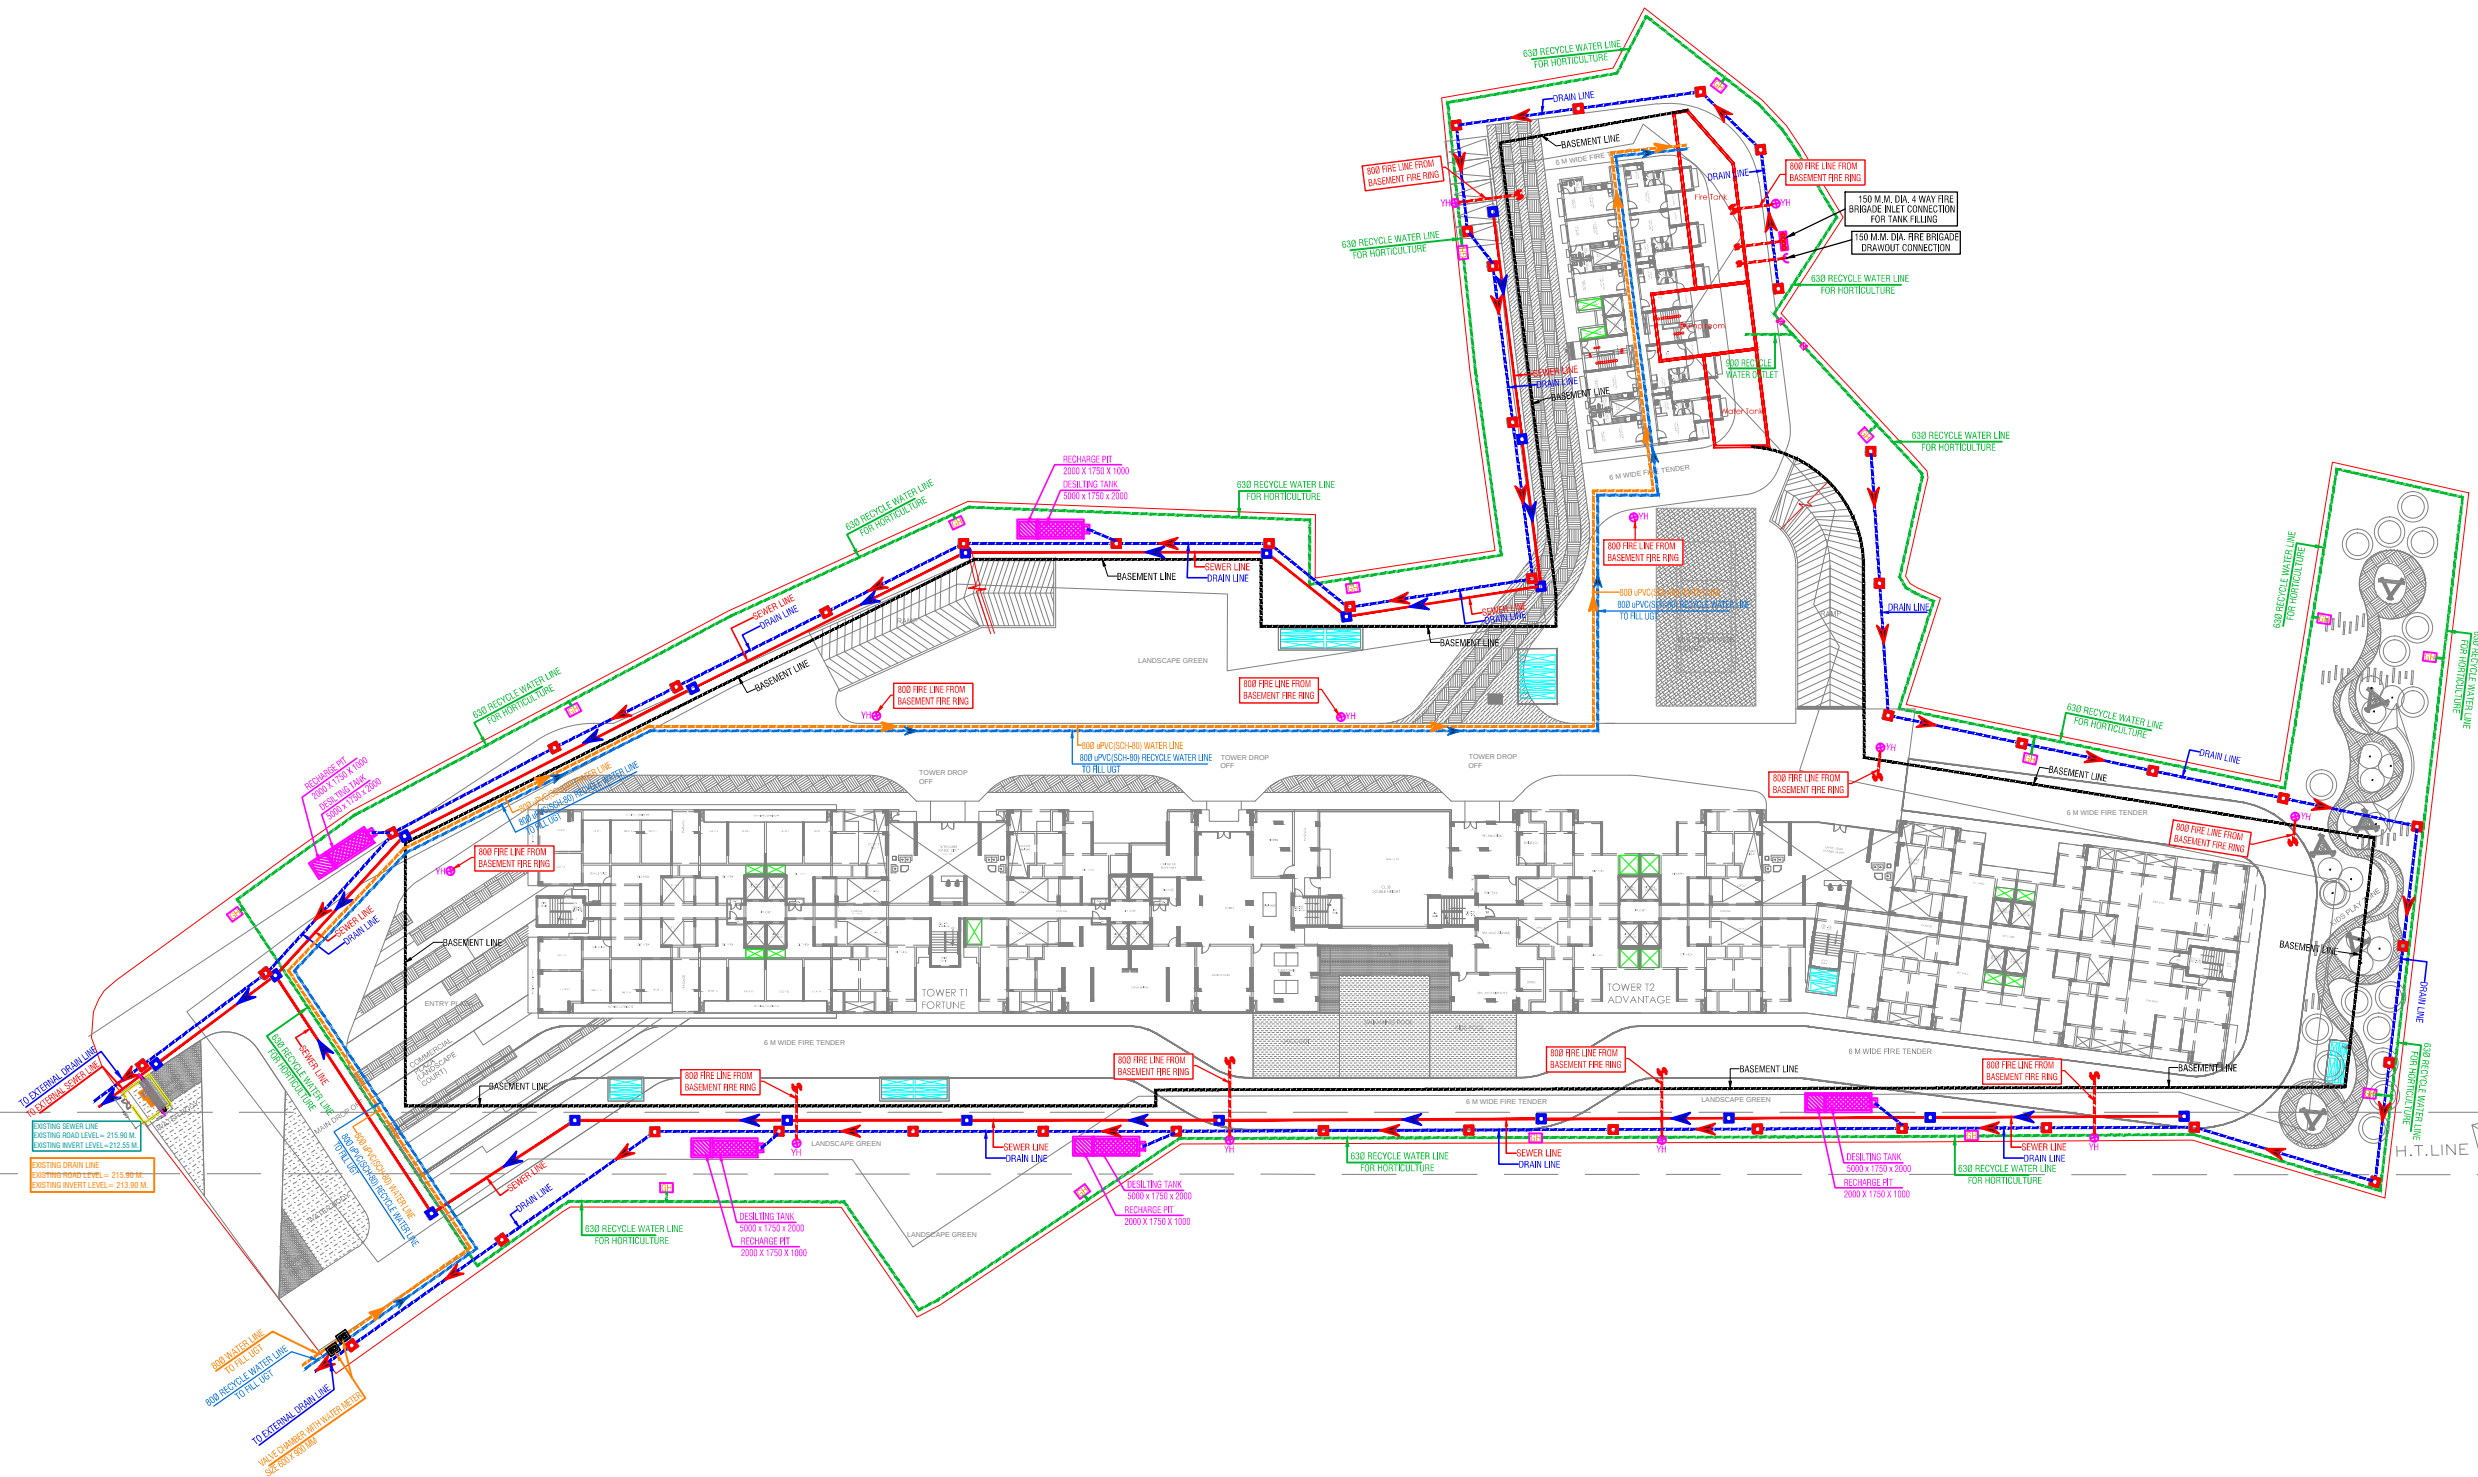

LEGEND :		
S. No.	SYMBOL	DESCRIPTION
1.	M.H.	MANHOLE
2.	SEWER LINE	SEWER LINE
3.	C.P.	CATCH PIT
4.	UNDER GROUND DRAIN	UNDER GROUND DRAIN
5.	RAIN WATER HARVESTING	RAIN WATER HARVESTING
6.	RECYCLED WATER SUPPLY PIPE LINE	RECYCLED WATER SUPPLY PIPE LINE
7.	RECYCLED WATER SUPPLY PIPE LINE TO FILL UST	RECYCLED WATER SUPPLY PIPE LINE TO FILL UST
8.	RISING MAIN WATER PIPE LINE	RISING MAIN WATER PIPE LINE
9.	WATER SUPPLY PIPE LINE	WATER SUPPLY PIPE LINE
10.	ISOLATING VALVE	ISOLATING VALVE
11.	PROPOSED TUBE WELL	PROPOSED TUBE WELL
12.	BASEMENT LINE	BASEMENT LINE
13.	GARDEN HYDRANT	GARDEN HYDRANT

LEGEND : FIRE SYSTEM		
S. No.	SYMBOL	DESCRIPTION
1.	FIRE LINE	FIRE LINE
2.	YH	YARD HYDRANT 63 M.M. DIA. SINGLE HEADED HYDRANT VALVE WITH 2 NOS. 15 M. LONG, 63 M.M. DIA. FIRE HOSE PIPE & 1 NO. BRANCH PIPE WITH NOZZLE
3.	FIRE BRIGADE CONNECTION	FIRE BRIGADE CONNECTION
4.	BUTTERFLY VALVE	BUTTERFLY VALVE
5.	NONRETURN VALVE (CHECK VALVE)	NONRETURN VALVE (CHECK VALVE)
6.	ISOLATING VALVE WITH MASONARY CHAMBER	ISOLATING VALVE WITH MASONARY CHAMBER

Rev. no.	Date	Revision
----------	------	----------

Project
MAHAGUN MONTAGE
AT GH3 CROSSING REPUBLIK, NH24 GHAZIABAD U.P.

Title
SITE PLAN (G.A.)

Subtitle
EXTERNAL COMBINED SERVICES

Drawing released for
☒ APPROVAL ☐ SUBMISSION
☐ ADVANCE COPY ☐ CONSTRUCTION

Drg. no. MONTAGE / EX / S-05 Drawn by Kulwant

Scale 1 : 420 Designed by R.K.

Date Sep. 2016 Checked by Anand Havelia

Architects
HAFEZ CONTRACTOR

Services Consultant
Consummate Engineering Services (P) Ltd.
Noida Office : B - 67, Sector - 67, Noida - 201 301
Tel : (0120) 6943300 (23 Lines)
Lko. Office : R 006, Rontas Plumeria, Gomti Nagar, Lucknow
e mail : mail@cespln.in, website : www.cespln.in