

**LEGEND:-PLUMBING**


SYMBOL	DESCRIPTION
	SEWER PIPE
	STORM PIPE
	MUNICIPAL WATER INLET LINE
	IRRIGATION WATER SUPPLY
	GARDEN HYDRANT
	STORM MANHOLE
	SEWER MANHOLE
	CATCH BASIN
	RAIN WATER HARVESTING PIT
	EXTERNAL FIRE HYDRANT

**LEGEND:-PLUMBING**

SYMBOL	DESCRIPTION
	DOMESTIC WATER SUPPLY
	FLUSHING WATER SUPPLY
	RAIN WATER PIPE
	SOIL PIPE

LEGEND:-

SYMBOL	DESCRIPTION
	84W LED STREET LIGHT POLE (HEIGHT OF 7Mtrs.)
	FEEDER PILLER PANEL
	PLATE EARTH PIT G.I.
	PLATE EARTH PIT Cu.

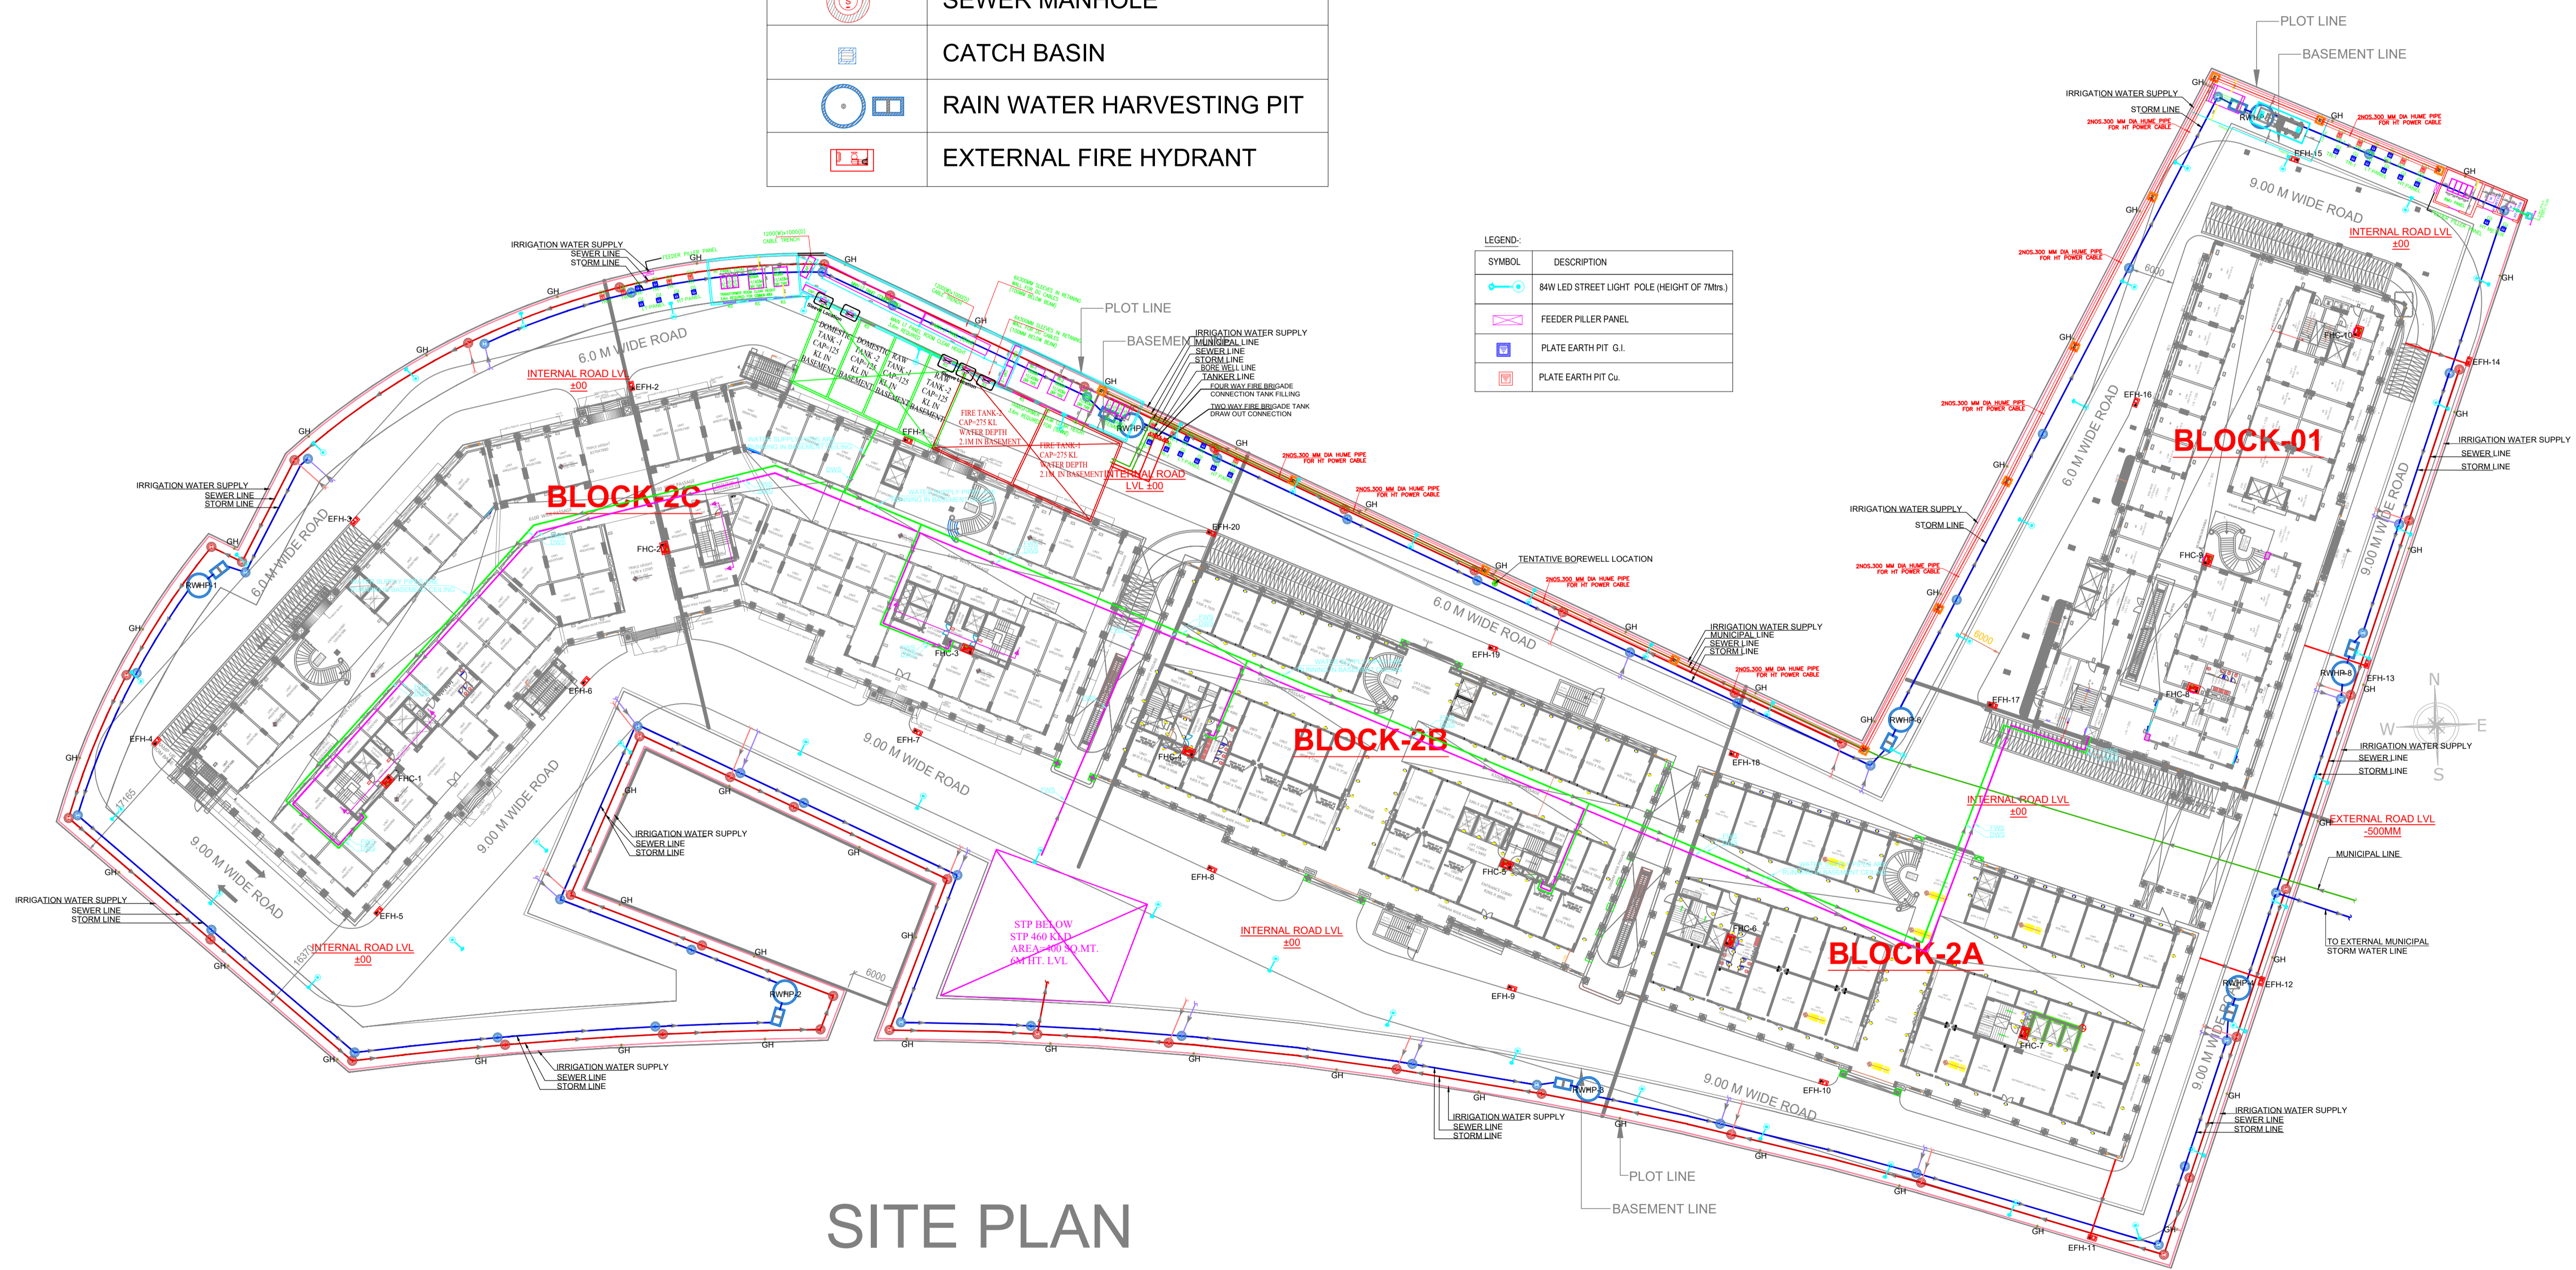

**SITE PLAN**

CLIENT: **OMAXE**  
Turning dreams into reality

ARCHITECTURAL CONSULTANT: **SPECTRUM DESIGN GROUP**  
CONSULTING ENGINEERS: **clancy global**  
CONSULTING ENGINEERS

MEP CONSULTANT & ADDRESS: **clancy global**  
CONSULTING ENGINEERS  
Unit 50, 118, 119, 120, 999, 1000

PROJECT: **COMMERCIAL AT LUCKNOW.**

DRAWING TITLE: **MEP LAYOUT AT SITE PLAN**

DRAWING NO. **OMX-COM-DD-AR-100**

DRAWN BY: HAK      CHKD. BY: SHH  
SCALE: 1:350@A0      DATE: 17.07.2024