


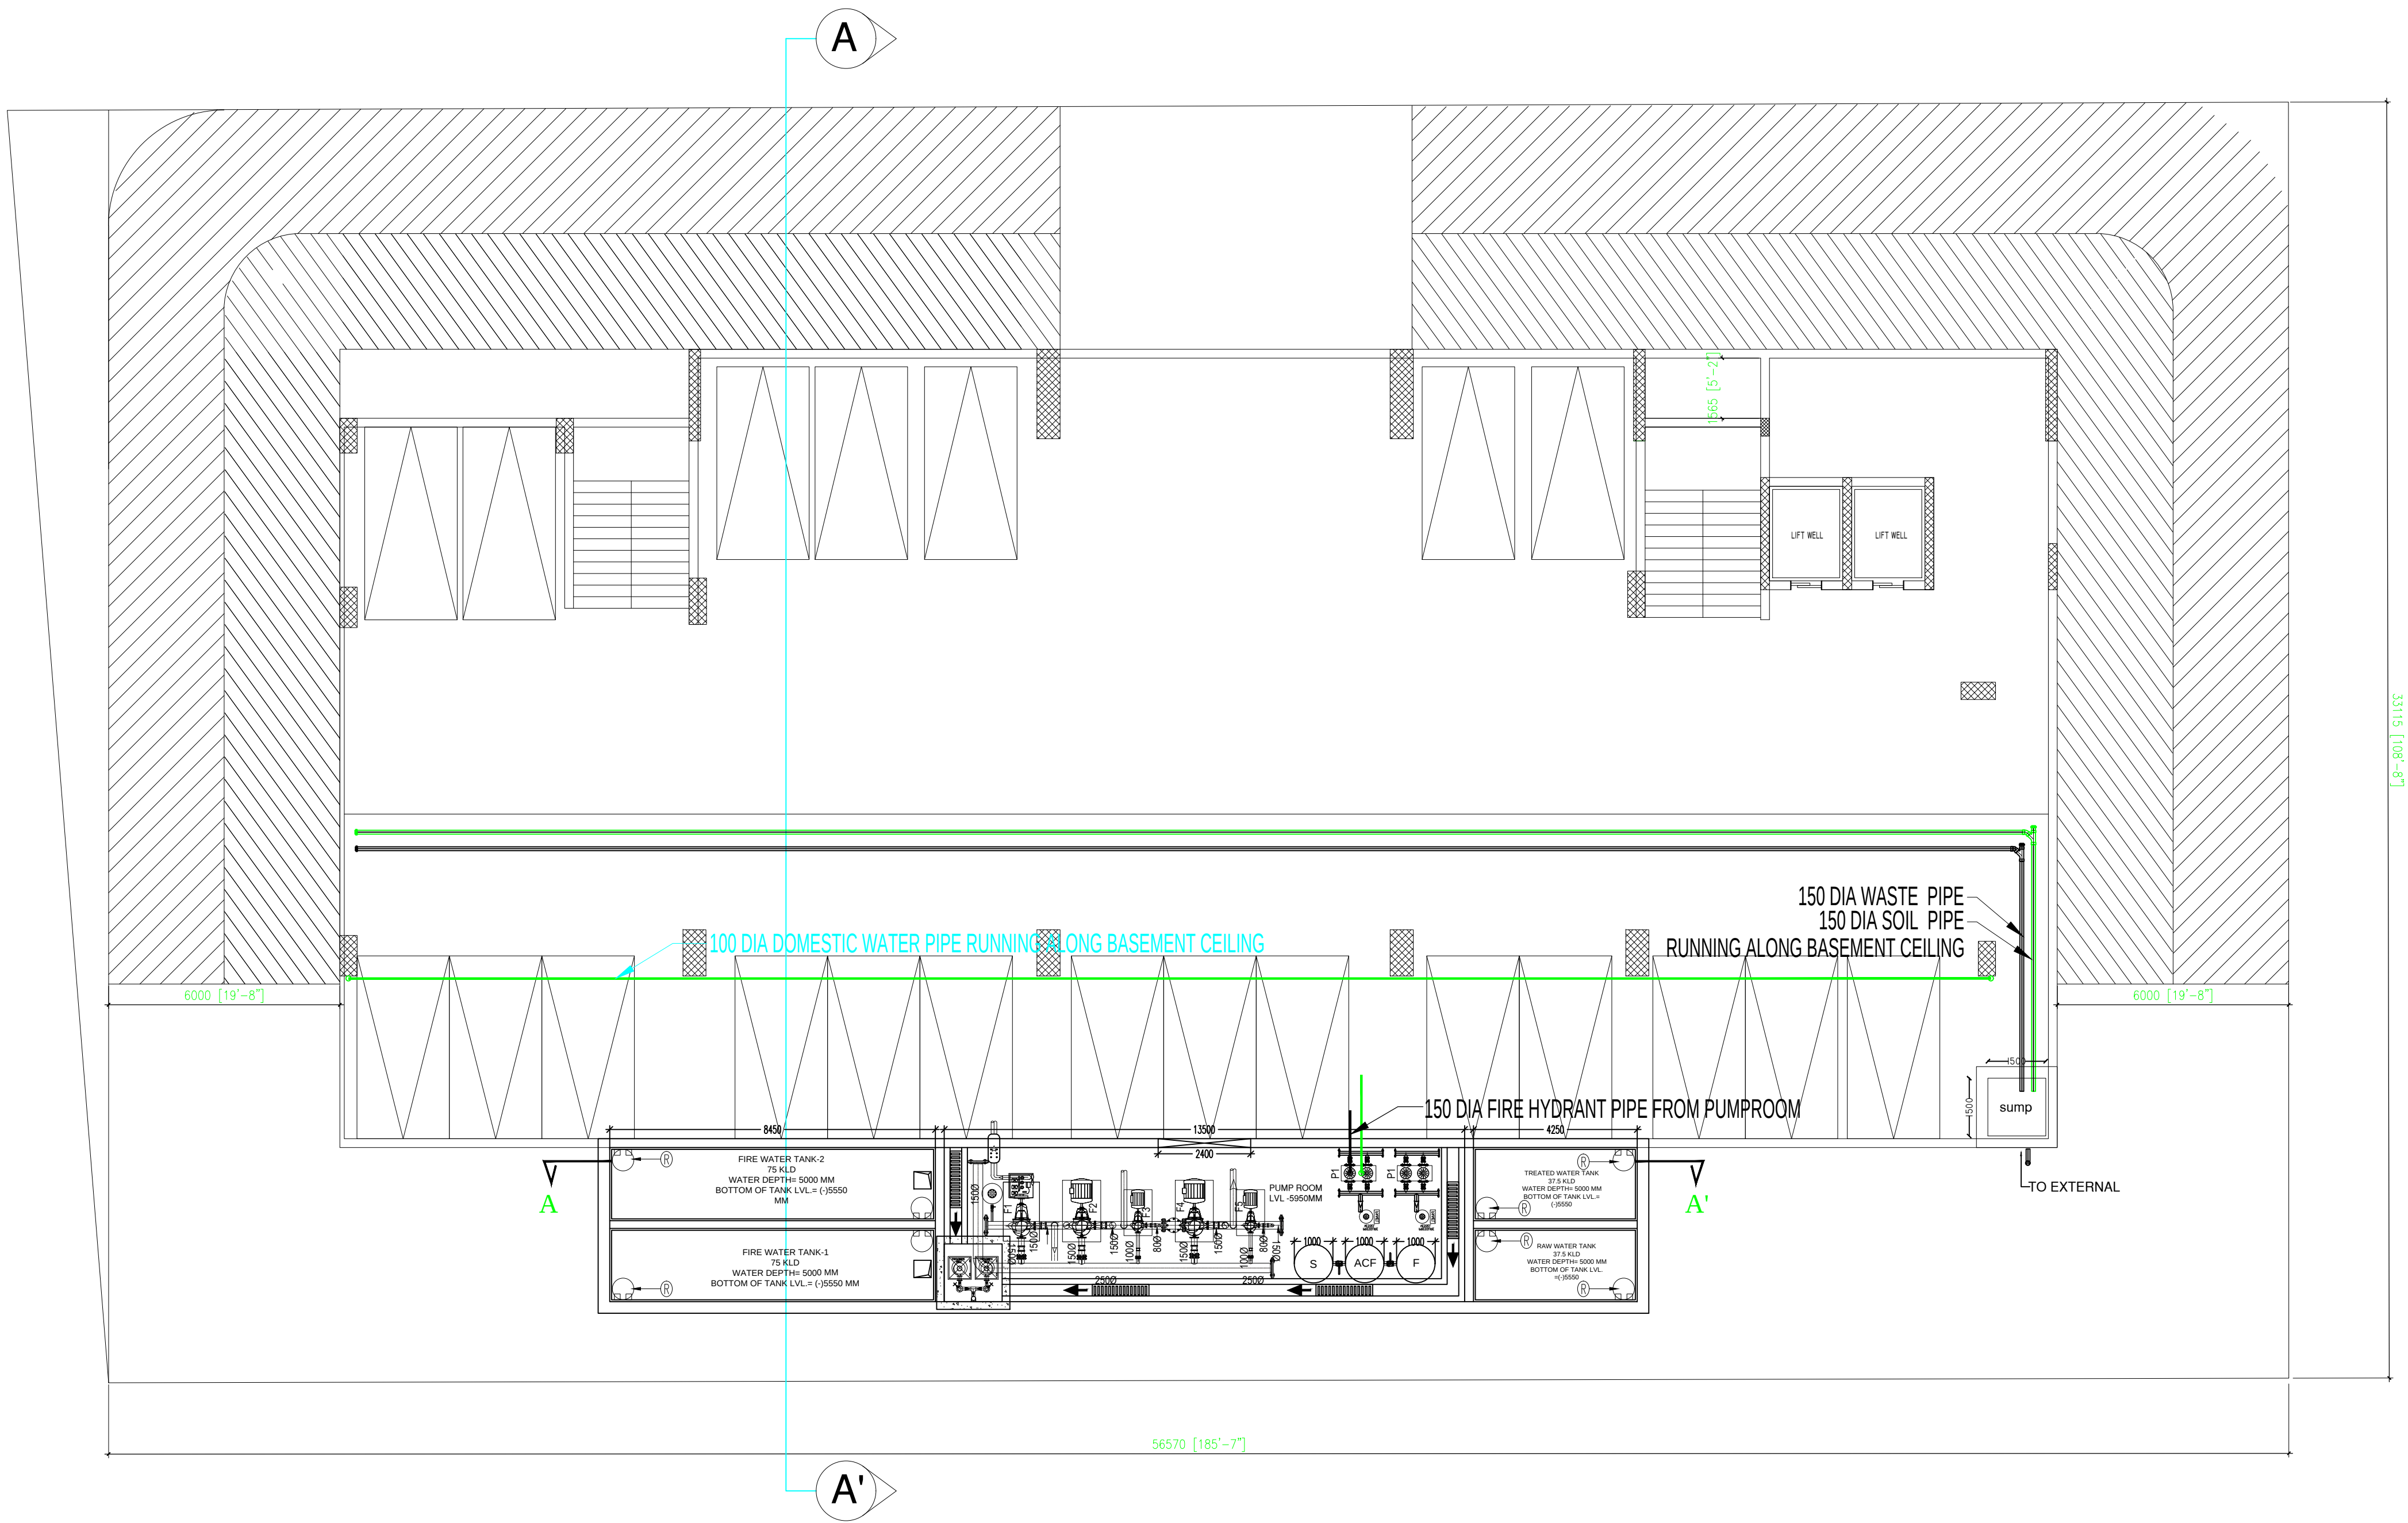

BASEMENT FLOOR PLAN

S.NO.	LEGEND:-	
1.	FIRE HYDRANT PIPE	
2.	DOMESTIC WATER SUPPLY PIPE	

PROJECT -

OWNER -

DRAWING TITLE :-
BASEMENT PLUMBING & WATER
SUPPLY LAYOUT PLAN

OWNER SIGN ARCHITECT SIGN

ARCHITECTS & PLANNERS:
SINGLA ARCHITECTS & ASSOCIATES
EROS MARKET PLACE, PLOT NO- 02, SHOP - 87, 1ST. FLOOR
SHAKTI KHAND - 2, INDIRAPURAM, GHAZIABAD (U.P.)
Mob: 9971998445
e-mail : gsingla32@gmail.com,

MEP Consultant:
 **WeDESIGN Associates**
"Engineered to perfection"
Email - wedesignassociates@gmail.com
Mob: - 9999288416, 9999288407, 9882244495

DEALT BY:- VIBHOR	CHECKED BY:- DK	SCALE:- NTS.	DATE:- 26.09.2024	DRG. No:- PL-BF-01
----------------------	--------------------	-----------------	----------------------	-----------------------