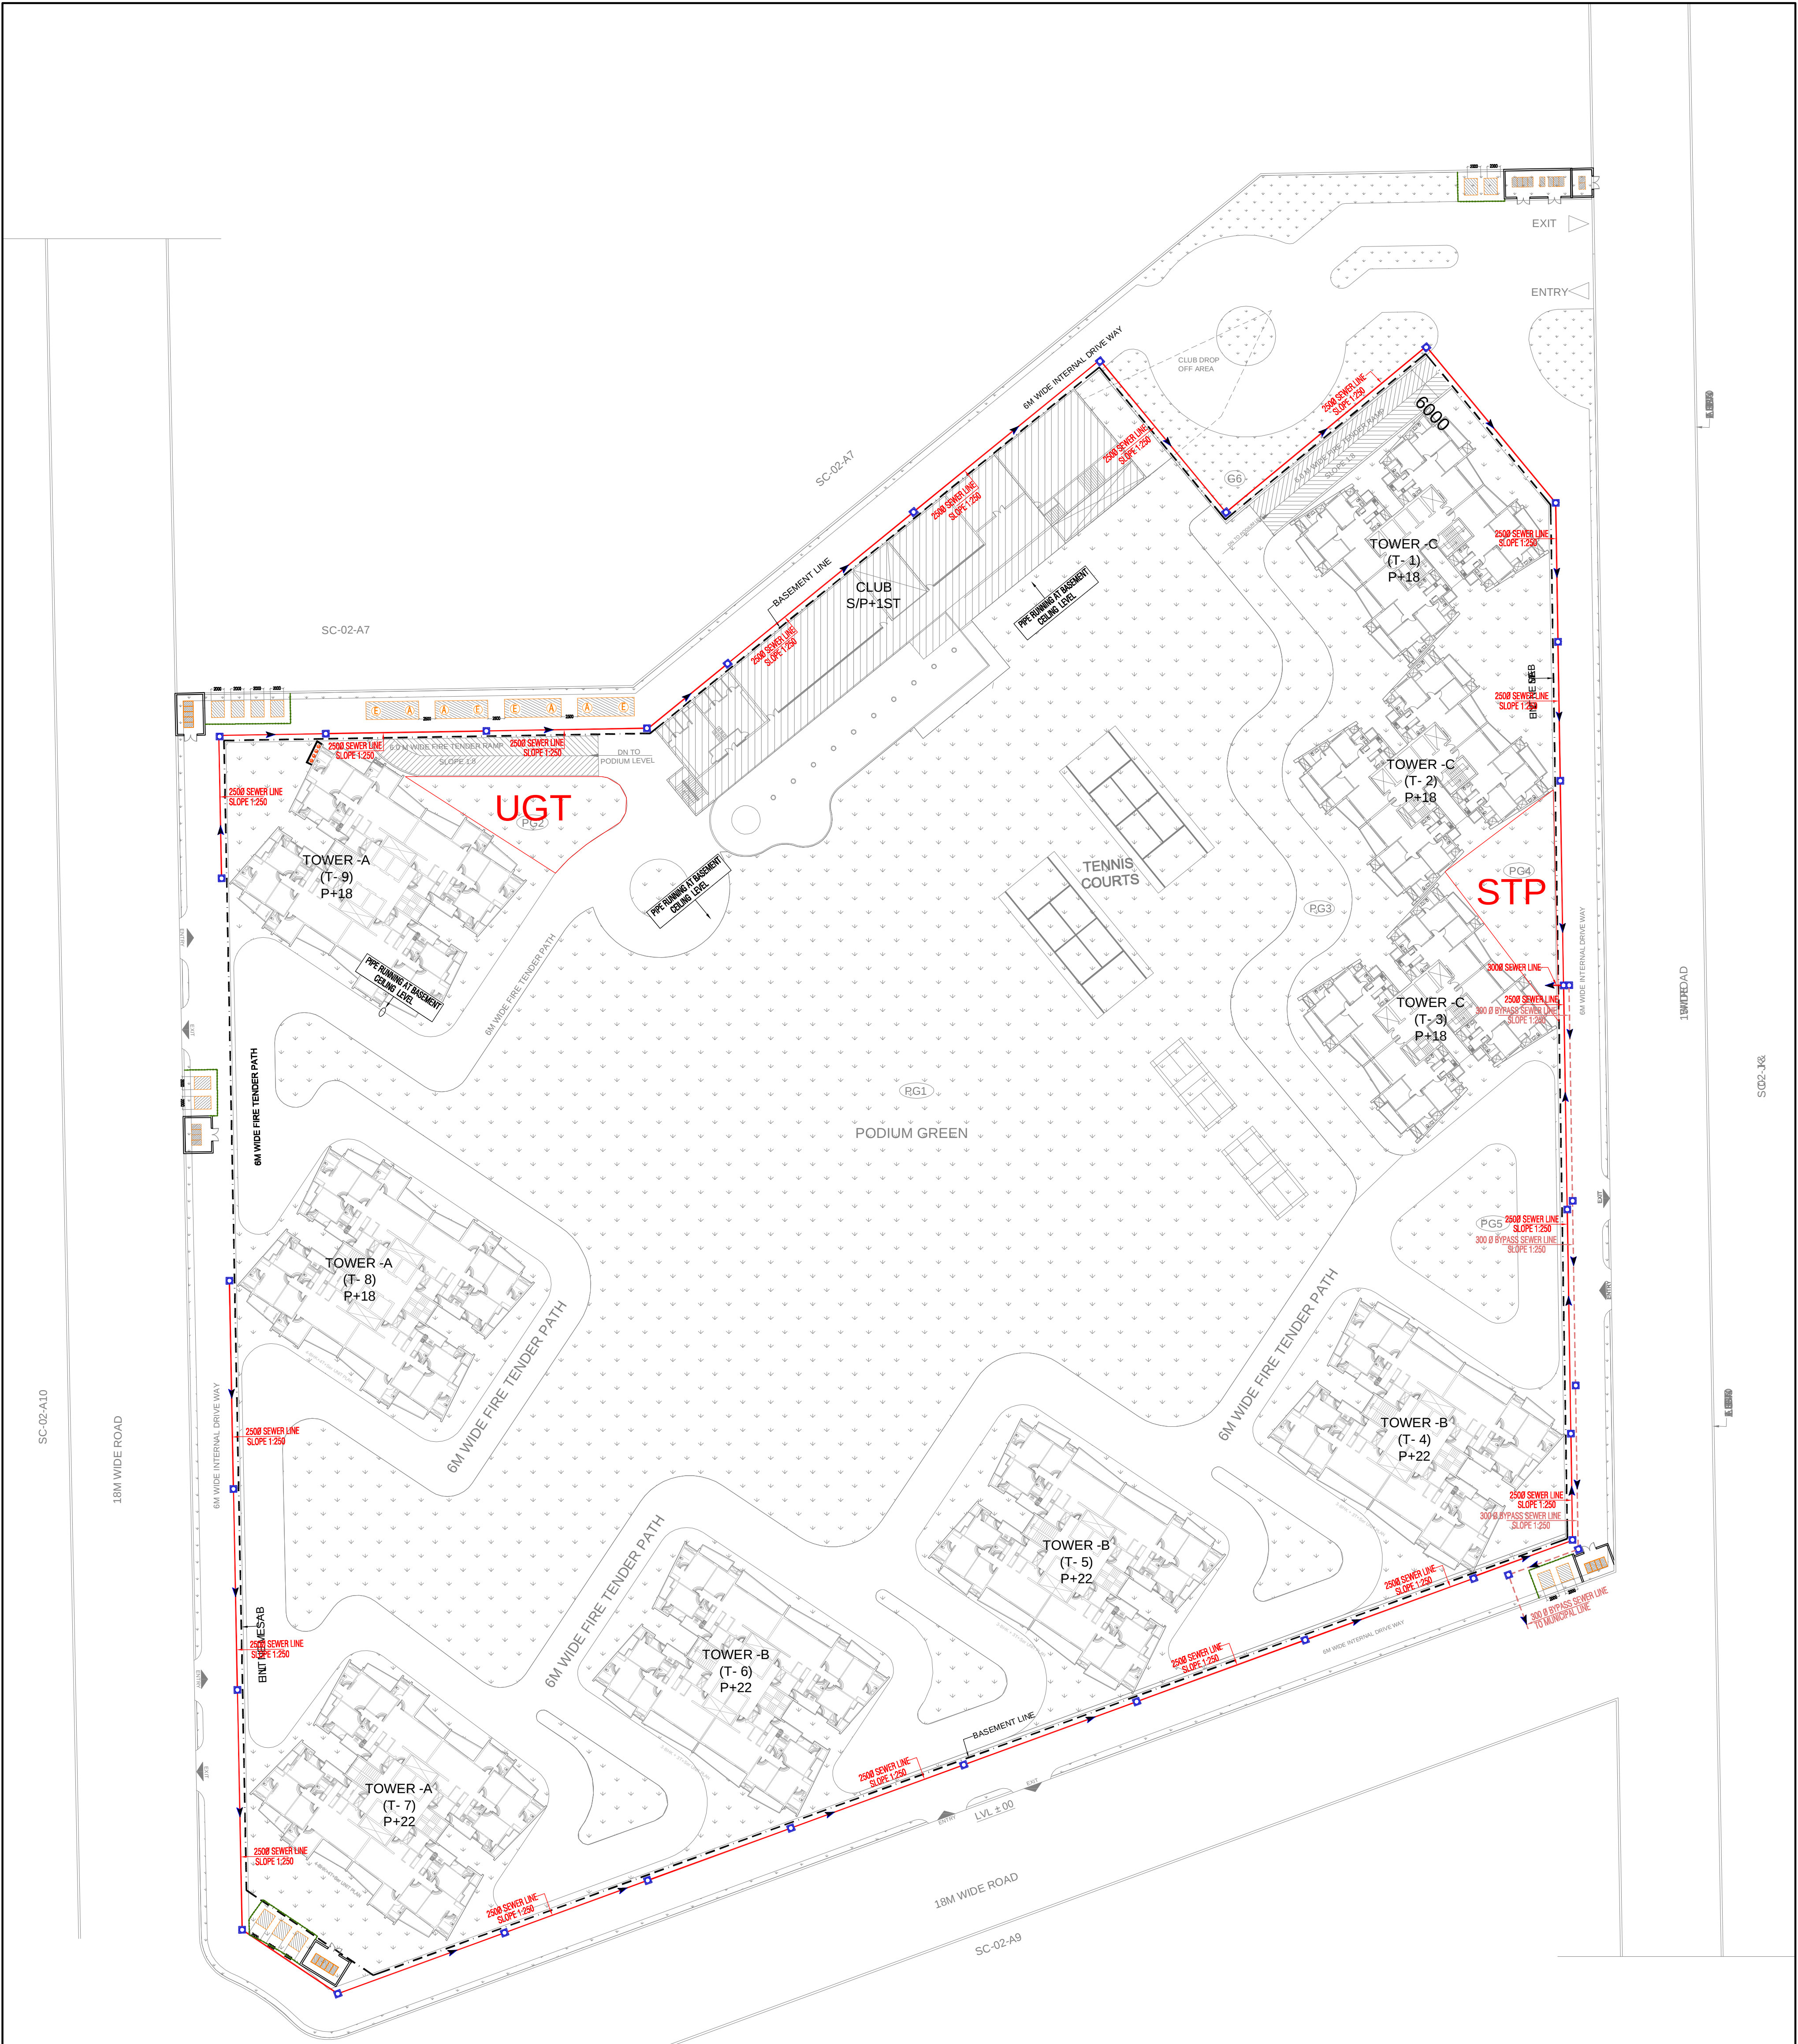


LEGEND :		
S. No.	SYMBOL	DESCRIPTION
1.	M.H.	MANHOLE
2.		SEWER LINE
3.		BYPASS MANHOLE
4.		BYPASS SEWER LINE
5.	C.P.	CATCH PIT
6.		BASEMENT LINE

Project
OPULENCE
PROPOSED PLAN FOR SPORTS CITY AT LAND PARCEL SC-02/A8,
SECTOR- 150, NOIDA FOR - M/S WISH LAND BUILDZONS PVT. LTD.

Title
SITE PLAN
Subtitle
EXTERNAL SEWERAGE SYSTEM

Drawing released for
☐ APPROVAL
☐ ADVANCE COPY
☒ SUBMISSION
☐ CONSTRUCTION

Drg. no.
OPULENCE / EX / S-01
Scale
1 : 500
Date
Jan. 2019

Drawn by
Kulwant
Designed by
R.K.
Checked by
Anand Havella

Architects
Architect Hafeez Contractor

Services Consultant
Consummate Engineering Services (P) Ltd.
Noida Office : B - 67, Sector - 67, Noida - 201 301
Tel : (0120) 6943500 (23 Lines)
Lko. Office : R 006, Rohas Plumeria, Gomti Nagar, Lucknow
Tel : (0522) 4025902
e mail : mail@cespl.in, website : www.cespl.in