
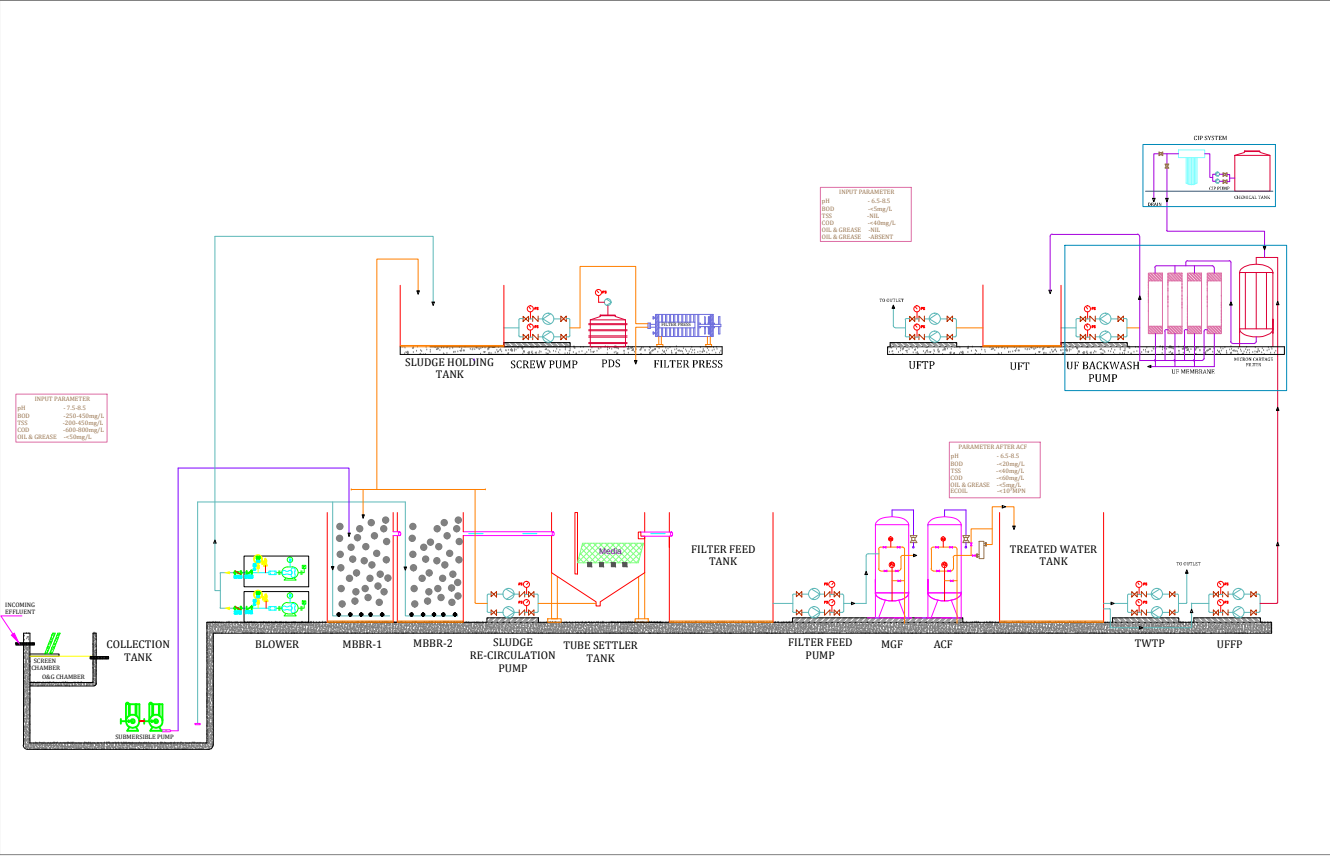
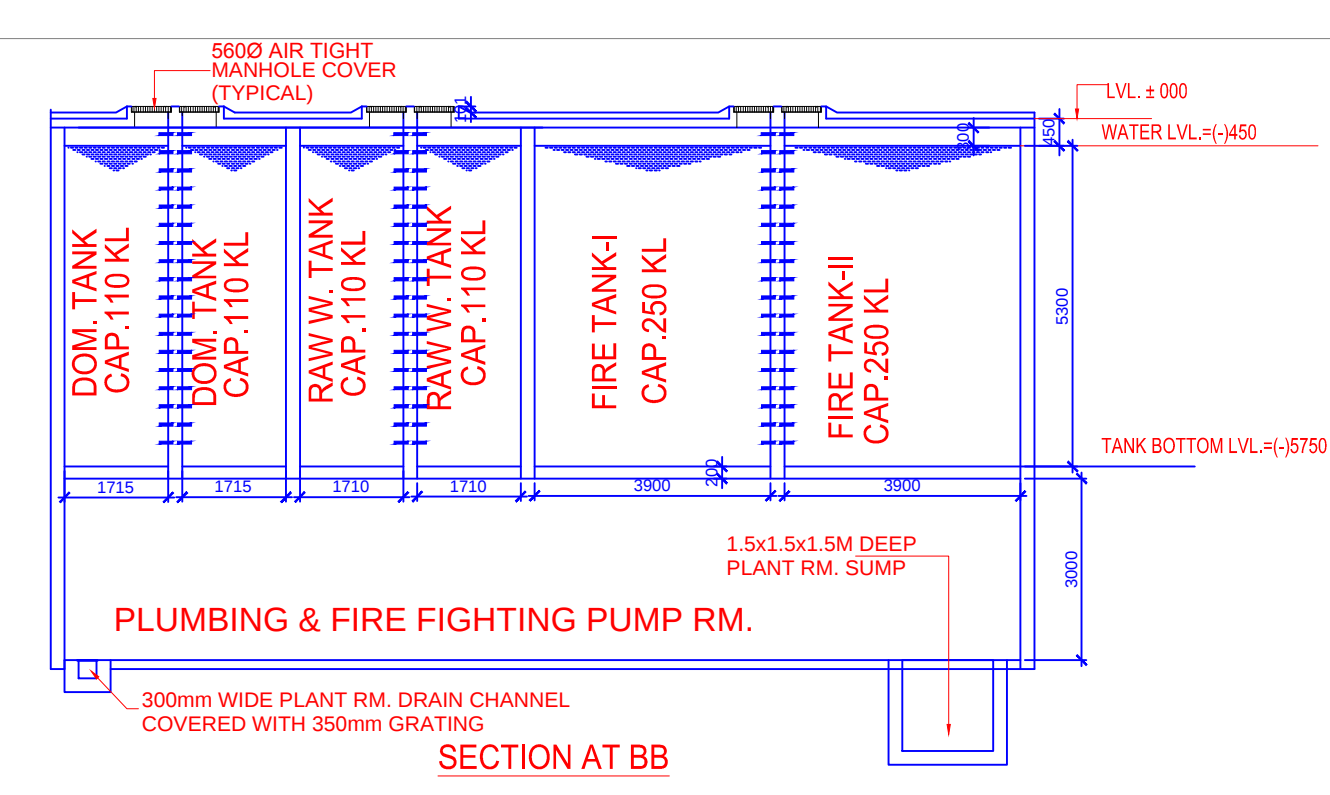
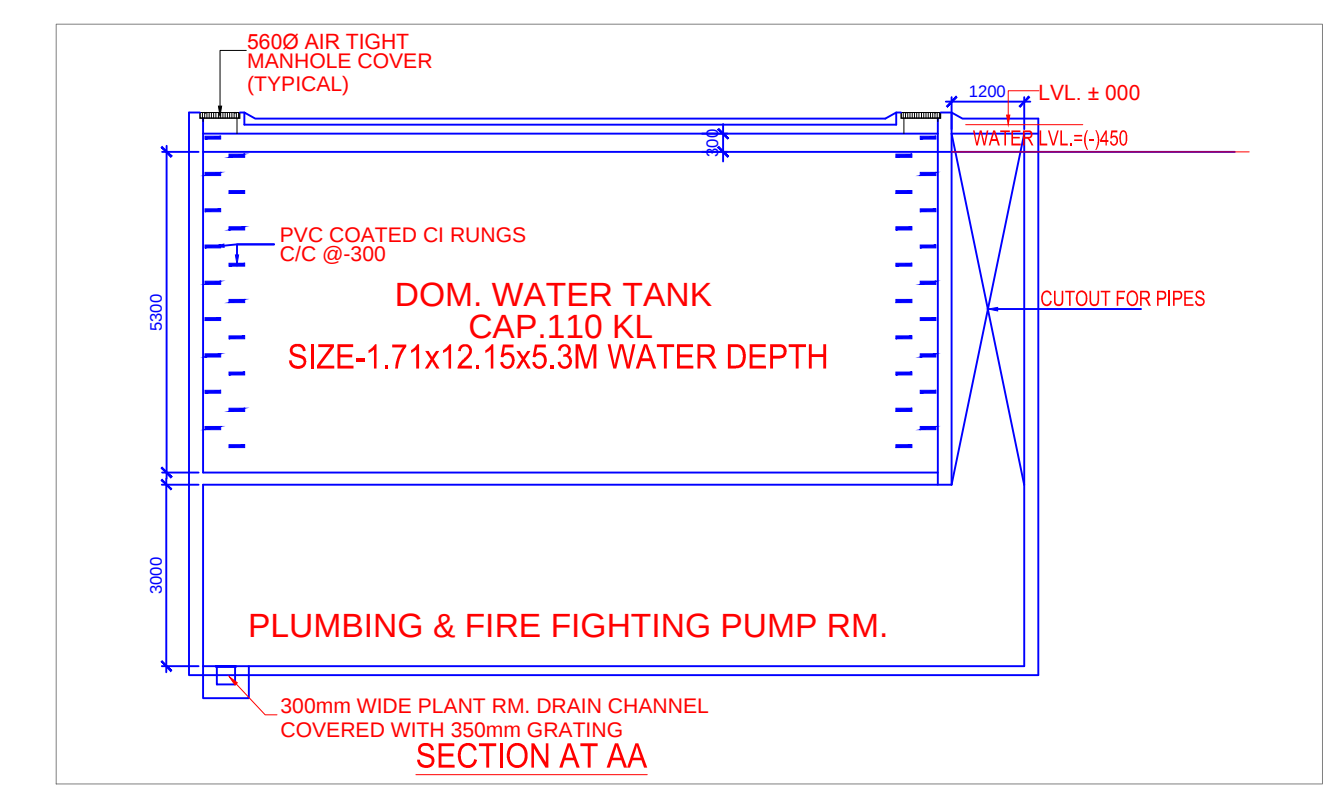
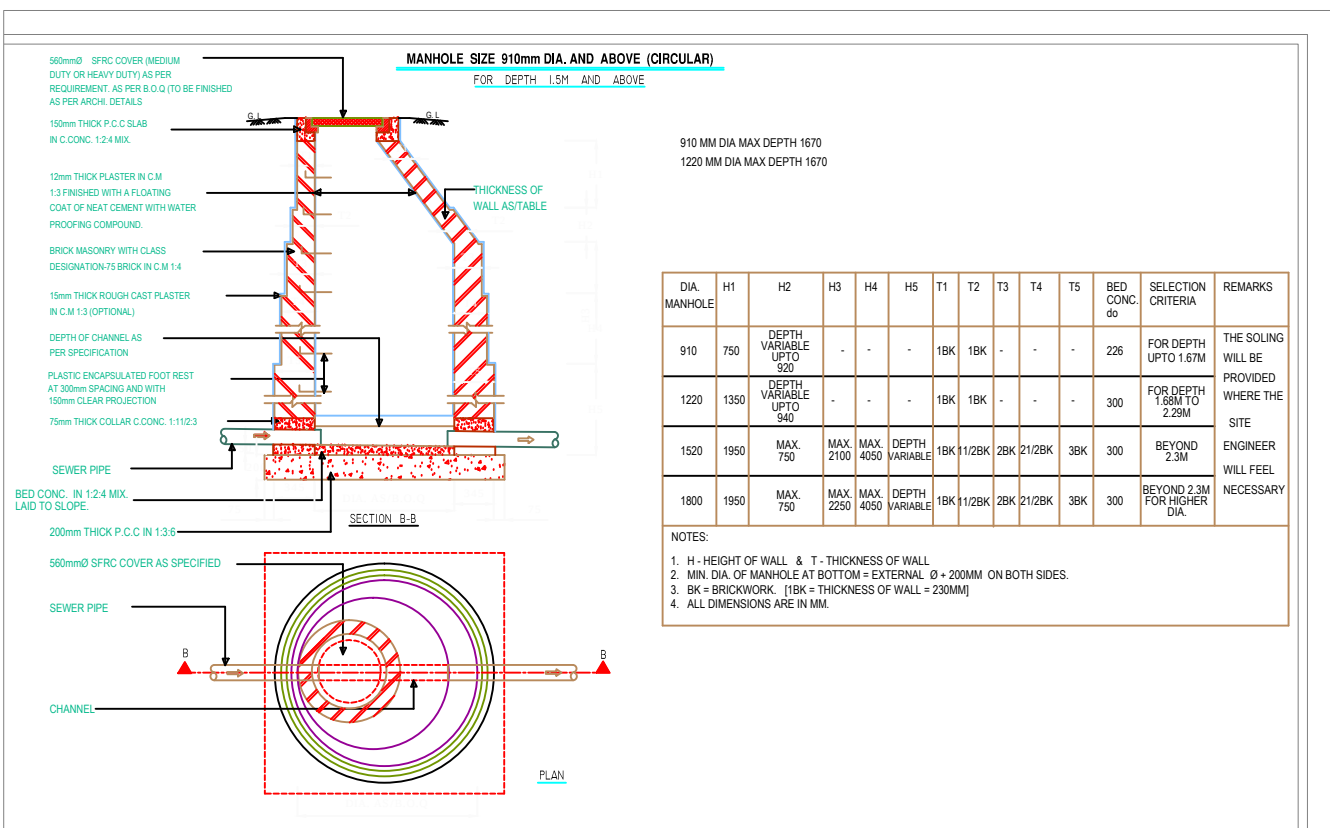
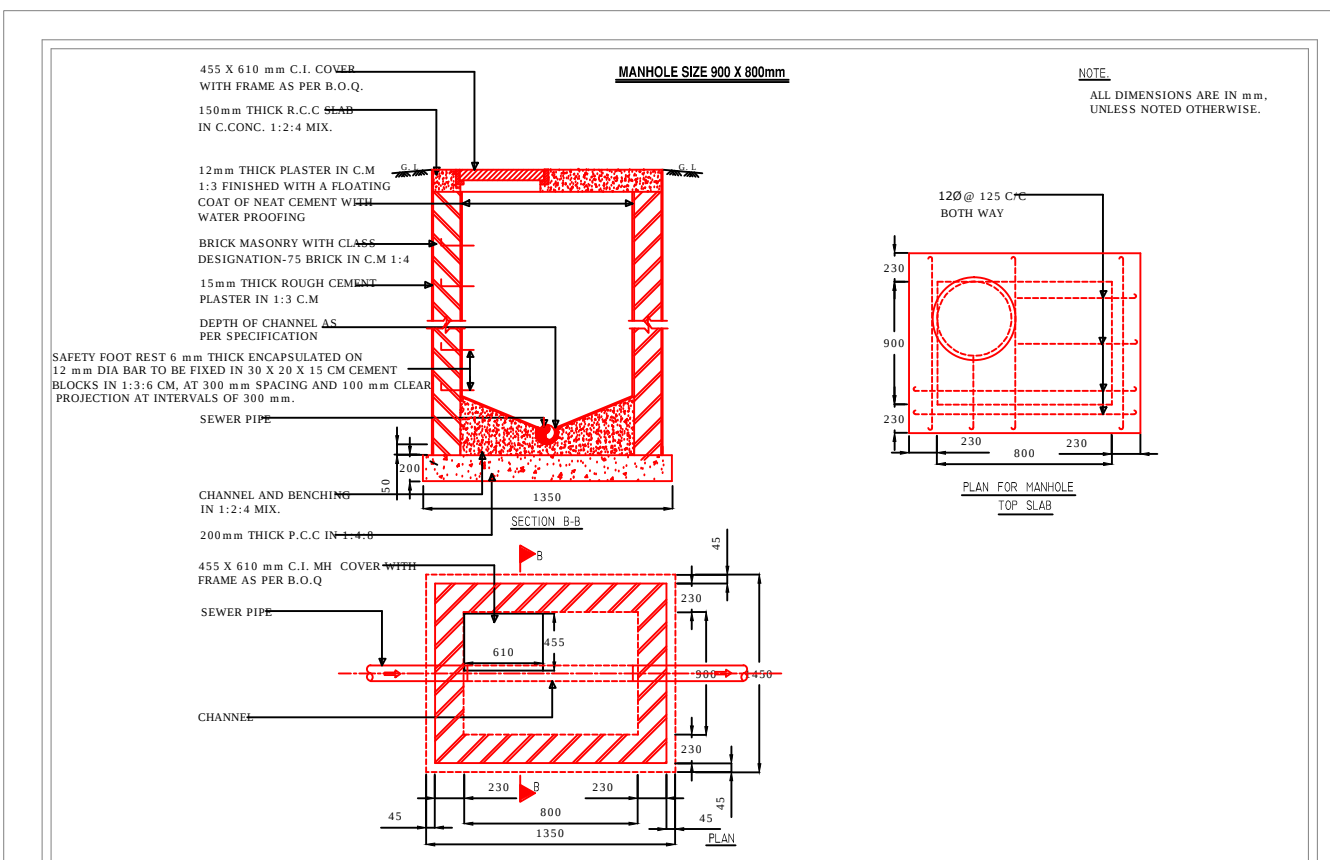


45.0 M. WIDE


PEDESTRIAN ENTRY

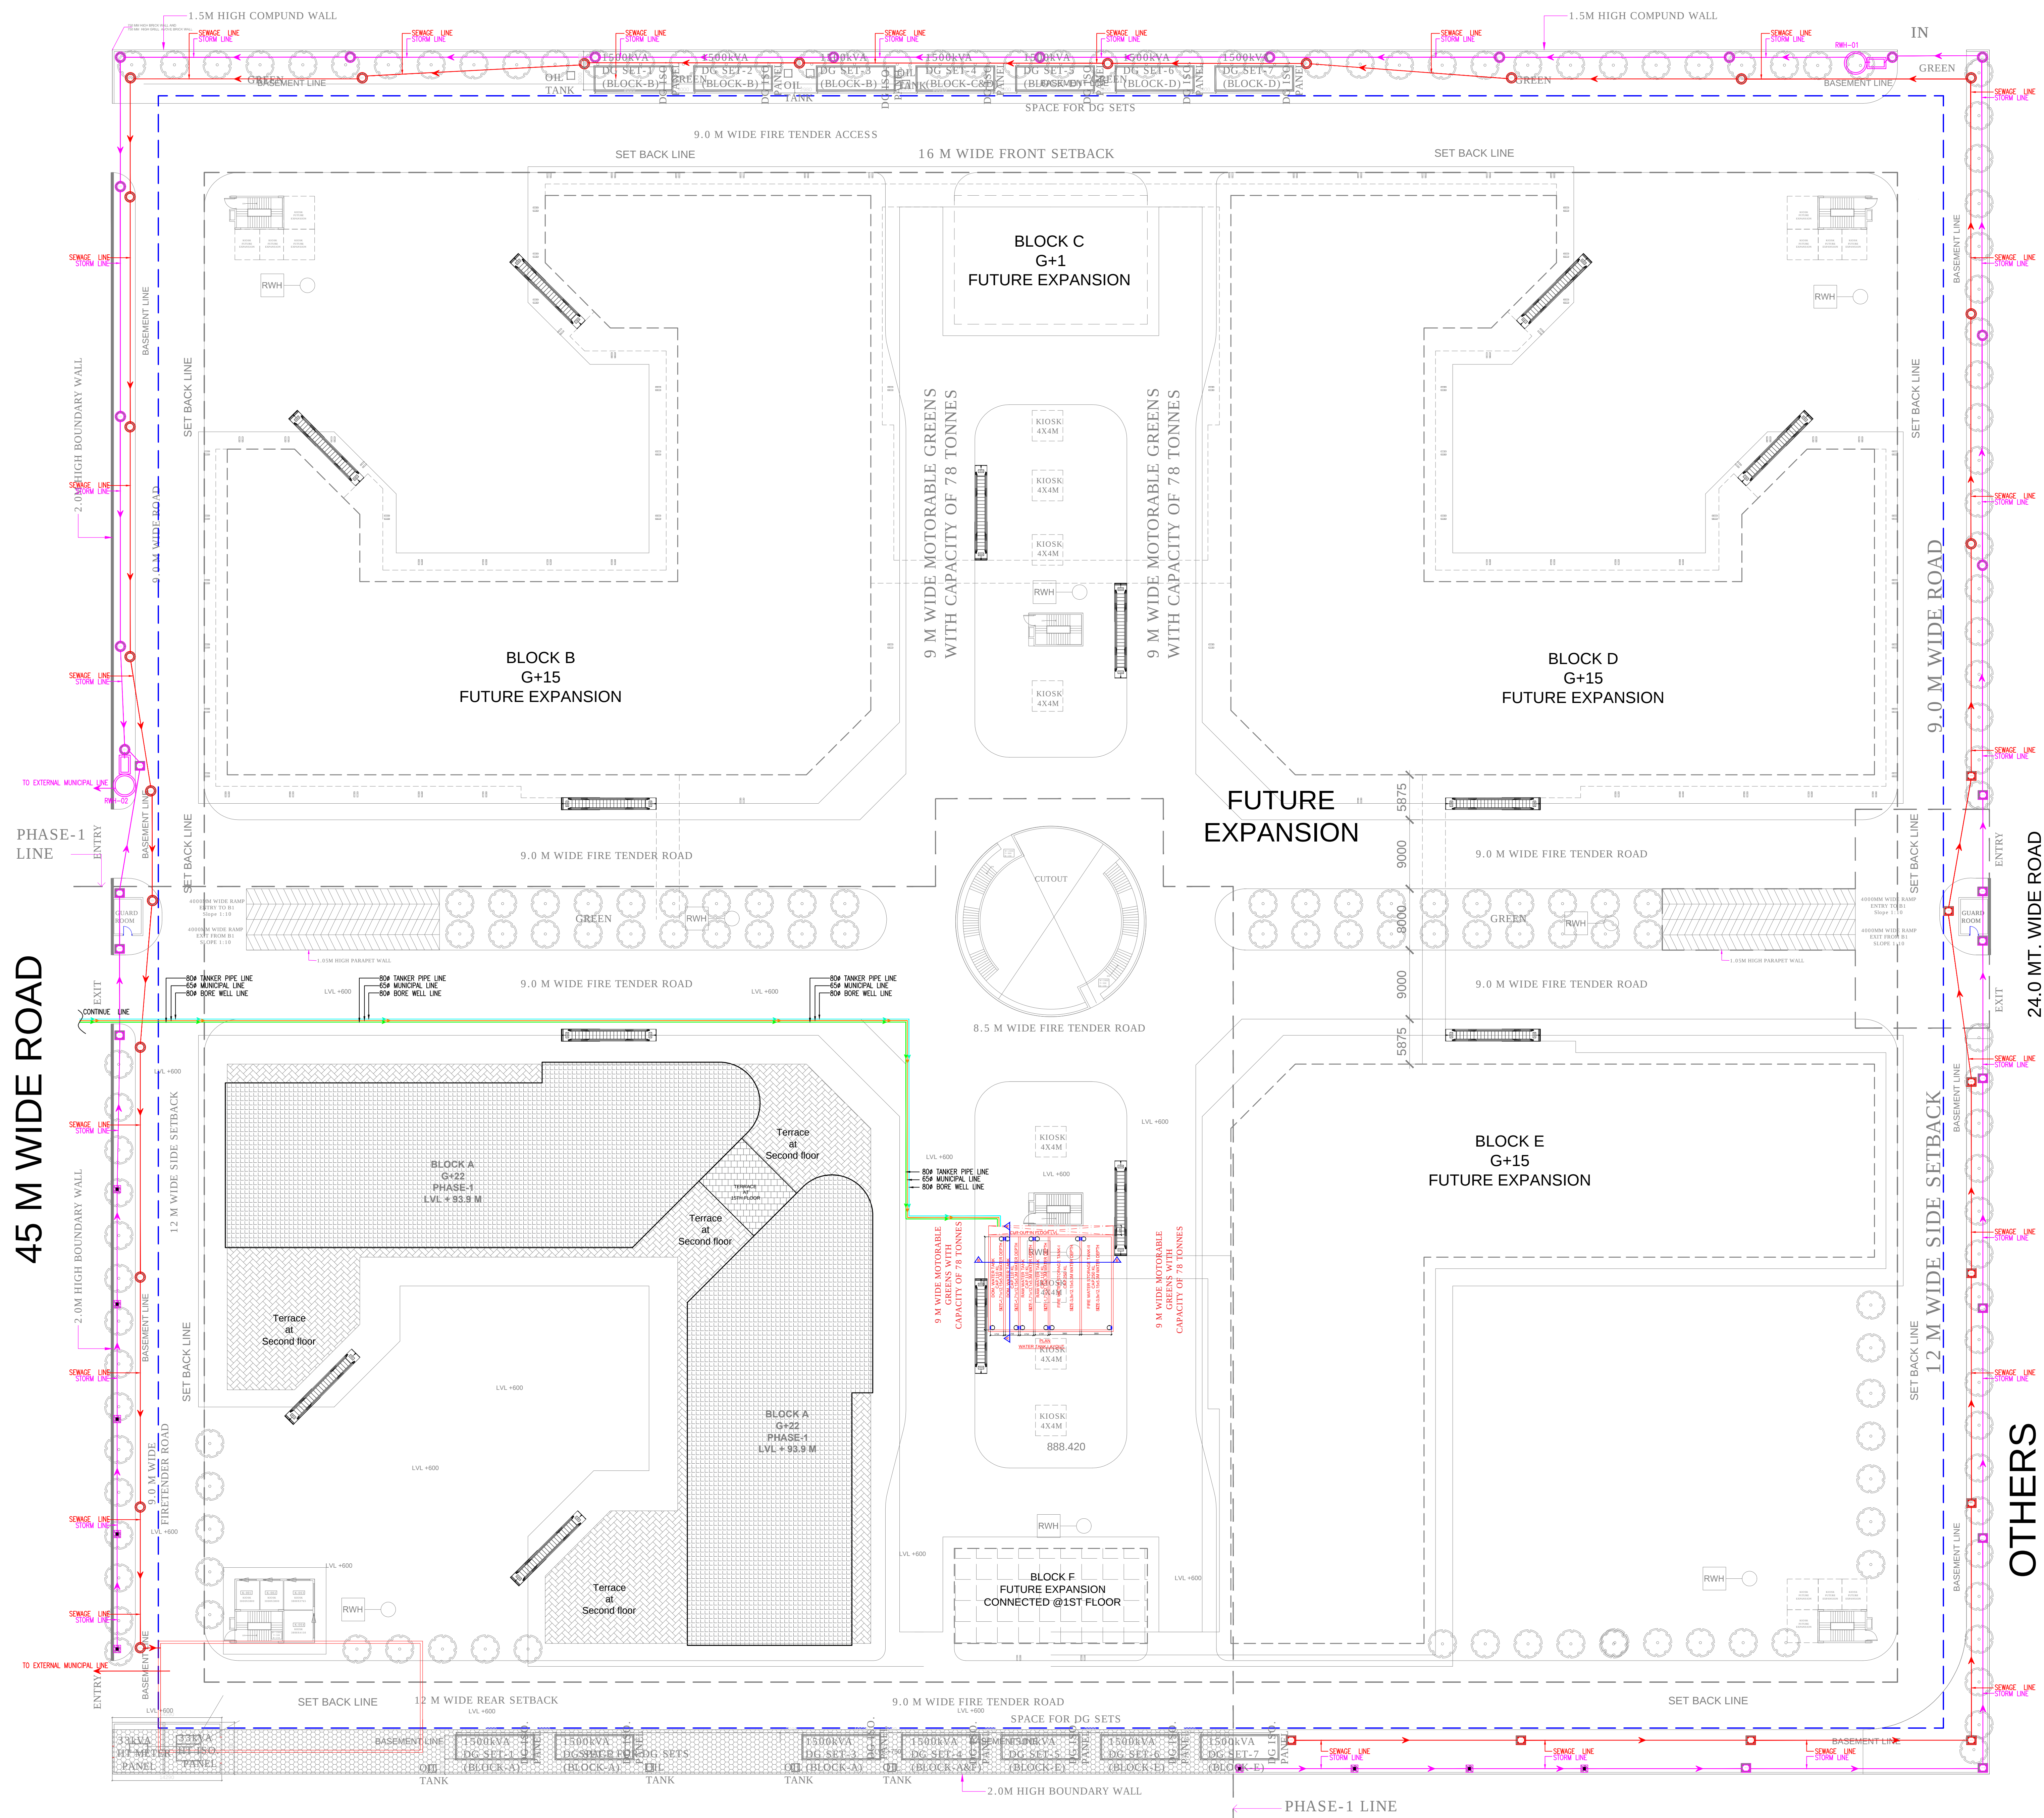

| LIST OF ELECTROMECHANICAL UNIT |                                |       |
|--------------------------------|--------------------------------|-------|
| S.NO.                          | DESCRIPTION                    | UNITS |
| 1                              | RAW SEWAGE WATER TRANSFER PUMP | 2 NOS |
| 2                              | SLUDGE RECIRCULATION PUMP      | 2 NOS |
| 3                              | FILTER FEED PUMP               | 2 NOS |
| AB                             | AIR BLOWER                     | 2 NOS |
| MF                             | MULTI-GRAB FILTER              | 1 NO  |
| ACF                            | ACTIVATED CARBON FILTER        | 1 NO  |
| SP-1                           | SCREW PUMP                     | 2 NOS |
| UF                             | ULTRA FILTRATION               | 1 NO  |
| UFP                            | UF FEED PUMP                   | 2 NO  |
| UFBP                           | UF BACK WASH PUMP              | 2 NO  |
| UFOP                           | UF CIP PUMP                    | 2 NO  |
| WTWP                           | TREATED WATER PUMP             | 2 NO  |
| SWP                            | UF TRANSFER PUMP               | 2 NO  |
| FP                             | FILTER PRESS                   | 1 NO  |

| LEGEND | DESCRIPTION           |
|--------|-----------------------|
| 1 NO   | AIR LINE              |
| 2 NO   | SLUDGE LINE           |
| 3 NO   | EFFLUENT LINE         |
| 4 NO   | EFFECTIVE WATER LEVEL |
| 5 NO   | BALL VALVE            |
| 6 NO   | NON RETURN VALVE      |
| 7 NO   | DIFFUSOR FIXED GRID   |
| 8 NO   | PRESSURE GAUGE        |
| 9 NO   | PUMP                  |
| 10 NO  | AIR BLOWER            |
| 11 NO  | ROTO METER            |

| PLUMBING LEGEND |                    |
|-----------------|--------------------|
|                 | SEWERAGE LINE      |
|                 | STORM LINE         |
|                 | TANKER SUPPLY LINE |
|                 | BORE WELL LINE     |
|                 | MUNICIPAL LINE     |
|                 | WATER FLOW         |
|                 | SEWAGE MH          |
|                 | SEWAGE MH          |
|                 | CATCH BASIN        |
|                 | STORM MH           |
|                 | STORM MH           |

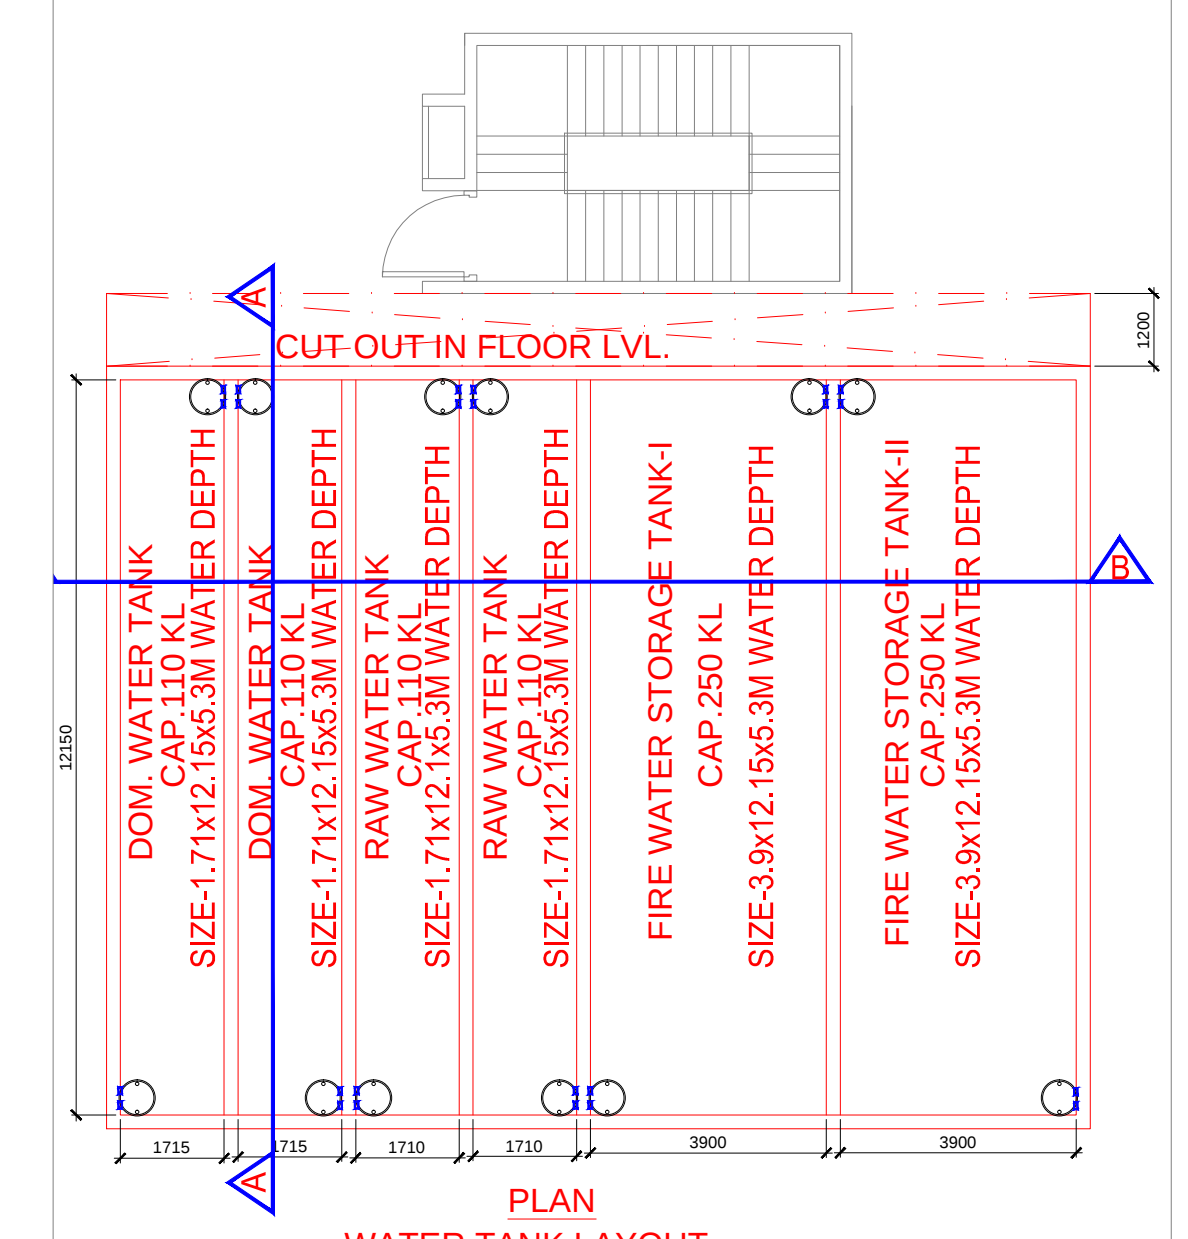

RERA SUBMISSION DRAWING

|                    |                      |                                                        |
|--------------------|----------------------|--------------------------------------------------------|
|                    |                      |                                                        |
|                    |                      |                                                        |
| NO                 | DATE                 | REVISION DISCRPTION                                    |
| PURPOSE OF DRAWING |                      |                                                        |
| G.F.C              | <input type="text"/> | F.I.O <input type="text"/> TENDER <input type="text"/> |

PROJECT  
**IT/ITES BUILDING**  
PLOT NO. 1A, Sector 140A,  
Noida, Uttar Pradesh 201305


CLIENT  
**FAIRFOX ITINFRA PRIVATE LIMITED**  
REGD ADDRESS- PLOT NO. DV-GH-09C, SEC. TECHZONE IV,  
GREATER NOIDA WEST, UTTAR PRADESH

STRUCTURE CONSULTANT  
**NNC DESIGN INTERNATIONAL**  
CONSULTING STRUCTURAL ENGINEERS  
G-70, 2nd FLOOR, JASWANT PLAZA, NEAR KALINDI KUNJ MAIN SARITA  
VIHAR ROAD, OKHLA, NEW DELHI-110025PHONE NO.: +91-11-26940734/5/6/7/8  
FAX: 26940738 E-Mail : nnc\_consultants@hotmail.com  
Web : www.nncdesigninternational.com

MEP CONSULTANT  
**MULTIPLE SERVICE CONSULTANT**  
253/B, Rajpur Khurd Extension,  
Chattarpur, New Delhi-110068,  
Ph. no.-8920225677/8920228058  
mscigbc@gmail.com

LANDSCAPE CONSULTANT  
**INTEGRAL DESIGNS**  
LANDSCAPE ARCHITECTURE, LIGHTING DESIGN  
E-90, ANAND NIKETAN NEW DELHI-110021  
TEL: 2411084, 2411092  
email: designintegral@gmail.com

ARCHITECT  
**DESIGN FORUM INTERNATIONAL**  
ARCHITECTURE, URBAN DESIGN, TOWN PLANNING  
K-47, KAILASH COLONY, NEW DELHI -110048  
PH. NO:- 011-46556600, FAX:- 011-46556601  
www.designforuminternational.com.
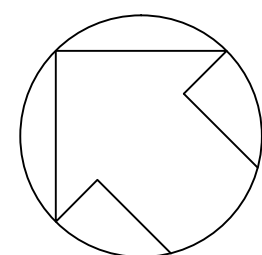
|                                                                                                                           |                                                                                                    |
|---------------------------------------------------------------------------------------------------------------------------|----------------------------------------------------------------------------------------------------|
| K-47, KAILASH COLONY, NEW DELHI -110048<br>PH. NO:- 011-46556600, FAX:- 011-46556601<br>www.designforuminternational.com. |                                                                                                    |
| Date : 25-10-2021                                                                                                         | <div>N</div>  |
| Scale : 1:325                                                                                                             |                                                                                                    |
| Rev. No. R 01                                                                                                             |                                                                                                    |
| Sheet Title<br>SITE PLAN WATER SUPPLY AND DRAINAGE PLAN                                                                   |                                                                                                    |
| Sheet No.<br>MSC/DFI/NOIDA/IT/SP/PL-01                                                                                    |                                                                                                    |