
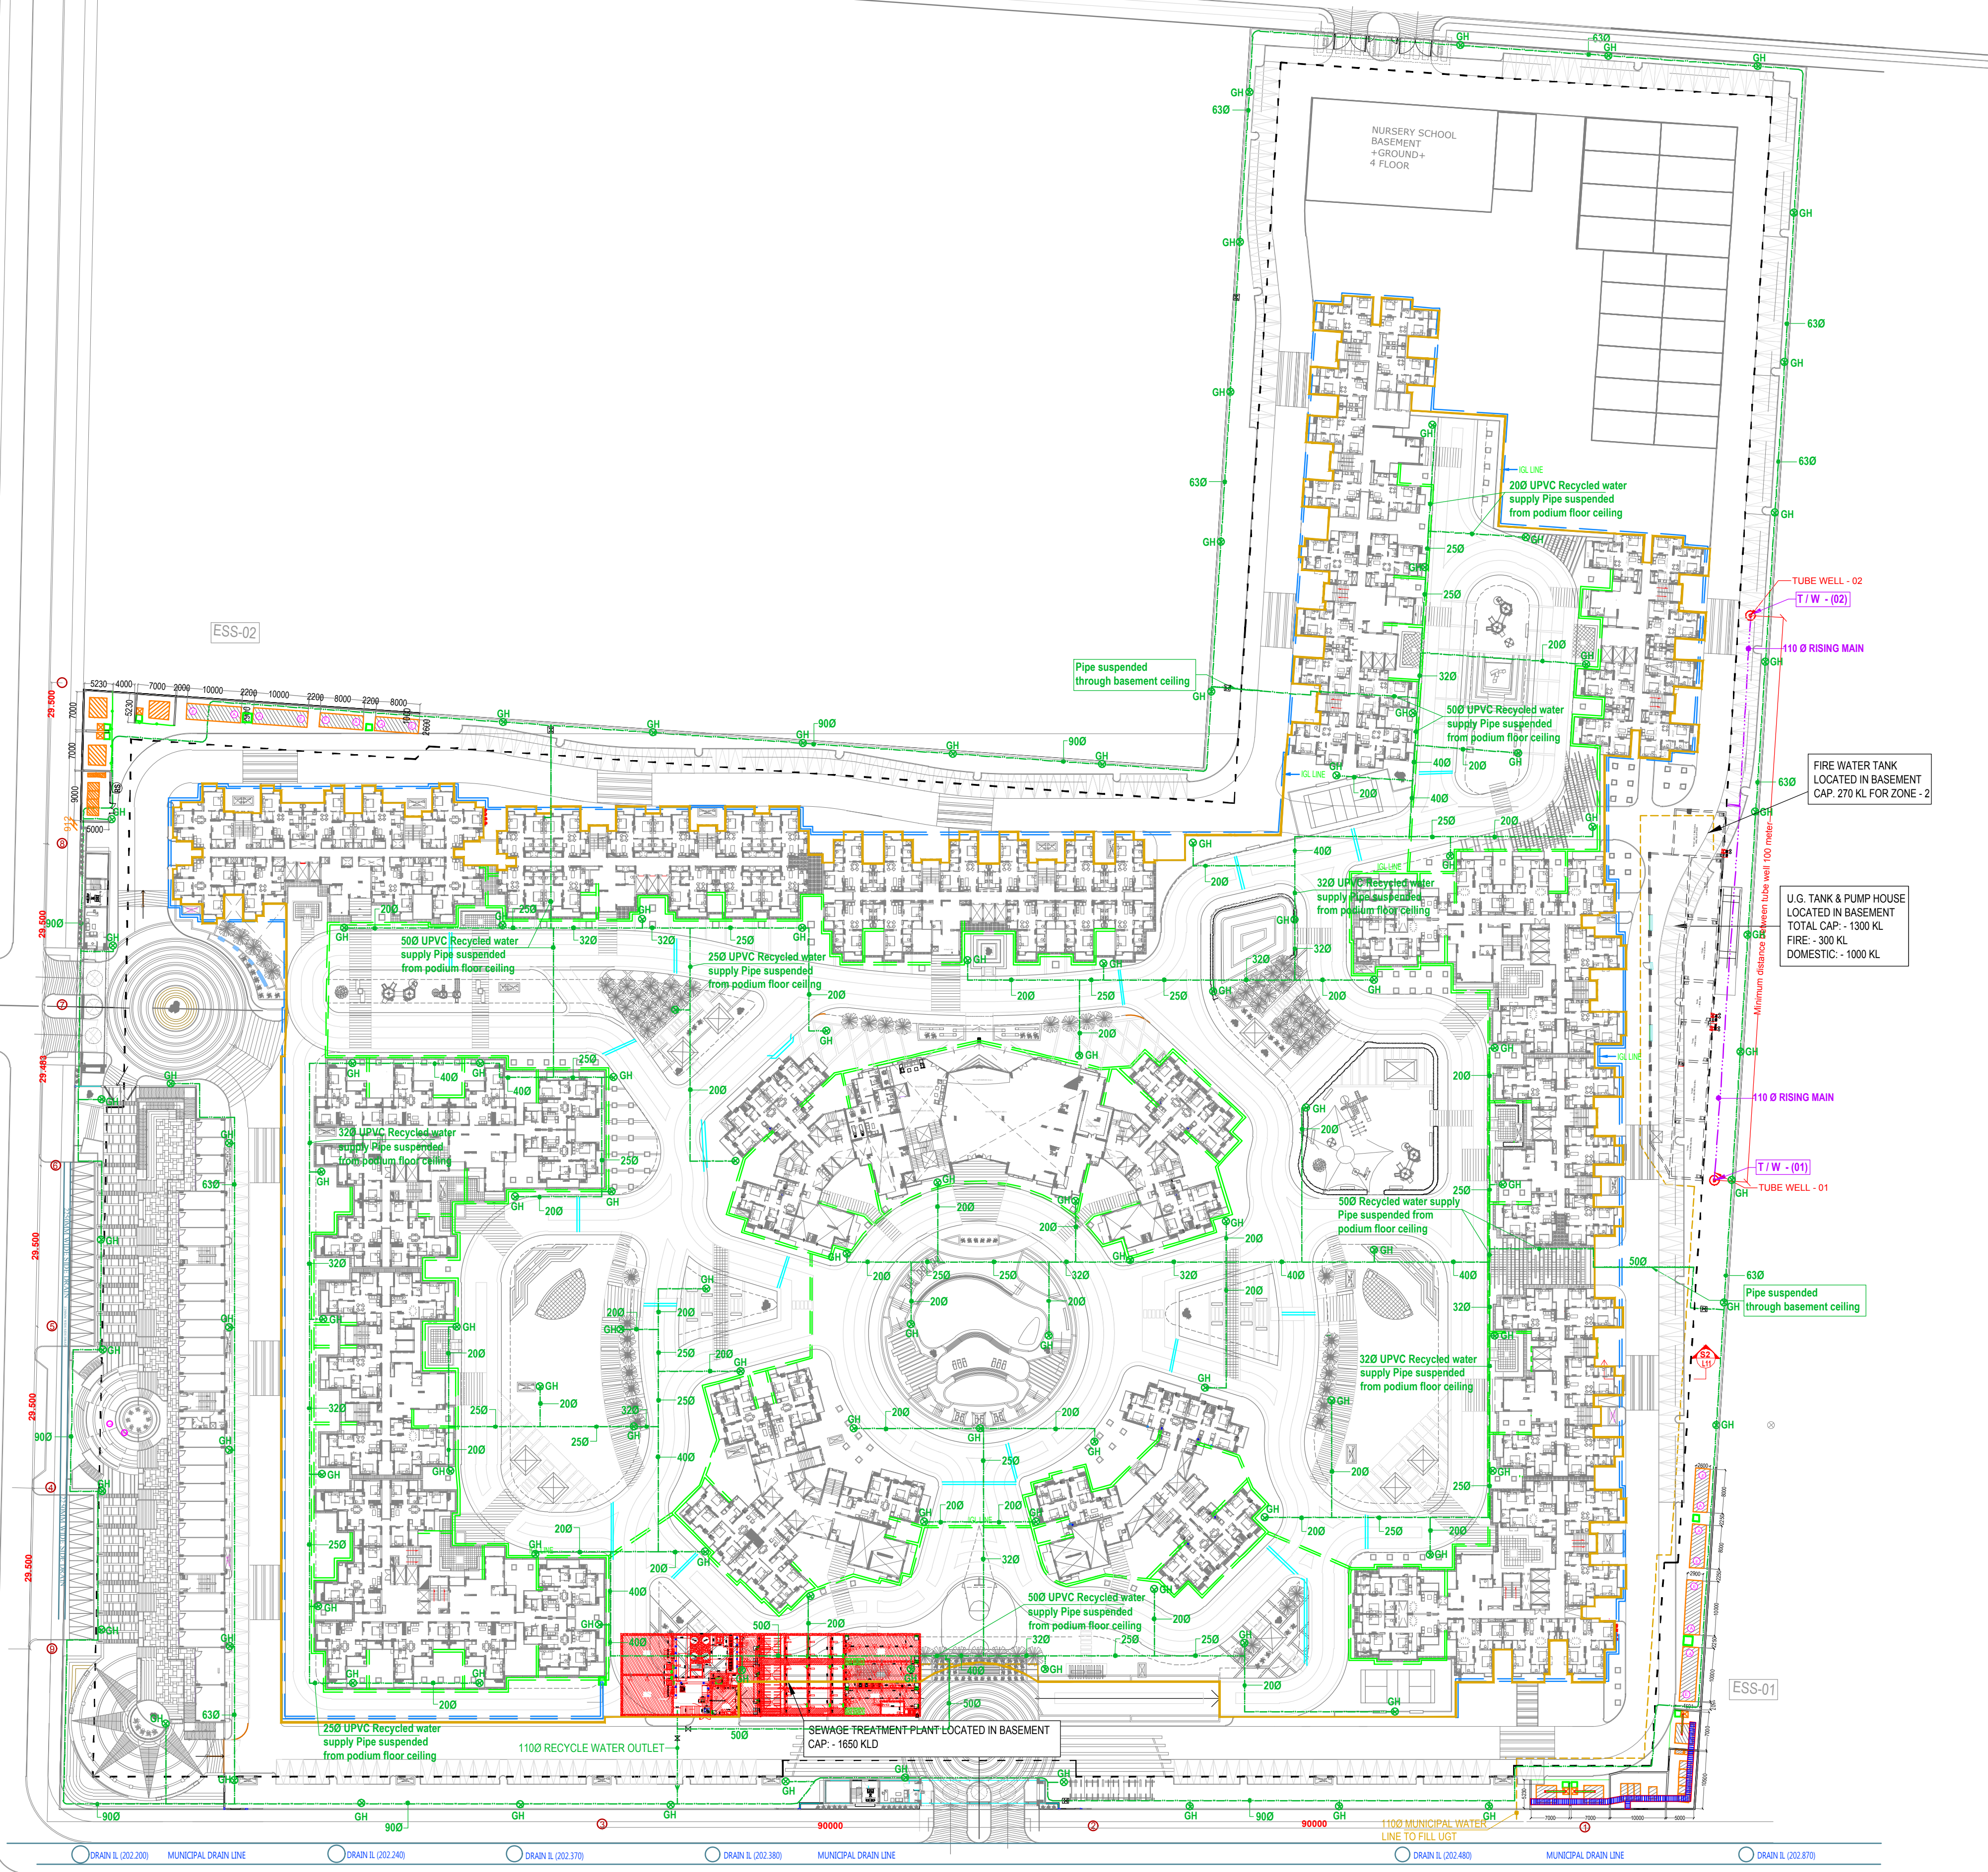


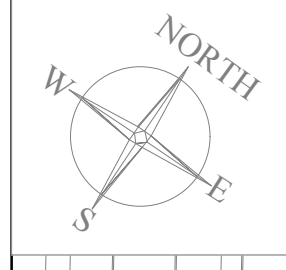

LEGEND :		
S. No.	SYMBOL	DESCRIPTION
1.	---	BASEMENT LINE
2.	---	PODIUM LINE
3.	---	RISING MAIN LINE (FROM TW TO U.G.T.)
4.	---	MUNICIPAL WATER SUPPLY PIPE LINE.
5.	---	RECYCLED WATER SUPPLY LINE FOR HORTICULTURE
6.	⊗ GH	GARDEN HYDRANT
7.	⊙	PROPOSED TUBE WELL
8.	⊠	ISOLATING VALVE WITH MASONRY CHAMBER

NOTES : WATER SUPPLY	
1. The depth of domestic water supply main shall be	-1000 mm
2. The depth of recycle water supply main shall be	- 900 mm
3. The depth of rising main shall be	- 1000 mm
4. Pipe material for external under ground water supply - recycle / tube well rising main / municipal line shall be : HDPE (PE100) PN8	
5. Pipe material for podium horticulture recycle water supply suspended from podium floor ceiling shall be : UPVC SCH 80	

rev. no.	date	revision
R7	27.06.2016	Podium level garden hydrant added
R6	16.08.2016	Drawing revised as per final Commercial area
R5	18.05.2016	Drawing revised as per revised ESS - 01
R4	30.01.2016	Substation layout revised as per comments
R3	18.01.2016	Issued as GFC
R2	04.01.2016	Revised according new layout
R1	06.10.2015	Issued as advance copy for approval
RO	08.04.2015	Issued for approval

project
GROUP HOUSING FOR "LE GARDEN"
AT NOIDA EXTENSION

title
SITE PLAN

subtitle
EXTERNAL WATER SUPPLY SYSTEM

drawing released for
☐ APPROVAL ☐ SUBMISSION
☐ ADVANCE COPY ☒ CONSTRUCTION

drg. no. AJ - LG - WS - 01 drawn by Ravi Chaudhary

scale 1 : 700 designed by Badri Vishal

date November 2014 checked by Anand Havelia

architects
Space Designers International
5 / 1306, VASUNDHARA, GHAZIABAD
PH : 0120-4122214, Mob: 981070399, 9811336231
e-mail : spacesdi@gmail.com, www.spacesdi.com

services consultant
Consummate Engineering Services (P) Ltd.
Noida Office : B - 67, Sector - 67, Noida - 201 301
Tel : (0120) 2593500 (30 Lines)
Lko. Office : R 006, Rohtas Plumeria, Gomti Nagar, Lucknow
Tel : (0522) 6515455
e mail : mail@cespl.in, website : www.cespl.in