
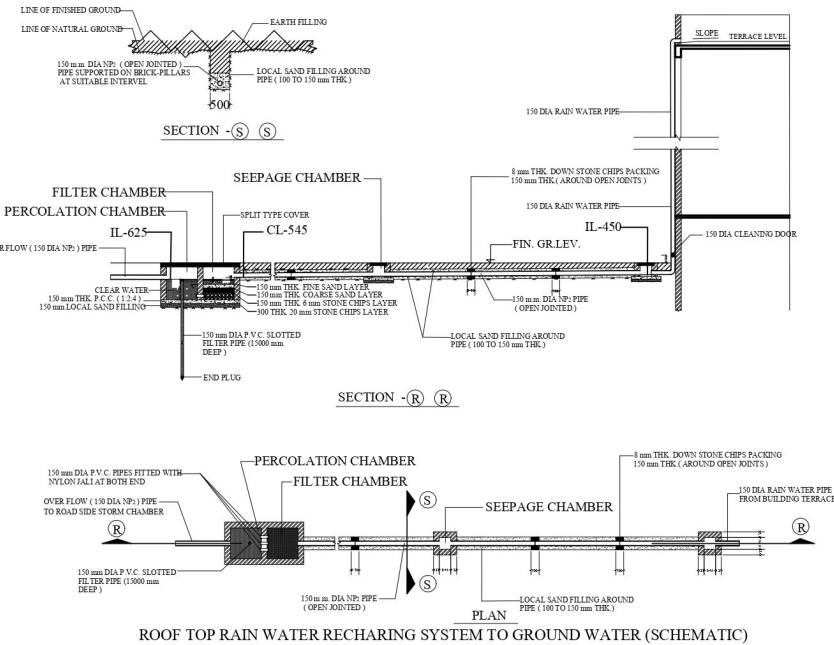


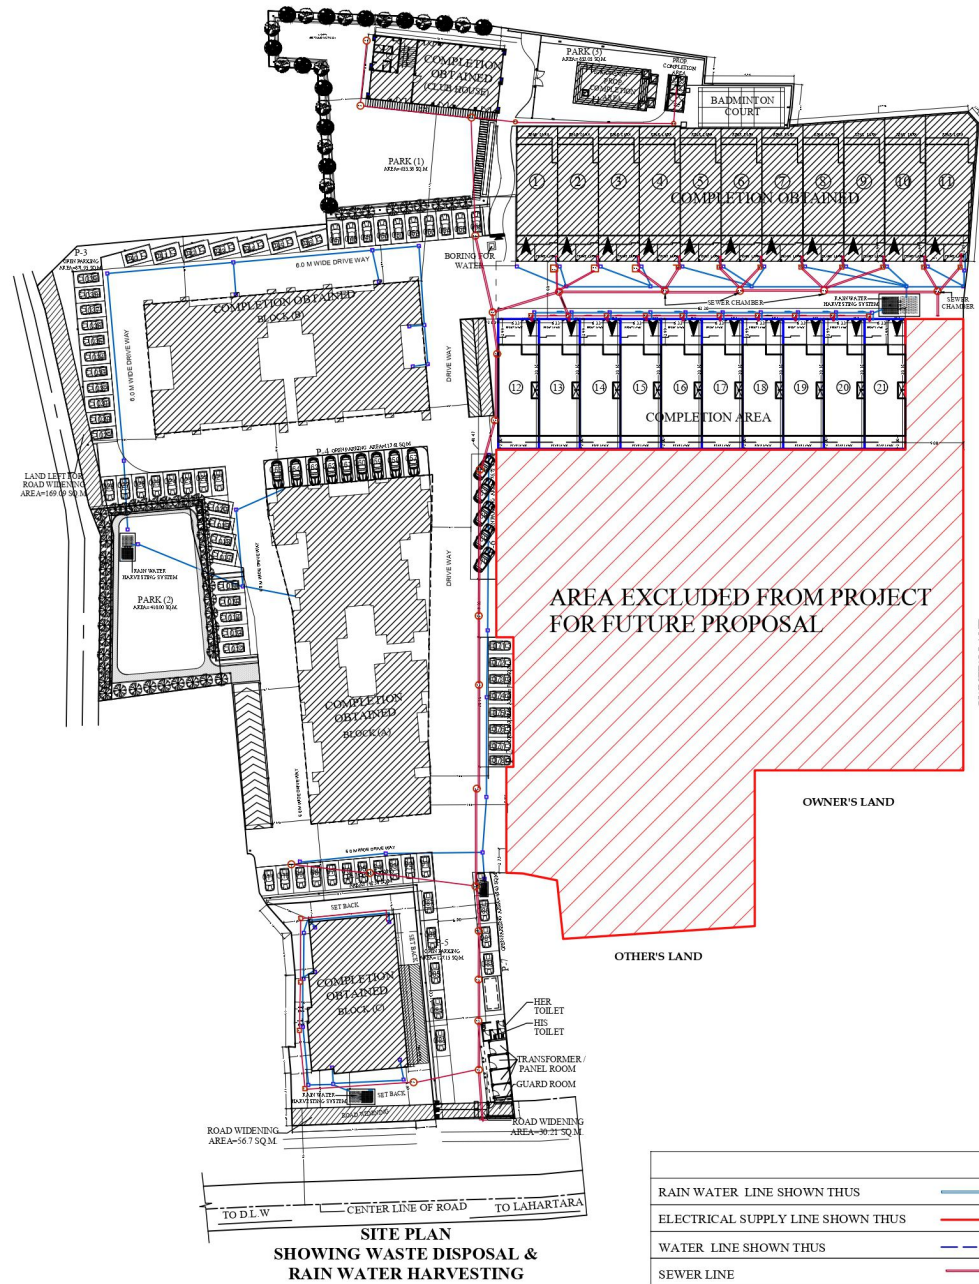

RAIN WATER LINE SHOWN THUS	—
ELECTRICAL SUPPLY LINE SHOWN THUS	—
WATER LINE SHOWN THUS	—
SEWER LINE	—

COMPLETION PLAN OF VILLA BUILDING (12 TO 21) AT 'MAHAVIR HEIGHTS' FOR SRI NITIN MALHOTRA & SRI JAYANT MALHOTRA S/O LATE HUKUM CHANDRA MALHOTRA ON S.M.PLOT NO. 99/1, 99/2 (PART), 101, 102, 104/1, 104/9, 104/10, 186, 187/1, 187/2, 188, 189/2, 189/9, 190, 191, 205 (PART), MAUZA - SHIVDASPUR, PARGANA - DEHAT AMANAT, TEHSIL & DISTT. VARANASI.

It is hereby certified that the structural and foundation design of the building for which map and plans are submitted for approval satisfy the safety requirements as stipulated in the relevant Indian Standard Codes, National Building Code, guidelines and documents specified in Annexure - 2 of Housing Department of Government of Uttar Pradesh vide G.O. No. 570/9-A-1-Bhookamp Rodhi (A.B.) dated February 3, 2001.

Note: THIS DRAWING IS THE PROPERTY OF M.S. SRISHITI AND IS NOT TO BE COPIED OR REPRODUCED WITHOUT THEIR PERMISSION.

Note: All dimensions are in meters.

DRG. TITLE: SITE PLANS SHOWING WASTE DISPOSAL & RAIN WATER HARVESTING

OWNER'S SIGN

ARCHITECT

Scale: 1:200, 1:400 (A1)

Project No. 100/SHIVDASPUR VILLA (101/1000)

Dwg. No. V-02/4

Dwn By: D.K. SENGH

Clkd By: S.P. Dharwan

Project No. 100/SHIVDASPUR VILLA (101/1000)

Dwg. No. V-02/4

M.S. SRISHITI

REGISTERED ARCHITECT

U.P. ARCHITECTS ACT, 1962

REG. NO. 221/03