
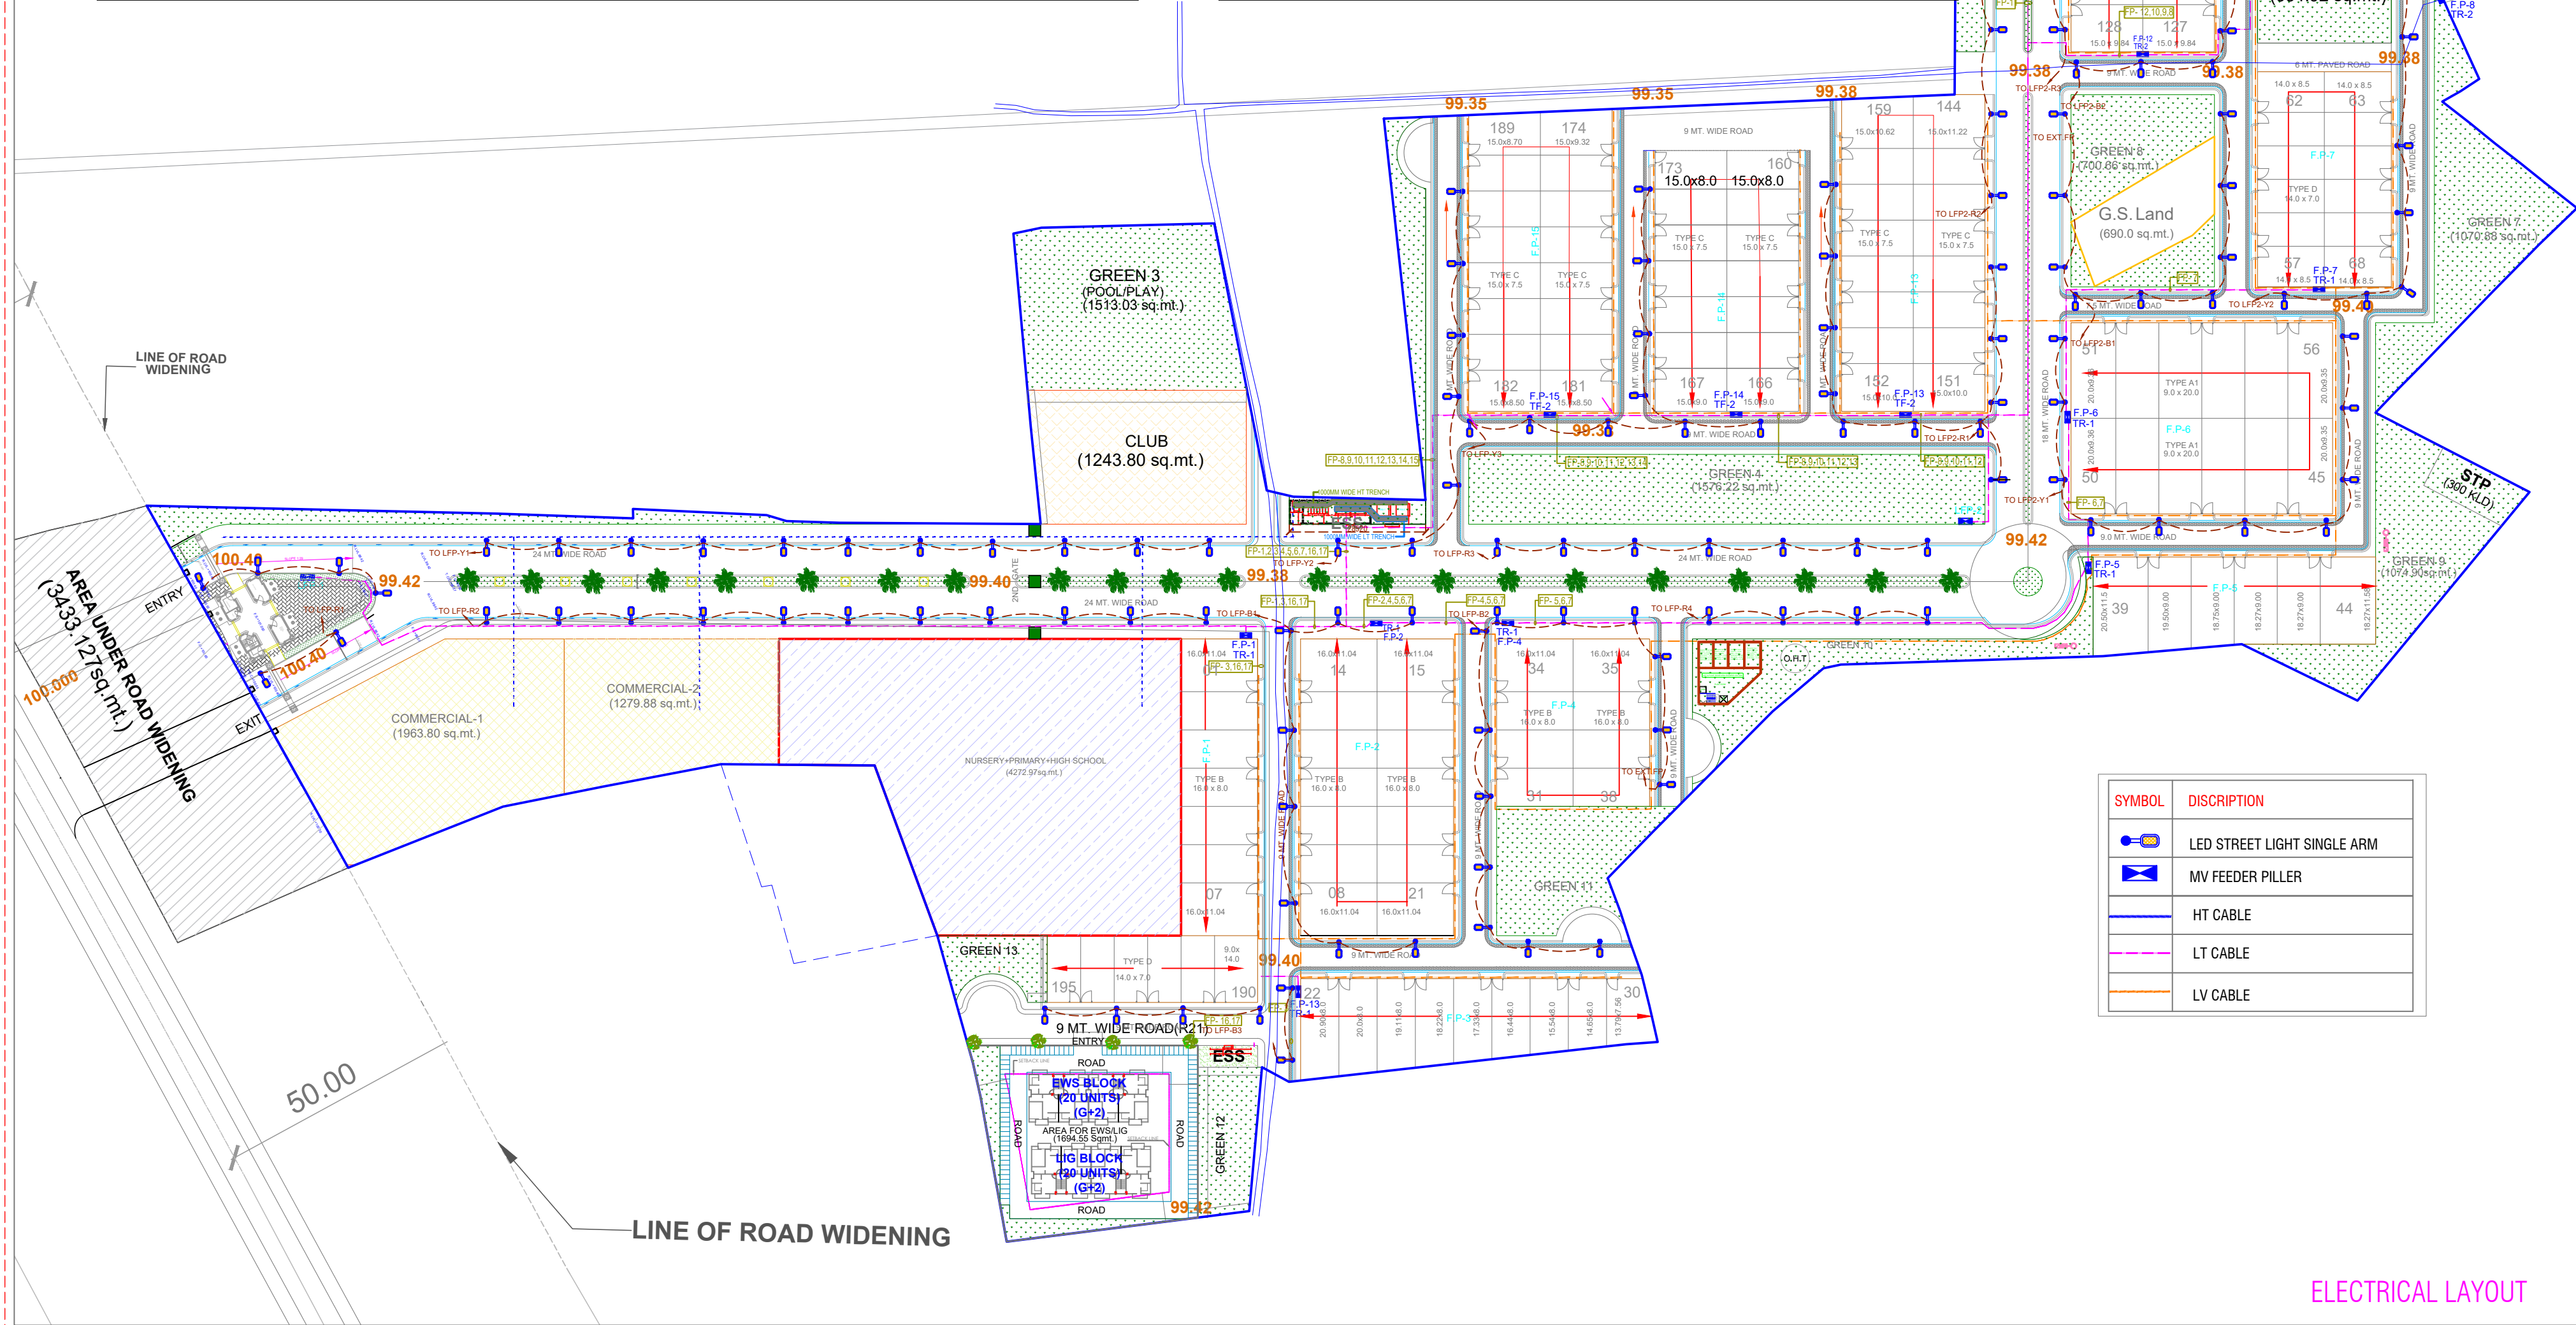
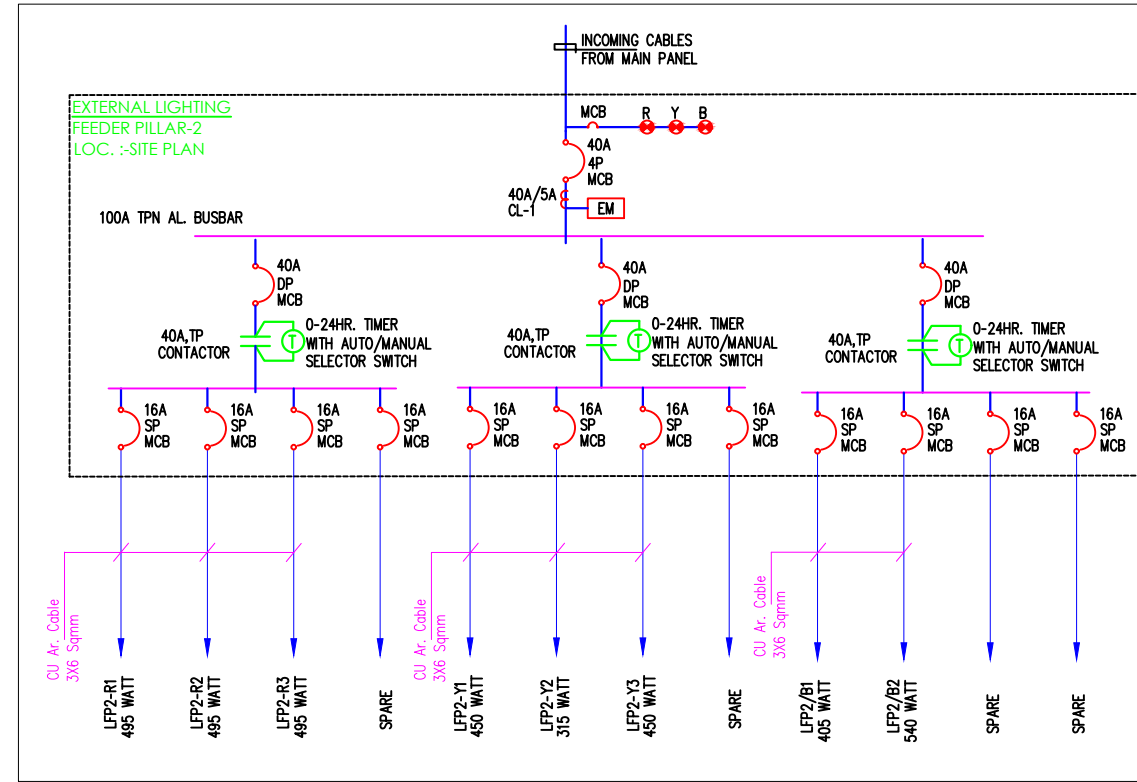


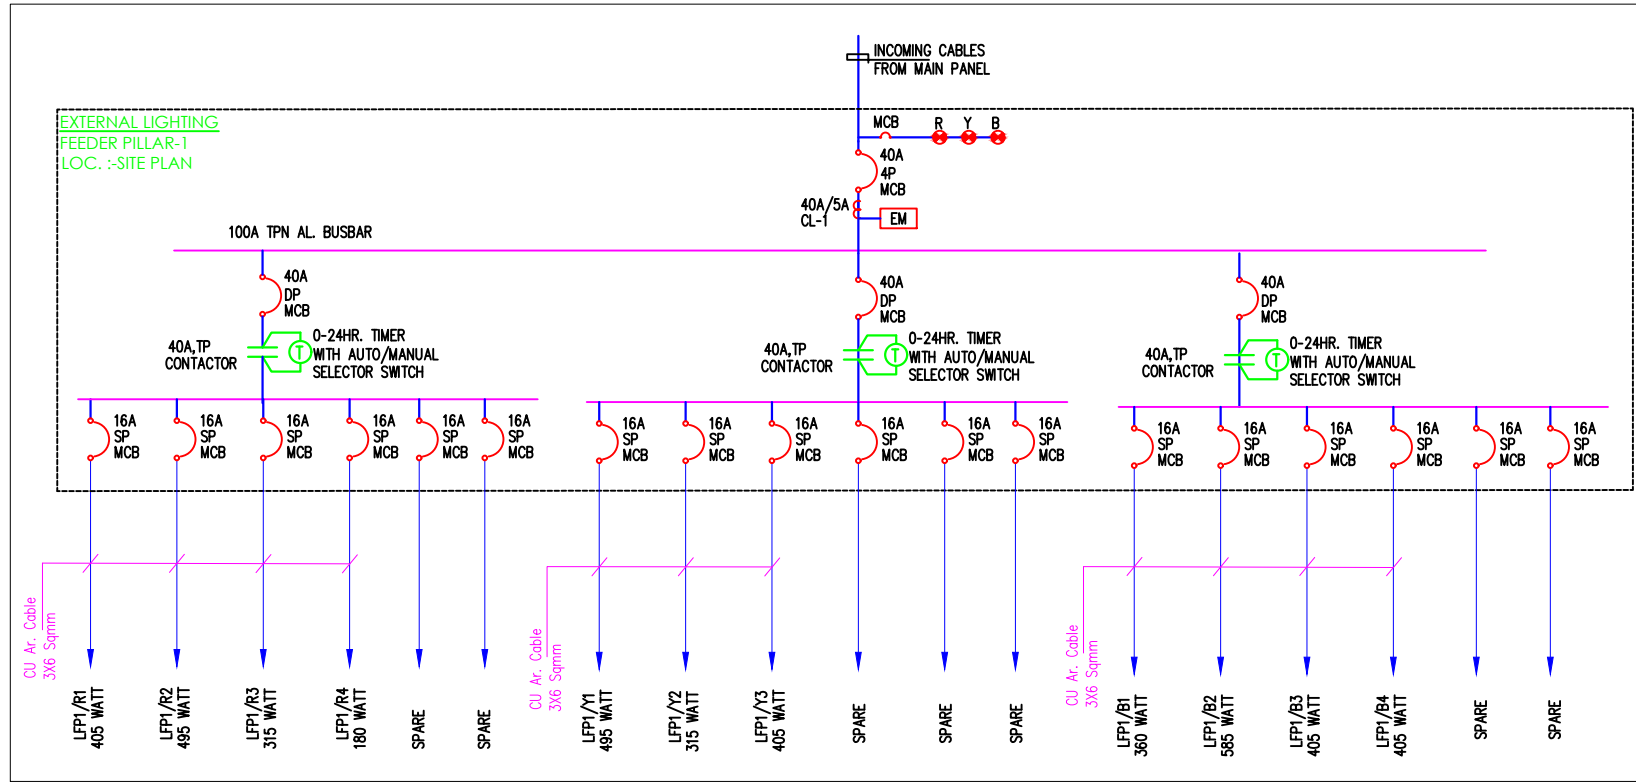

SYMBOL	DISCRIPTION
	LED STREET LIGHT SINGLE ARM
	MV FEEDER PILLER
	HT CABLE
	LT CABLE
	LV CABLE

SPECIAL NOTES:

1. ALL DIMENSIONS ON THIS DRAWING ARE IN MTR.
2. ONLY WRITTEN DIMENSIONS ARE TO BE FOLLOWED. DRAWINGS SHOULD NOT BE SCALED UNDER ANY CIRCUMSTANCES.
3. ALL MEASUREMENTS MUST BE CHECKED AND VERIFIED BY THE CONTRACTORS PRIOR TO EXECUTION OF WORK AT THE SITE.
4. THIS DRAWING IS TO BE READ IN CONJUNCTION WITH ALL RELEVANT STRUCTURAL SERVICES & FACILITY PLANNING DRAWINGS.
5. ARCHITECTURAL DRAWINGS ARE TO BE FOLLOWED FOR THE LOCATION OF ALL STRUCTURAL MEMBERS & MASONRY WALLS. FOR SIZES & REINFORCEMENT DETAILS OF STRUCTURAL MEMBERS RELEVANT STRUCTURAL DRAWINGS ARE TO BE REFERRED.
6. ANY DISCREPANCIES BETWEEN ARCHITECTURAL, STRUCTURAL AND SERVICES DRAWINGS MUST BE BROUGHT TO THE NOTICE OF THE ARCHITECTS IMMEDIATELY & PRIOR TO EXECUTION AT SITE.
7. CO-ORDINATION WITH THE SERVICES SUCH AS HVAC, PLUMBING & ELECTRICAL ETC. IS THE RESPONSIBILITY OF THE CONTRACTORS.
8. ALL MASONRY WALLS SHOULD BE ALIGNED WITH THE COLUMNS AS INDICATED ON THE PLAN IRRESPECTIVE OF THE POSITION AS CALCULATED WITH THE DIMENSIONING.
9. FOR DETAILS, REFER RELEVANT LARGE SCALE DETAIL DRGS. AS INDICATED.

ISSUES

NO.	DESCRIPTION	DATE

REVISIONS

NO.	DESCRIPTION	DATE

DRAWING STATUS: **WORKING DRAWING**

PROJECT: **PROPOSED PLOTTED DEVELOPMENT "ELDECO IMPERIA" AT VILLAGE-JAITIKHERA**

DEVELOPER: **ELDECO HOUSING & INDUSTRIES LTD.**

ARCHITECT: **espaces**
Ar. SANJAY KR. GUPTA
108, CORPORATE CHAMBER-I,
VIBHUTI KHAND, GOMTI NAGAR,
LUCKNOW
ph.no. - 0522-4065958, 09415114589

MEP CONSULTANTS: **PARADISE CONSULTANTS**
PLOT NO. 103, POCKET-1, BASEMENT
JASOLA VIHAR NEW DELHI - 110025
PH+91-11-29943601, 46132800, 41030619
E-mail: paradiseconsultants@gmail.com

DRAWING TITLE: **MASTER PLAN ELECTRICAL LAYOUT**

scale : 1:500 (A0) drawn by : M.S
date : 25/01/2021 checked by : ATIO
project no : approved by : NAFEEES
drawing no : **EL-PC-EI-JK-SITE-101**

REVISION

--	--	--	--	--	--	--	--	--	--