


PART OF FREE HOLD PLOT NO.-53/2 & 53/7

SYMBOL	DESCRIPTION
	VERTICAL INLET PIPE FROM S.C.
	VERTICAL COLD WATER SUPPLY
	1100 uPVC RAIN WATER PIPE
	1100 uPVC SOIL AND VENT PIPE
	1100 uPVC WASTE AND VENT PIPE
	1100 uPVC SOIL PIPE
	900 uPVC WASTE PIPE
	320 CPVC WASTE PIPE
	WATER SUPPLY PIPE (G.I.) ON TERRACE & CPVC INSIDE TOILE
	CPVC COLD WATER PIPE
	URINAL TRAP
	FLOOR TRAP
	300X300 GULLY TRAP
	450X450 KHURRA
	600X600 MAN HOLE
	900X800 MAN HOLE

OTHER'S BUILDING

PART OF FREE HOLD PLOT NO.-53/4

PART OF FREE HOLD PLOT NO. 53/3

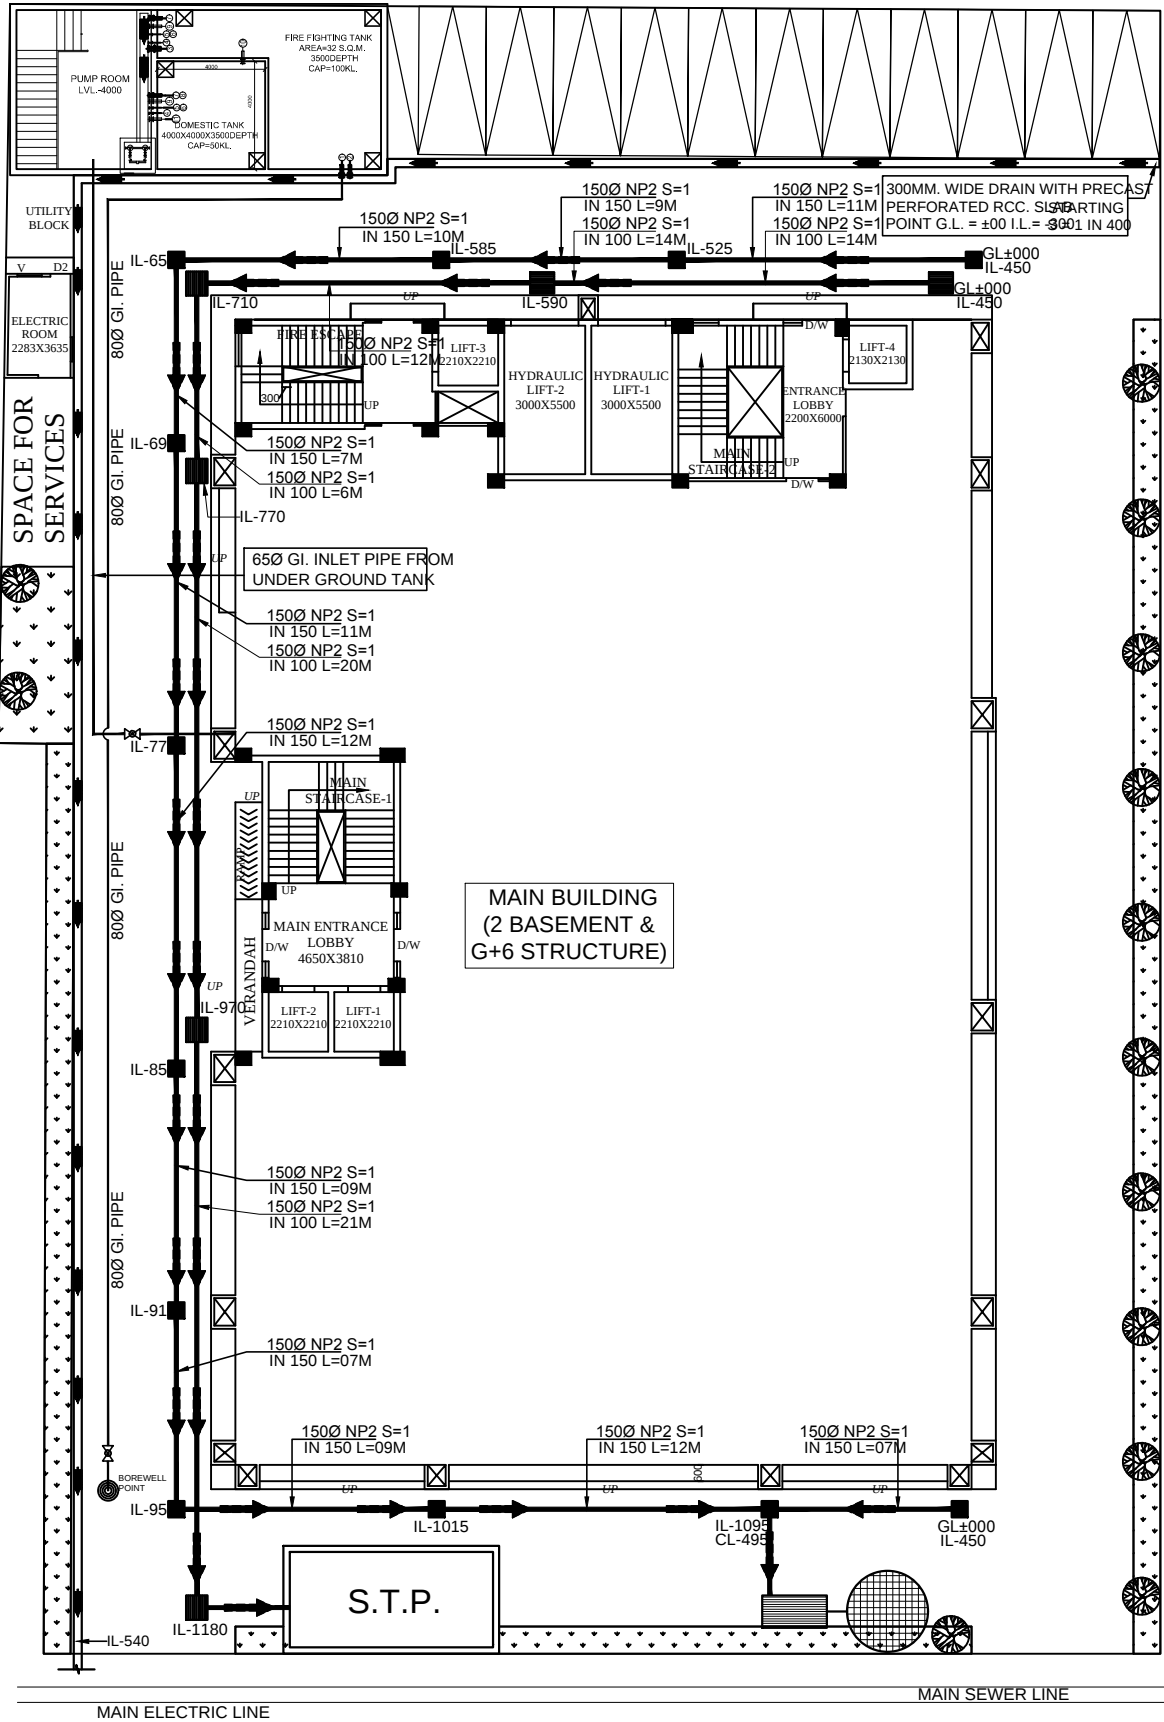

PROPOSED SITE PLAN (WITH PLUMBING LAYOUT SYSTEM)

PROJECT:- PROPOSED OFFICIAL BUILDING PLAN ON PART PORTION OF FREEHOLD PLOT NO. 53/2, FREEHOLD PLOT NO. 53/3, PART PORTION OF FREEHOLD PLOT NO. 53/4, PART PORTION OF FREEHOLD PLOT NO. 53/6, PART OF FREEHOLD PLOT NO. 53/7 ALL PART OF NAZUL (NOW FREEHOLD) PLOT NO. 53, CIVIL STATION, ELGIN ROAD (JAL BAHAUDUR SHAH MARG), ALLAHABAD.	OWNER:- 1. MIS. TULSIANI CONSTRUCTIONS AND DEVELOPERS PVT. LTD. OFF. - PLOT NO. 3, BLOCK 'N' GREEN PARK N. DELHI-110016 2. SMT. SAVITRI GUPTA W/O SHRI. SANT RAM GUPTA 3. SHRI. RAJESH GUPTA S/O SHRI. SANT RAM GUPTA	DRAWING TITLE:- PLUMBING LAYOUT SITE PLAN	Drg. No. PL-01 Checked By AMIT Date AUG/2018 M. PANT	Architectural Consultants :- ARCON'S AR. ANKHILSHWAR SINGH (FIRMS APARTMENT/FLATS AND MARG/TOILE LINES, ALL.) TEL. : +91-9415214329	Services Consultant :- SHAH & PANT CONSULTING ENGINEERS (P. LTD.) 110, BANGALORE ROAD, NEW DELHI-110014 TEL. : +91-11-26100000
---	---	---	--	---	--