


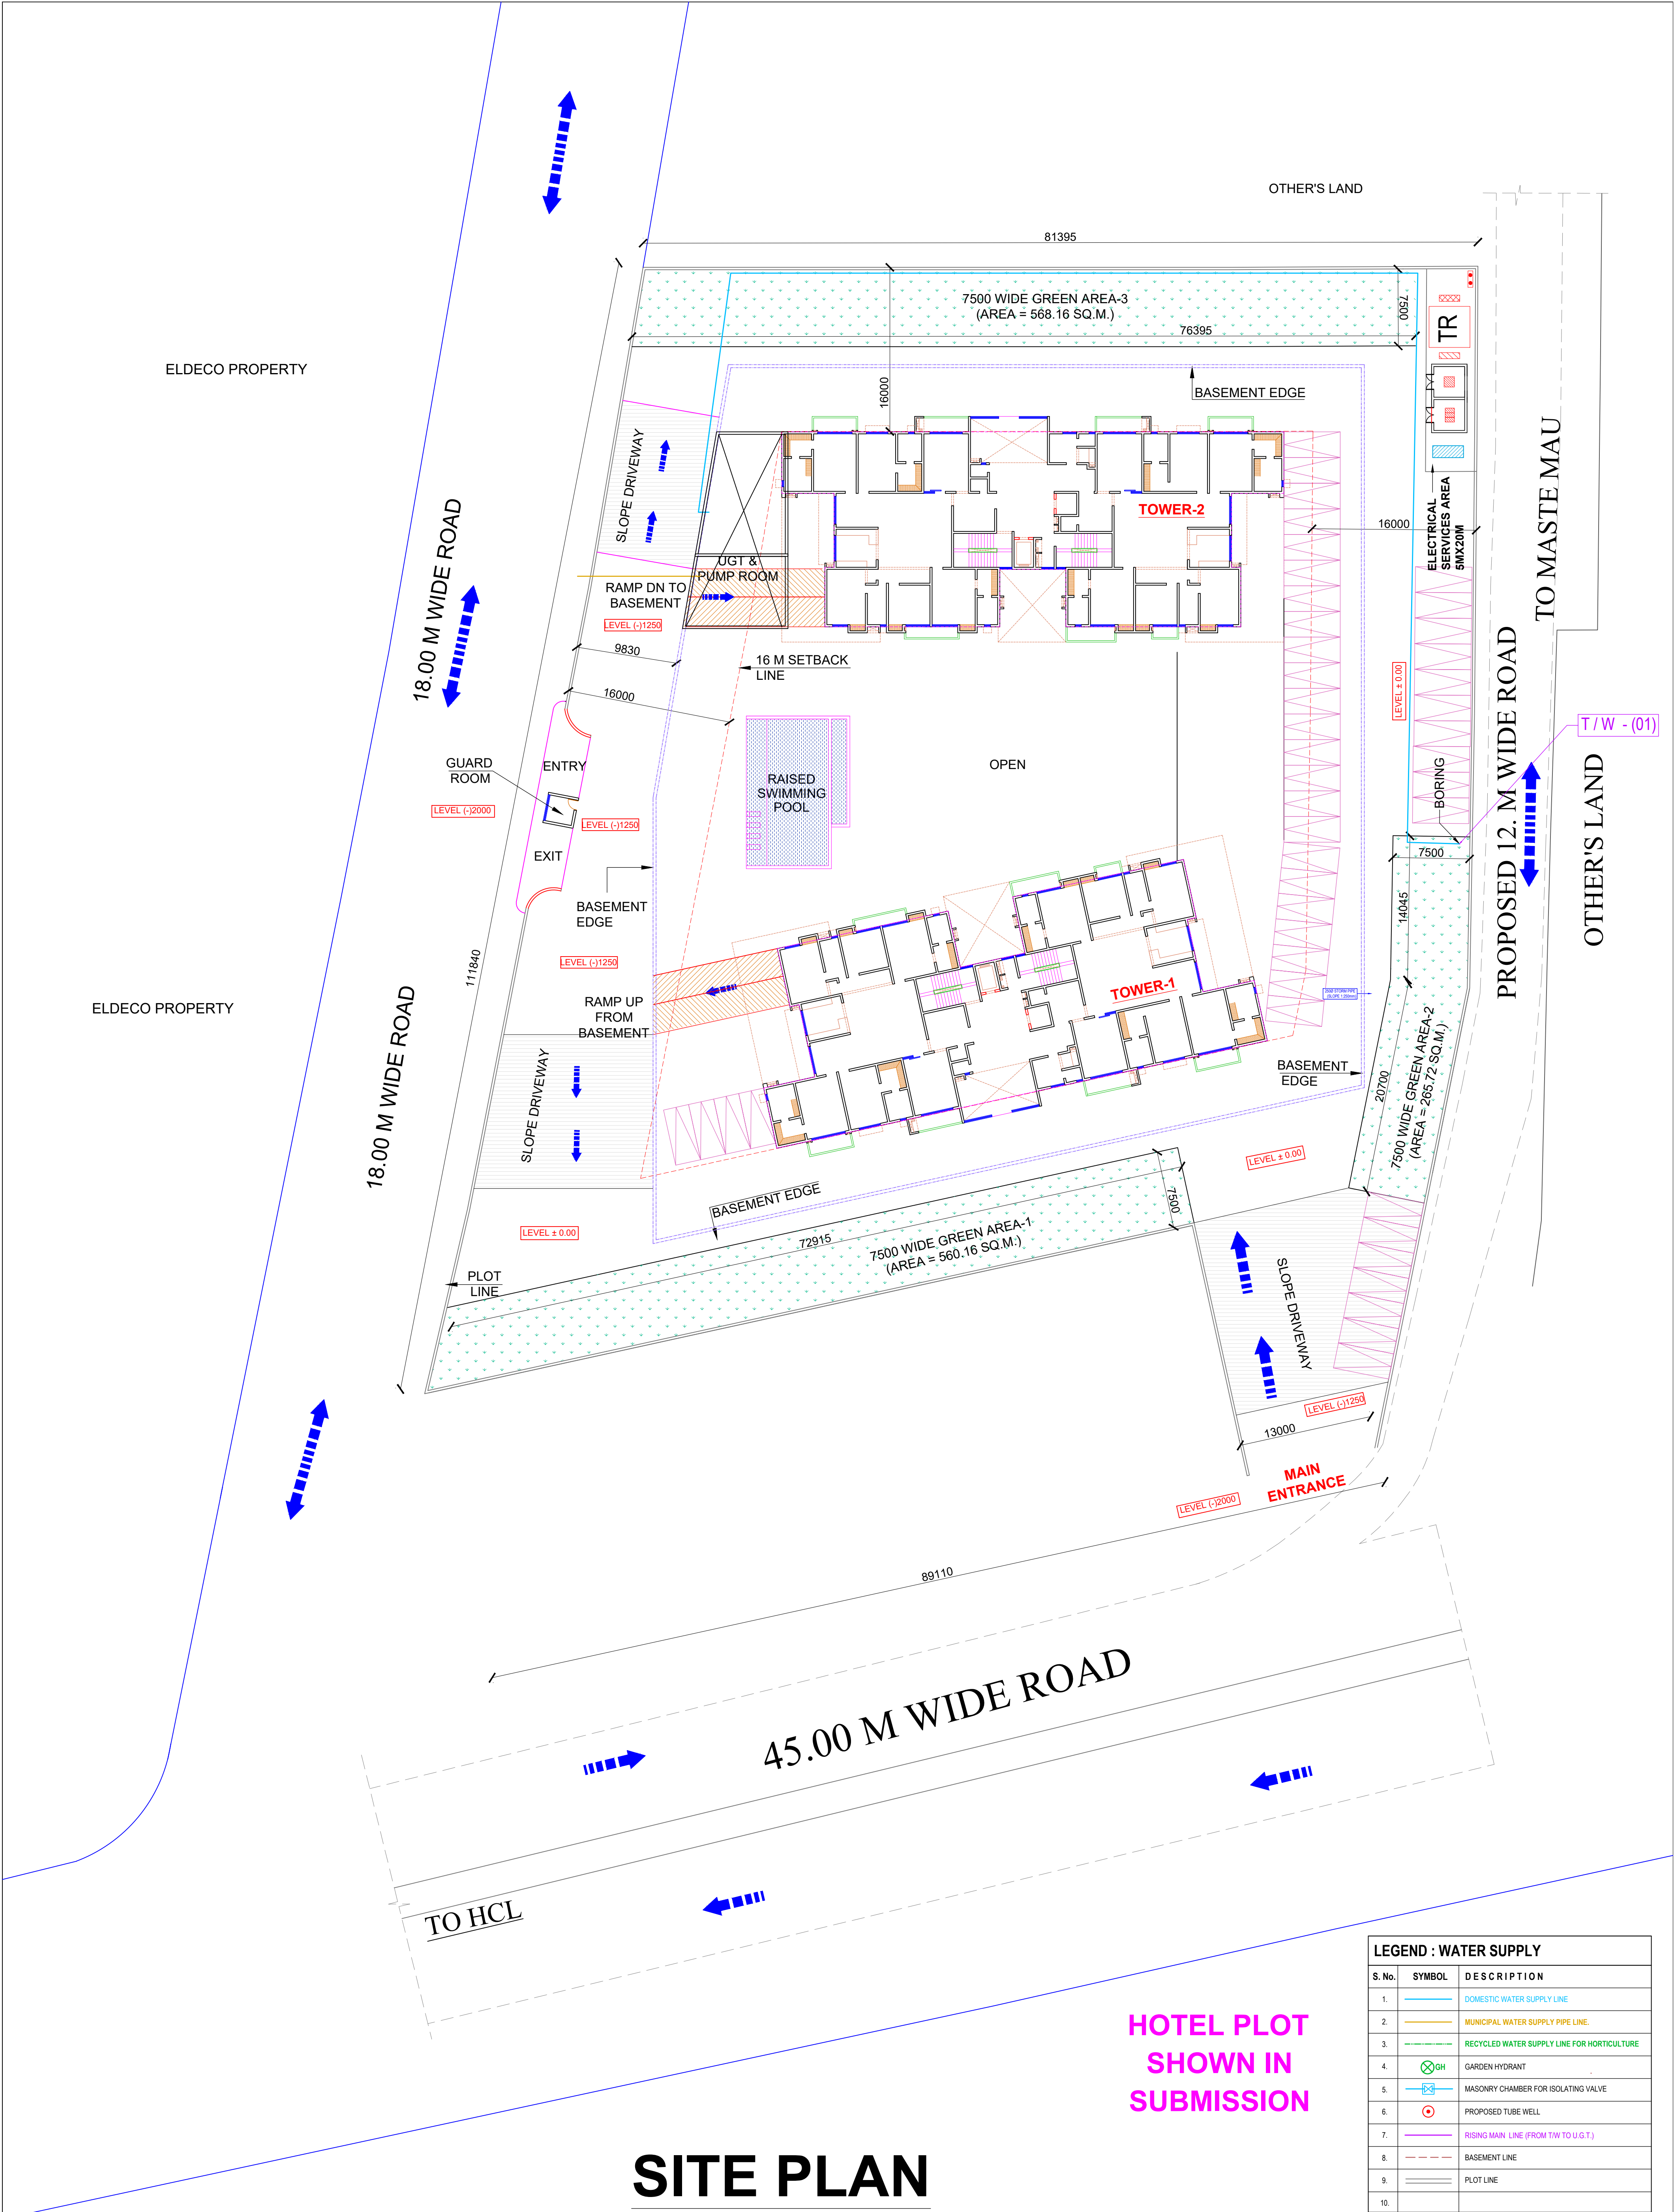

Job title :
PROPOSED GROUP HOUSING FOR CHINMAY DEVELOPERS THROUGH PARTNER
MR. RAVI BANSAL ON KHASRA NO. 477,478,479KA, 611 AND 612 OF VILLAGE
MASTEMAU, PARGANA AND TEHSEEL MOHANLALGANJ, LUCKNOW

Drg title :
SITE PLAN
EXTERNAL WATER SUPPLY SYSTEM



ARCHITECTS:
VISHAL & ASSOCIATES
3/77, Viraj Khand, Gomti Nagar, Lucknow
Mob : 9839447965,9839097571