
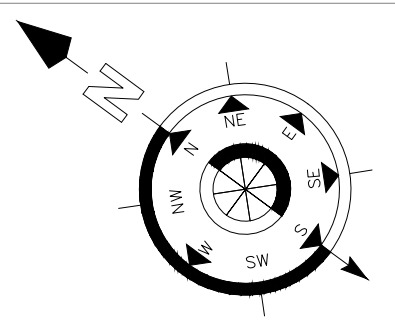


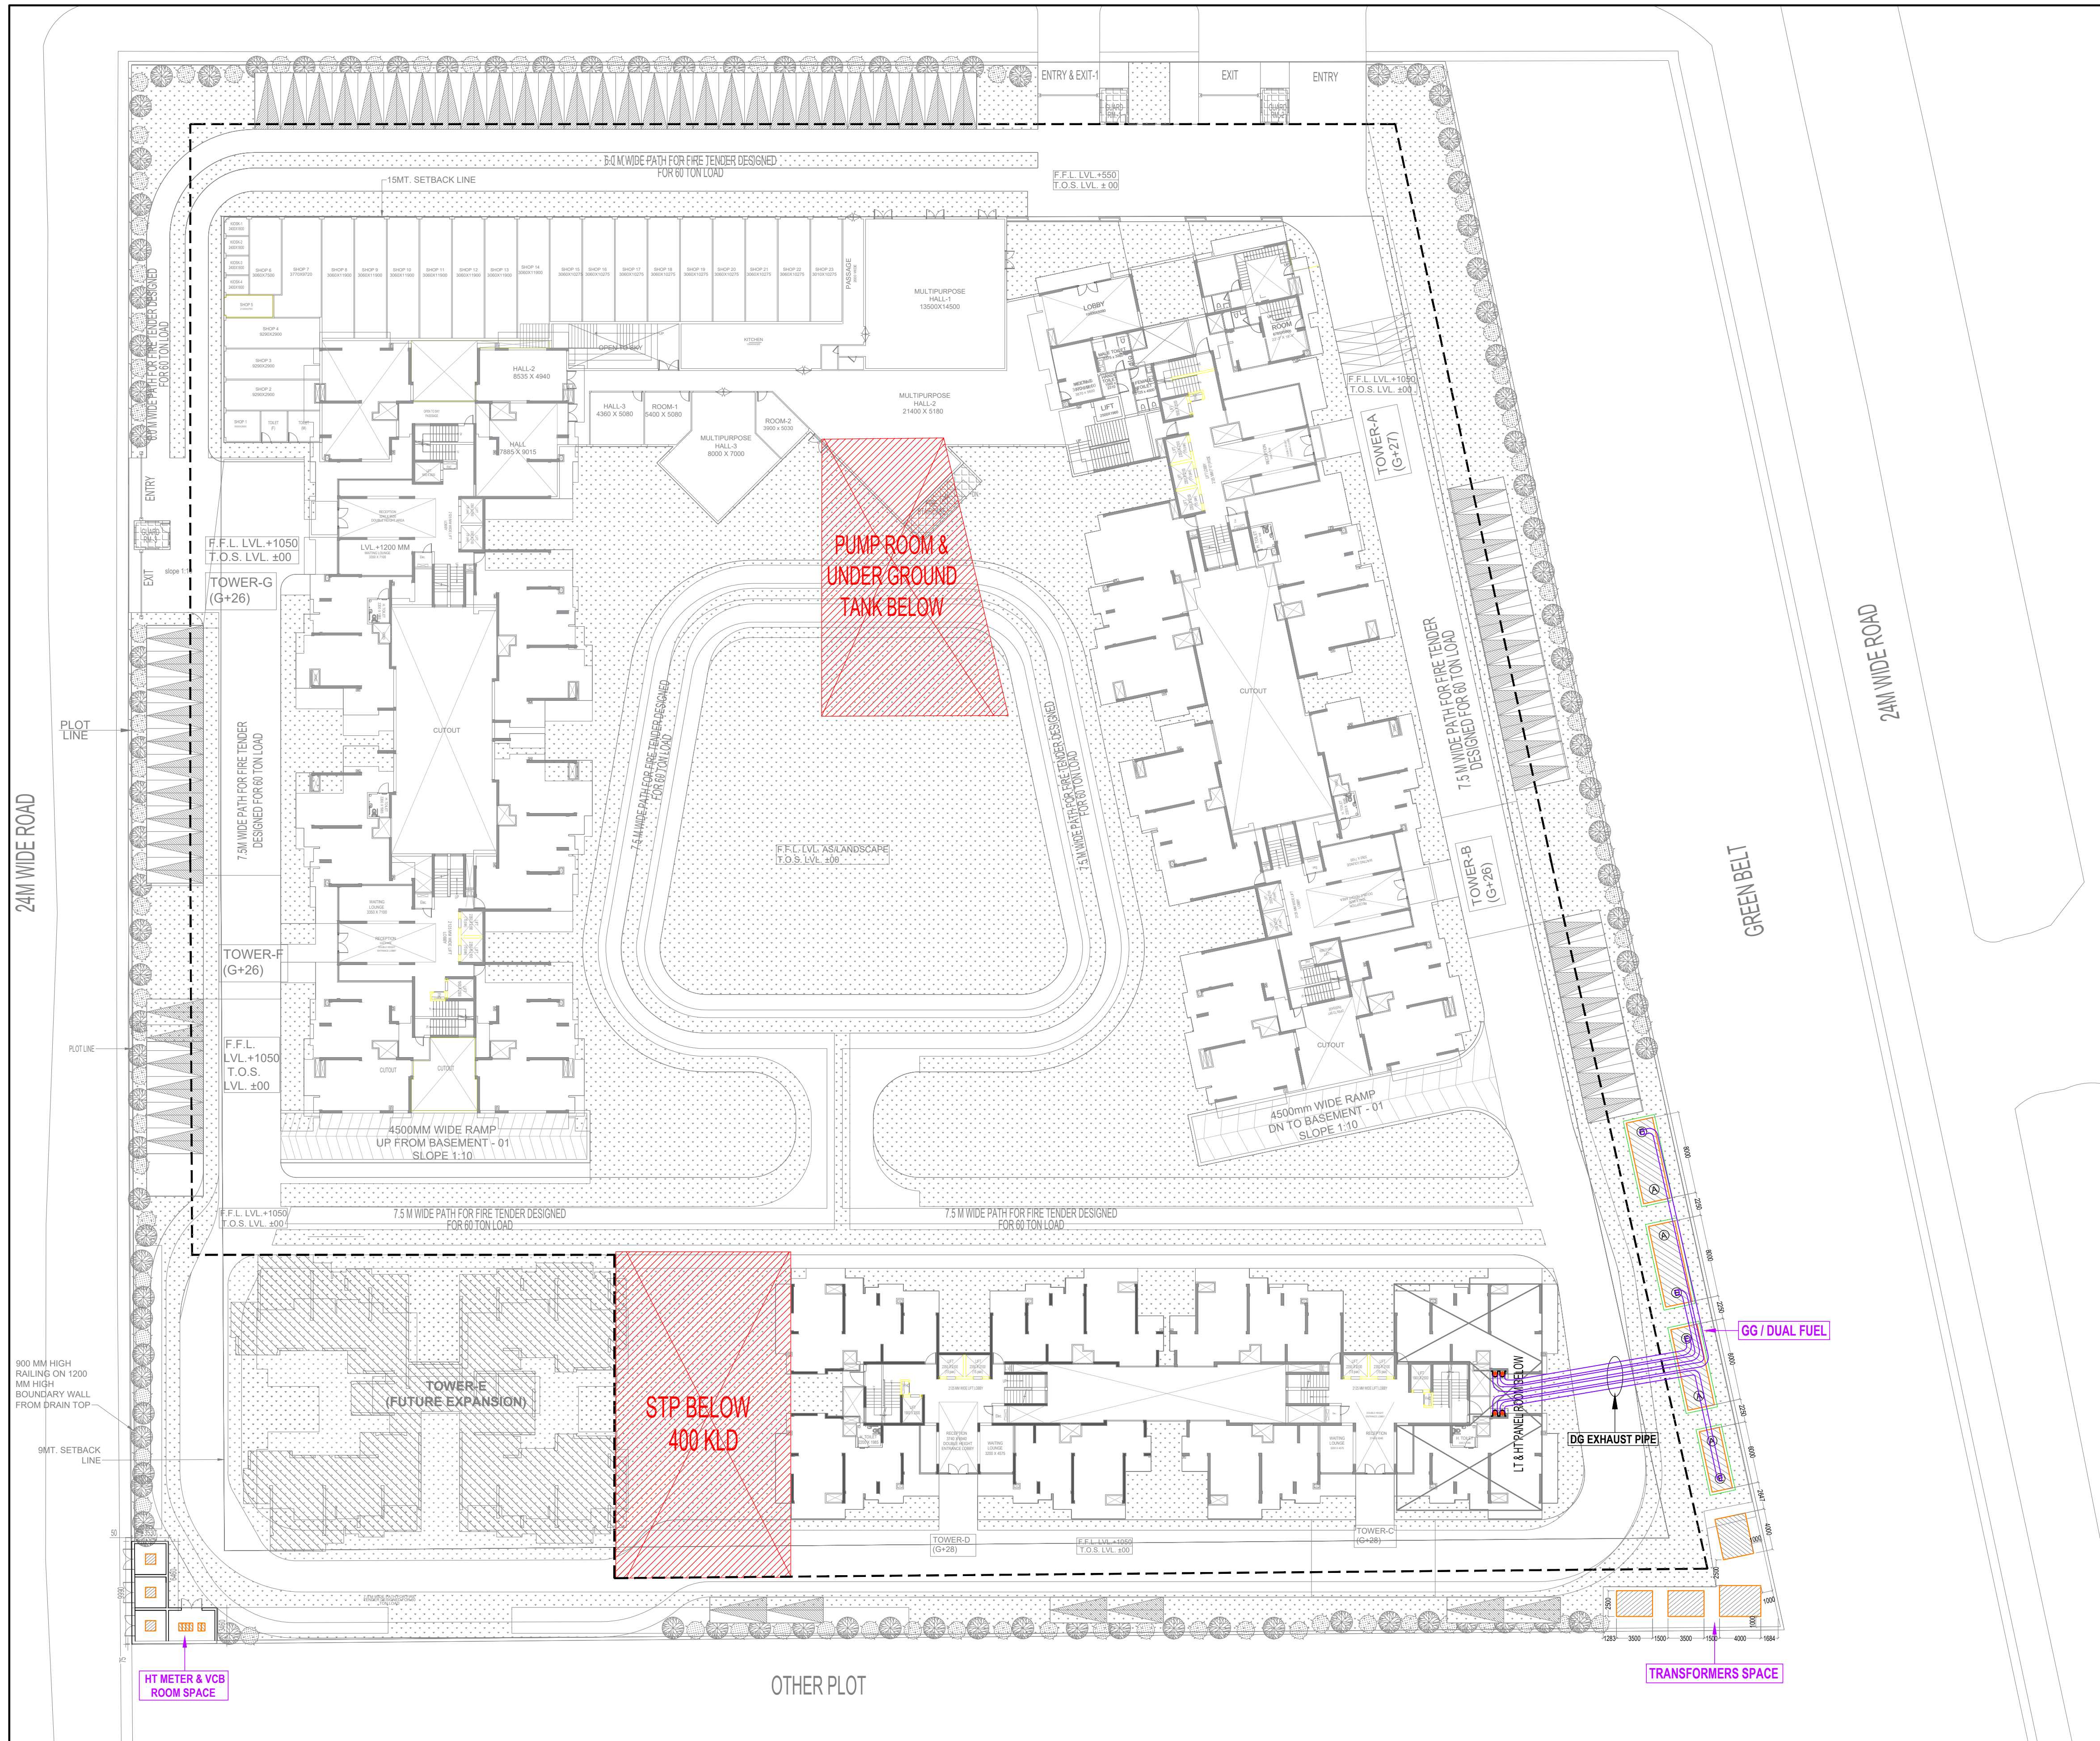

R 01	18-12-2023	---	for Rera Submission
Rev. no.	Date	NO.OF PRINTS	Revision

Project
PROPOSED GROUP HOUSING FOR
M/S GOLF GREEN MANSIONS (P) LTD.
AT PLOT NO: - GH-3A, SECTOR -10
GREATER NOIDA, (U.P.)

Title
SITE PLAN

Subtitle
EXTERNAL ELECTRICAL LAYOUT

Drawing released for
☐ APPROVAL ☒ SUBMISSION
☐ ADVANCE COPY ☐ CONSTRUCTION

Drg. no. Elite / EX. / E-01 Drawn by Kulwant

Scale 1:310 Designed by R.K.

Date Oct. 2023 Checked by Anand Havelia

Architects
Confluence
R. 421, NITC, Ph: +91-11-26010000, confluence@confluence.com, Member of IASCI
Noida, U.P. Ph: +91-11-26010000, www.confluence.com, 020-2001-0000
architects urban design hospitals interiors

Services Consultant
Consummate Engineering Services (P) Ltd.
Noida Office : B - 67, Sector - 67, Noida - 201 301
Tel : (0120)6943500 (23 Lines)
Lko Office : R 06, Rohas Plumeria, Gomti Nagar, Lucknow
e mail : mail@cespl.in, website : www.cespl.in
cespl
Working Together To Create Value